


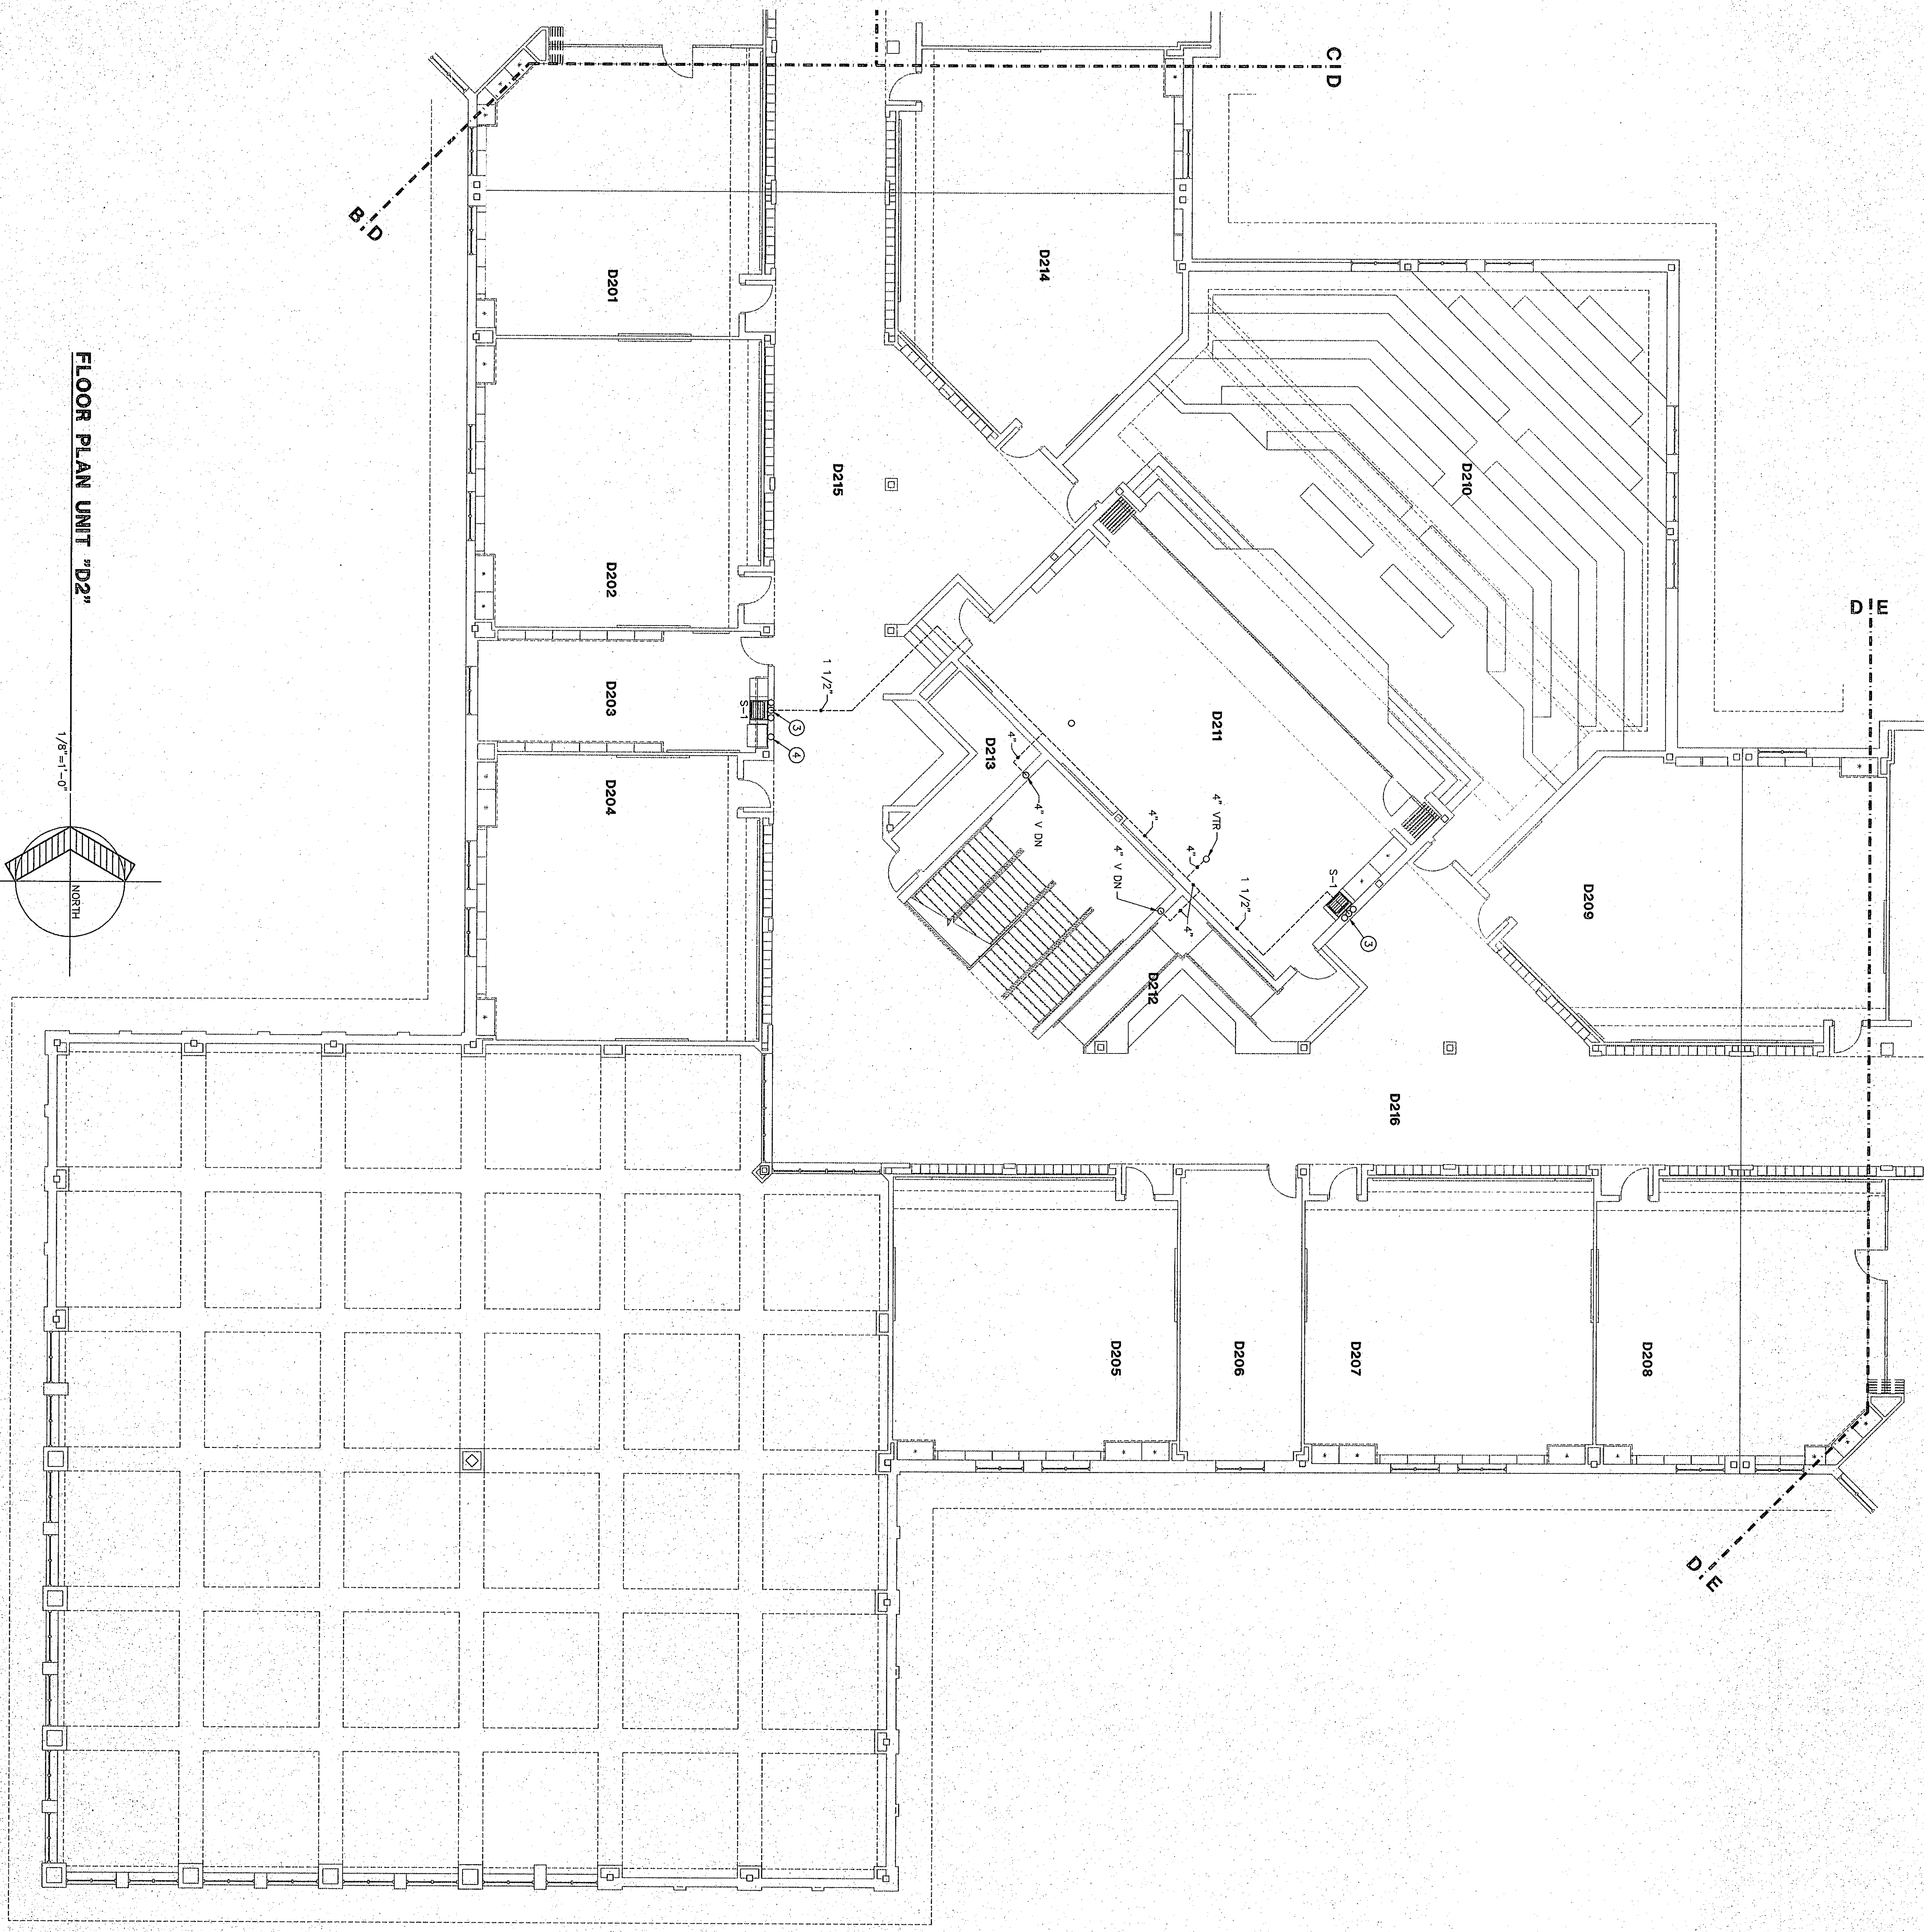

ROOM LEGEND "D2"	
ROOM NO.	AREA
D201	CL. 100
D202	CL. 100
D203	CL. 100
D204	CL. 100
D205	CL. 100
D206	CL. 100
D207	CL. 100
D208	CL. 100
D209	CL. 100
D210	CL. 100
D211	CL. 100
D212	CL. 100
D213	CL. 100
D214	CL. 100
D215	CL. 100
D216	CL. 100

- PLUMBING PLAN NOTES:**
- 1/2" H&C WATER, 1 1/2" WASTE UP TO FUTURE ABOVE
 - 1/2" COLD WATER UP AND DOWN TO DMC.
 - 1/2" HOT AND COLD WATER, 1 1/2" WASTE DOWN TO FLOOR BELOW.
 - 1/2" CW DOWN TO 6" ABOVE FLOOR, VALVE AND CAP FOR REFRIGERATOR ICEMAKER.
 - DISWASHER TO BE CONNECTED TO WATER AND WASTE PLUMBING OF ADJACENT SINK.
 - HOT WATER AND/OR COLD WATER, GAS, AND SANITARY VENT PIPING ARE TO BE INSTALLED IN COVERED FLOOR AREAS. REFER TO DETAIL OF TRENCH INCLUDED ON ARCHITECTURAL PLANS.
 - HOT WATER AND/OR COLD WATER AND/OR GAS AND/OR SANITARY VENT PIPING ARE TO BE INSTALLED IN COVERED FLOOR AREAS. REFER TO DETAIL OF TRENCH INCLUDED ON ARCHITECTURAL PLANS.
 - INSTALL DISPOSER AT THIS LOCATION TO BE IN-SINK-EXTERIOR, MODEL 1/2, 3/4 HP.
 - GAS PIPING DOWN TO SOLENOID VALVE WITHIN RECESSED CABINET, AND UP FROM CABINET, REFER TO DETAIL.
 - WASHING MACHINE FITTING, REFER TO DETAIL DWG. P3.1
 - 1/2" GAS AT 6" ABOVE FLOOR WITH STOP VALVE FOR RANGE CONNECTION.
 - DARKROOM SINK WITH KINKING FLARET BY DIVISION 11470. SANITARY VENT, H&C WATER CONNECTIONS BY DIVISION 15450. VERIFY ALL CONNECTIONS.
 - 1/2" COMPRESSED AIR PIPING DOWN TO 48" ABOVE FINISHED FLOOR, VALVE AND TEE WITH DIRT LEG, AND PLUG FOR FUTURE QUICK DISCONNECT BY OWNER.
 - GAS REGULATOR TO PROVIDE 45 O.U. FT. OF 7"WC NATURAL GAS PRESSURE FROM 2 PSI. REFER TO DETAIL DWG. P3.1
 - GAS VALVE CABINET REFER TO DETAIL DWG. P3.1
 - COMPRESSED AIR PRESSURE REGULATOR PIPING DETAIL, REFER TO DETAIL DWG. P3.1
 - FLOOR DRAIN TO BE (SINK) 35033-2 WITH HINGED GRAIL AND SEDIMENT BASKET, TO BE INSTALLED 1/4" TRAP
 - SUMP PUMP TO BE LITTLE GIANI MODEL 95-GA-RS WITH CHECK VALVE UNION AND 24" BASIN, COMPLETE WITH CHECK VALVE UNION AND 24" BASIN, COMPLETE
 - 1 1/2" OPEN SITE DRAIN, SEE DETAIL DWG. P3.1, LOCATE ABOVE CEILING TO ALLOW FOR MAINTENANCE ACCESS.

PLUMBING PLAN UNIT "D2"

DRAWN BY: JJD

CHECKED BY: CAM

COMM. NO.: 95067.00

DATE: APRIL 21, 1997

P2.8

REVISIONS NO. DATE

Fanning/Howey

Associates, Inc.

Architects Engineers Consultants

THE NEW

CHESTERTON HIGH SCHOOL

FOR THE

DUNELAND SCHOOL CORPORATION

CHESTERTON, INDIANA

COPYRIGHT 1997 BY FANNING/HOWEY ASSOCIATES, INC.