


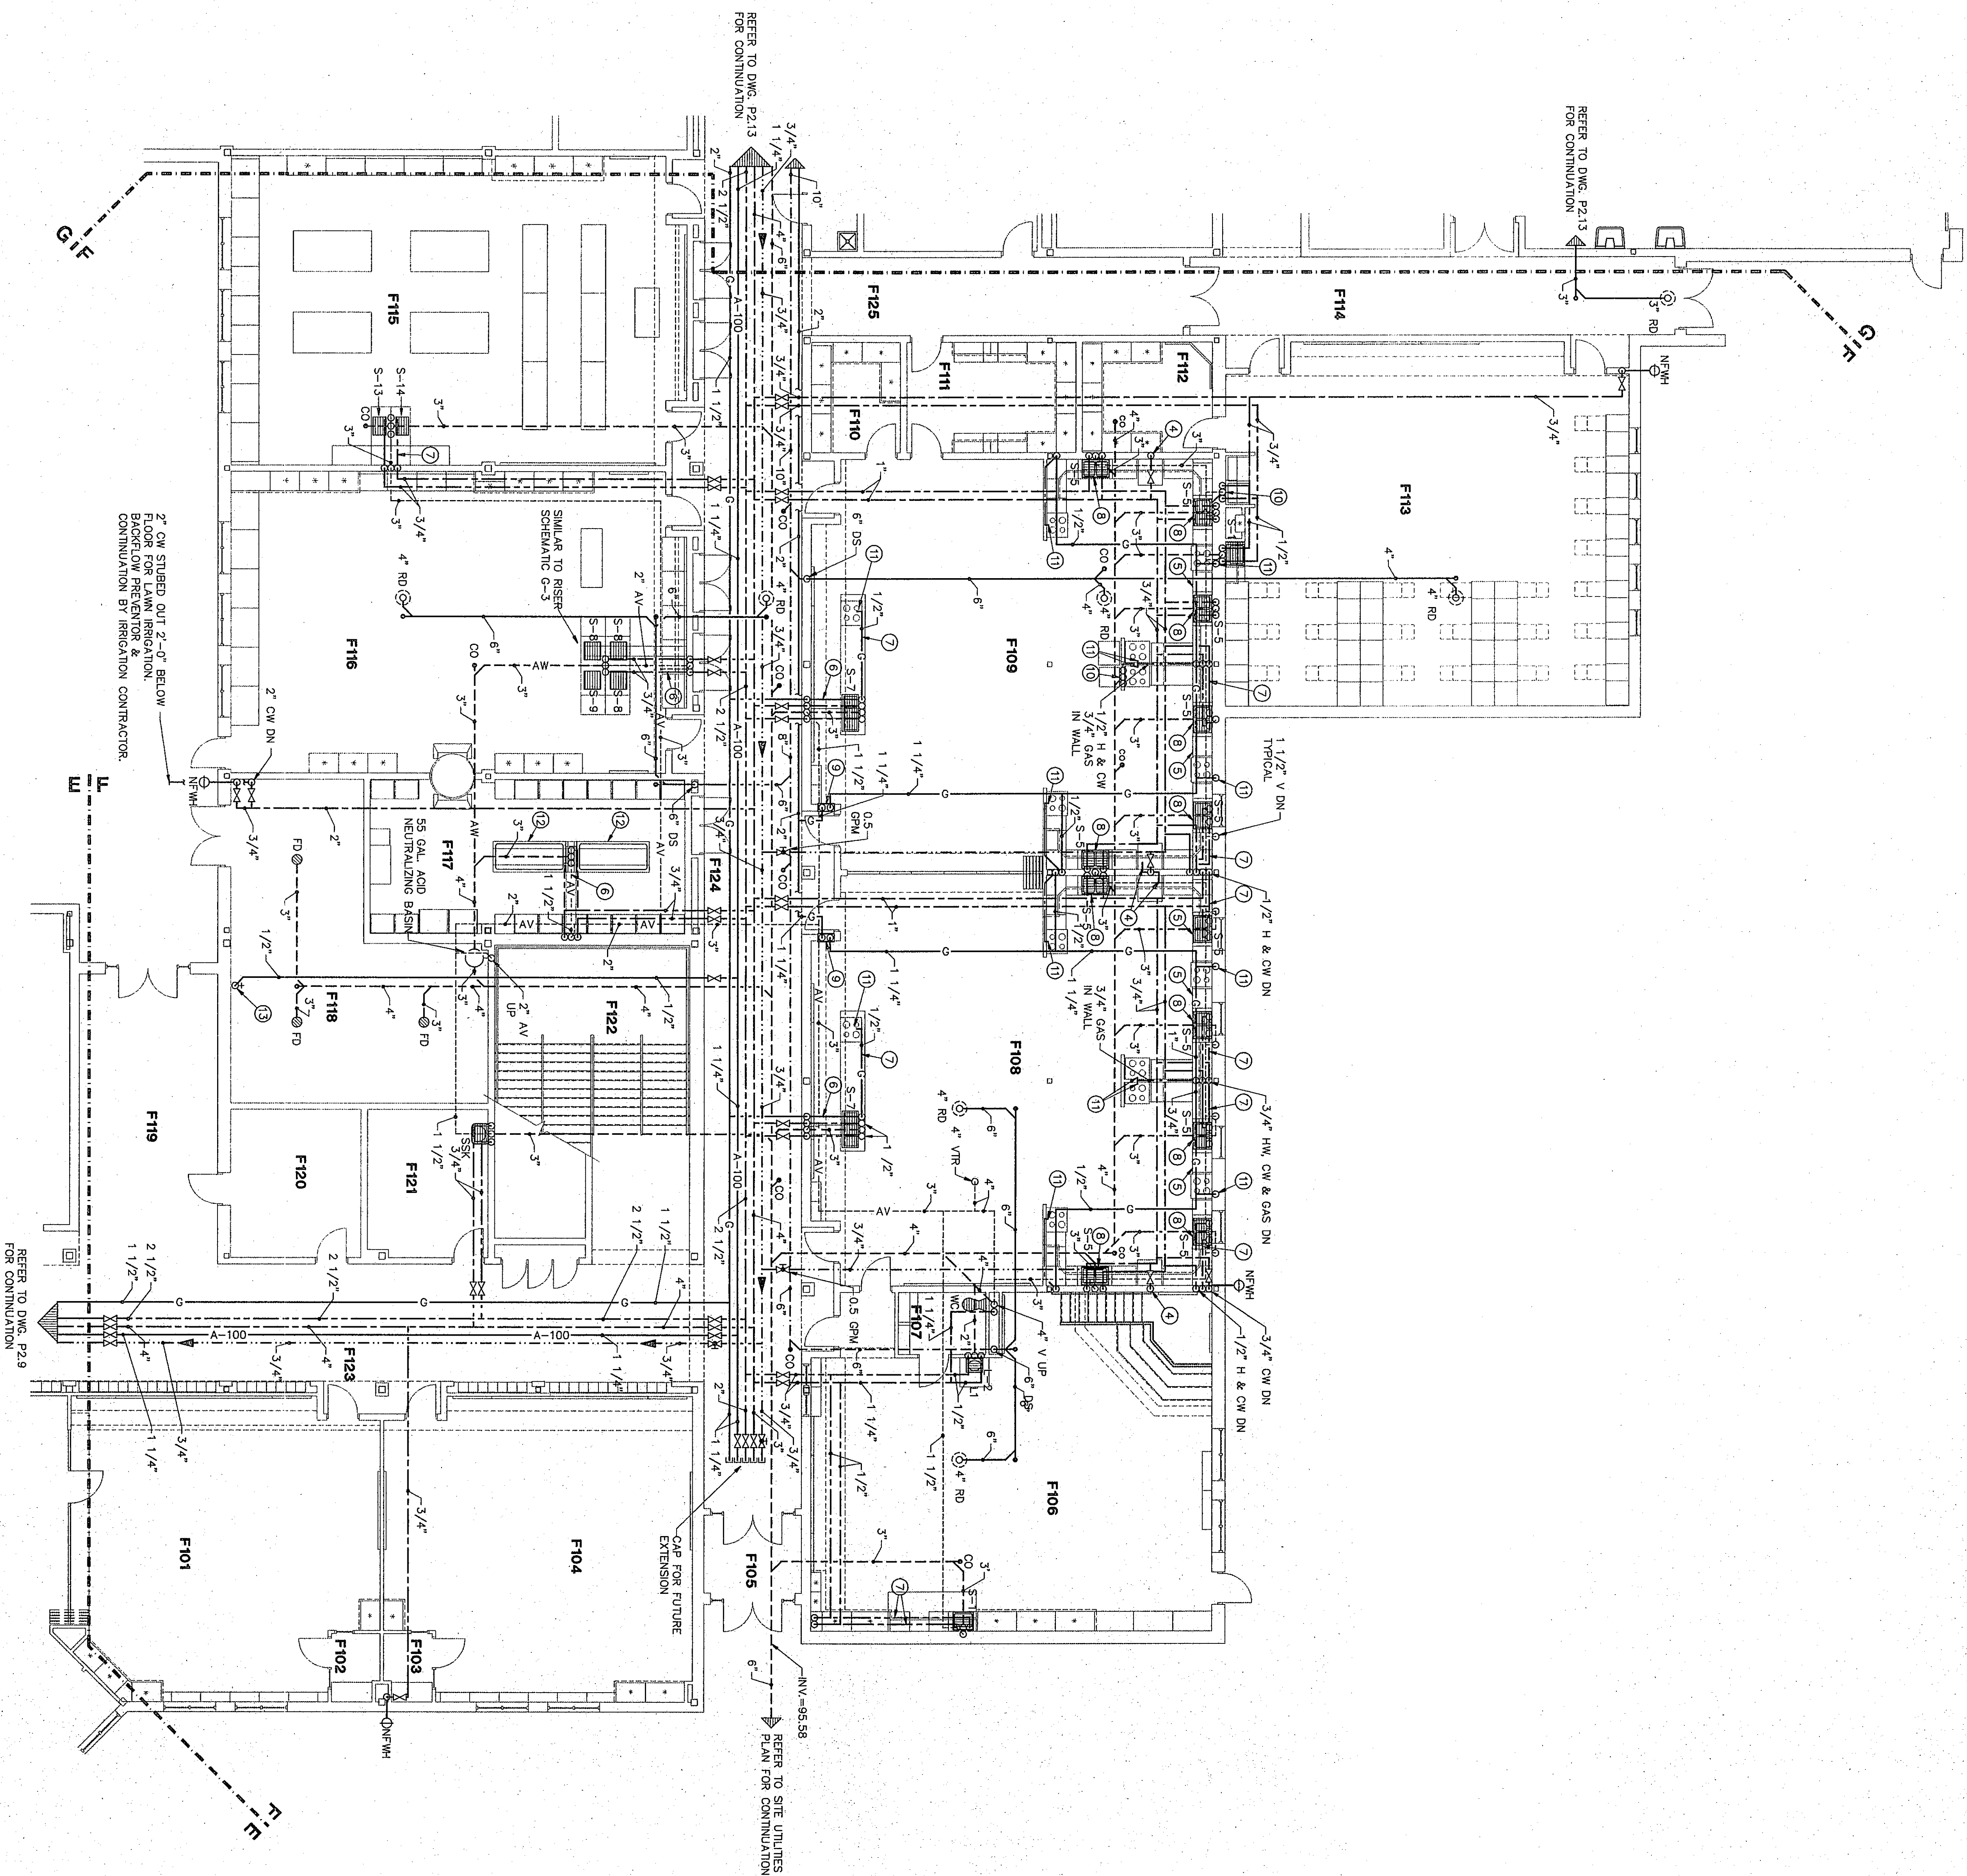


ROOM NO.	ROOM NAME	AREA S.F.	CEILING HEIGHT	FINISHES
F101	CLASSROOM	823	9'-4"	FOR LING.
F102	RECORDING	333	9'-4"	FOR LING.
F103	RECORDING	333	9'-4"	FOR LING.
F104	RECORDING	333	9'-4"	FOR LING.
F105	RECORDING	333	9'-4"	FOR LING.
F106	RECORDING	333	9'-4"	FOR LING.
F107	RECORDING	333	9'-4"	FOR LING.
F108	RECORDING	333	9'-4"	FOR LING.
F109	RECORDING	333	9'-4"	FOR LING.
F110	RECORDING	333	9'-4"	FOR LING.
F111	RECORDING	333	9'-4"	FOR LING.
F112	RECORDING	333	9'-4"	FOR LING.
F113	RECORDING	333	9'-4"	FOR LING.
F114	RECORDING	333	9'-4"	FOR LING.
F115	RECORDING	333	9'-4"	FOR LING.
F116	RECORDING	333	9'-4"	FOR LING.
F117	RECORDING	333	9'-4"	FOR LING.
F118	RECORDING	333	9'-4"	FOR LING.
F119	RECORDING	333	9'-4"	FOR LING.
F120	RECORDING	333	9'-4"	FOR LING.
F121	RECORDING	333	9'-4"	FOR LING.
F122	RECORDING	333	9'-4"	FOR LING.
F123	RECORDING	333	9'-4"	FOR LING.
F124	RECORDING	333	9'-4"	FOR LING.

PLUMBING PLAN NOTES:

- 1/2" H&C WATER, 1 1/2" WASTE UP TO FUTURE ABOVE
- 1/2" COLD WATER UP AND DOWN TO DMC.
- 1/2" HOT AND COLD WATER, 1 1/2" WASTE DOWN TO FLOOR BELOW.
- 1/2" CW DOWN TO 6" ABOVE FLOOR, VALVE AND CAP FOR REFRIGERATOR ICEMAKER.
- DISHWASHER TO BE CONNECTED TO WATER AND WASTE.
- PLUMBING OF ADJACENT SINK.
- HOT WATER AND/OR COLD WATER, GAS, AND SANITARY VENT PIPING ARE TO BE INSTALLED IN COVERED FLOOR TRENCHES. REFER TO DETAIL OF TRENCH INCLUDED ON ARCHITECTURAL PLANS.
- HOT WATER AND/OR COLD WATER AND/OR GAS AND/OR SANITARY VENT PIPING TO BE INSTALLED IN BASE FRAMING OF OVERHANG CABINET AND ABOVE FLOOR.
- INSTALL DISPOSER AT THIS LOCATION, TO BE IN-SINK-EXTRACTOR, MODEL 77, 3/4 HP.
- GAS PIPING DOWN TO SOLENOID VALVE WITHIN RECESSED CABINET, AND UP FROM CABINET. REFER TO DETAIL.
- WASHING MACHINE FITTING. REFER TO DETAIL DMC, P.3.1
- 1/2" GAS AT 6" ABOVE FLOOR WITH STOP VALVE FOR RANGE CONNECTION.
- DANGER: SINK WITH WING FLUENT BY DIVISION 1470. SANITARY VENT, H&C WATER CONNECTIONS BY DIVISION 1940. VERIFY ALL CONNECTIONS.
- 1/2" COMPRESSED AIR PIPING DOWN TO 48" ABOVE FINISHED FLOOR, VALVE AND TEE WITH DIRT LEG, AND PLUG FOR FUTURE QUICK DISCONNECT BY OWNER.
- GAS REGULATOR TO PROVIDE 45 O.L. FT. OF TWO NATURAL GAS PRESSURE FROM 2 PSI. REFER TO DETAIL DMC, P.3.1
- GAS VALVE CABINET REFER TO DETAIL DMC, P.3.1
- COMPRESSED AIR PRESSURE REGULATOR PIPING DETAIL REFER TO DETAIL DMC, P.3.1
- FLOOR DRAIN TO BE JOWAY 55235-2 WITH HINGED GRATE AND SEDIMENT BUCKET, TO BE INSTALLED W/ TRAP.
- SLIP PUMP TO BE LITTLE GANT MODEL BE-COA-RTS TO PUMP 30 GPM @ 20 FT. HD. 1/2" HD. 200V, COMPLETE WITH CHECK VALVE, W/IN AND 24" BASKIN.
- 1 1/2" OPEN SITE DRAIN, SEE DETAIL DMC, P.3.1. LOCATE ABOVE CEILING TO ALLOW FOR MAINTENANCE ACCESS.

FLOOR PLAN UNIT "F"

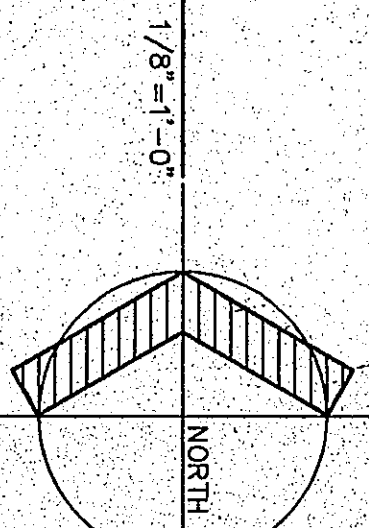

97-P-12


CHESTERTON HIGH SCHOOL
95067.00

PLUMBING PLAN UNIT "F"


DRAWN BY: JJD COMM. NO.: 95067.00
CHECKED BY: CAM DATE: APRIL 21, 1997

P2.11

REVISIONS NO. DATE

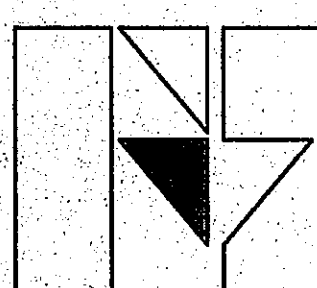

Fanning/Howey
Associates, Inc.
Architects Engineers Consultants

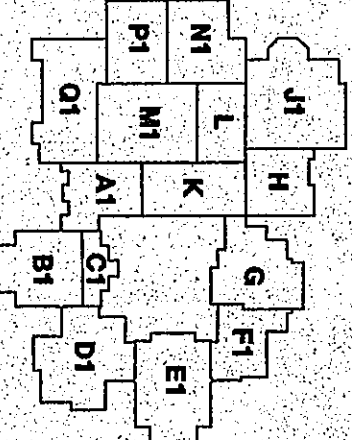

THE NEW
CHESTERTON HIGH SCHOOL
FOR THE
DUNELAND SCHOOL CORPORATION
CHESTERTON, INDIANA

COPYRIGHT 1997 BY FANNING/HOWEY ASSOCIATES, INC.

