



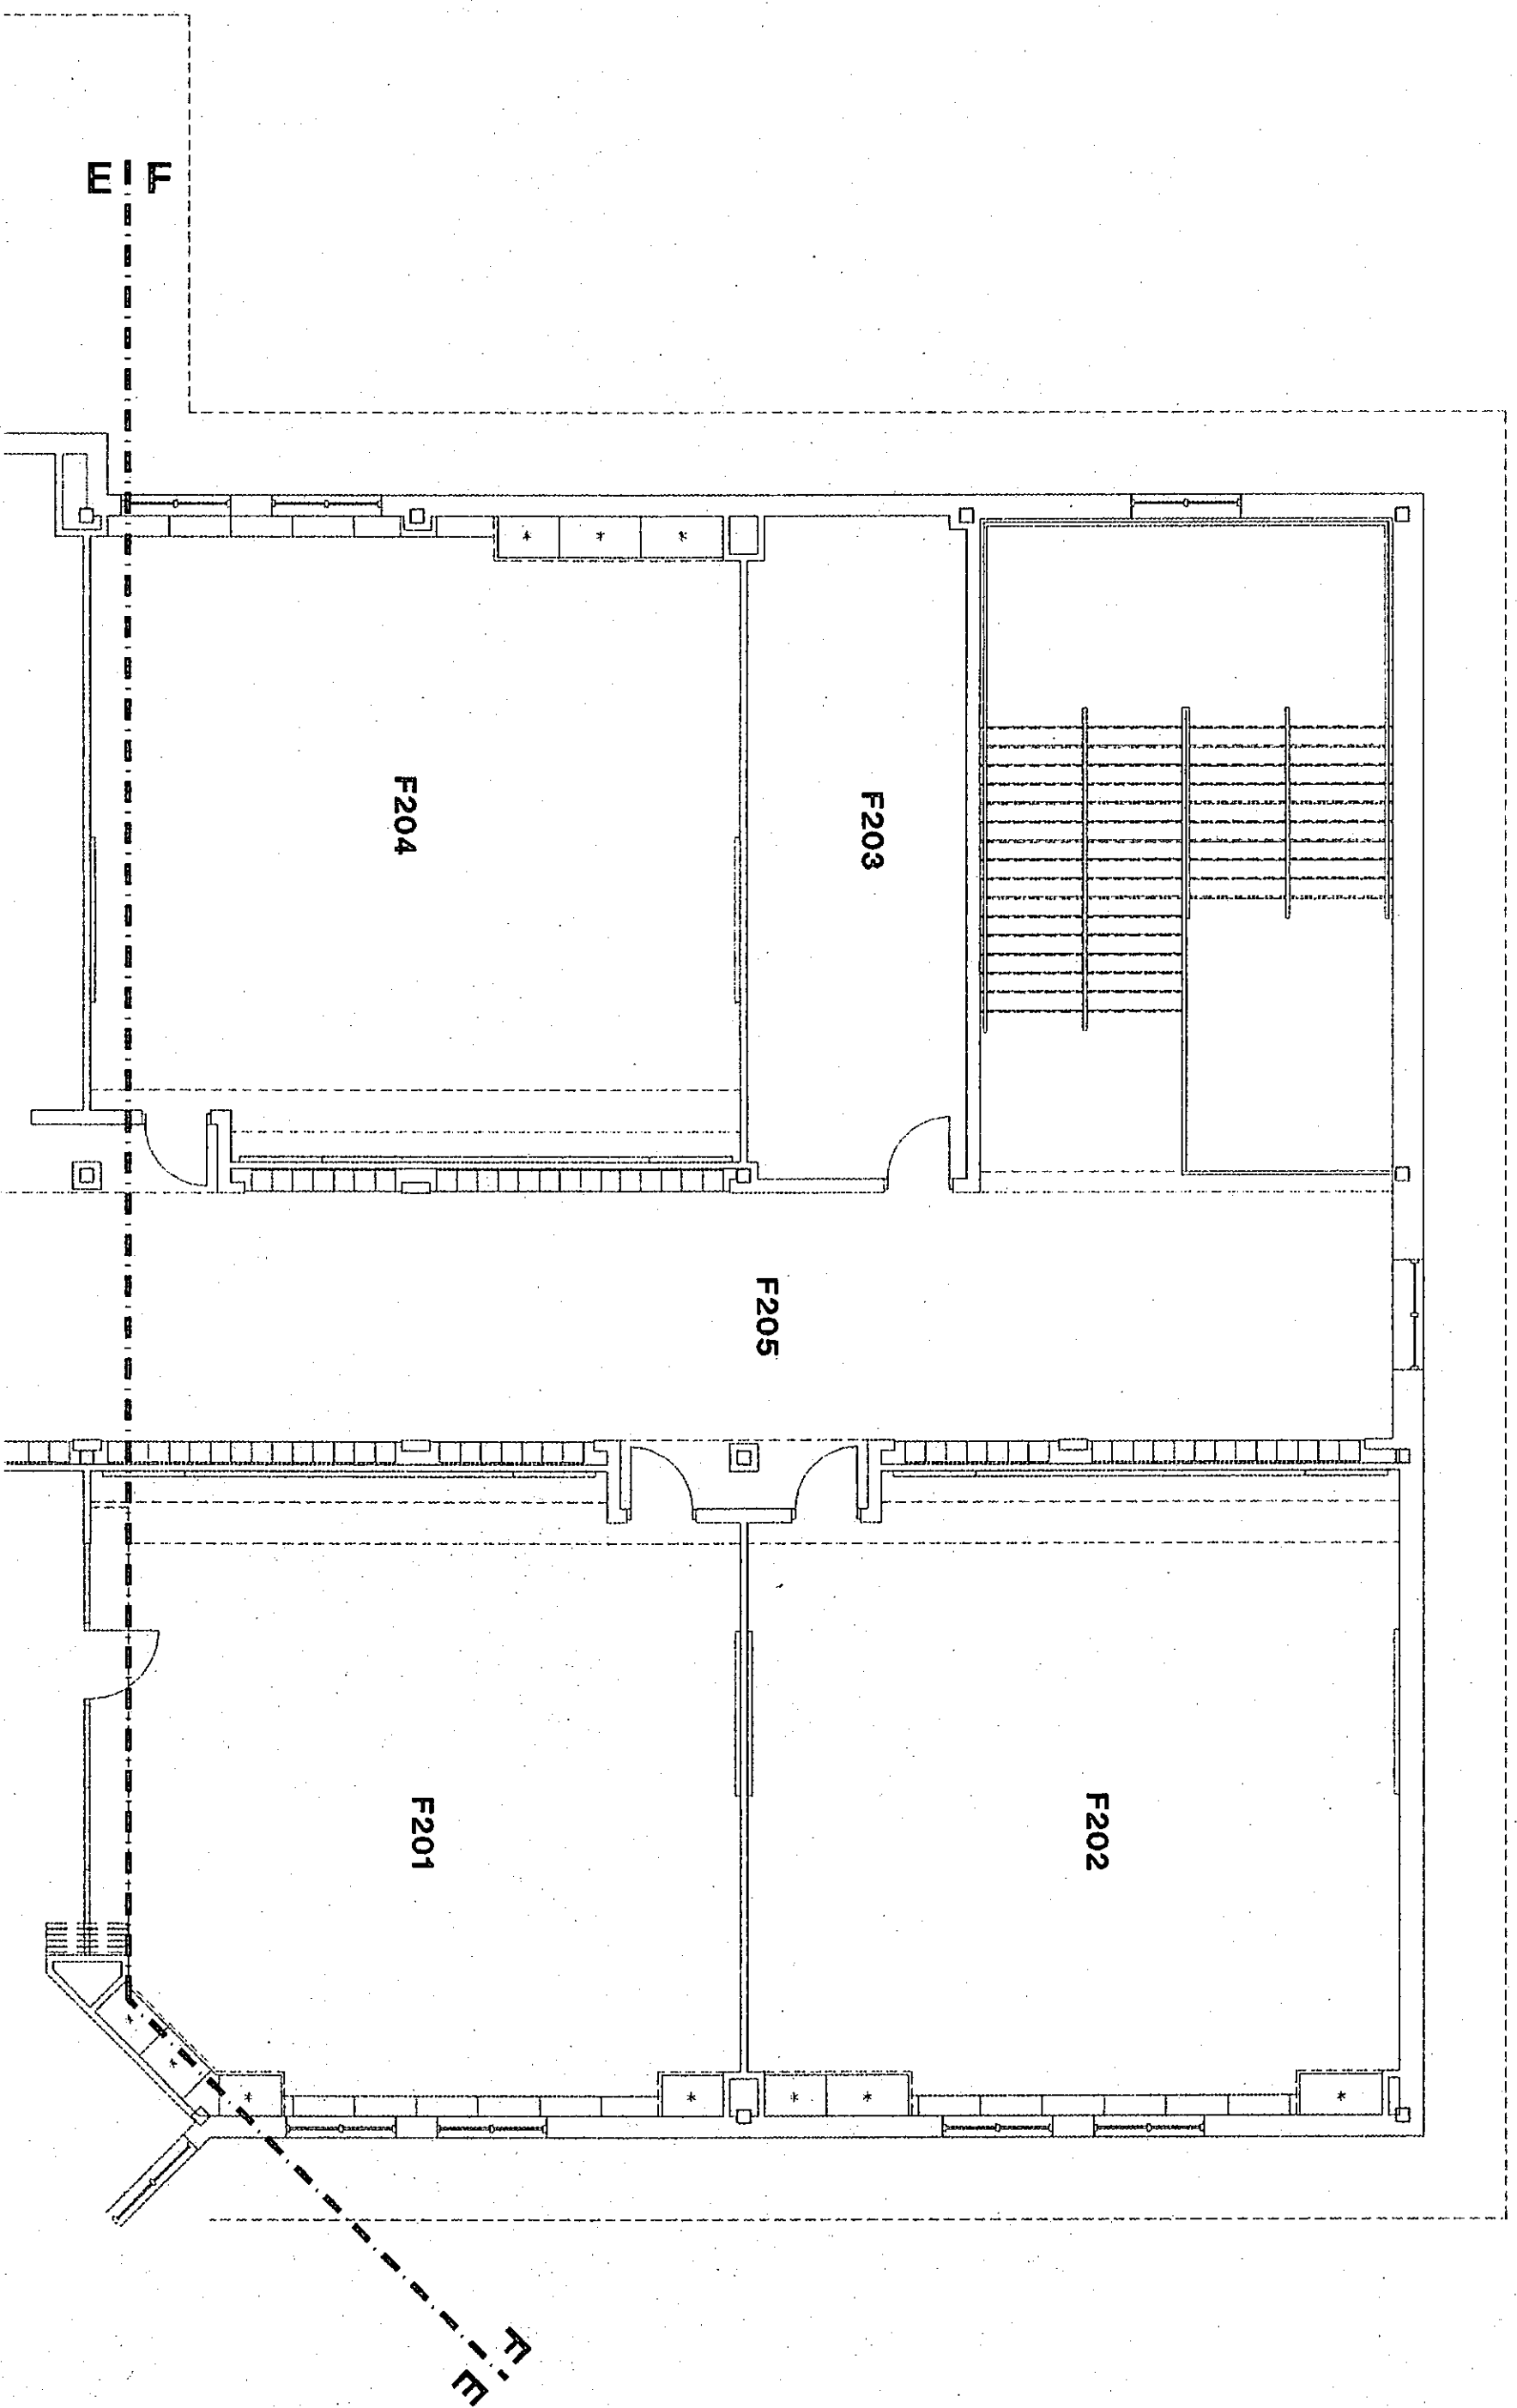

NOTE:
THERE IS NO PLUMBING WORK TO BE PERFORMED IN THIS AREA.
THIS AREA IS SHOWN FOR REFERENCE ONLY.


FLOOR PLAN UNIT "F2"

1/8"=1'-0"

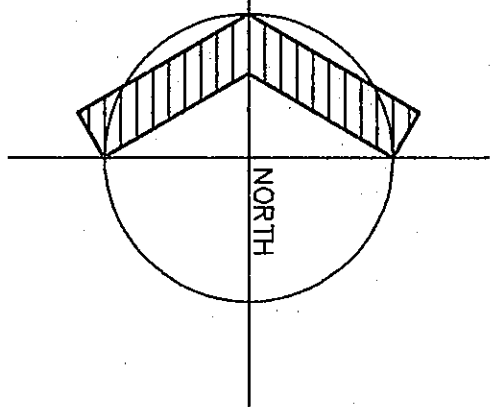



PLUMBING PLAN NOTES:

- 1/2" H&C WATER, 1 1/2" WASTE UP TO FIXTURE ABOVE
- 1/2" COLD WATER UP AND DOWN TO DMC
- 1/2" HOT AND COLD WATER, 1 1/2" WASTE DOWN TO FLOOR BELOW
- 1/2" CW DOWN TO 6" ABOVE FLOOR, VALVE AND CAP FOR REFRIGERATOR ICEMAKERS
- DISWASHER TO BE CONNECTED TO WATER AND WASTE
- PLUMBING OF ADJACENT SINK
- HOT WATER AND/OR COLD WATER, GAS AND SANITARY TRENCHES, REFER TO DETAIL OF TRENCH INCLUDED ON ARCHITECTURAL PLANS
- SANITARY VENT PIPING TO BE INSTALLED IN BASE FRAMING OF CASEWORK BEHIND CABINET AND ABOVE FLOOR
- INSTALL DISPOSER AT THIS LOCATION, TO BE IN-SINK-EVAPORATOR, MODEL 771, 3/4 HP
- GAS PIPING DOWN TO SOLENOID VALVE WITHIN RECESSED CABINET, AND UP FROM CABINET, REFER TO DETAIL
- WASHING MACHINE FITTING, REFER TO DETAIL DWG. P3.1
- 1/2" GAS AT 6" ABOVE FLOOR WITH STOP VALVE FOR RANGE CONNECTION
- DARKROOM SINK WITH MIXING FAUCET BY DIVISION 11470, 15450, VERIFY ALL CONNECTIONS BY DIVISION 15450, VERIFY ALL CONNECTIONS
- 1/2" COMPRESSED AIR PIPING DOWN TO 48" ABOVE FINISHED FLOOR, VALVE AND TEE WITH DIRT LEG, AND PLUG FOR FUTURE QUICK DISCONNECT BY OWNER
- GAS REGULATOR TO PROVIDE 45 PSI, FT. OF 7"WC NATURAL GAS PRESSURE FROM 2 PSI, REFER TO DETAIL DWG. P3.1
- GAS VALVE CABINET REFER TO DETAIL DWG. P3.1
- COMPRESSED AIR PRESSURE REGULATOR PIPING DETAIL, REFER TO DETAIL DWG. P3.1
- FLOOR DRAIN TO BE J05AM 39233-2 WITH HINGED GRAPE AND SEDIMENT BUCKET, TO BE INSTALLED W/ TRAP
- SUMP PUMP TO BE LITTLE GIANT MODEL# SE-CA-RHS TO PUMP 30 GPM @ 20 FT. HD, 1/2 HP, 120V, COMPLETE WITH CHECK VALVE, UNION AND 24" BWSN
- 1 1/2" OPEN SITE DRAIN, SEE DETAIL DWG. P3.1, LOCATE ABOVE CEILING TO ALLOW FOR MAINTENANCE ACCESS.

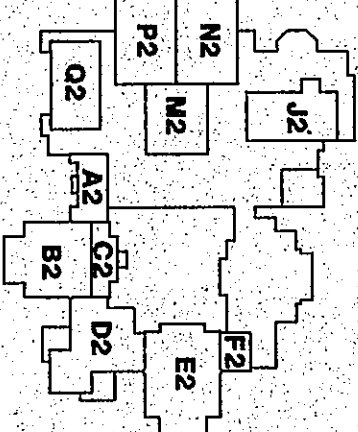

THE NEW
CHESTERTON HIGH SCHOOL
FOR THE
DUNELAND SCHOOL CORPORATION
CHESTERTON, INDIANA

COPYRIGHT 1997 BY FANNING/HOWEY ASSOCIATES, INC.

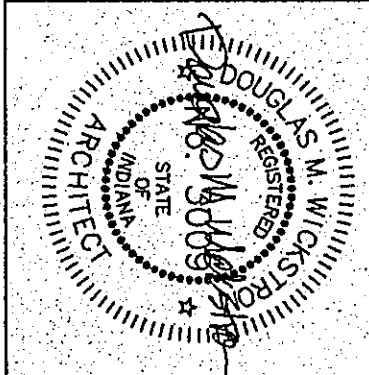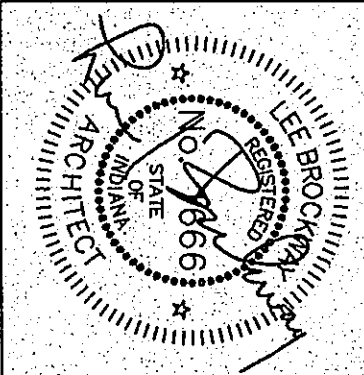

Fanning/Howey
Associates, Inc.
Architects Engineers Consultants

PLUMBING PLAN UNIT "F2"

DRAWN BY: JJD COMM. NO.: 95067.00
CHECKED BY: CAM DATE: APRIL 21, 1997

P2.12

REVISIONS NO. DATE

CHESTERTON HIGH SCHOOL
95067.00