



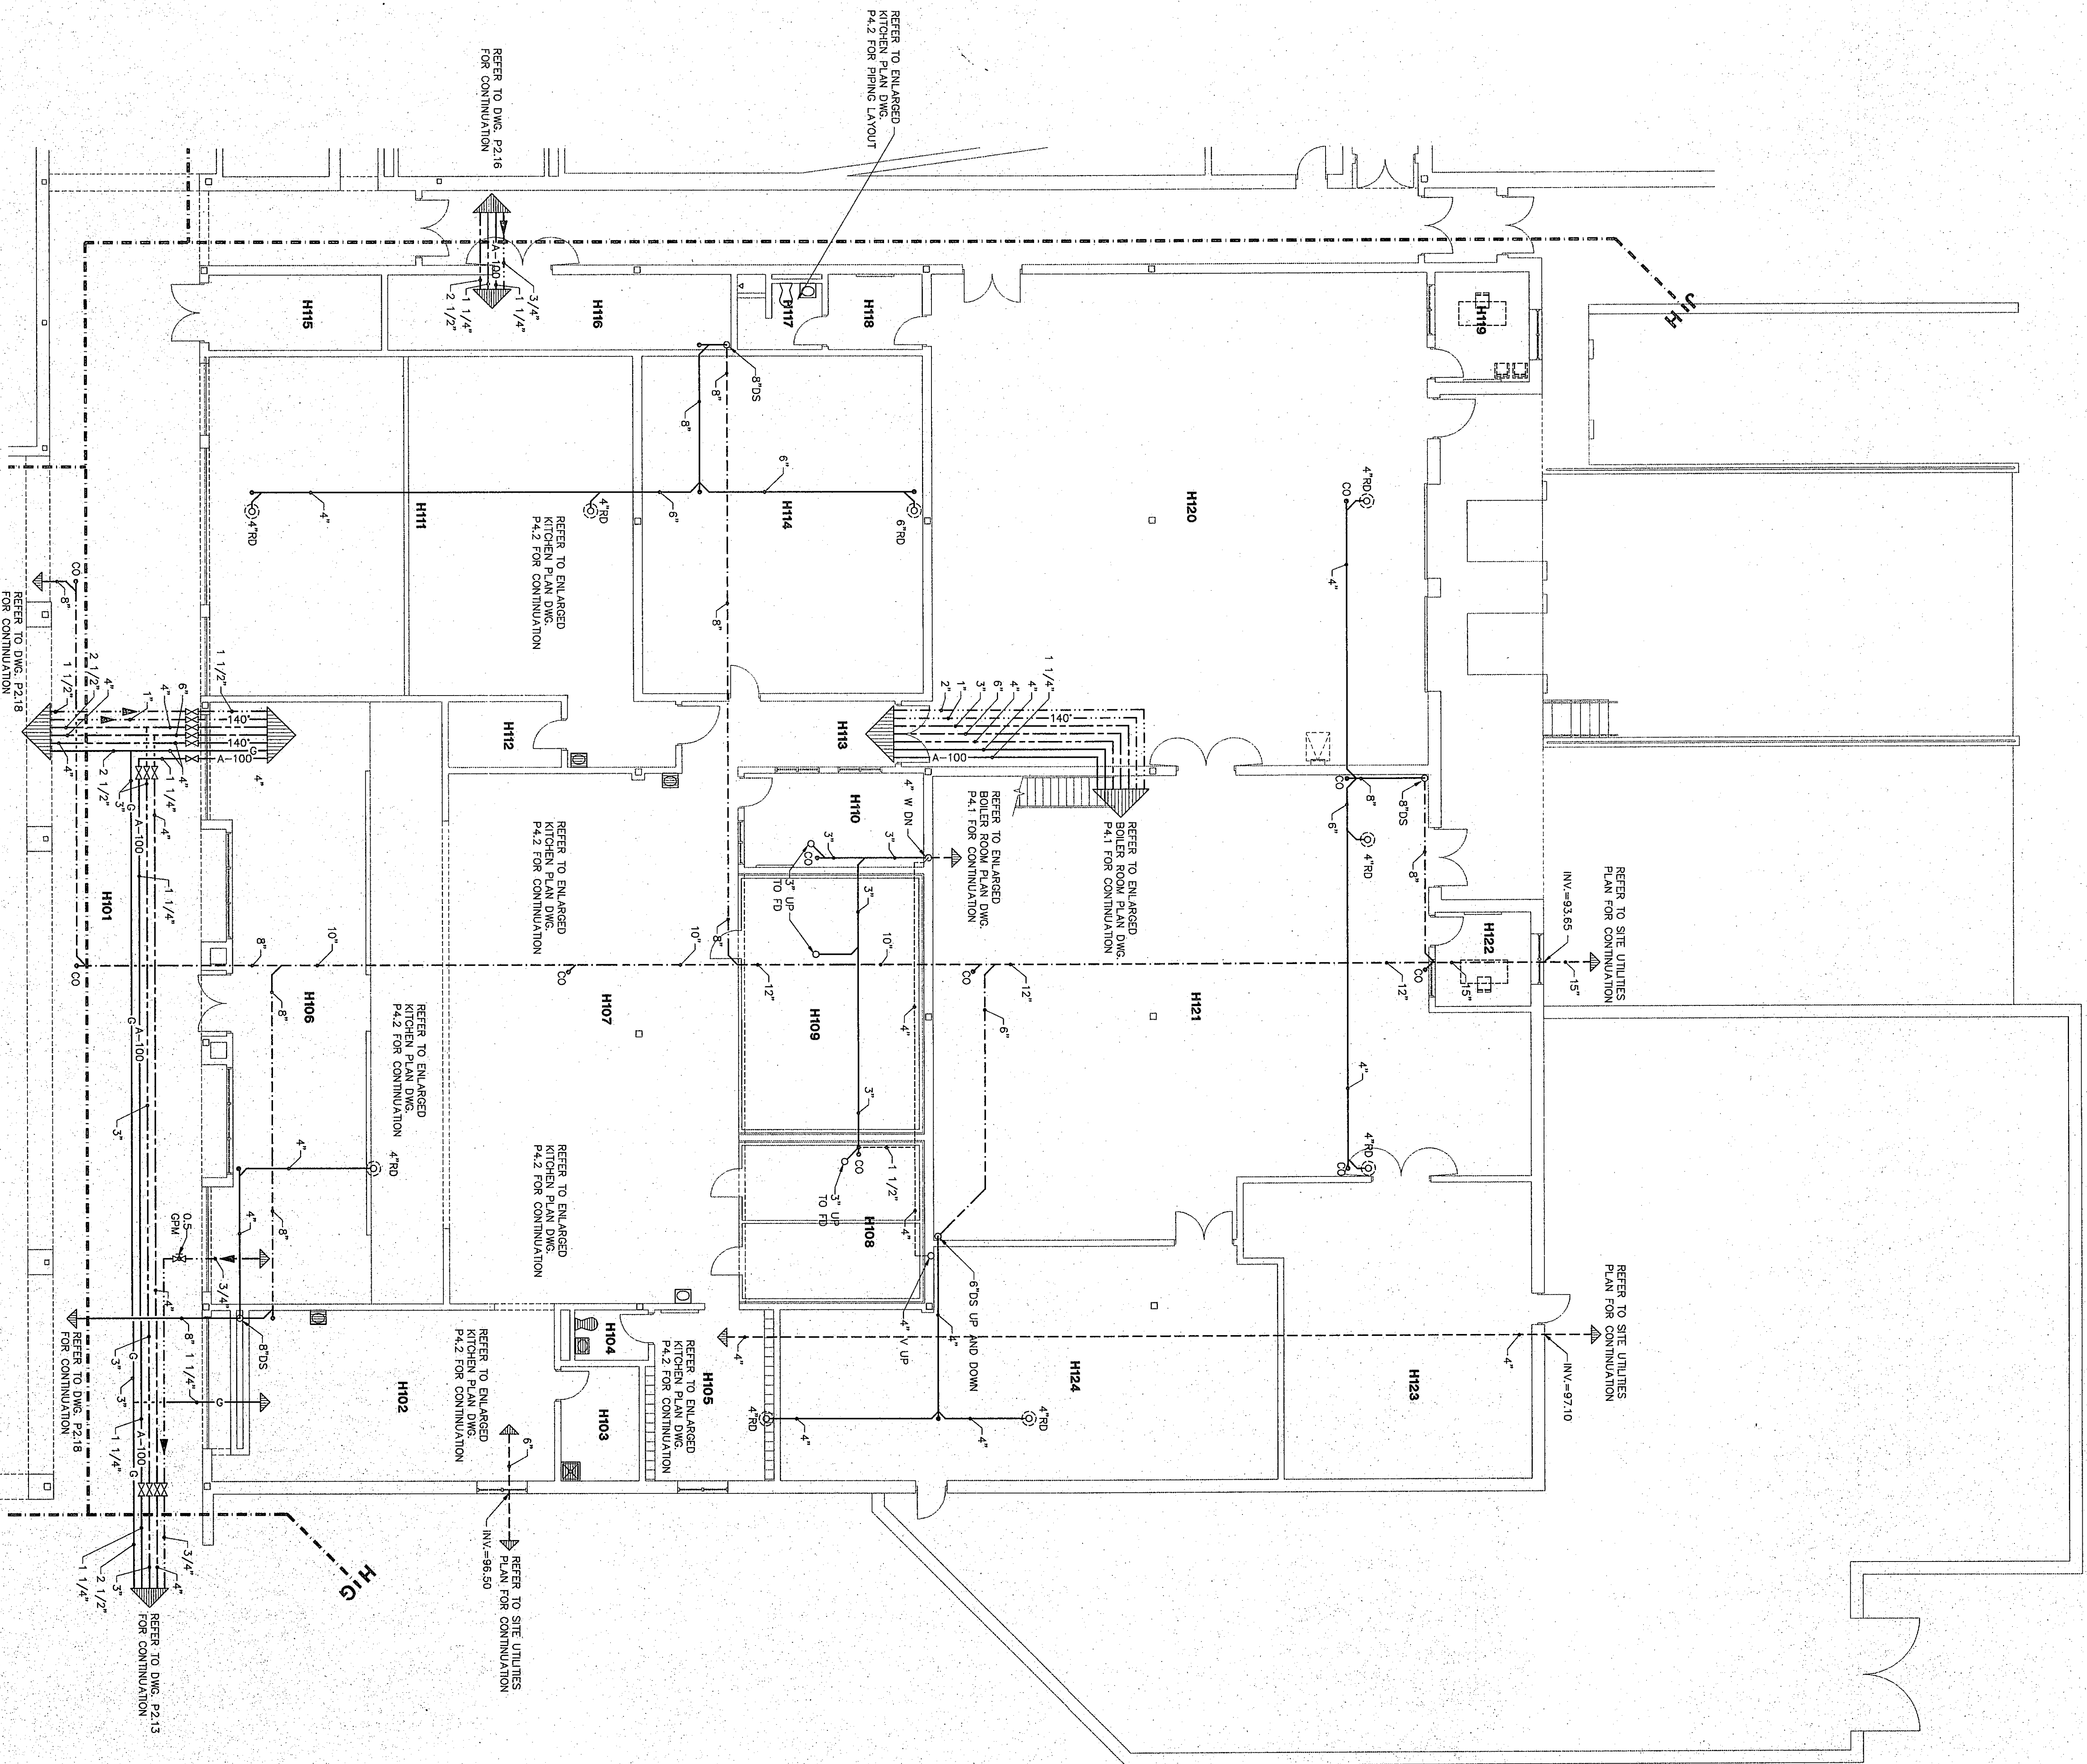

ROOM LEGEND "H"			
NO.	ROOM	AREA	CEILING
H101	BOILER ROOM	2,240	10'-0"
H102	WASHING	600	9'-4"
H103	LAUNDRY/LAUNDRY	101	9'-4"
H104	LOCKER/BREAK ROOM	242	9'-4"
H105	SEWING	555	9'-4"
H106	COOLER	342	9'-4"
H107	FREEZER	546	9'-4"
H108	FAST FOOD SERVING	1,171	9'-4"
H109	STORAGE	84	9'-4"
H110	STORAGE	150	9'-4"
H111	STORAGE	1080	9'-4"
H112	STORAGE	147	9'-4"
H113	STORAGE	702	9'-4"
H114	TOILET	80	9'-4"
H115	OFFICE	80	9'-4"
H116	OFFICE	7788	9'-4"
H117	BOILER ROOM	2859	9'-4"
H118	BOILER ROOM	1209	9'-4"
H119	MECHANICAL MEZZ	---	---


PLUMBING PLAN NOTES:

- 1/2" H&C WATER, 1/2" WASTE UP TO PLUMBING ABOVE
- 1/2" COLD WATER UP AND DOWN TO DMC.
- 1/2" HOT AND COLD WATER, 1/2" WASTE DOWN TO FLOOR BELOW
- 1/2" CW DOWN TO 6" ABOVE FLOOR, VALVE AND CAP FOR REFRIGERATOR ICEMAKER.
- DISBURSED TO BE CONNECTED TO WATER AND WASTE
- PUMPING OF ADJACENT SINK
- HOT WATER AND/OR COLD WATER, GAS AND SANITARY TRENCHES, REFER TO DETAIL OF TRENCH INCLUDED ON ARCHITECTURAL PLANS.
- HOT WATER AND/OR COLD WATER AND/OR GAS AND/OR SANITARY KENT PIPING TO BE INSTALLED IN BASE FRAMING OF CASKWORK BENEATH CABINETS AND ABOVE FLOOR.
- INSTALL DISPOSER AT THIS LOCATION, TO BE "IN-SINK-GRATOR", MODEL 77, 3/4 HP.
- GAS PIPING DOWN TO SOLENOID VALVE WITH RECESSED CABINET, AND UP FROM CABINET, REFER TO DETAIL.
- WASHING MACHINE FITTING, REFER TO DETAIL DWG. P3.1
- 1/2" GAS AT 6" ABOVE FLOOR WITH STOP VALVE FOR RANGE CONNECTION.
- DANGER ROOM SINK WITH WING FAUCET BY DIVISION 11470, 15400, VERIFY ALL CONNECTIONS BY DIVISION 15400.
- 1/2" COMPRESSED AIR PIPING DOWN TO 48" ABOVE FLOOR, VALVE AND CAP FOR FUTURE DISCONNECT BY OWNER.
- GAS REGULATOR TO PROVIDE 45 CU. FT. OF 7"WC NATURAL GAS PRESSURE FROM 2 PSI, REFER TO DETAIL DWG. P3.1
- GAS VALVE CABINET REFER TO DETAIL DWG. P3.1
- COMPRESSED AIR PRESSURE REGULATOR PIPING DETAIL, REFER TO DETAIL DWG. P3.1
- FLOOR DRAIN TO BE JOSAN, 35233-2, WITH HINGED GRATE AND SEDIMENT BUCKET, TO BE INSTALLED W/ TRAP
- SUMP PUMP TO BE LITTLE GIANI MODEL# 95-CA-RRS TO PUMP 30 GPM @ 20 FT. HD, 1/2 HP, 120V, COMPLETE WITH CHECK VALVE, UNION AND 24" BASIN
- 1 1/2" OPEN SITE DRAIN, SEE DETAIL DWG. P3.1, LOCATE ABOVE CEILING TO ALLOW FOR MAINTENANCE ACCESS.

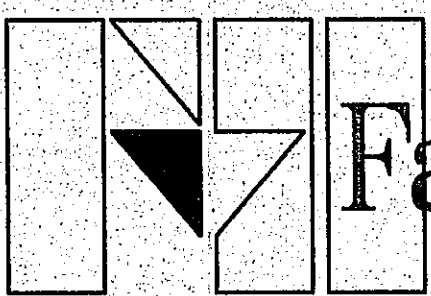


Architects Engineers Consultants

Fanning/Howey Associates, Inc.

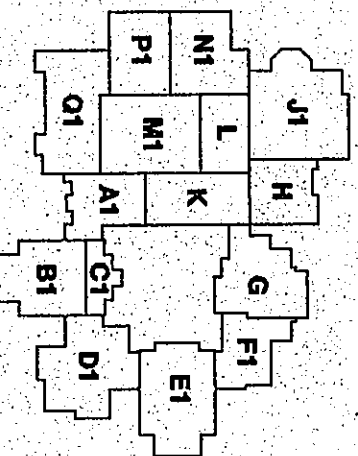

THE NEW
CHESTERTON HIGH SCHOOL
FOR THE
DUNELAND SCHOOL CORPORATION
CHESTERTON, INDIANA

COPYRIGHT 1997 BY FANNING/HOWEY ASSOCIATES, INC.

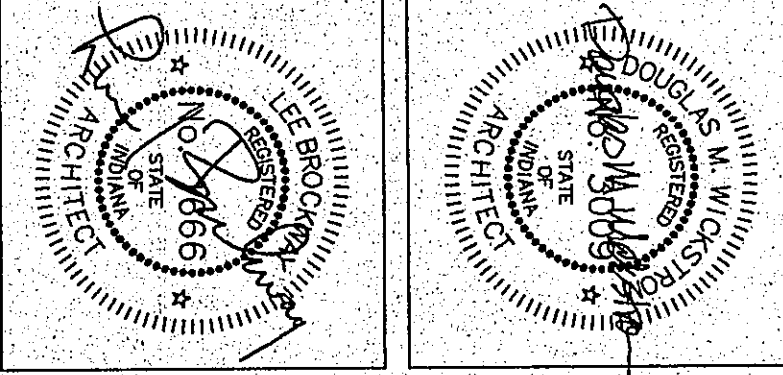

PLUMBING PLAN UNIT "H"

DRAWN BY: JJD COMM. NO.: 95067.00
CHECKED BY: CAM DATE: APRIL 21, 1997

P2.14

REVISIONS NO. DATE

CHESTERTON HIGH SCHOOL
95067.00