



ROOM NO.	ROOM NAME	AREA S.F.	CEILING HEIGHT
M101	GYMNASIUM	17084	9'-4"
M102	MEN'S TOILET	482	9'-4"
M103	WOMEN'S TOILET	482	9'-4"
M104	STORAGE	857	10'-0"
M105	WESTING	4553	10'-0"
M106	OFFICE	120	9'-4"
M107	OFFICE	2475	10'-0"
M108	STAIR	254	10'-0"

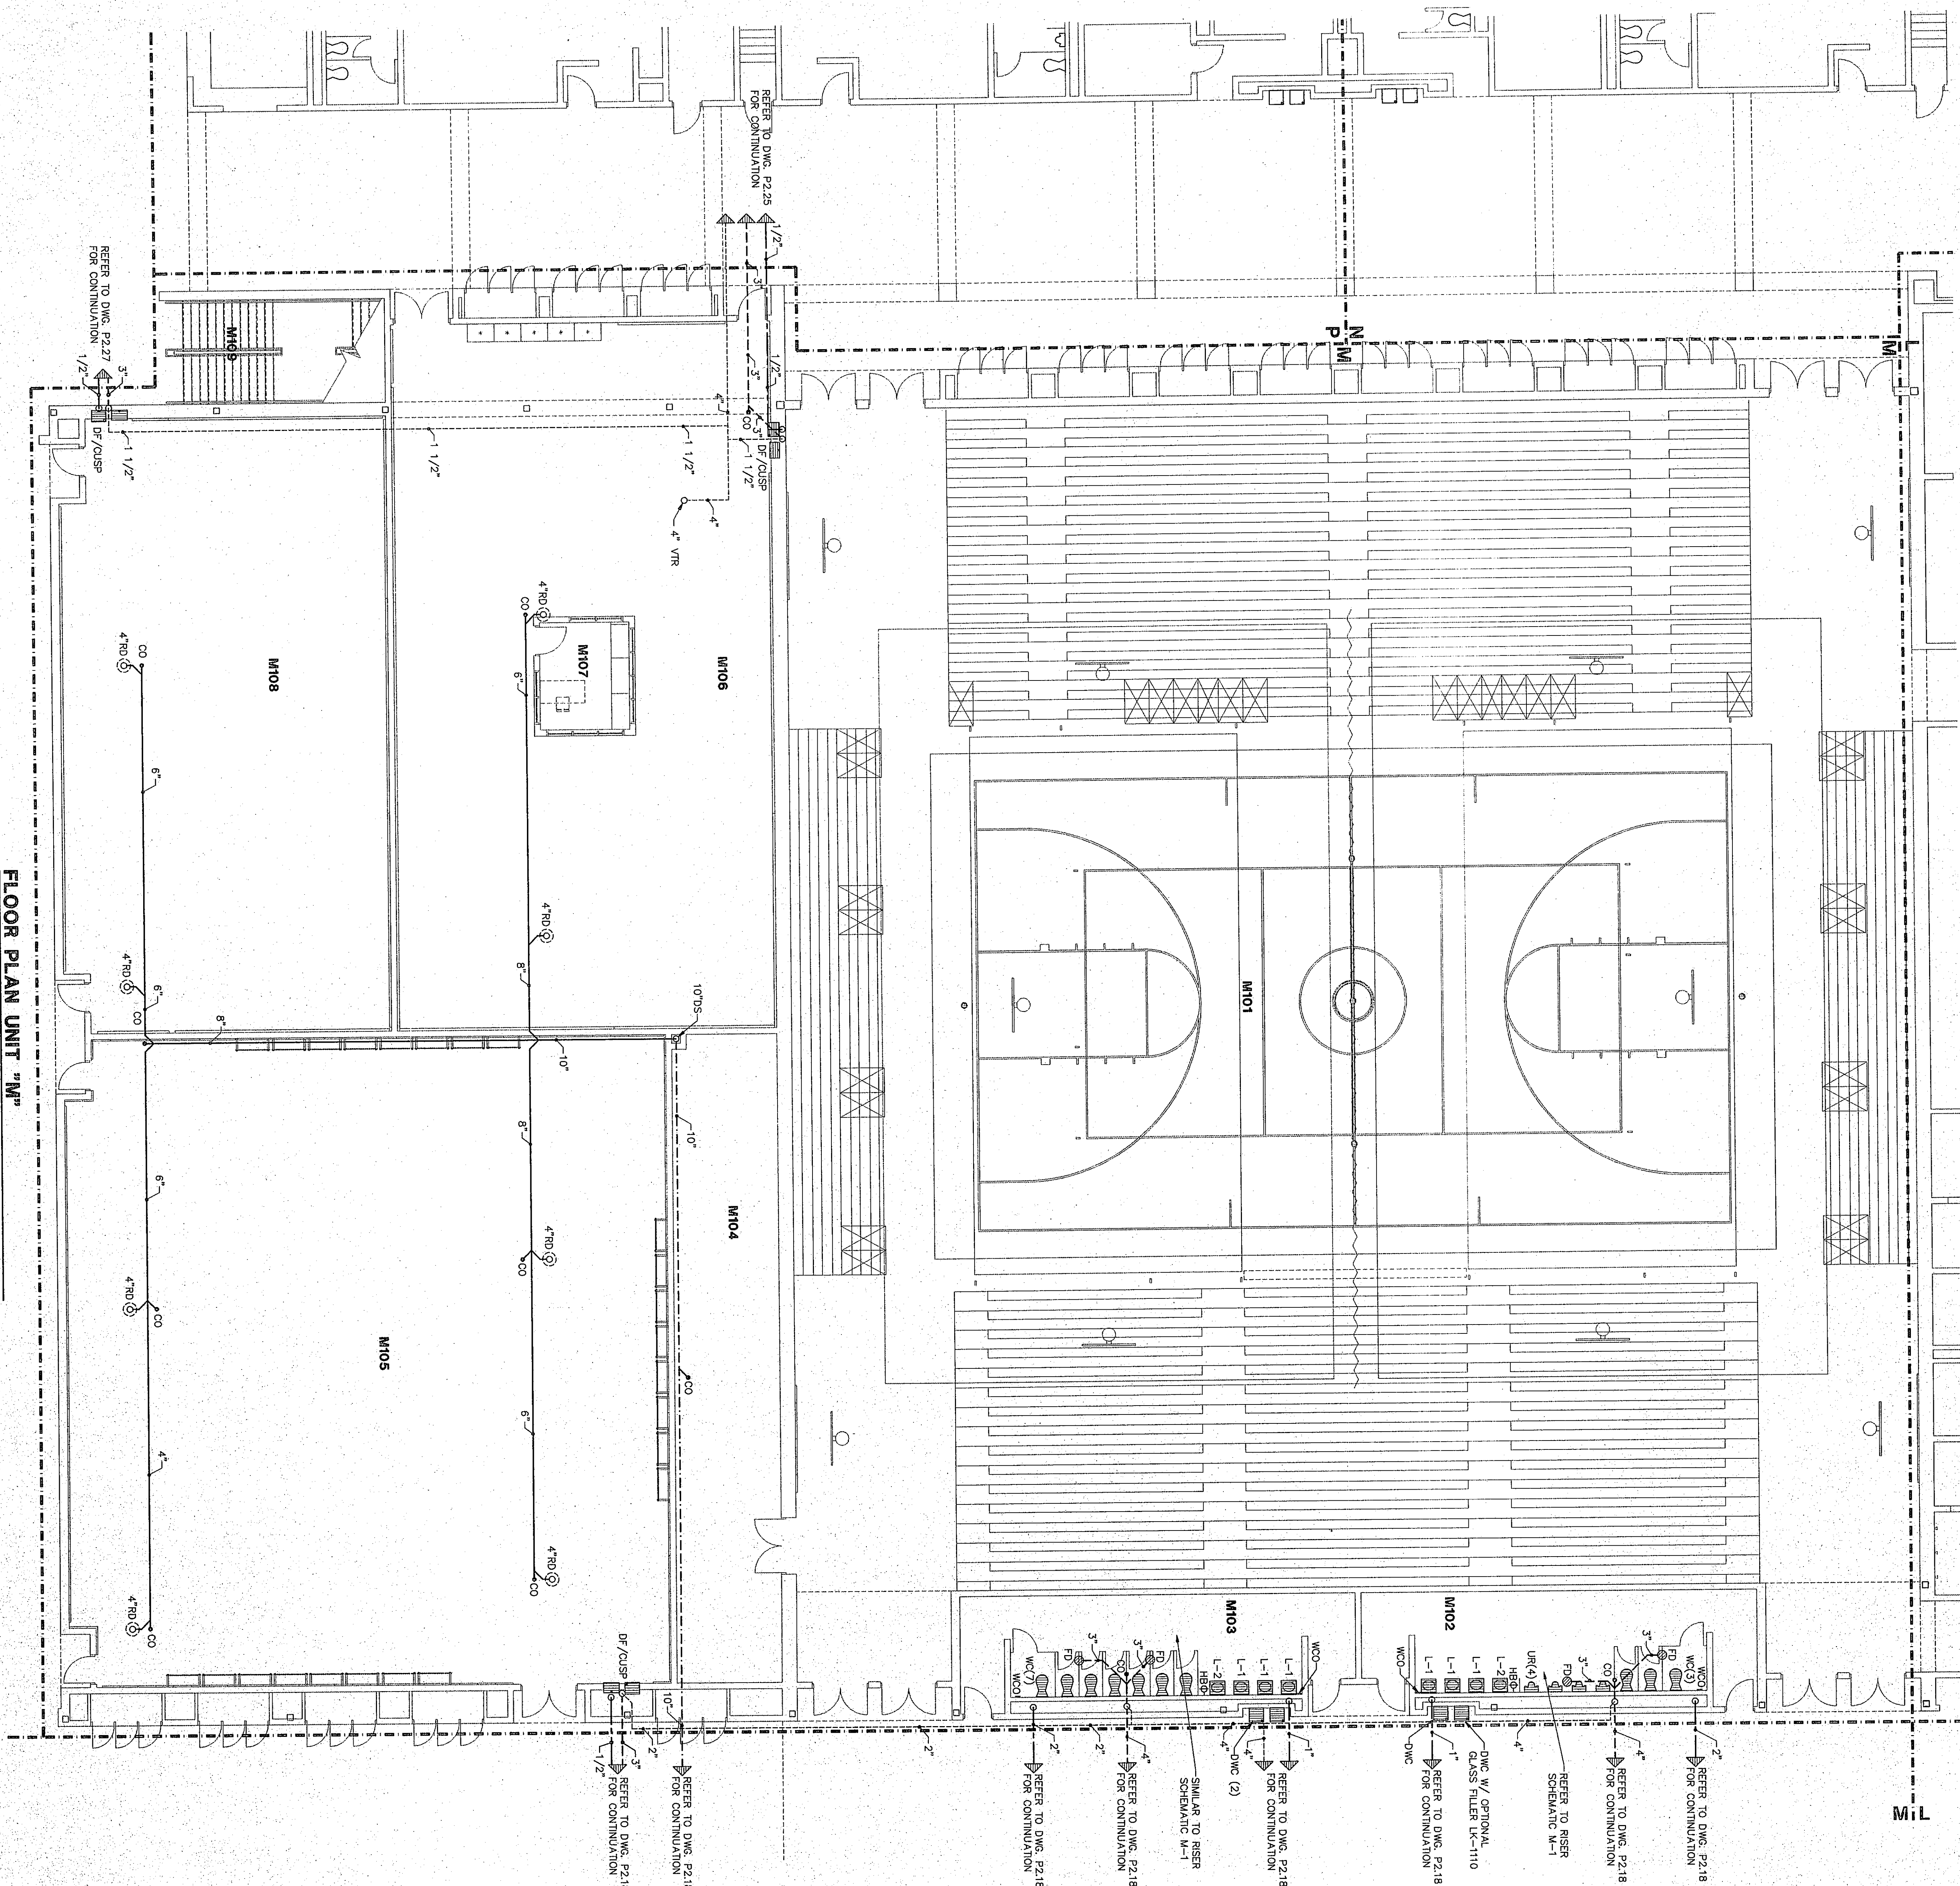

PLUMBING PLAN NOTES:

- 1/2" H/C WATER, 1 1/2" WASTE UP TO FIXTURE ABOVE.
- 1/2" COLD WATER UP AND DOWN TO DMC.
- 1/2" HOT AND COLD WATER, 1 1/2" WASTE DOWN TO FLOOR BELOW.
- 1/2" C/W DOWN TO 6" ABOVE FLOOR VALVE AND CAP FOR REFRIGERATOR ICEMAKER.
- DISHWASHER TO BE CONNECTED TO WATER AND WASTE PLUMBING OF ADJACENT SINK.
- HOT WATER AND/OR COLD WATER, GAS, AND SANITARY TRENCHES REFER TO BE INSTALLED IN COVERED FLOOR ARCHITECTURAL PLANS.
- HOT WATER AND/OR COLD WATER AND/OR GAS AND/OR OF CASEWORK BENEATH CABINETS AND ABOVE FLOOR.
- INSTALL DISPOSES AT THE LOCATION TO BE IN-SINK SERVICE, MODEL 77, 3/4" HP.
- GAS PIPING DOWN TO SOUNDED VALVE WITH RECESSED CABINET, AND UP FROM CABINET, REFER TO DETAIL.
- WASHING MACHINE FITTING, REFER TO DETAIL DWG. P3.1
- 1/2" GAS AT 6" ABOVE FLOOR WITH STOP VALVE FOR RANGE CONNECTION.
- DANGER: SINK WITH WING FAUCET BY DIVISION 11420. SANITARY, VENT, H/C WATER CONNECTIONS BY DIVISION 15450. VERIFY ALL CONNECTIONS.
- 1/2" COMPRESSED AIR PIPING DOWN TO 48" ABOVE FINISHED FLOOR VALVE AND TEE WITH DIRT LEG, AND PLUG FOR FUTURE QUICK DISCONNECT BY OWNER.
- GAS REGULATOR TO PROVIDE 45 CU. FT. OF 7"WC NATURAL GAS PRESSURE FROM 2 PSI. REFER TO DETAIL DWG. P3.1
- GAS VALVE CABINET REFER TO DETAIL DWG. P3.1
- COMPRESSED AIR PRESSURE REGULATOR PIPING DETAIL, REFER TO DETAIL DWG. P3.1
- FLOOR DRAIN TO BE JOMAX 35523-2 WITH HINGED GRATE AND SEDIMENT BUCKET, TO BE INSTALLED 1/4" RAMP.
- SUMP PUMP TO BE LITTLE GIANI MODEL# BE-CA-RS WITH CHECK VALVE, UNION AND 24" BASIN.
- 1 1/2" OPEN SITE DRAIN, SEE DETAIL DWG. P3.1, LOCATE ABOVE CEILING TO ALLOW FOR MAINTENANCE ACCESS.

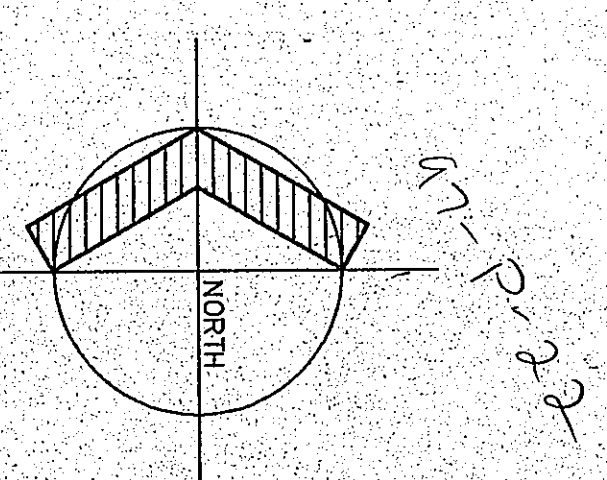

PLUMBING PLAN UNIT "M"


DRAWN BY: JD
CHECKED BY: CAM

COMM. NO.: 95067.00
DATE: APRIL 21, 1997

P2.21

REVISIONS NO. DATE

Fanning/Howey Associates, Inc.
Architects Engineers Consultants

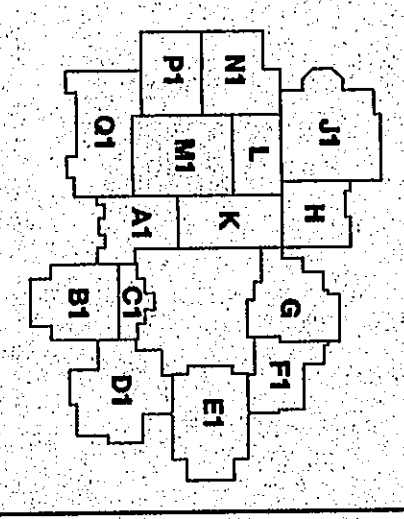

THE NEW CHESTERTON HIGH SCHOOL
FOR THE
DUNELAND SCHOOL CORPORATION
CHESTERTON, INDIANA

COPYRIGHT 1997 BY FANNING/HOWEY ASSOCIATES, INC.