


ROOM LEGEND "M2"			
ROOM NO.	ROOM NAME	AREA S.F.	CEILING HEIGHT
M201	SEALING MEZZANINE	3746	----


PLUMBING PLAN NOTES:

- 1/2" H&C WATER, 1 1/2" WASTE UP TO FIXTURE ABOVE
- 1/2" COLD WATER UP AND DOWN TO DMC.
- 1/2" HOT AND COLD WATER, 1 1/2" WASTE DOWN TO FLOOR BELOW.
- 1/2"CW DOWN TO 6" ABOVE FLOOR. VALVE AND CAP FOR REFRIGERATOR ICEMAKER.
- DISHWASHER TO BE CONNECTED TO WATER AND WASTE PLUMBING OF ADJACENT SINK.
- HOT WATER AND/OR COLD WATER, GAS, AND SANITARY VENT PIPING ARE TO BE INSTALLED IN COVERED FLOOR AREA. SEE DETAIL OF TRENCH INCLUDED ON ARCHITECTURAL PLANS.
- HOT WATER AND/OR COLD WATER AND/OR GAS AND/OR SANITARY VENT PIPING TO BE INSTALLED IN BASE FRAMING OF CASEWORK BENEATH CABINETRY AND ABOVE FLOOR.
- "IN-SINK-BRAVOR", MODEL 77, 3/4" HP.
- GAS PIPING DOWN TO SOLANOID VALVE WITHIN RECESSED CABINET, AND UP FROM CABINET. REFER TO DETAIL.
- 1/2" GAS AT 6" ABOVE FLOOR WITH STOP VALVE FOR RANGE CONNECTION.
- 1/2" COMPRESSED AIR PIPING DOWN TO 48" ABOVE FINISHED FLOOR. VALVE AND TEE WITH DIRT LEG, AND FLOOD FOR FUTURE QUICK DISCONNECT BY OWNER.
- GAS REGULATOR TO PROVIDE 45 C.I. FT. OF 7"WC NATURAL GAS PRESSURE FROM 2 PSI. REFER TO DETAIL DWG. P3.1
- GAS VALVE CABINET REFER TO DETAIL DWG. P3.1
- COMPRESSED AIR PRESSURE REGULATOR PIPING DETAIL. REFER TO DETAIL DWG. P3.1
- FLOOR DRAIN TO BE JOSELYN 35333-2 WITH UNFED GRATE AND SEDIMENT BUCKET TO BE INSTALLED W/ TRAP
- SHUT PIPING TO BE LITTLE GALT USED # 85-CLARS TO PLUMB TO OSW @ 20' E. AND 1/2" HP 120% COMPLETE WITH CHECK VALVE, UNION AND 24" BASIN
- 1 1/2" OPEN SITE DRAIN. SEE DETAIL DWG. P3.1 LOCATE ABOVE CEILING TO ALLOW FOR MAINTENANCE ACCESS.

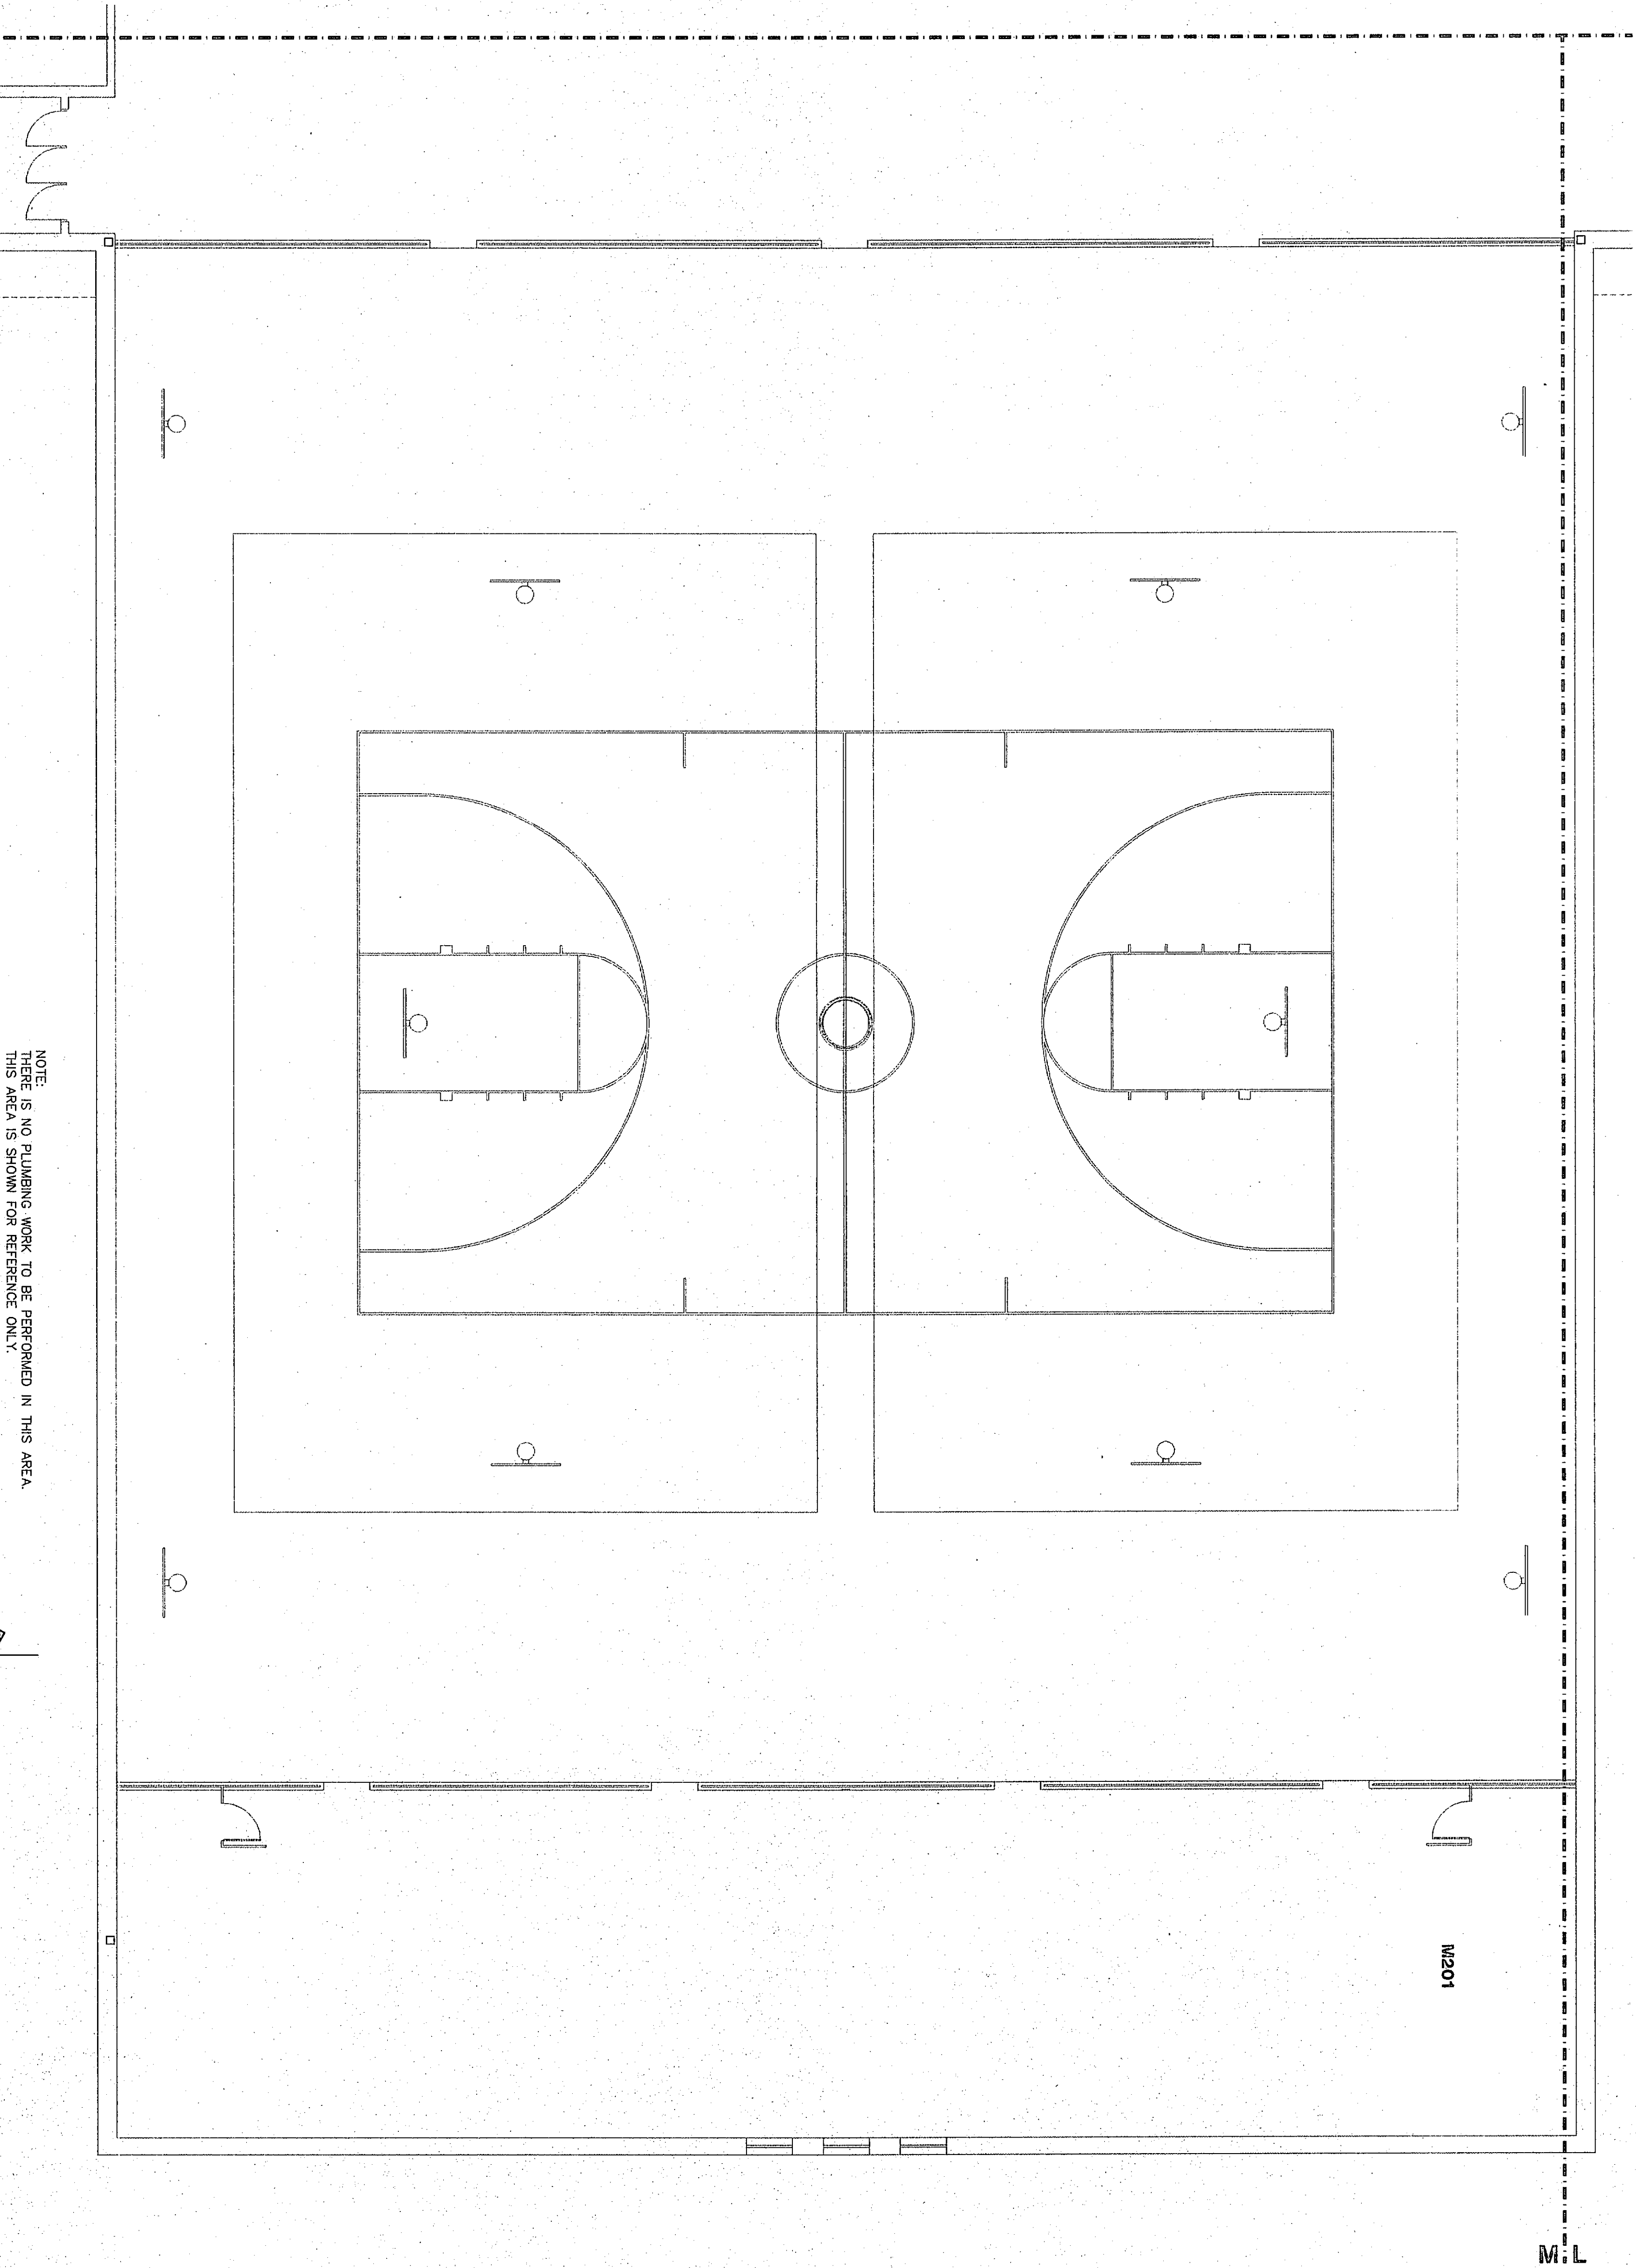


NOTE:
THERE IS NO PLUMBING WORK TO BE PERFORMED IN THIS AREA.
THIS AREA IS SHOWN FOR REFERENCE ONLY.

FLOOR PLAN UNIT "M2"

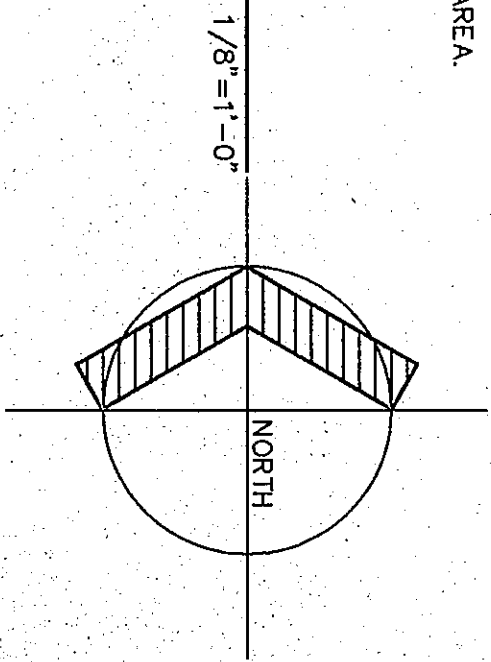

COPYRIGHT 1997 BY FANNING/HOWEY ASSOCIATES, INC.

THE NEW
CHESTERTON HIGH SCHOOL
 FOR THE
 DUNELAND SCHOOL CORPORATION
 CHESTERTON, INDIANA

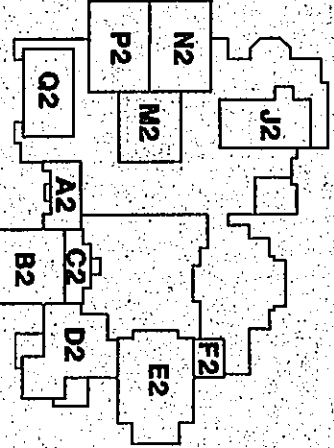

Fanning/Howey
 Associates, Inc.
 Architects Engineers Consultants

PLUMBING PLAN UNIT "M2"

DRAWN BY: JLD COMM. NO.: 95067.00
 CHECKED BY: CAM DATE: APRIL 21, 1997

P2.22

REVISIONS NO. DATE

CHESTERTON HIGH SCHOOL
 35353-2