



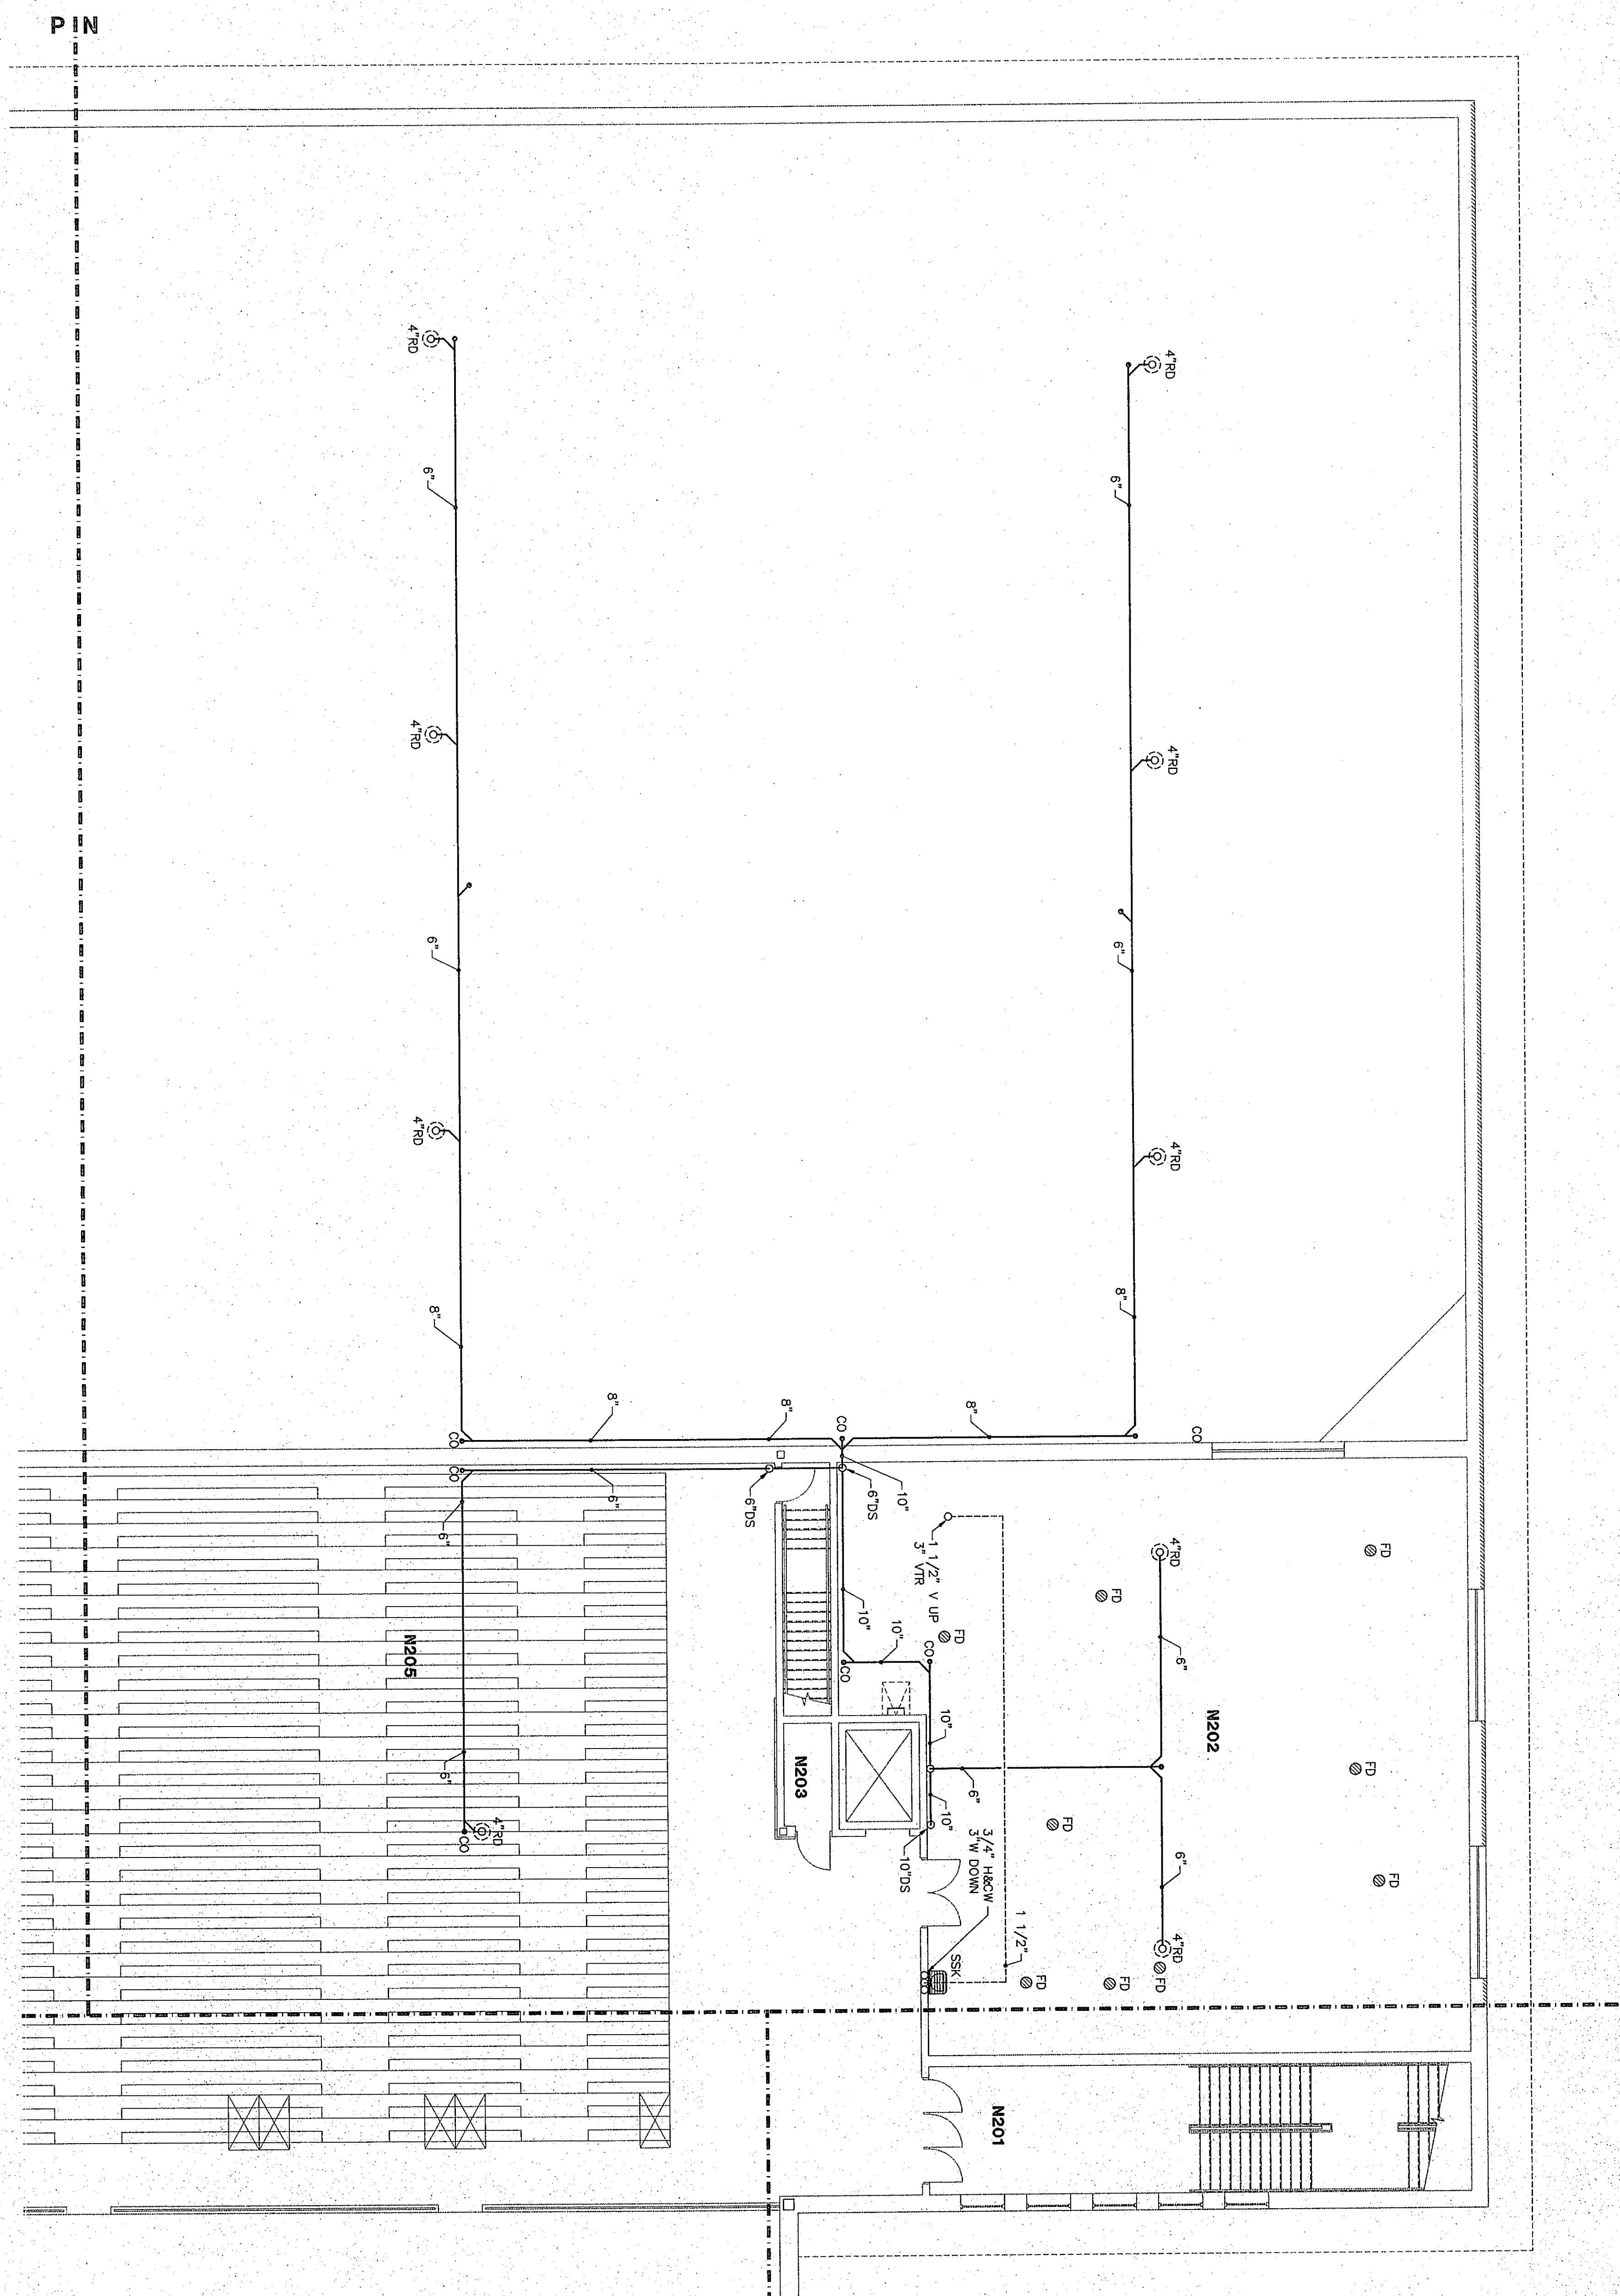


**FLOOR PLAN UNIT "N2"**

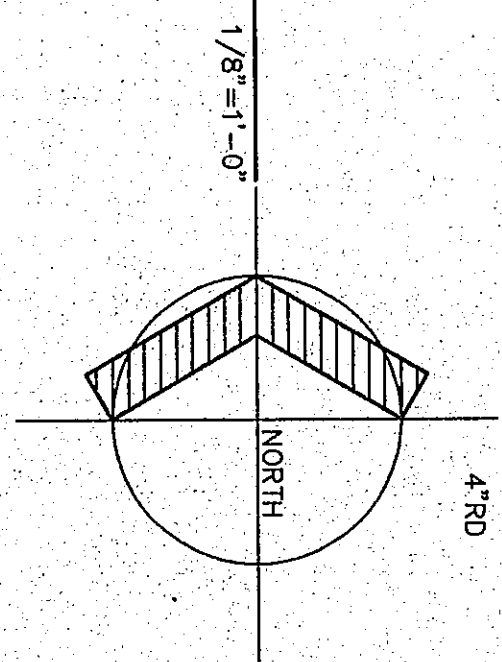

| ROOM NO. | ROOM NAME          | AREA S.F. | CEILING HEIGHT |
|----------|--------------------|-----------|----------------|
| N201     | STAR               | 579       | 10'-8"         |
| N202     | MECHANICAL ROOM    | 2856      | ---            |
| N203     | ELEVATOR EQUIPMENT | 37        | ---            |
| N204     | NOT USED           | ---       | ---            |
| N205     | BALCONY COURT      | 4681      | ---            |



**PLUMBING PLAN NOTES:**

- ① 1/2" H&G WATER, 1 1/2" WASTE UP TO FURTER ABOVE
- ② 1/2" HOT AND COLD WATER, 1 1/2" WASTE DOWN TO DMC.
- ③ 1/2" HOT AND COLD WATER, 1 1/2" WASTE DOWN TO FLOOR BELOW
- ④ 1/2" COLD WATER, VALVE, AND ONE FOR REFRIGERATOR ICEMAKER
- ⑤ DISMISHER TO BE CONNECTED TO WATER AND WASTE PLUMBING OF ADJACENT SINK.
- ⑥ PUMP FROM 8' ABOVE FLOOR, VALVE, AND ONE FOR REFRIGERATOR ICEMAKER
- ⑦ HOT WATER AND/OR COLD WATER, GAS, AND SANITARY LINE PIPING ARE TO BE INSTALLED IN COVERED FLOOR TRENCHES REFER TO DETAIL OF TRENCH INCLUDED ON ARCHITECTURAL PLANS.
- ⑧ HOT WATER AND/OR COLD WATER AND/OR GAS AND/OR SANITARY LINE PIPING TO BE INSTALLED IN BASE FRAMING OF JACKSON BENCHTOP CABINET AND ABOVE FLOOR.
- ⑨ INSTALL DISPOSER AT THIS LOCATION, TO BE IN-SINK-DRAINOR, MODEL 771, 9/4" HP.
- ⑩ GAS PIPING DOWN TO SOLENOID VALVE WITHIN RECESSED CABINET, AND UP FROM CABINET, REFER TO DETAIL.
- ⑪ WASHING MACHINE FITTING, REFER TO DETAIL DMC, P.31
- ⑫ 1/2" GAS LINE, 6" ABOVE FLOOR WITH STOP VALVE FOR FLAME CONNECTION.
- ⑬ DRAGONK SINK WITH MIXING FAUCET BY JONSON, 1/2", 15-500, VERIFY ALL CONNECTIONS BY JONSON, 15-500, VERIFY ALL CONNECTIONS.
- ⑭ 1/2" COMPRESSED AIR PIPING DOWN TO 4" ABOVE FINISHED FLOOR, VALVE ANDTEE WITH 1/2" H&G, AND PUMP FOR PUMPER CLOU DOCUMENT BY OWNER
- ⑮ GAS REGULATOR TO PROVIDE .45 OI, FT OF "WC NATURAL GAS PRESSURE, FROM 2 PSI, REFER TO DETAIL DMC, P.31
- ⑯ GAS VALVE, CABINET REFER TO DETAIL DMC, P.31
- ⑰ COMPRESSED AIR PRESSURE REGULATOR PIPING DETAIL, REFER TO DETAIL DMC, P.31
- ⑱ FLOOR DRAIN TO BE JOSSA, 3523-2, WITH HINGED VAPOR ARREST AND SEDIMENT BUCKET, TO BE INSTALLED VTRAP
- ⑲ SHIP PUMP TO BE LITTLE GIANIT MODEL 85-CI-GRS, TO PUMP 20 GPM @ 20 FT HD, 1/2" HP, 120V, COMPLETE WITH CHECK VALVE, UNION, AND 2-4" BSIN
- ⑳ 1/2" OPEN SIDE BRASS SEE DETAIL DMC, P.31, LOCATE ABOVE CEILING TO ALLOW FOR MAINTENANCE ACCESS.

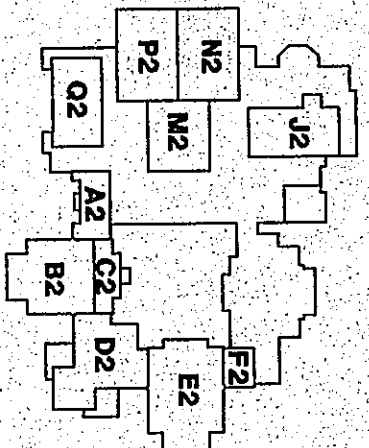

THE NEW  
**CHESTERTON HIGH SCHOOL**  
FOR THE  
DUNELAND SCHOOL CORPORATION  
CHESTERTON, INDIANA

**COPYRIGHT 1997 BY FANNING/HOWEY ASSOCIATES, INC.**

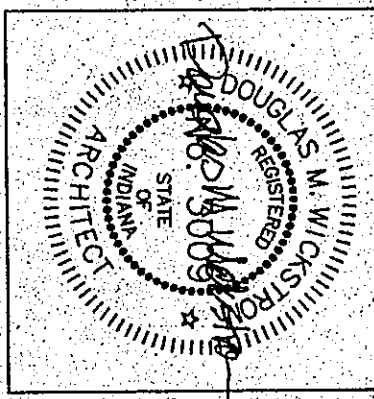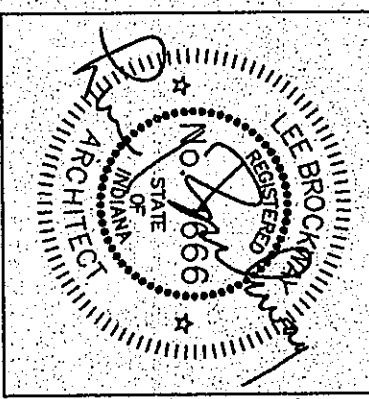


## PLUMBING PLAN UNIT "N2"

**DRAWN BY:** JJD      **COMM. NO.:** 95067.00  
**CHECKED BY:** CAM      **DATE:** APRIL 21, 1997

REVISIONS NO. DATE

**P2.24**

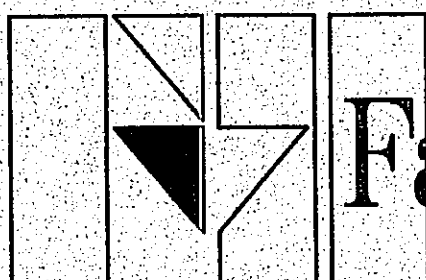

**Fanning/Howey**  
**Associates, Inc.**  
Architects Engineers Consultants

CHESTERTON HIGH SCHOOL  
95067.00