



ROOM LEGEND "P1"		
ROOM NO.	ROOM NAME	AREA S.F.
P101	MEN'S TOILET	429
P102	ATHLETIC STORAGE	294
P103	DRINKING ROOM	49
P104	LOCKER	130
P105	SHOWER	71
P106	STORAGE	79
P107	COACH LOCKER	52
P108	TOILET	52
P109	BOY'S PE LOCKER	747
P110	TOILET ROOM	104
P111	SHOWER	130
P112	CONCESSION STAND	333
P113	CORRIDOR	389
P114	ELECTRICAL ROOM	95

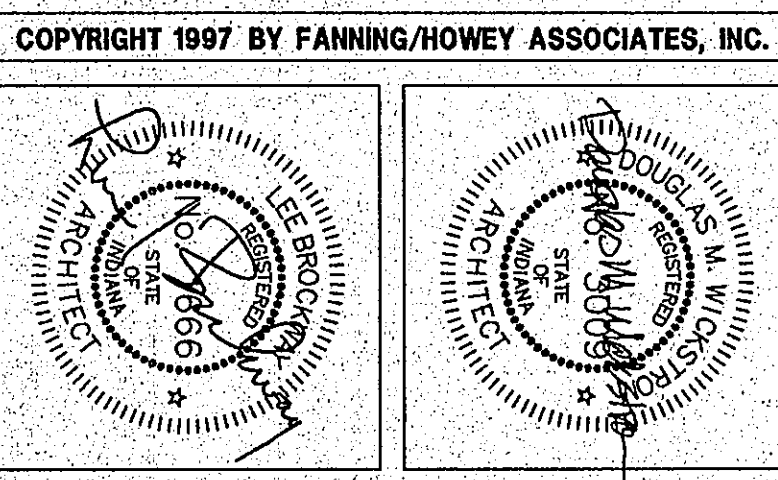

THE NEW
CHESTERTON HIGH SCHOOL
 FOR THE
 DUNELAND SCHOOL CORPORATION
 CHESTERTON, INDIANA

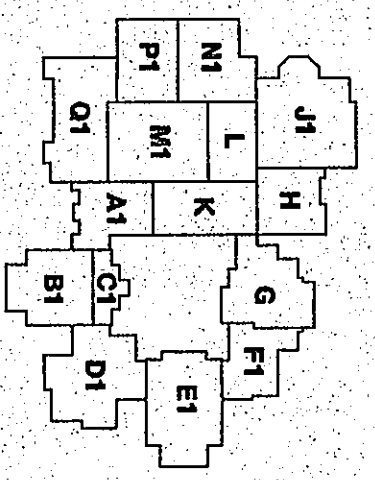

Fanning/Howey Associates, Inc.
 Architects Engineers Consultants


PLUMBING PLAN UNIT "P"

DRAWN BY: JLD COMM. NO.: 95067.00
 CHECKED BY: CAM DATE: APRIL 21, 1997

P2.25

REVISIONS NO. DATE

- PLUMBING PLAN NOTES:**
- 1/2" H.C. WATER, 1/2" WASTE UP TO EXISTURE ABOVE
 - 1/2" COLD WATER UP AND DOWN TO D.W.C.
 - 1/2" HOT AND COLD WATER, 1/2" WASTE DOWN TO FLOOR BELOW
 - 1/2" C.W. DOWN TO 6" ABOVE FLOOR, VALVE AND CWP FOR REFRIGERATOR ICEMAKER
 - DISWASHER TO BE CONNECTED TO WATER AND WASTE
 - PLUMBING OF ADJACENT SINK
 - HOT WATER AND/OR COLD WATER, GAS AND SANITARY TRENCHES, REFER TO DETAIL OF TRENCH INCLUDED ON ARCHITECTURAL PLANS
 - HOT WATER AND/OR COLD WATER AND/OR GAS AND/OR SANITARY VENT PIPING TO BE INSTALLED IN BASE FRAMING OF CASKWORK BENEATH CABINETRY AND ABOVE FLOOR
 - INSTALL DISPOSER AT THIS LOCATION, TO BE "IN-SINK-ERATOR", MODEL 77, 3/4 HP.
 - GAS PIPING DOWN TO SOLENOID VALVE, WITHIN RECESSED CABINET, AND UP FROM CABINET, REFER TO DETAIL
 - WASHING MACHINE FITTING, REFER TO DETAIL DWG. P3.1
 - 1/2" GAS AT 6" ABOVE FLOOR WITH STOP VALVE FOR RANGE CONNECTION
 - DARRAGON SINK WITH MIXING FAUCET BY DIVISION 11470, 1/2" GAS AND 1/2" C.W. CONNECTIONS BY DIVISION 12460, VERIFY ALL CONNECTIONS
 - 1/2" COMPRESSED AIR PIPING DOWN TO 4" ABOVE FINISHED FLOOR, WITH 1/2" GAS AND 1/2" C.W. AND PLUG FOR FUTURE QUICK DISCONNECT BY OWNER
 - GAS REGULATOR TO PROVIDE 45 CU. FT. OF 7" N.C. NATURAL GAS PRESSURE FROM 2 PSI, REFER TO DETAIL DWG. P3.1
 - GAS VALVE CABINET REFER TO DETAIL DWG. P3.1
 - COMPRESSED AIR PRESSURE REGULATOR PIPING DETAIL, REFER TO DETAIL DWG. P3.1
 - FLOOR DRAIN TO BE JOSAM 35533-2, WITH HINGED GRATE AND SEDIMENT BUCKET, TO BE INSTALLED W/ TRAP
 - SUMP PUMP TO BE LITTLE GIANT MODEL 9E-GA-RFS TO PUMP 30 GPM @ 20 FT. HD, 1/2 HP, 120V, COMPLETE WITH CHECK VALVE, UNION AND 24" BASIN
 - 1/2" OPEN SITE DRAIN, SEE DETAIL DWG. P3.1, LOCATE ABOVE CEILING TO ALLOW FOR MAINTENANCE ACCESS

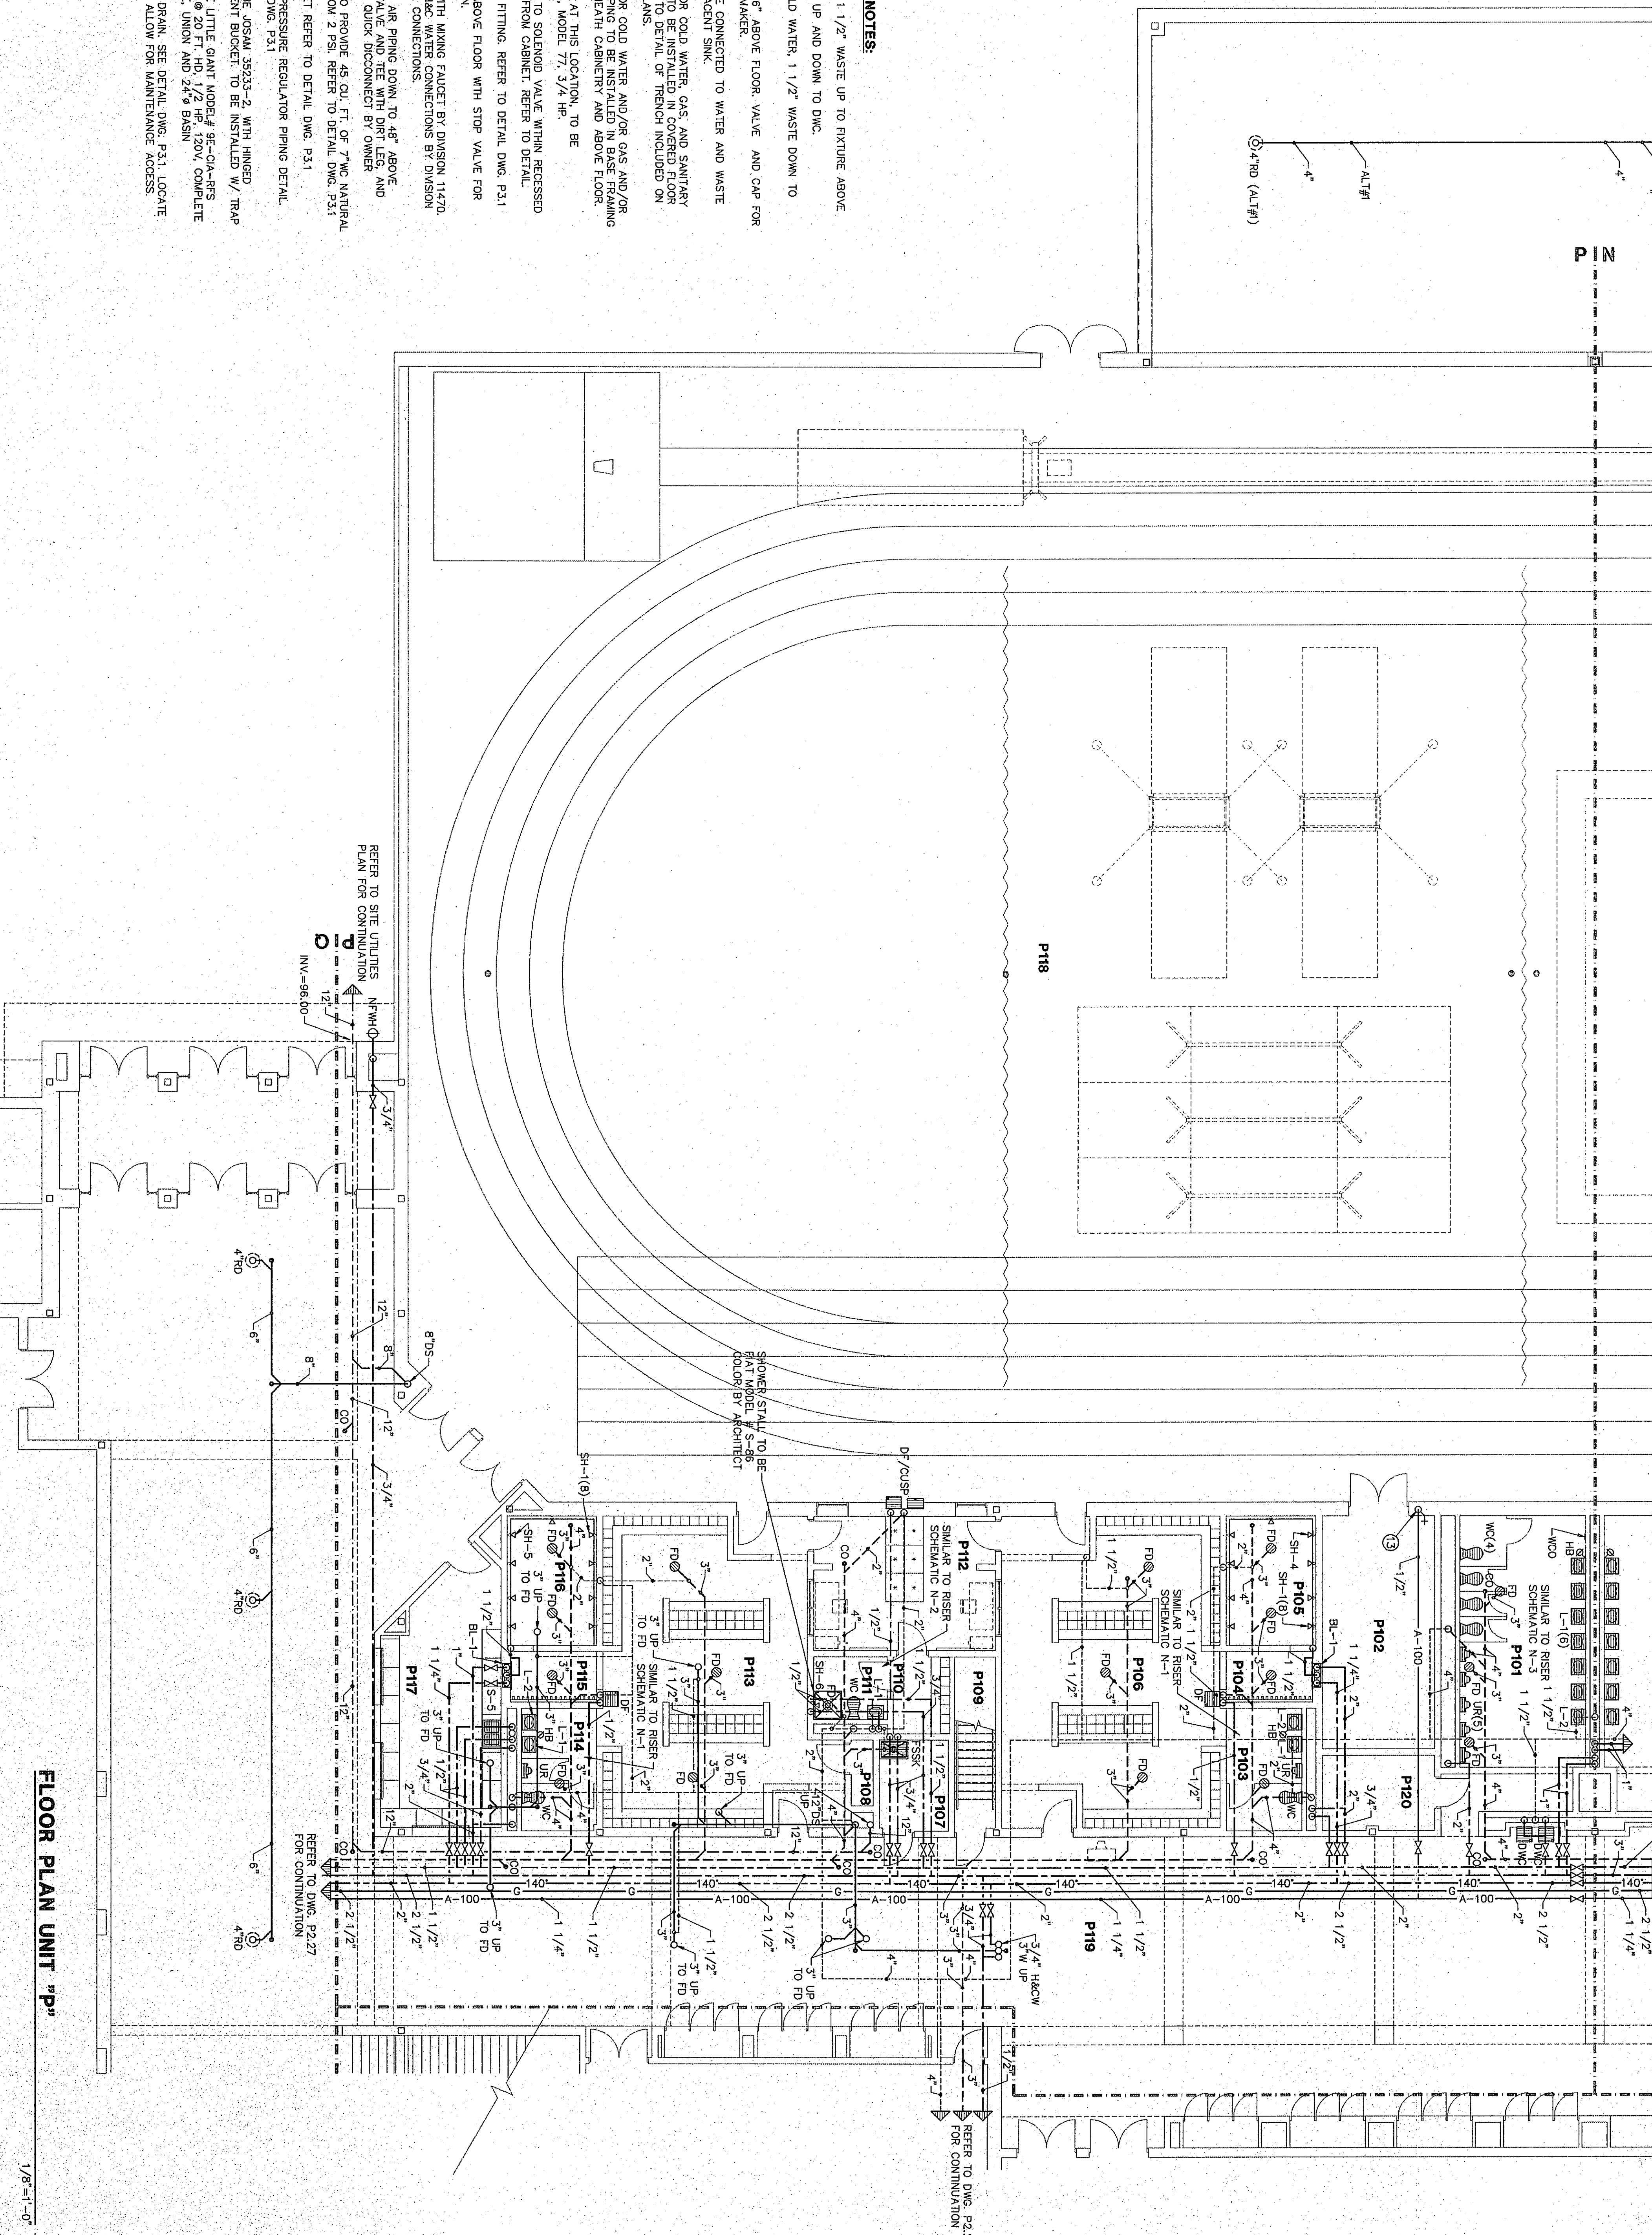

FLOOR PLAN UNIT "P"

