




ROOM LEGEND "P2"			
ROOM NO.	ROOM NAME	AREA S.F.	CEILING HEIGHT
P201	STAIR	681	10'-8"
P202	MECHANICAL ROOM	2725	
P203	STORAGE	193	9'-4"
P204	BALCONY COURT	4326	---

PLUMBING PLAN NOTES



- [illegible]

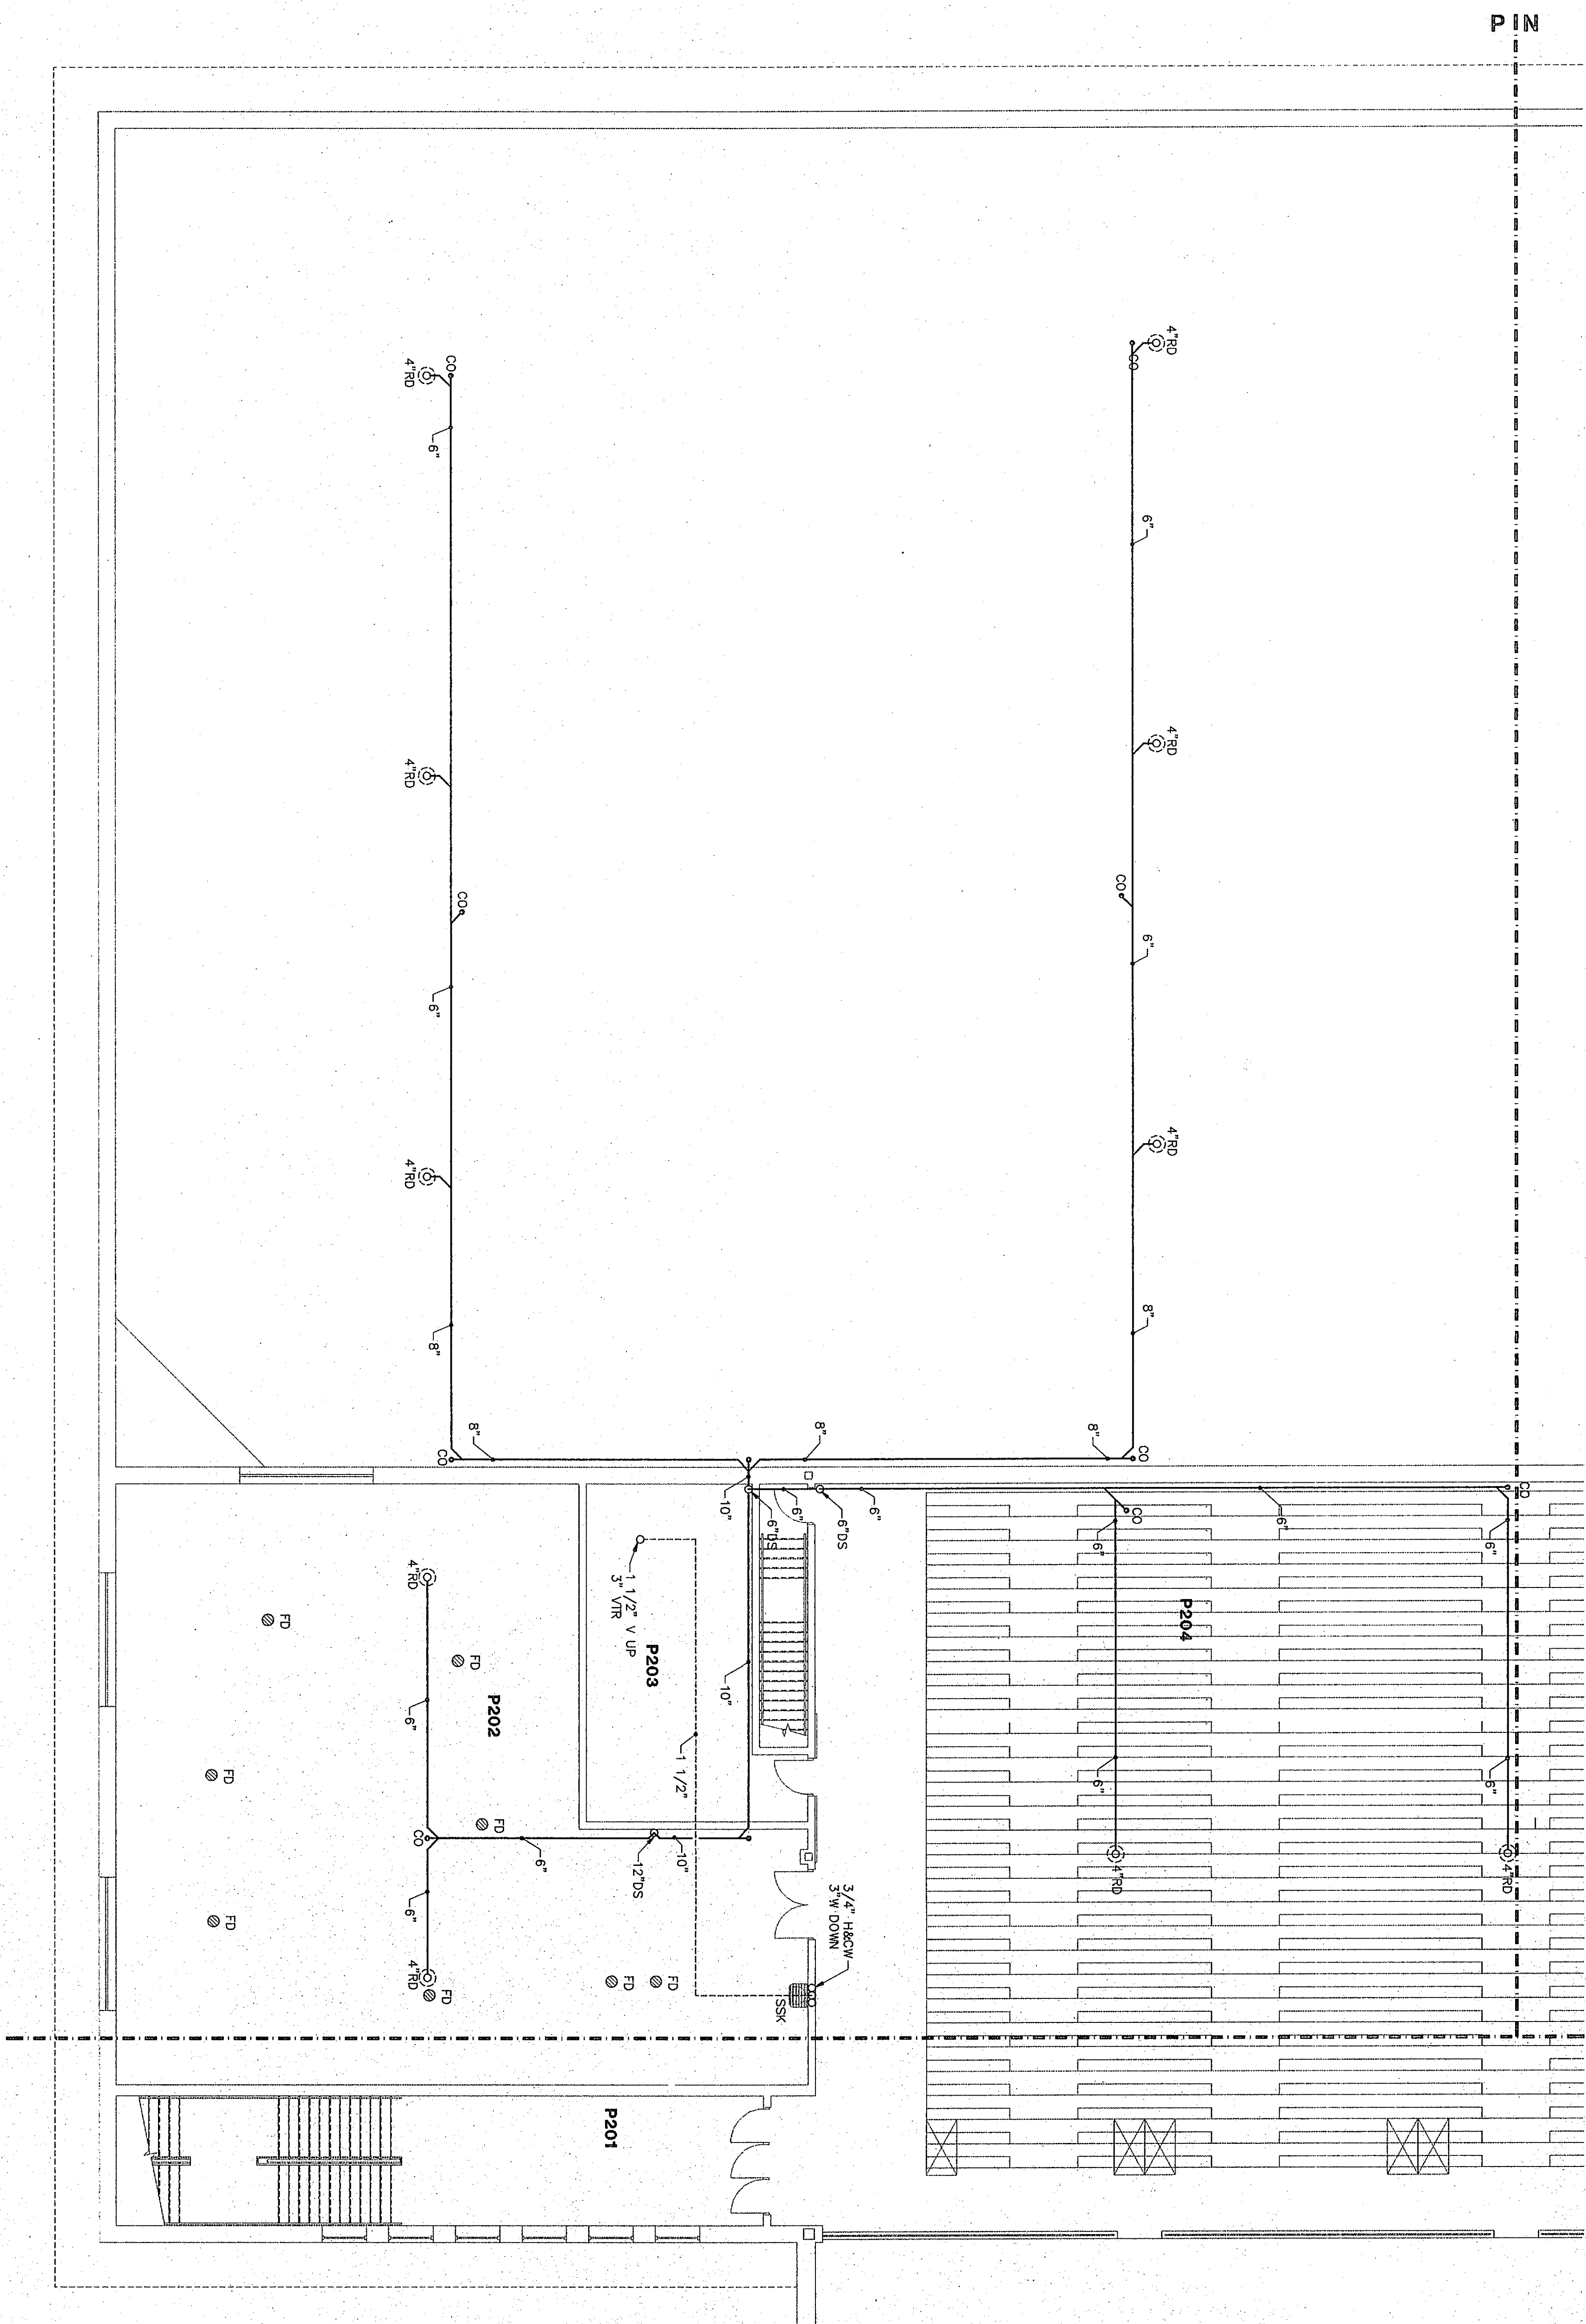

FLOOR PLAN UNIT "P2"

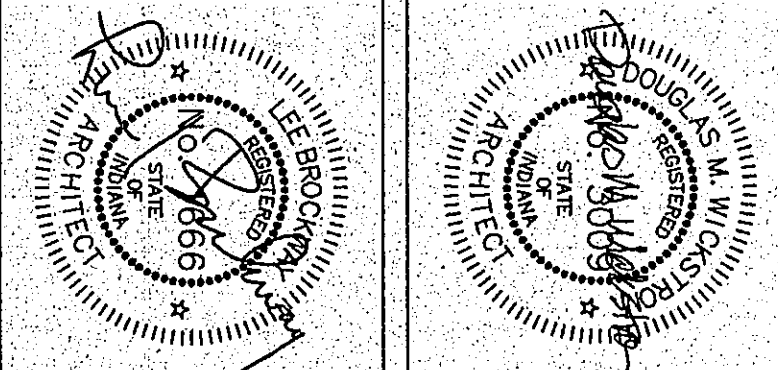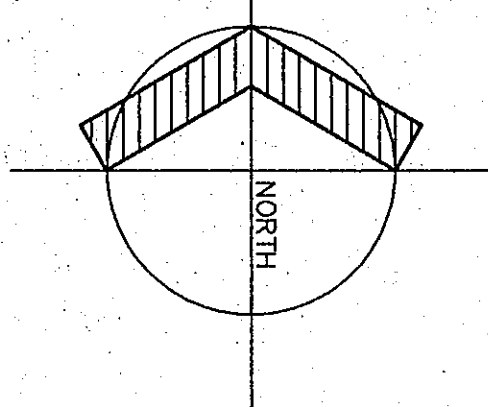 $1/8"=1'-0"$ 

THE NEW
CHESTERTON HIGH SCHOOL
FOR THE
DUNELAND SCHOOL CORPORATION
CHESTERTON, INDIANA

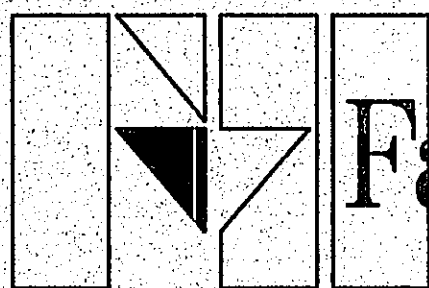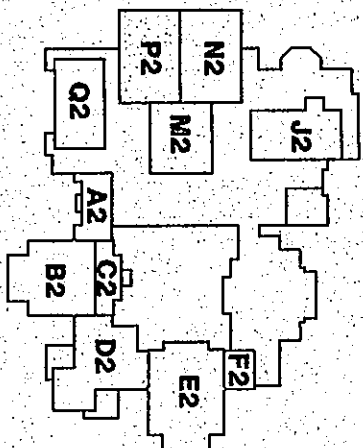

Fanning/Howey
Associates, Inc.
Architects Engineers Consultants

PLUMBING PLAN UNIT "P2"

DRAWN BY: JJD	COMM. NO.: 95067.00
CHECKED BY: CAM	DATE: APRIL 21, 1997

REVISIONS NO. DATE

P2.26