


PLUMBING PLAN NOTES:

- 1/2" H&O WATER, 1 1/2" WASTE UP TO FUTURE ABOVE
- 1/2" COLD WATER UP AND DOWN TO DMC.
- 1/2" HOT AND COLD WATER, 1 1/2" WASTE DOWN TO FLOOR BELOW.
- 1/2" CW DOWN TO 6" ABOVE FLOOR, VALVE AND CAP FOR REFRIGERATOR ICEMAKER.
- DISHWASHER TO BE CONNECTED TO WATER AND WASTE PLUMBING OF ADJACENT SINK.
- HOT WATER AND/OR COLD WATER, GAS, AND SANITARY VENT PIPING ARE TO BE INSTALLED IN COVERED FLOOR REFINISHES. REFER TO DETAIL OF FINISHES INCLUDED ON ARCHITECTURAL PLANS.
- HOT WATER AND/OR COLD WATER AND/OR GAS AND/OR SANITARY VENT PIPING ARE TO BE INSTALLED IN COVERED FLOOR REFINISHES. REFER TO DETAIL OF FINISHES INCLUDED ON ARCHITECTURAL PLANS.
- INSTALL DISPOSER AT THIS LOCATION, TO BE IN-SINK-EXTRACTOR, MODEL 71, 3/4" HP.
- GAS PIPING DOWN TO SOLENOID VALVE WITHIN RECESSED CABINET, AND UP FROM CABINET, REFER TO DETAIL.
- WASHING MACHINE FITTING, REFER TO DETAIL DWG. P-31
- 1/2" GAS AT 6" ABOVE FLOOR WITH STOP VALVE FOR RANGE CONNECTION.
- DANGER: SINK WITH MIXING FAUCET BY DIVISION 11470 SANITARY, VENT, H&O WATER CONNECTIONS BY DIVISION 15450, VERIFY ALL CONNECTIONS.
- 1/2" COMPRESSED AIR PIPING DOWN TO 48" ABOVE FINISHED FLOOR, VALVE AND TEE WITH DIRT LEG, AND PLUG FOR FUTURE QUICK DISCONNECT BY OWNER.
- GAS REGULATOR TO PROVIDE 45 CU. FT. OF 7"WC NATURAL GAS PRESSURE FROM 2 PSI, REFER TO DETAIL DWG. P-31
- GAS VALVE CABINET REFER TO DETAIL DWG. P-31
- COMPRESSED AIR PRESSURE REGULATOR PIPING DETAIL, REFER TO DETAIL DWG. P-31
- FLOOR DRAIN TO BE JOSEPH 3523-2 WITH HINGED GRATE AND SEDIMENT BUCKET, TO BE INSTALLED 1/4" TRAP
- SUMP PUMP TO BE LITTLE GIANT MODEL# 95-CV-ARS TO PUMP 30 GPM @ 20' AND 24" BASIN
- 1 1/2" OPEN SITE DRAIN, SEE DETAIL DWG. P-31, LOCATE ABOVE CEILING TO ALLOW FOR MAINTENANCE ACCESS.


ROOM LEGEND "Q"

ROOM NO.	ROOM NAME	AREA S.F.	CEILING HEIGHT
Q101	VESTIBULE	408	9'-4"
Q102	CORRIDOR	2628	9'-4"
Q103	CLASSROOM/SUSPENSION	924	9'-4"
Q104	CLASSROOM	924	9'-4"
Q105	CLASSROOM	924	9'-4"
Q106	CLASSROOM	924	9'-4"
Q107	CLASSROOM	924	9'-4"
Q108	CLASSROOM	924	9'-4"
Q109	CLASSROOM	924	9'-4"
Q110	CLASSROOM	924	9'-4"
Q111	CLASSROOM	924	9'-4"
Q112	CLASSROOM	924	9'-4"
Q113	CLASSROOM	924	9'-4"
Q114	CLASSROOM	924	9'-4"
Q115	CLASSROOM	924	9'-4"
Q116	CLASSROOM	924	9'-4"
Q117	CLASSROOM	924	9'-4"
Q118	CLASSROOM	924	9'-4"
Q119	CLASSROOM	924	9'-4"
Q120	CLASSROOM	924	9'-4"
Q121	CLASSROOM	924	9'-4"
Q122	CLASSROOM	924	9'-4"
Q123	CLASSROOM	924	9'-4"
Q124	CLASSROOM	924	9'-4"
Q125	CLASSROOM	924	9'-4"
Q126	CLASSROOM	924	9'-4"
Q127	CLASSROOM	924	9'-4"
Q128	CLASSROOM	924	9'-4"
Q129	CLASSROOM	924	9'-4"
Q130	CLASSROOM	924	9'-4"
Q131	CLASSROOM	924	9'-4"
Q132	CLASSROOM	924	9'-4"
Q133	CLASSROOM	924	9'-4"
Q134	CLASSROOM	924	9'-4"
Q135	CLASSROOM	924	9'-4"
Q136	CLASSROOM	924	9'-4"
Q137	CLASSROOM	924	9'-4"

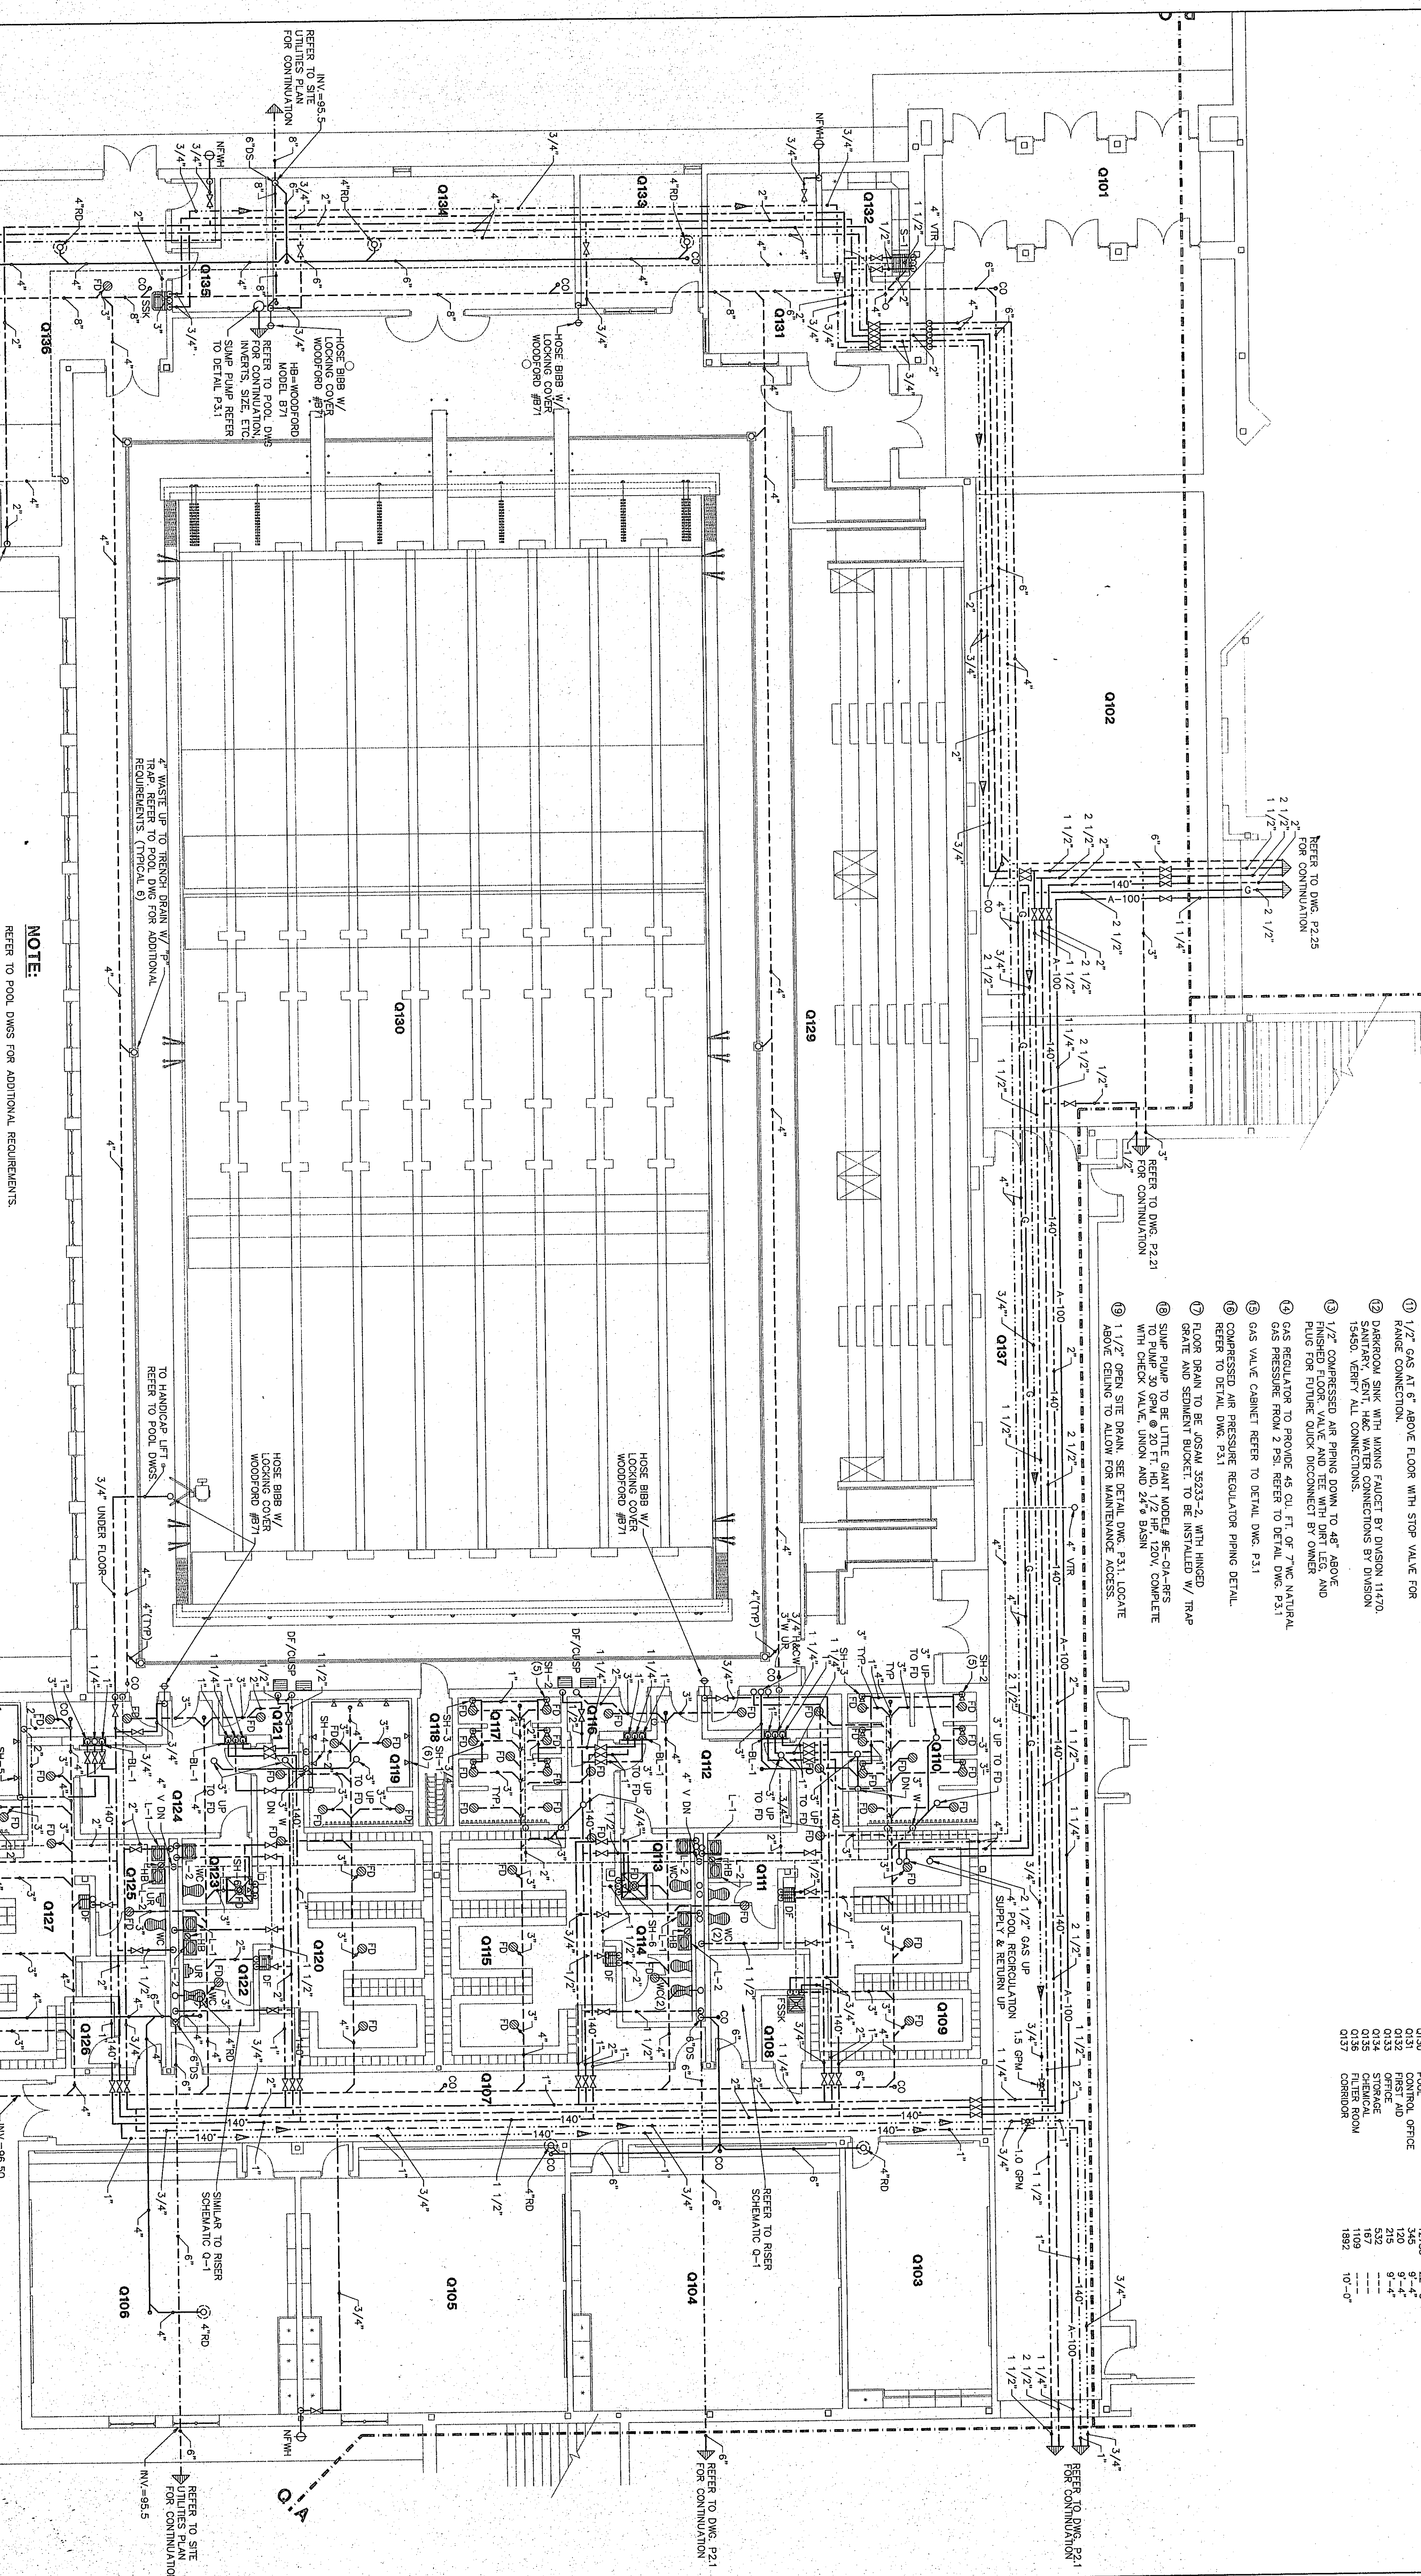

NOTE:
REFER TO POOL DWGS FOR ADDITIONAL REQUIREMENTS.

FLOOR PLAN UNIT "Q"

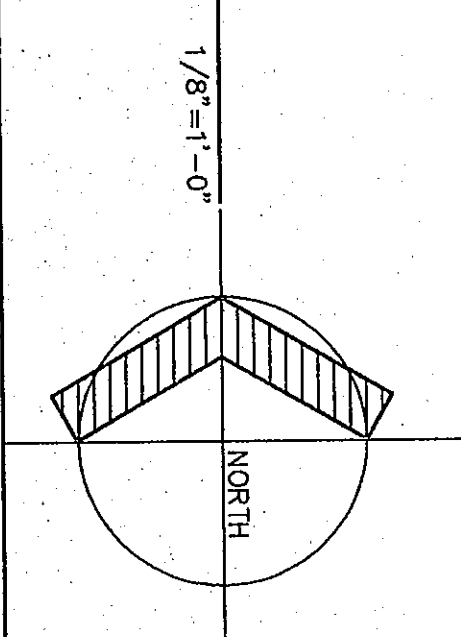

PLUMBING PLAN UNIT "Q"


DRAWN BY: JJD COMM. NO.: 95067.00
CHECKED BY: CAM DATE: APRIL 21, 1997

P2.27

REVISIONS NO. DATE

Fanning/Howey Associates, Inc.

Architects Engineers Consultants

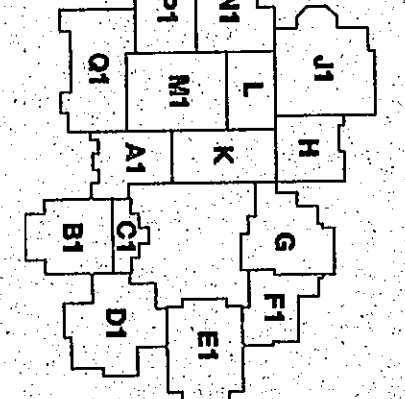

THE NEW
CHESTERTON HIGH SCHOOL
FOR THE
DUNELAND SCHOOL CORPORATION
CHESTERTON, INDIANA

COPYRIGHT 1997 BY FANNING/HOWEY ASSOCIATES, INC.