

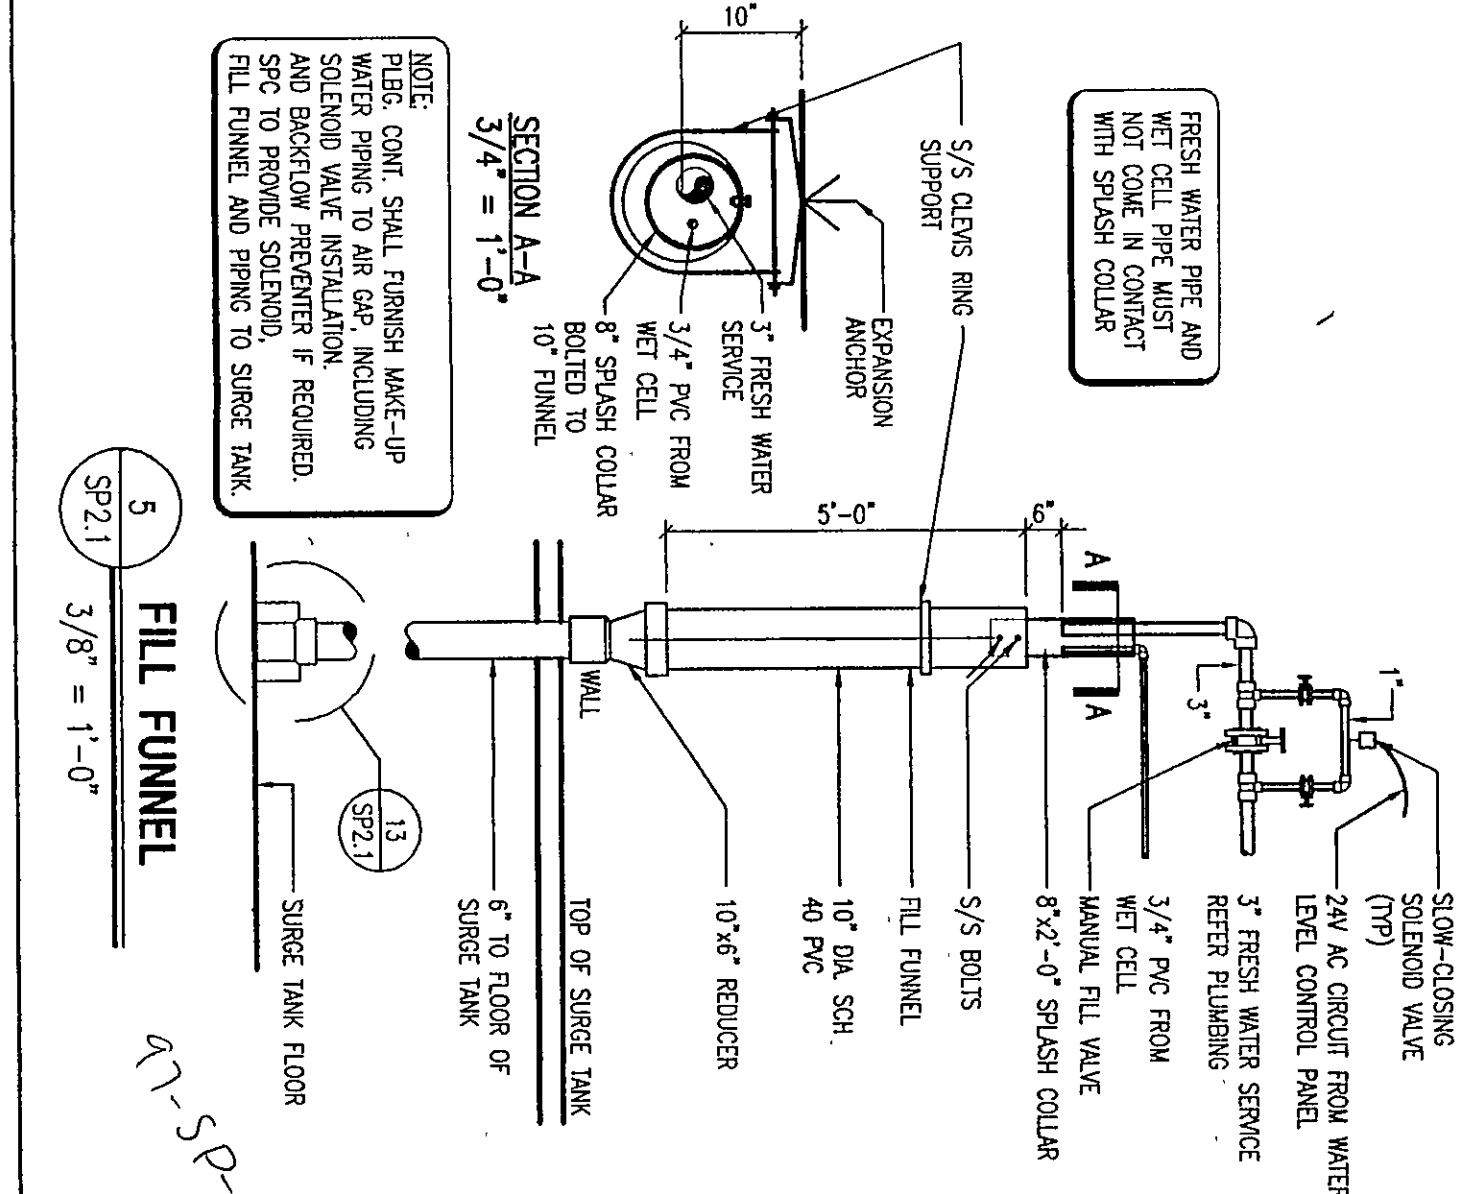
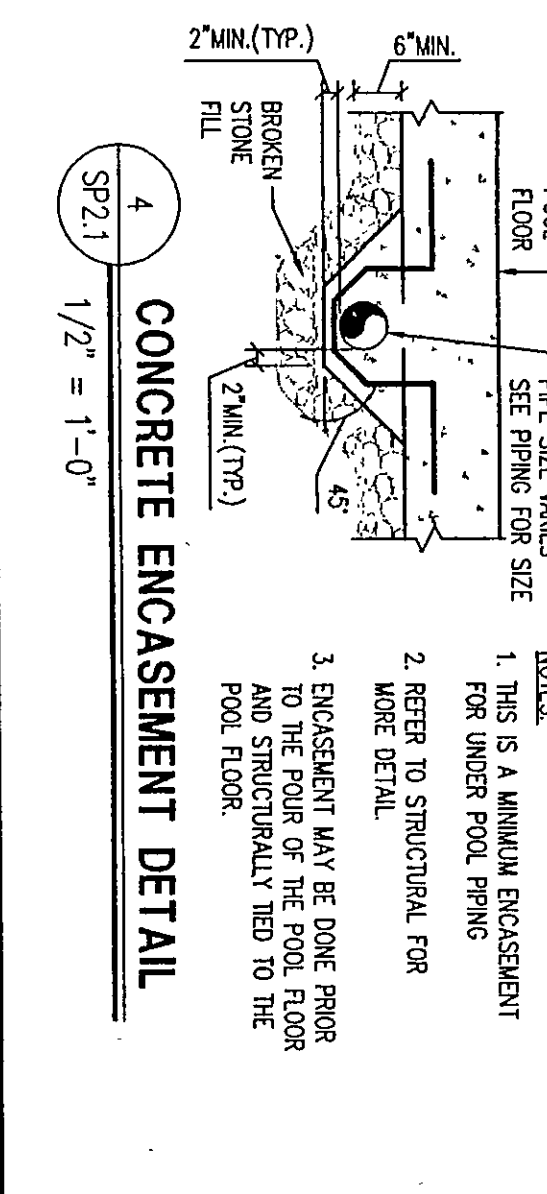
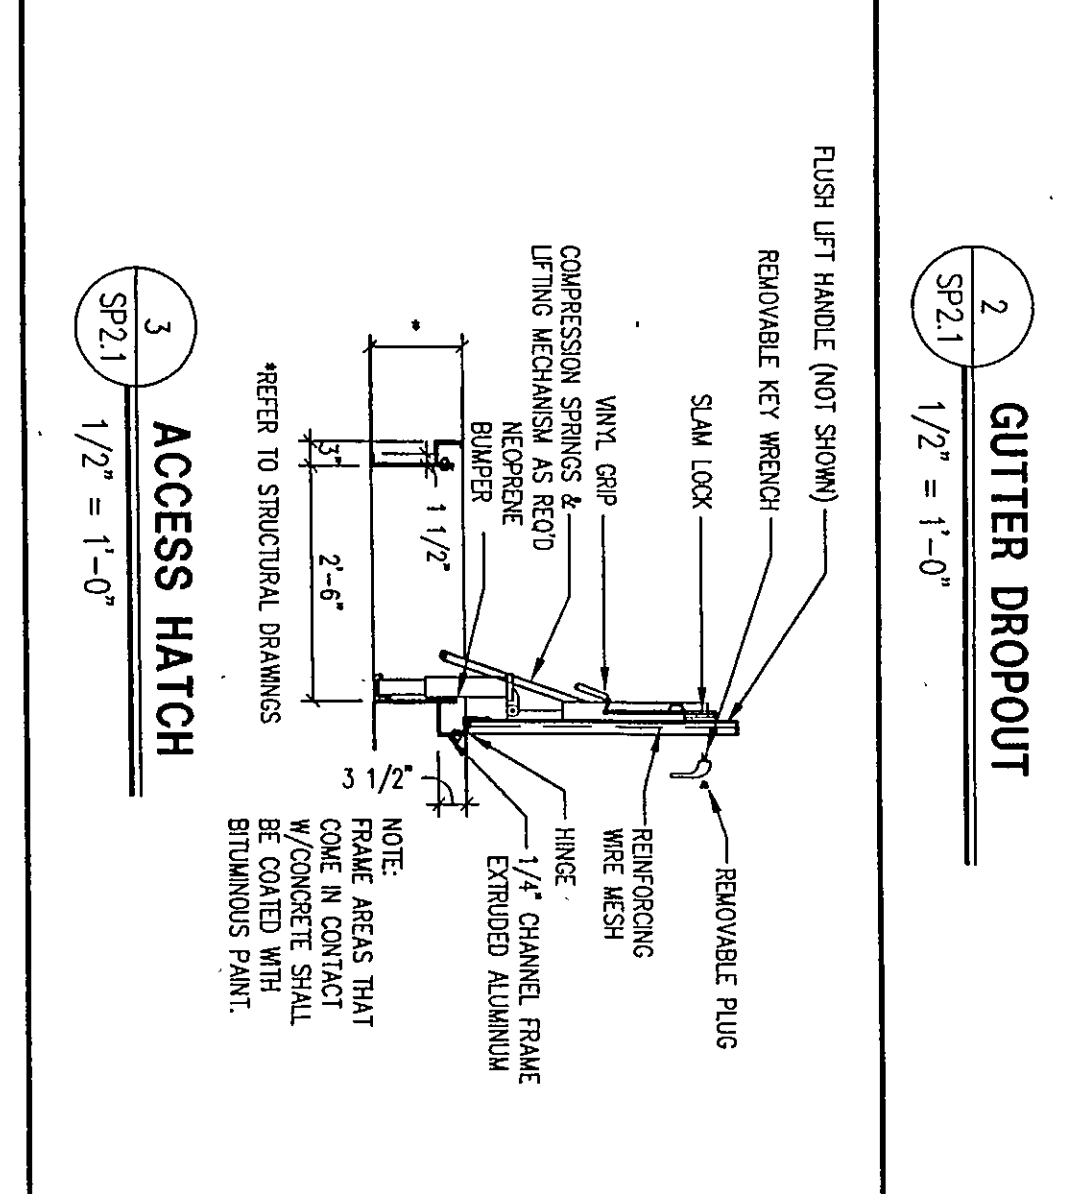
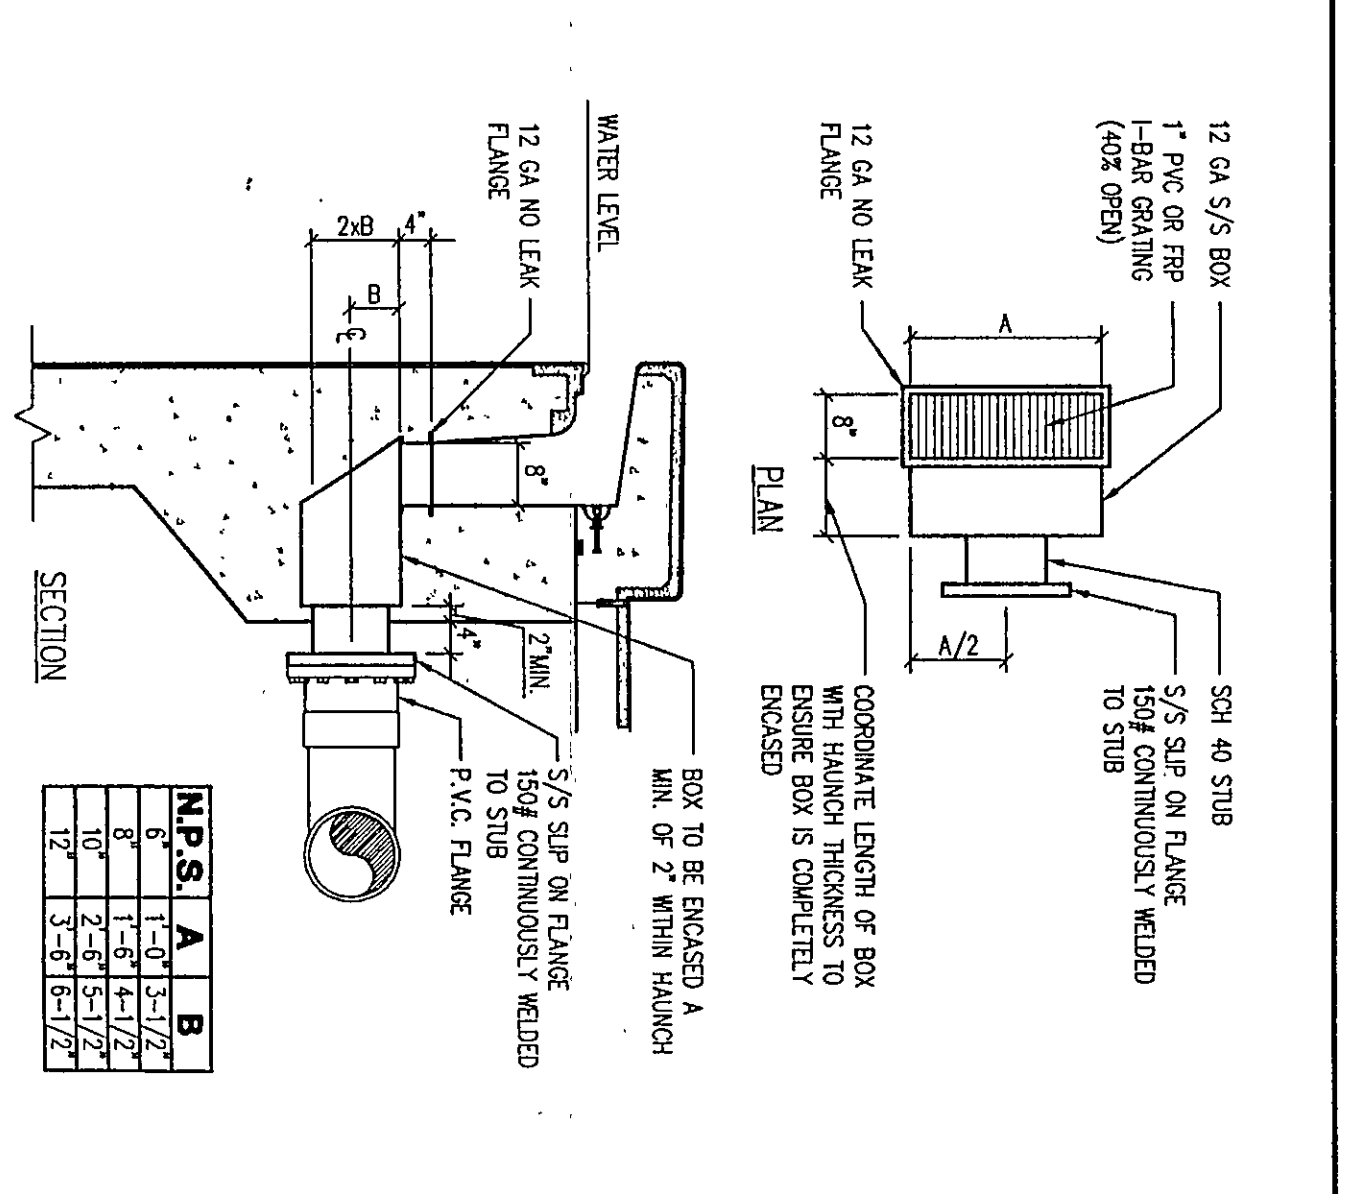


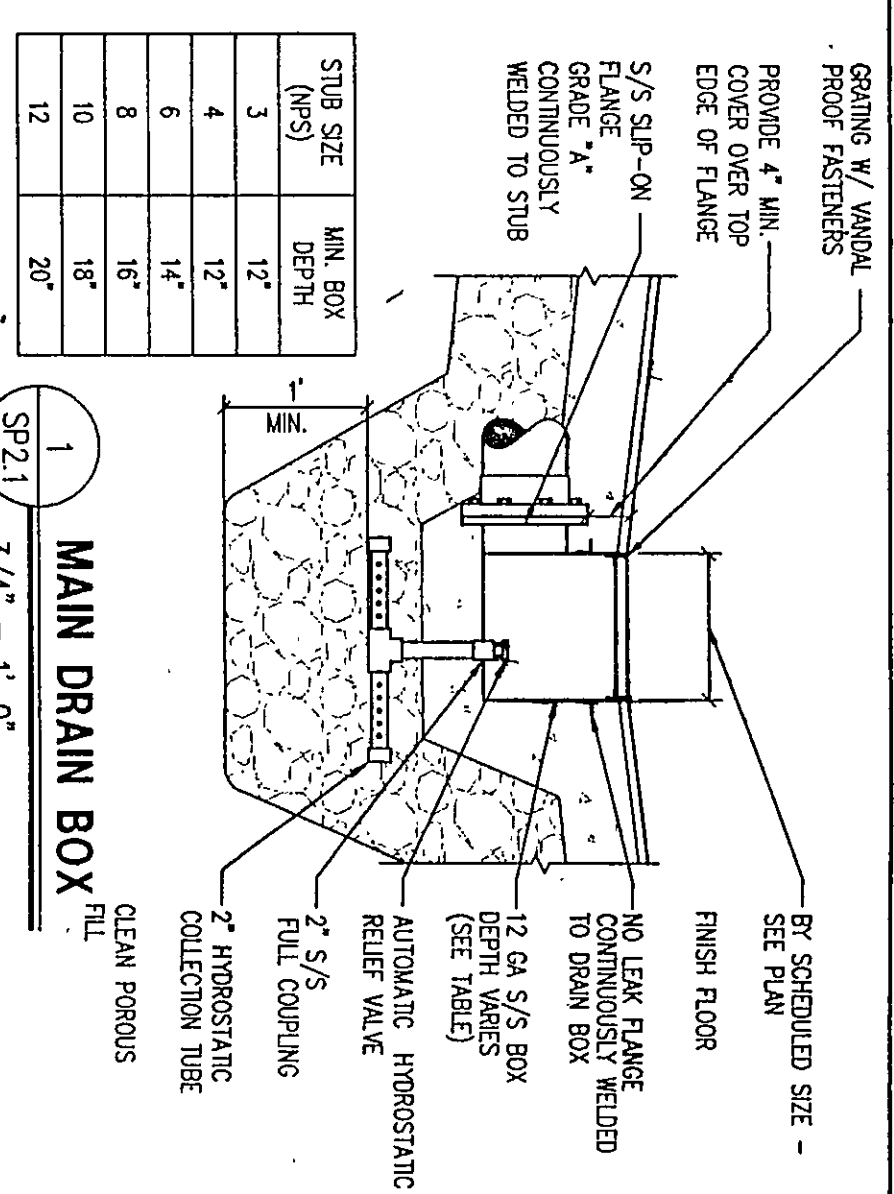

COPYRIGHT 1996 BY FANNING/HOWEY ASSOCIATES, INC.

PROPOSED NEW
CHESTERTON HIGH SCHOOL
FOR THE
DUNELAND SCHOOL CORPORATION
CHESTERTON, INDIANA

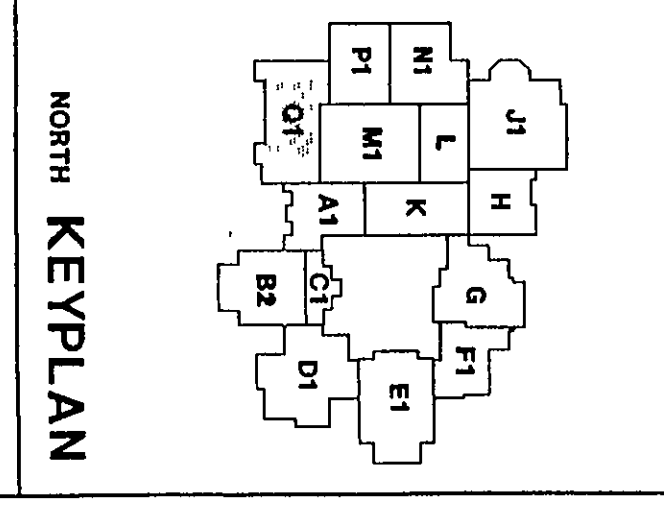

Fanning/Howey Associates Inc.
Architects Engineers Consultants

POOL MECHANICAL DETAILS

DRAWN BY: TBR COMM. NO.: 9506700
CHECKED BY: DATE: 4-14-97

SP2.1

REVISIONS NO. DATE