


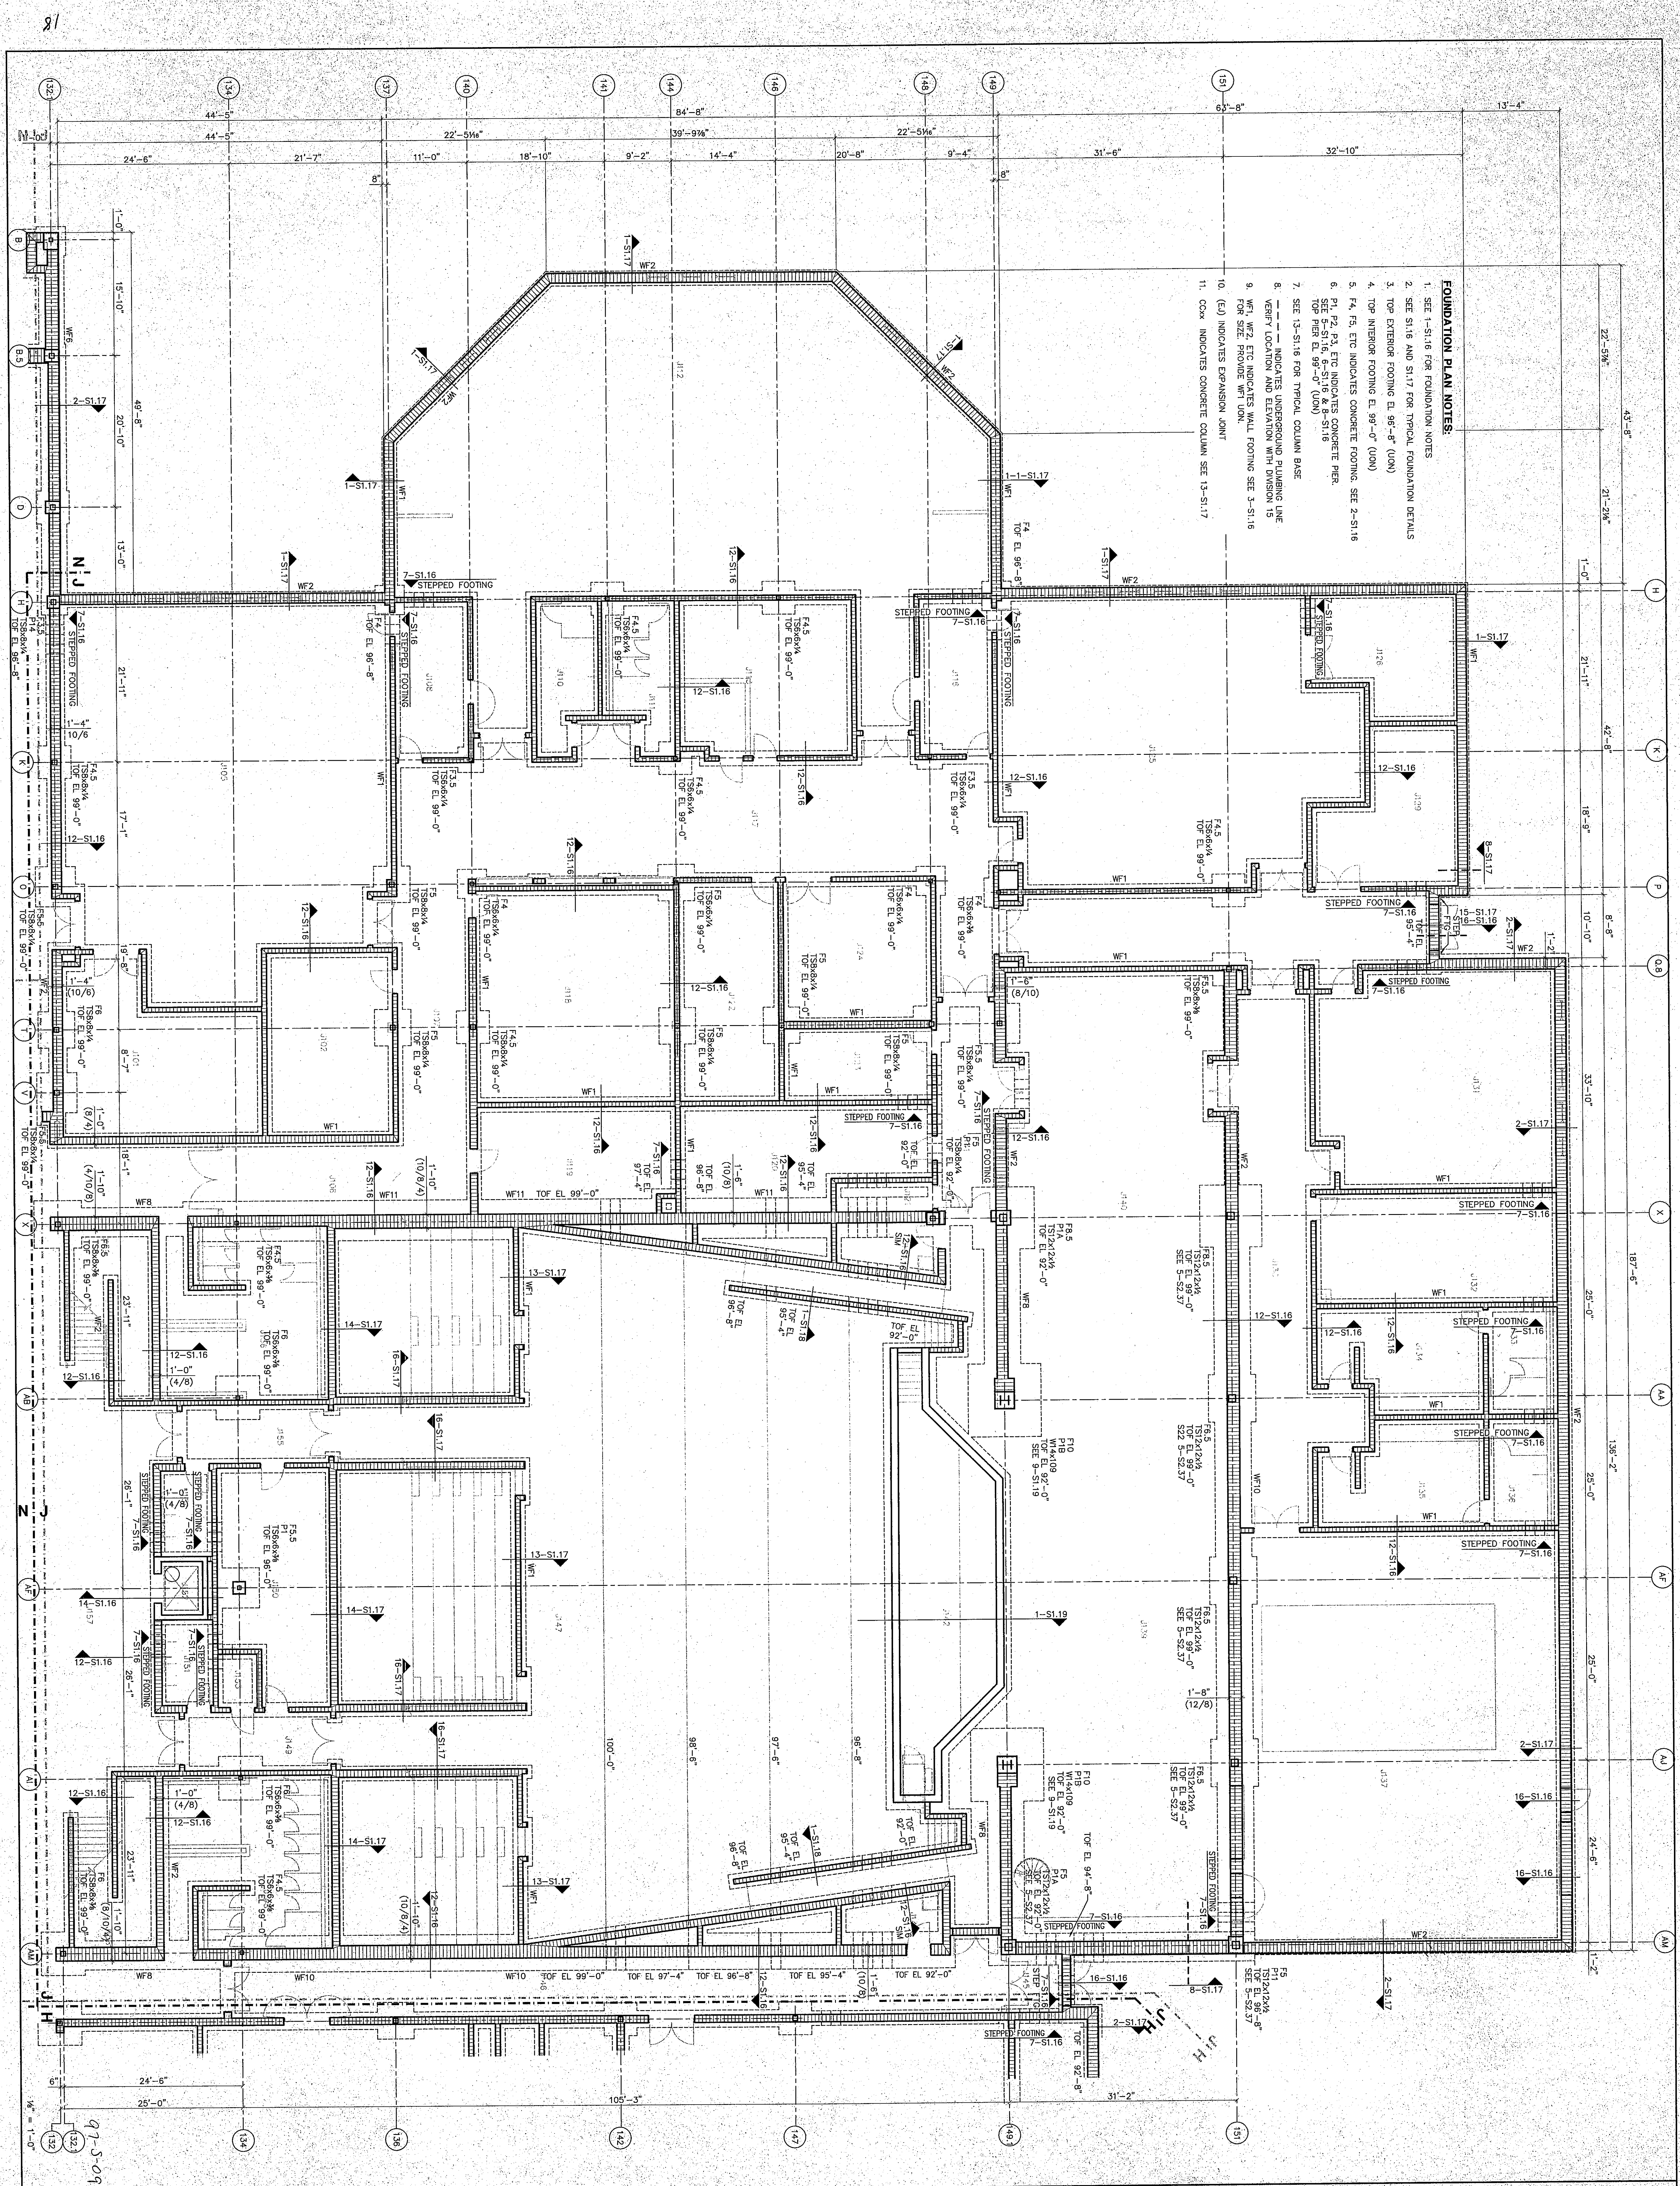

UNIT J FOUNDATION PLAN

DRAWN BY: B.A.M. COMM. NO.: 95067.00
CHECKED BY: D.D.F. DATE: APRIL 21, 1997

S1.9

REVISIONS NO. DATE

Fanning/Howey Associates, Inc.
Architects Engineers Consultants

KEY PLAN

THE NEW CHESTERTON HIGH SCHOOL FOR THE DUNELAND SCHOOL CORPORATION CHESTERTON, INDIANA

Copyright 1997 by Fanning/Howey Associates, Inc.