

SEE DWG. NO. 72703E14 FOR CONTINUATION

SEE DWG. NO. 72703E17 FOR CONTINUATION

SEE DWG. NO. 72703E16 FOR CONTINUATION



SEE DWG. NO. 72703E14 FOR CONT.

AUXILIARY PLAN UNIT H1

SCALE 1/8" = 1'-0"

AUXILIARY PLAN MEZZANINE H2

SCALE 1/8" = 1'-0"

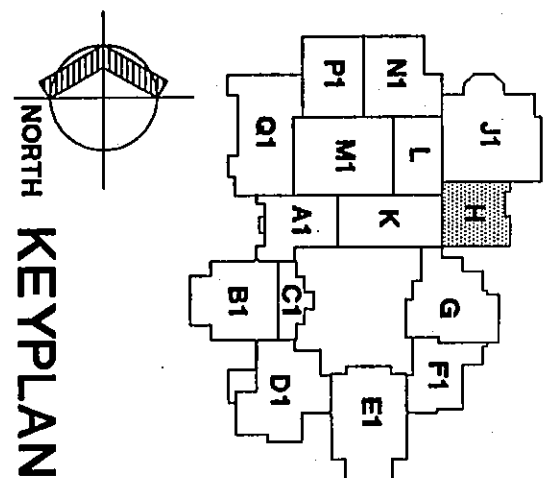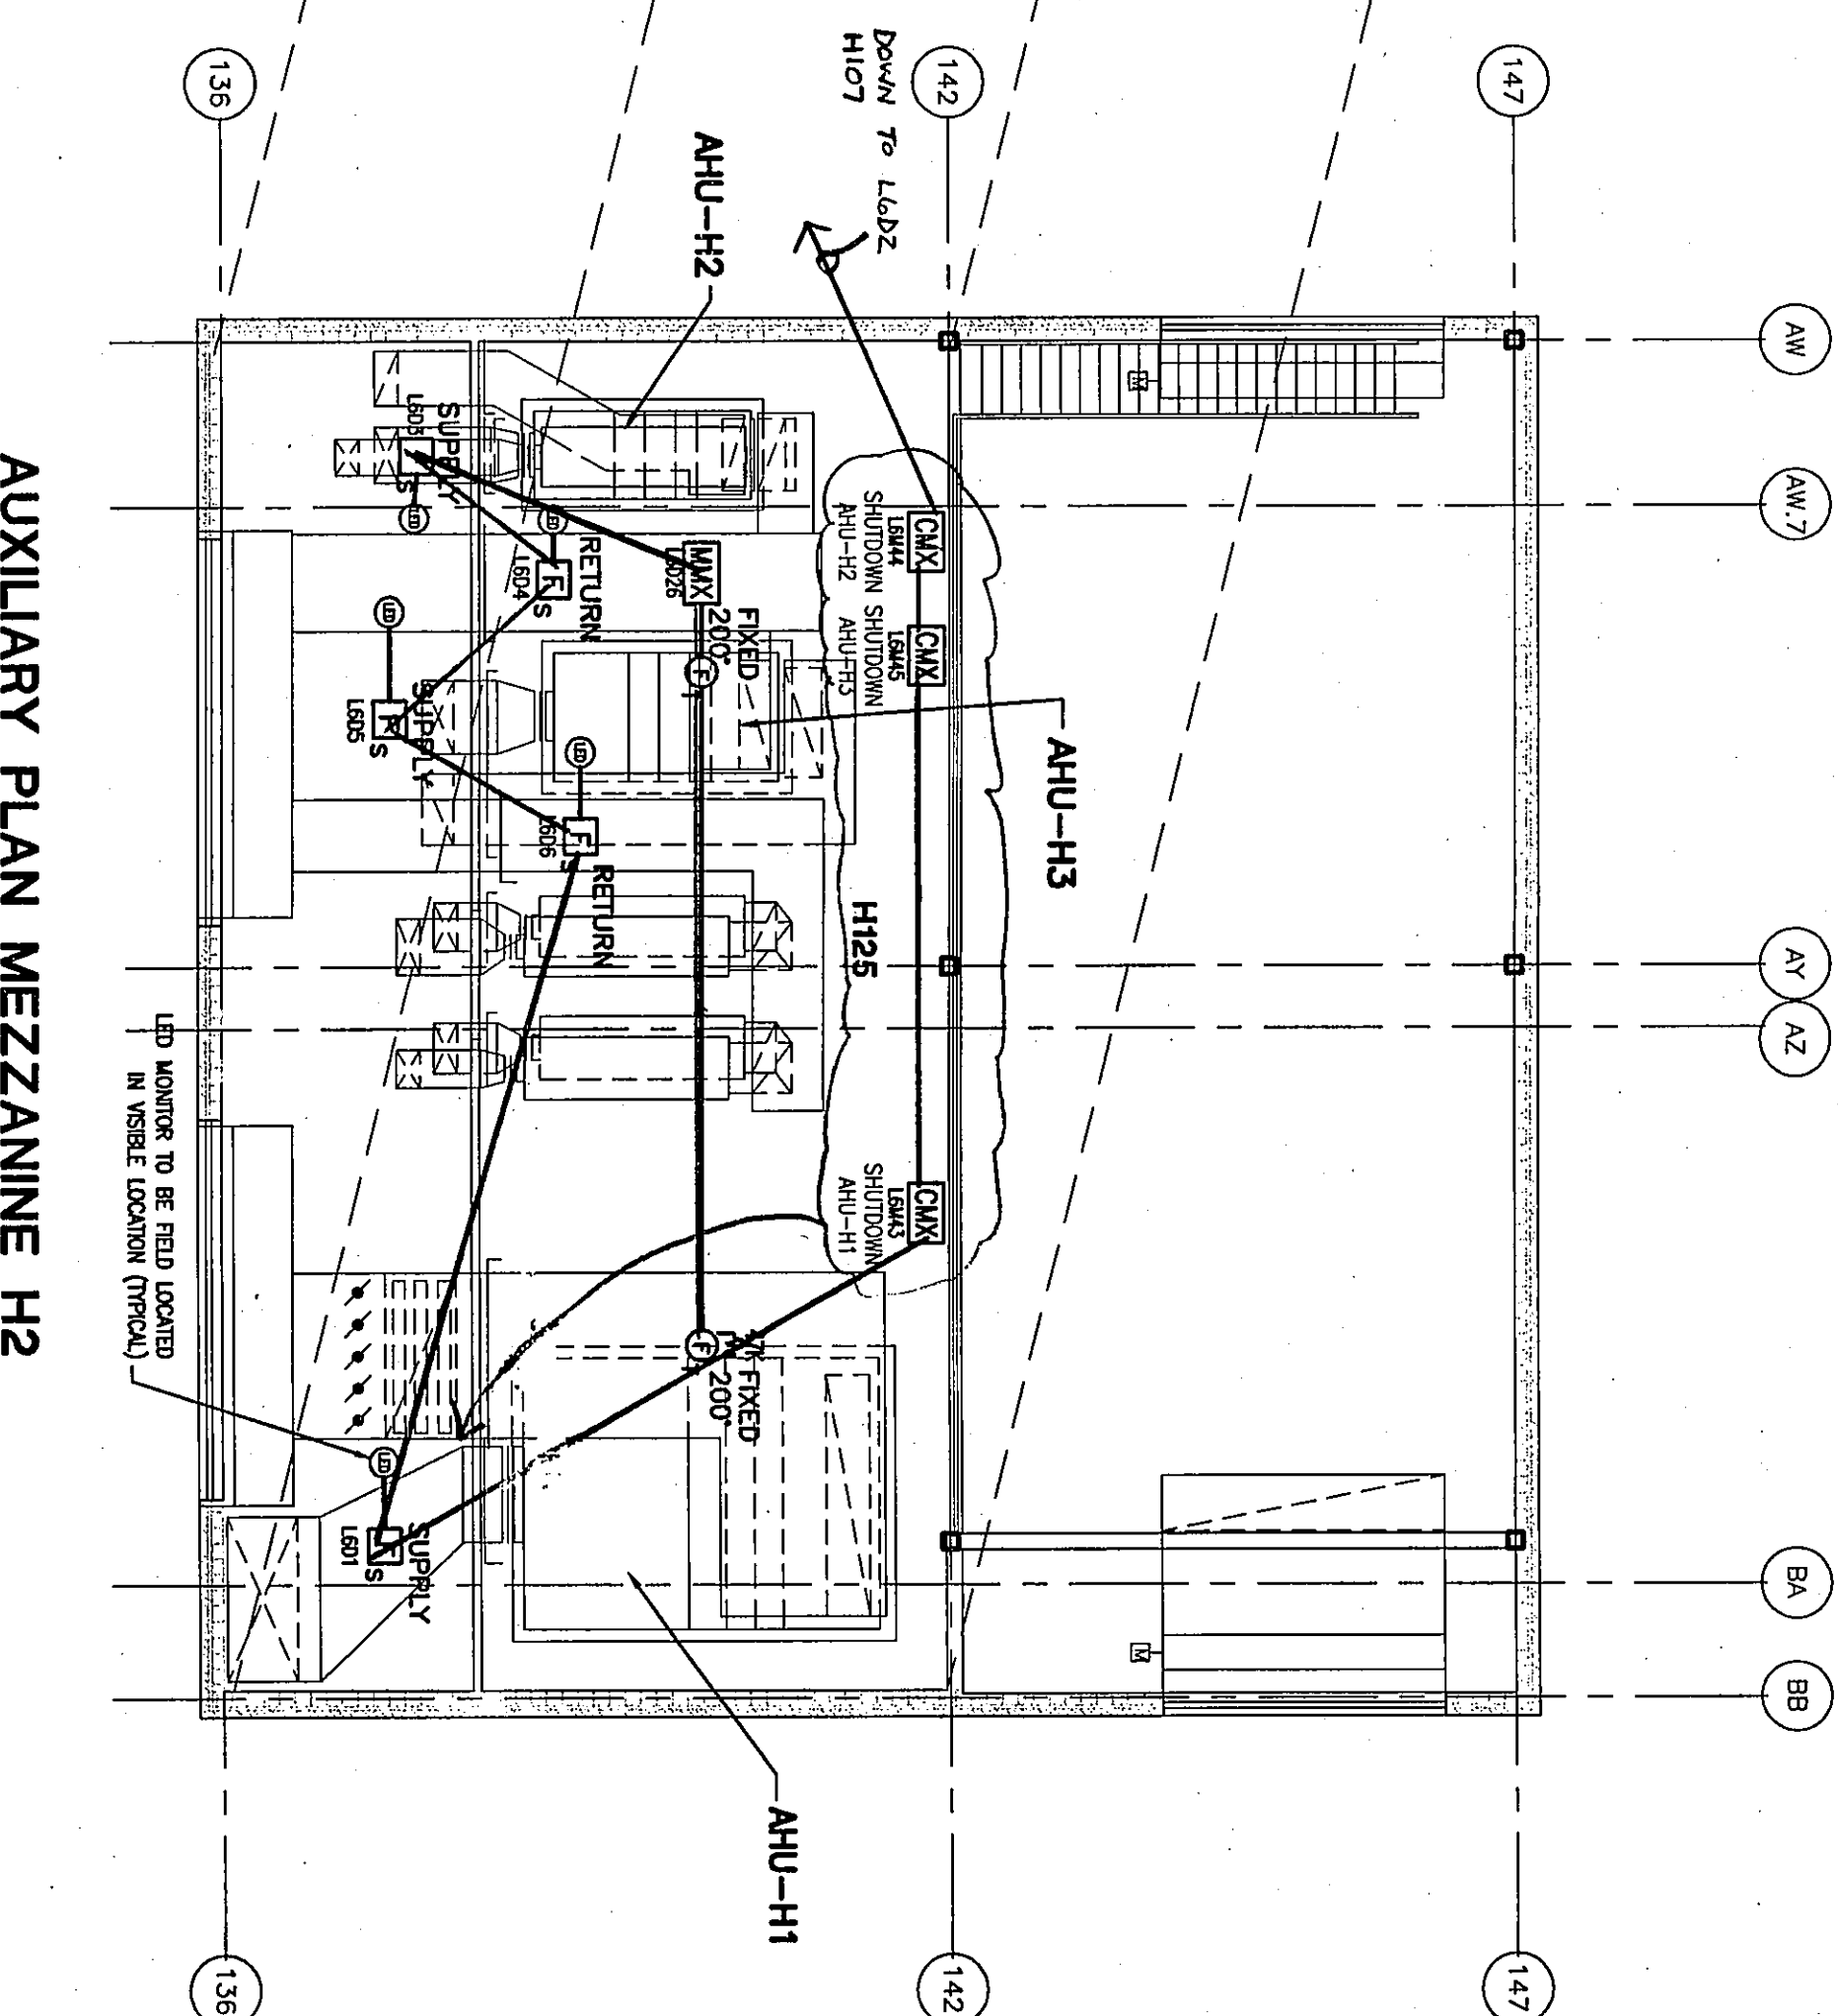

Dialer fed by
JHLX-29

PLAN NOTES

1. VERIFY EXACT LOCATION OF POST INDICATOR VALVE WITH DIVISION 15.
2. VERIFY EXACT LOCATION OF GAS VALVE WITH DIVISION 15.
3. REFER TO FIRE ALARM RISER DIAGRAM 6/E1.6 FOR FLOW SWITCH AND SUPERVISED VALVE INFORMATION.

ROOM LEGEND H1

ROOM NO.	ROOM NAME	AREA S.F.	CEILING HEIGHT
H101	CORRIDOR	2240	10'-0"
H102	WATERWORKS	600	9'-4"
H103	TOILET	42	9'-4"
H104	LOCKER/BREAK ROOM	42	9'-4"
H105	LOCKER/BREAK ROOM	42	9'-4"
H106	COOKING/PAVING	2232	9'-4"
H107	COOKING/PAVING	2232	9'-4"
H108	COOKING/PAVING	2232	9'-4"
H109	COOKING/PAVING	2232	9'-4"
H110	COOKING/PAVING	2232	9'-4"
H111	COOKING/PAVING	2232	9'-4"
H112	COOKING/PAVING	2232	9'-4"
H113	COOKING/PAVING	2232	9'-4"
H114	COOKING/PAVING	2232	9'-4"
H115	COOKING/PAVING	2232	9'-4"
H116	COOKING/PAVING	2232	9'-4"
H117	COOKING/PAVING	2232	9'-4"
H118	COOKING/PAVING	2232	9'-4"
H119	COOKING/PAVING	2232	9'-4"
H120	COOKING/PAVING	2232	9'-4"
H121	COOKING/PAVING	2232	9'-4"
H122	COOKING/PAVING	2232	9'-4"
H123	COOKING/PAVING	2232	9'-4"
H124	COOKING/PAVING	2232	9'-4"
H125	COOKING/PAVING	2232	9'-4"

LEGEND

- SYM DESCRIPTION
- [F] FIRE ALARM PANEL
- [A] FIRE ANNUNCIATOR
- [M] MANUAL PULL STATION
- [K] ALARM HORN/STROBE
- [K] ALARM HORN/STROBE WEATHERPROOF
- [K] ALARM STROBE
- [K] ALARM SPEAKER
- [Q] SMOKE DETECTOR
- [Q] HEAT DETECTOR
- [E] DUCT MOUNTED SMOKE DETECTOR
- [E] DUCT MOUNTED SMOKE DETECTOR WITH INTEGRAL RELAY
- [M] MONITORING LED
- [M] CONTROL MODULE
- [M] MONITOR MODULE
- [D] Junction Box

DWG. NO.	DESCRIPTION	DATE	BY	CHKD.	APP'D.
72703E17	FIRE ALARM WIRING RISER DIAGRAM	7/16/88	J. J. GOWINSIAK	K. A. LUNSTEDT	J. J. GOWINSIAK
72703E16	FIRE ALARM WIRING DETAILS & NOTES	7/16/88	J. J. GOWINSIAK	K. A. LUNSTEDT	J. J. GOWINSIAK
72703E15	FIRE ALARM WIRING DETAILS & NOTES	7/16/88	J. J. GOWINSIAK	K. A. LUNSTEDT	J. J. GOWINSIAK
72703E14	FIRE ALARM WIRING DETAILS & NOTES	7/16/88	J. J. GOWINSIAK	K. A. LUNSTEDT	J. J. GOWINSIAK
72703E13	FIRE ALARM WIRING DETAILS & NOTES	7/16/88	J. J. GOWINSIAK	K. A. LUNSTEDT	J. J. GOWINSIAK
72703E12	FIRE ALARM WIRING DETAILS & NOTES	7/16/88	J. J. GOWINSIAK	K. A. LUNSTEDT	J. J. GOWINSIAK
72703E11	FIRE ALARM WIRING DETAILS & NOTES	7/16/88	J. J. GOWINSIAK	K. A. LUNSTEDT	J. J. GOWINSIAK
72703E10	FIRE ALARM WIRING DETAILS & NOTES	7/16/88	J. J. GOWINSIAK	K. A. LUNSTEDT	J. J. GOWINSIAK
72703E09	FIRE ALARM WIRING DETAILS & NOTES	7/16/88	J. J. GOWINSIAK	K. A. LUNSTEDT	J. J. GOWINSIAK
72703E08	FIRE ALARM WIRING DETAILS & NOTES	7/16/88	J. J. GOWINSIAK	K. A. LUNSTEDT	J. J. GOWINSIAK
72703E07	FIRE ALARM WIRING DETAILS & NOTES	7/16/88	J. J. GOWINSIAK	K. A. LUNSTEDT	J. J. GOWINSIAK
72703E06	FIRE ALARM WIRING DETAILS & NOTES	7/16/88	J. J. GOWINSIAK	K. A. LUNSTEDT	J. J. GOWINSIAK
72703E05	FIRE ALARM WIRING DETAILS & NOTES	7/16/88	J. J. GOWINSIAK	K. A. LUNSTEDT	J. J. GOWINSIAK
72703E04	FIRE ALARM WIRING DETAILS & NOTES	7/16/88	J. J. GOWINSIAK	K. A. LUNSTEDT	J. J. GOWINSIAK
72703E03	FIRE ALARM WIRING DETAILS & NOTES	7/16/88	J. J. GOWINSIAK	K. A. LUNSTEDT	J. J. GOWINSIAK
72703E02	FIRE ALARM WIRING DETAILS & NOTES	7/16/88	J. J. GOWINSIAK	K. A. LUNSTEDT	J. J. GOWINSIAK
72703E01	FIRE ALARM WIRING DETAILS & NOTES	7/16/88	J. J. GOWINSIAK	K. A. LUNSTEDT	J. J. GOWINSIAK

DWG. NO.	DESCRIPTION	DATE	BY	CHKD.	APP'D.
72703E17	FIRE ALARM WIRING RISER DIAGRAM	7/16/88	J. J. GOWINSIAK	K. A. LUNSTEDT	J. J. GOWINSIAK
72703E16	FIRE ALARM WIRING DETAILS & NOTES	7/16/88	J. J. GOWINSIAK	K. A. LUNSTEDT	J. J. GOWINSIAK
72703E15	FIRE ALARM WIRING DETAILS & NOTES	7/16/88	J. J. GOWINSIAK	K. A. LUNSTEDT	J. J. GOWINSIAK
72703E14	FIRE ALARM WIRING DETAILS & NOTES	7/16/88	J. J. GOWINSIAK	K. A. LUNSTEDT	J. J. GOWINSIAK
72703E13	FIRE ALARM WIRING DETAILS & NOTES	7/16/88	J. J. GOWINSIAK	K. A. LUNSTEDT	J. J. GOWINSIAK
72703E12	FIRE ALARM WIRING DETAILS & NOTES	7/16/88	J. J. GOWINSIAK	K. A. LUNSTEDT	J. J. GOWINSIAK
72703E11	FIRE ALARM WIRING DETAILS & NOTES	7/16/88	J. J. GOWINSIAK	K. A. LUNSTEDT	J. J. GOWINSIAK
72703E10	FIRE ALARM WIRING DETAILS & NOTES	7/16/88	J. J. GOWINSIAK	K. A. LUNSTEDT	J. J. GOWINSIAK
72703E09	FIRE ALARM WIRING DETAILS & NOTES	7/16/88	J. J. GOWINSIAK	K. A. LUNSTEDT	J. J. GOWINSIAK
72703E08	FIRE ALARM WIRING DETAILS & NOTES	7/16/88	J. J. GOWINSIAK	K. A. LUNSTEDT	J. J. GOWINSIAK
72703E07	FIRE ALARM WIRING DETAILS & NOTES	7/16/88	J. J. GOWINSIAK	K. A. LUNSTEDT	J. J. GOWINSIAK
72703E06	FIRE ALARM WIRING DETAILS & NOTES	7/16/88	J. J. GOWINSIAK	K. A. LUNSTEDT	J. J. GOWINSIAK
72703E05	FIRE ALARM WIRING DETAILS & NOTES	7/16/88	J. J. GOWINSIAK	K. A. LUNSTEDT	J. J. GOWINSIAK
72703E04	FIRE ALARM WIRING DETAILS & NOTES	7/16/88	J. J. GOWINSIAK	K. A. LUNSTEDT	J. J. GOWINSIAK
72703E03	FIRE ALARM WIRING DETAILS & NOTES	7/16/88	J. J. GOWINSIAK	K. A. LUNSTEDT	J. J. GOWINSIAK
72703E02	FIRE ALARM WIRING DETAILS & NOTES	7/16/88	J. J. GOWINSIAK	K. A. LUNSTEDT	J. J. GOWINSIAK
72703E01	FIRE ALARM WIRING DETAILS & NOTES	7/16/88	J. J. GOWINSIAK	K. A. LUNSTEDT	J. J. GOWINSIAK