

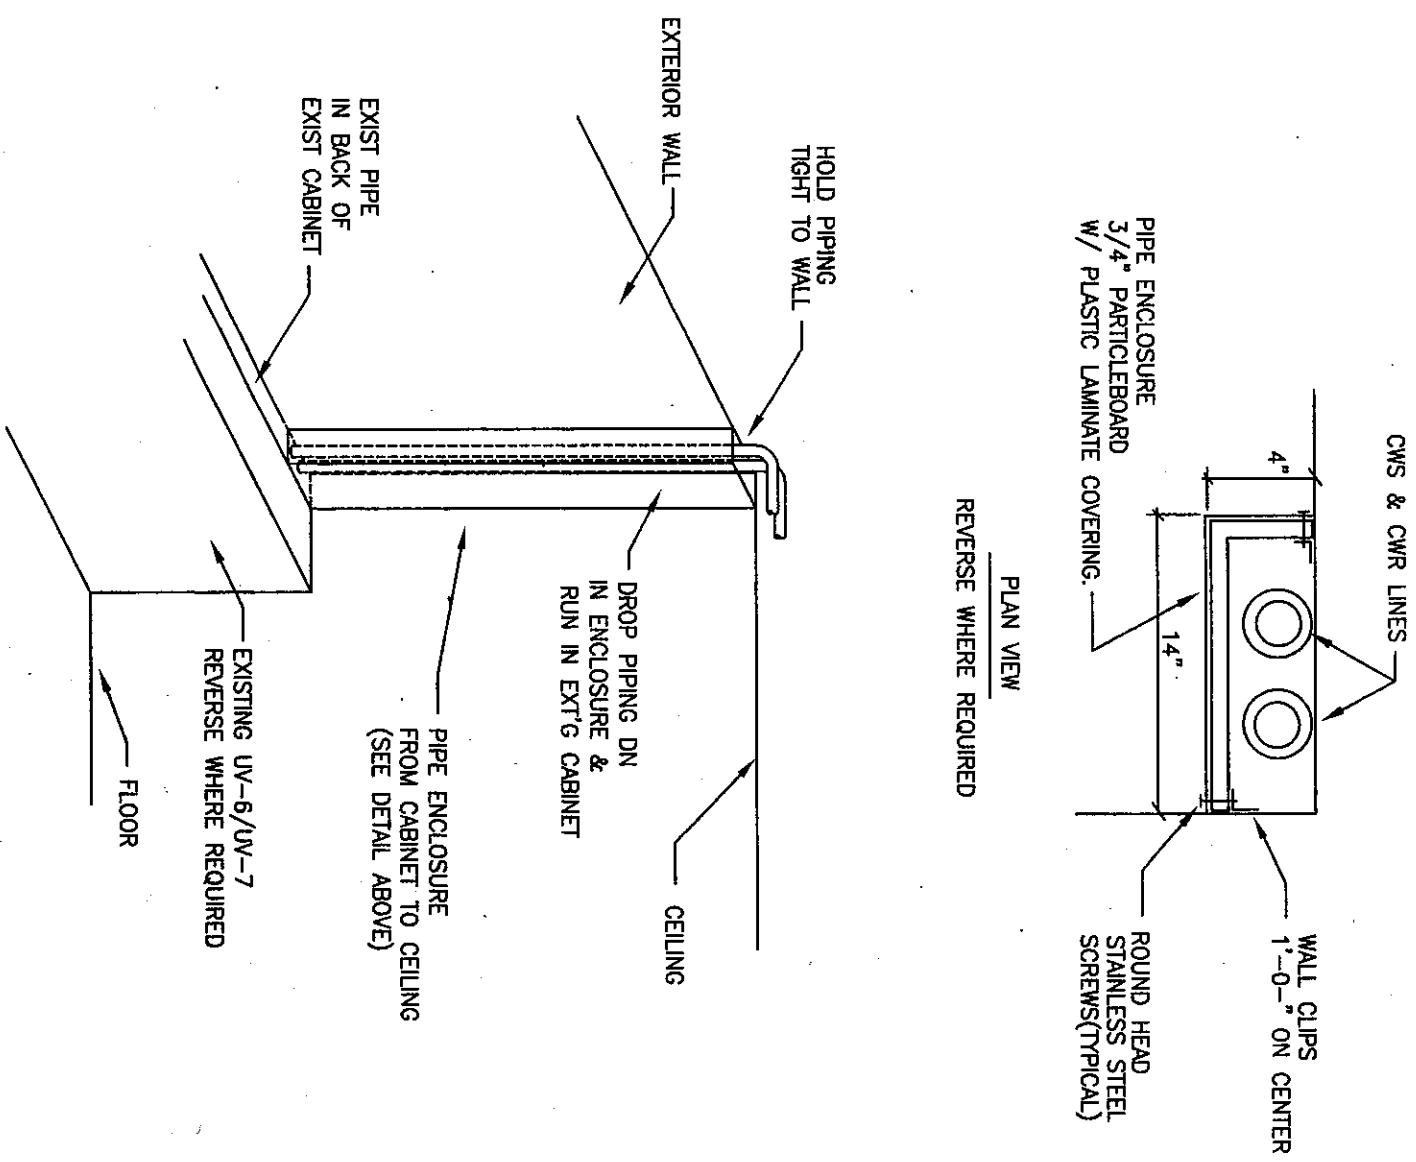
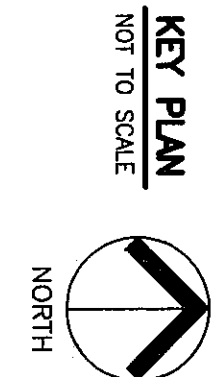
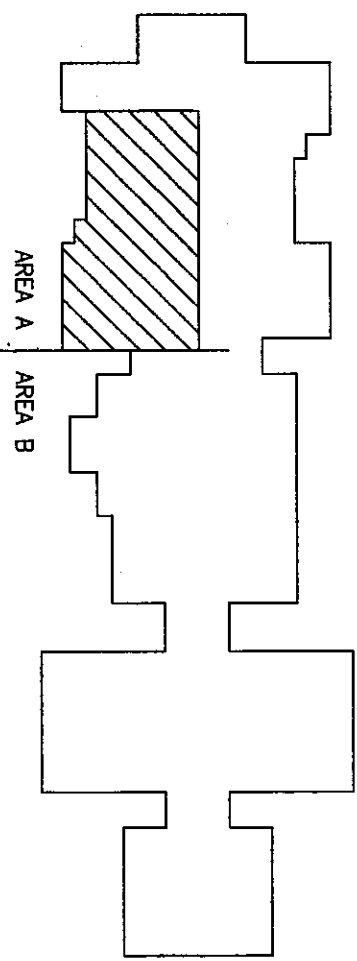



PIPE ENCLOSURE DETAIL
NOT TO SCALE

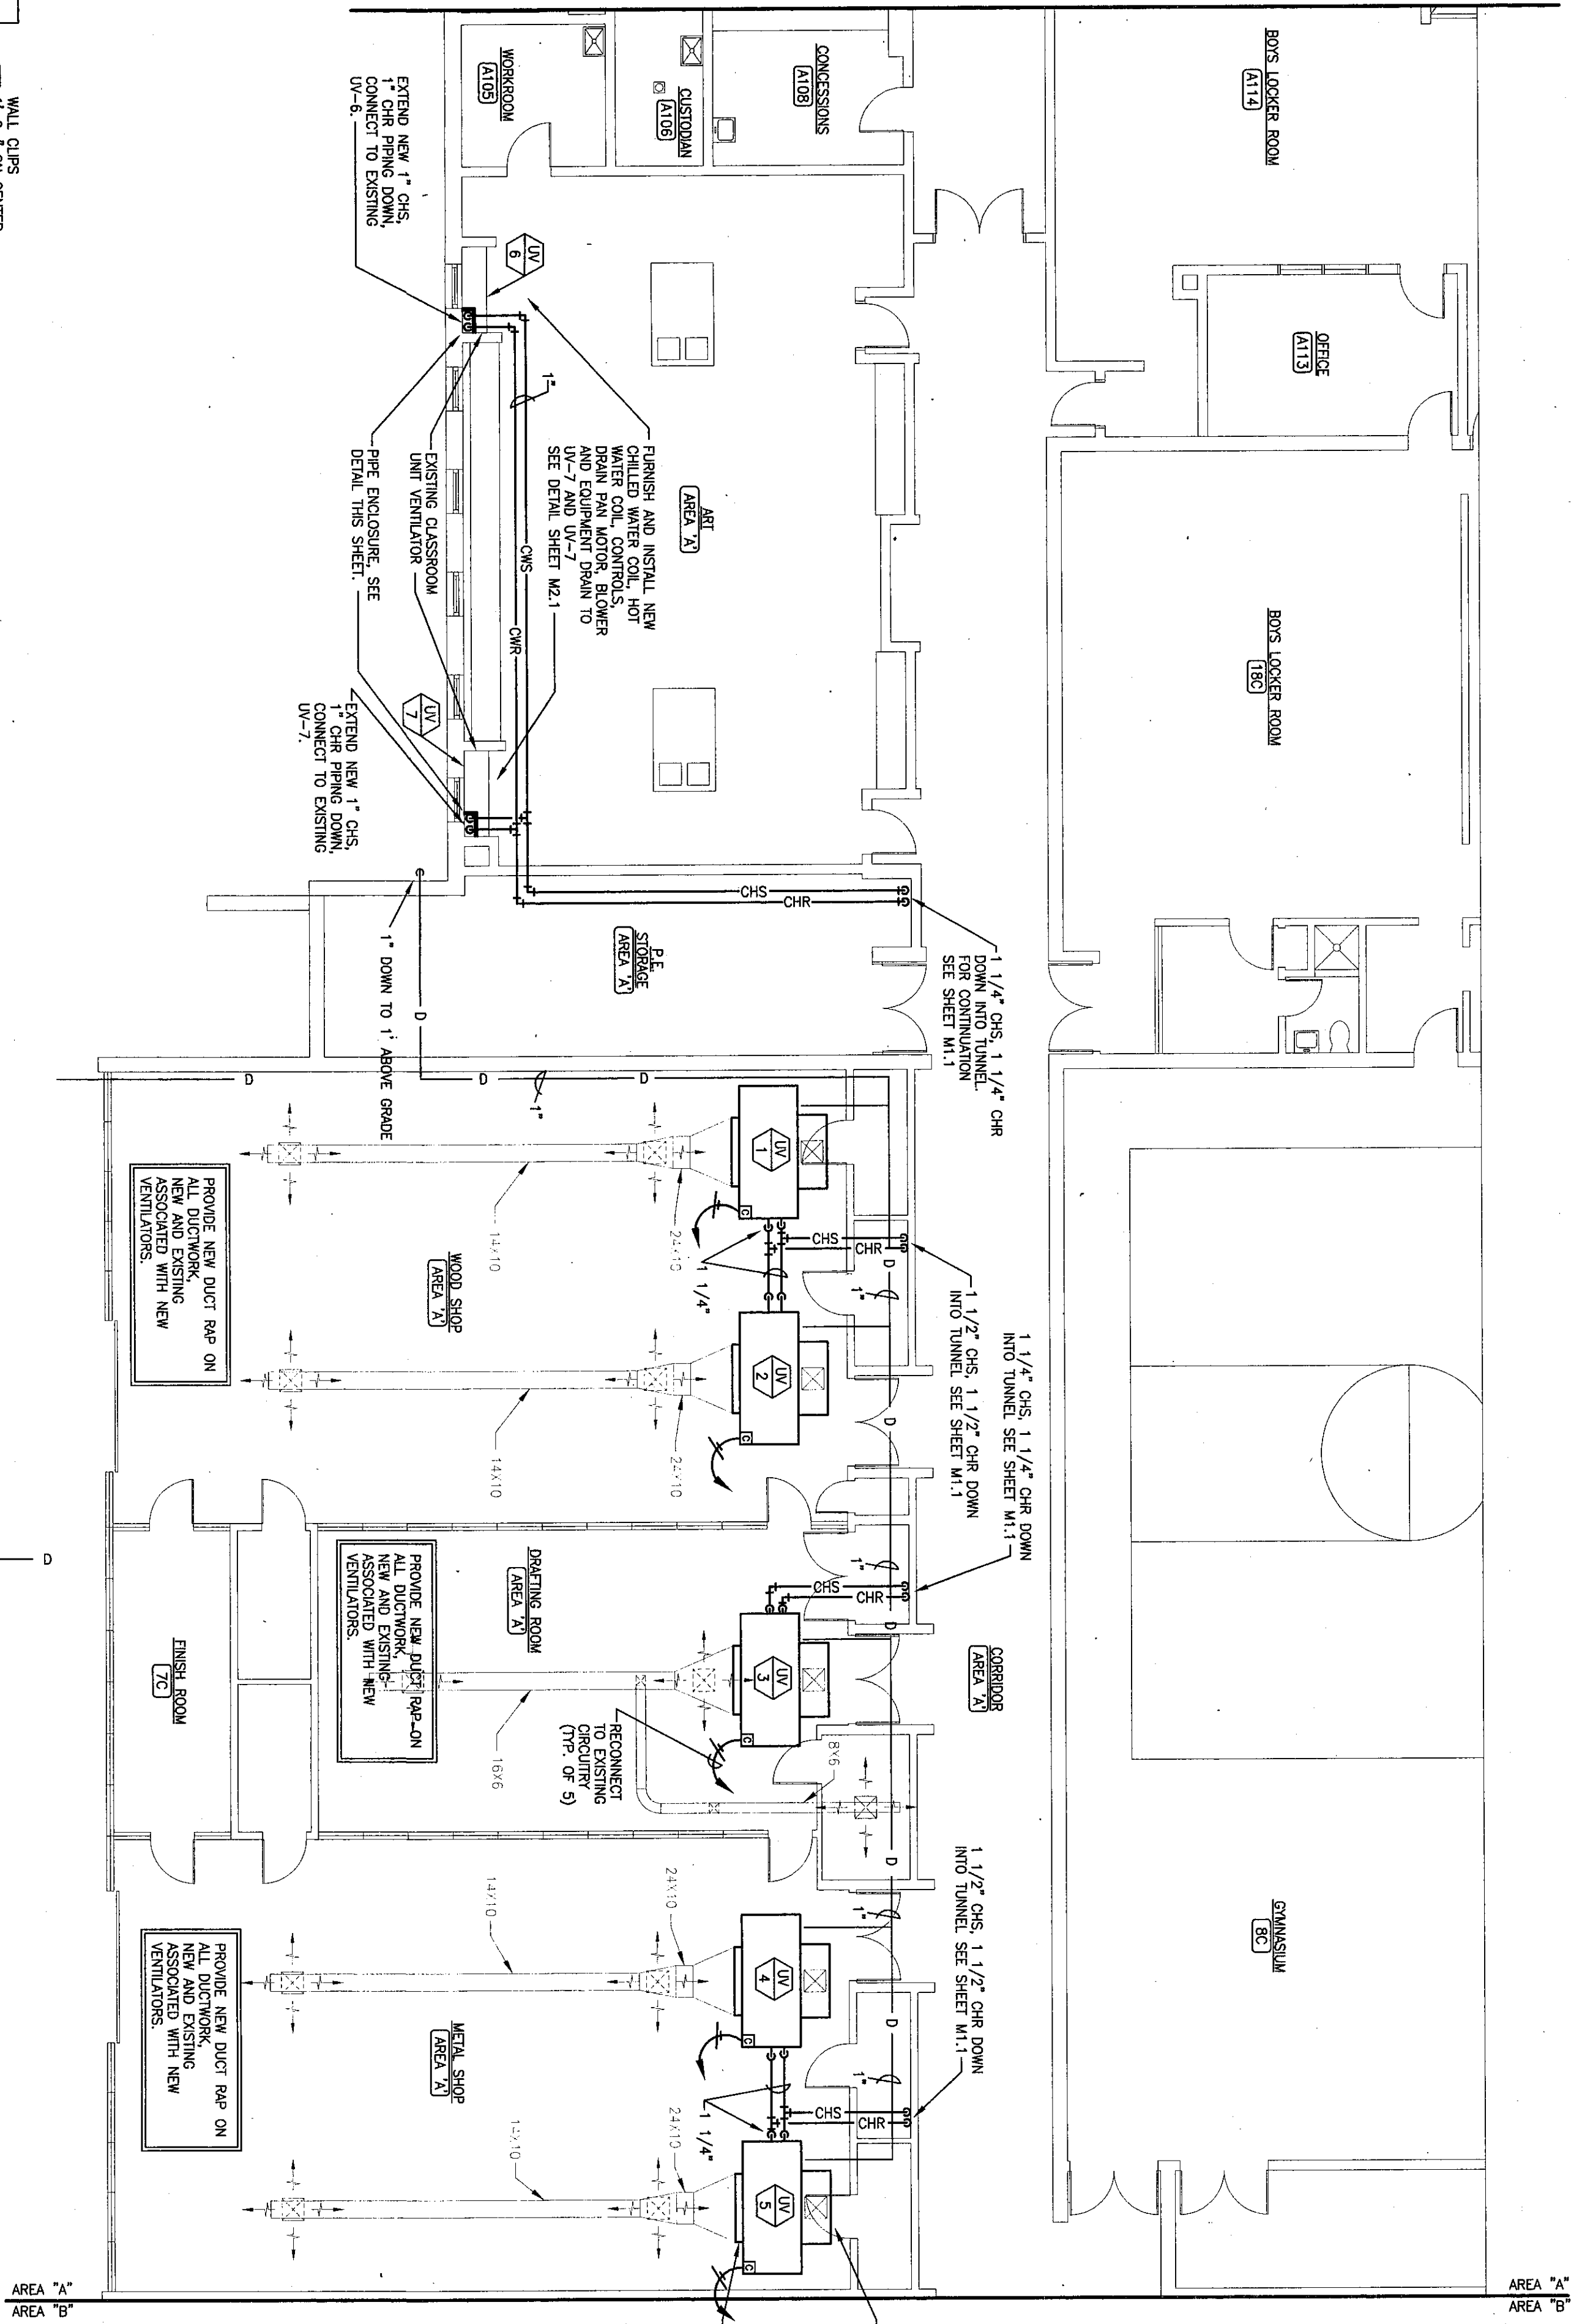

FIRST FLOOR PLAN - AREA 'A'
SCALE: 1/8" = 1'-0"
(ALTERNATE 1)

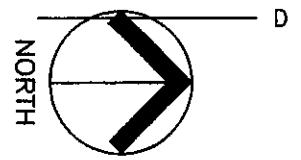

M/E DESIGN SERVICES
1200 South Fifth Street
Chesterton, IN 46412
(219) 258-1814
REG. NO. 2393

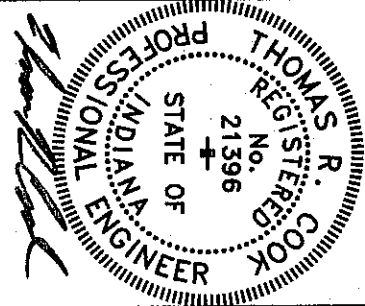

REVISIONS	BY