



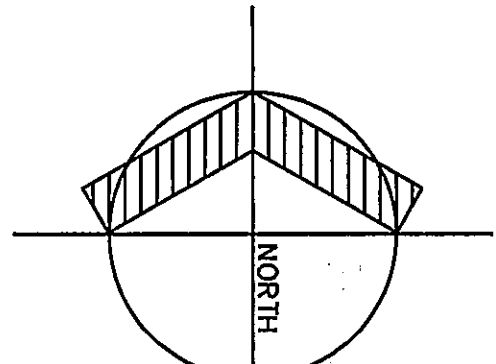

TECHNOLOGY PLAN UNIT A2

SCALE 1/8" = 1'-0"

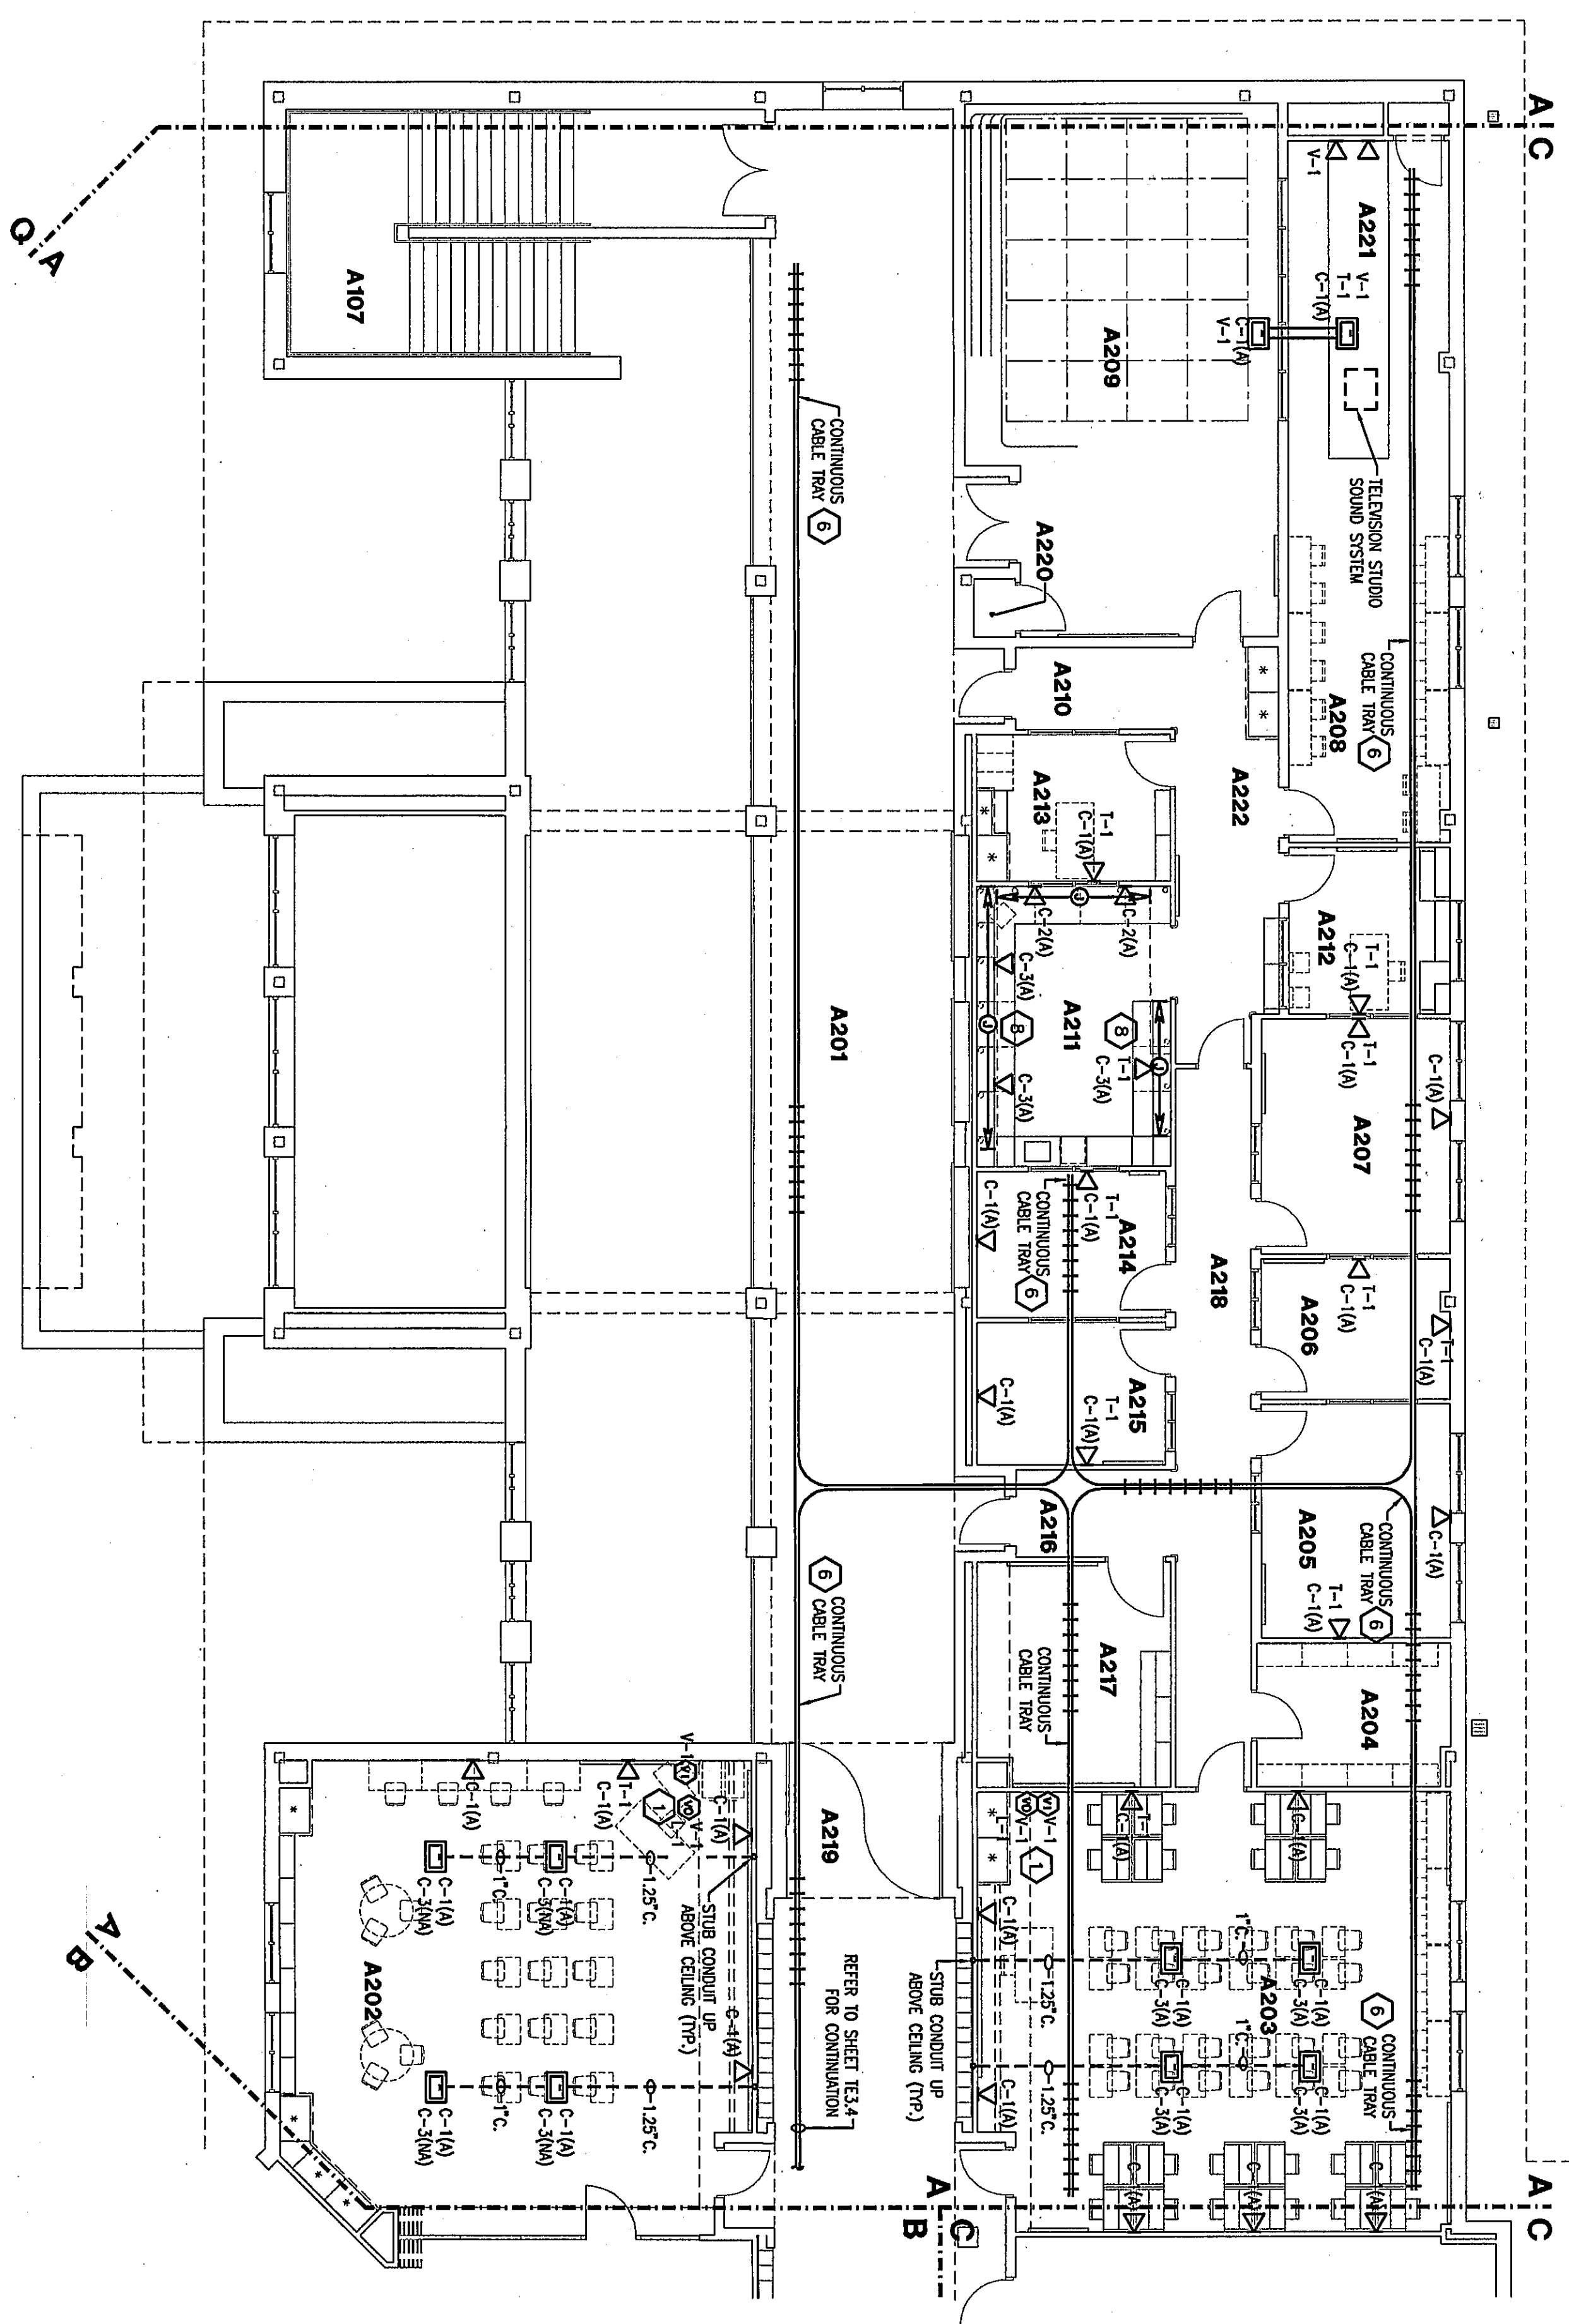

ROOM LEGEND "A2"


ROOM NO.	ROOM NAME	AREA S.F.	CEILING HEIGHT
A201	CORRIDOR	1552	WARS
A202	CLASSROOM	3600	WARS
A203	LABORATORY	1800	WARS
A204	LIBRARY	1201	9'-6"
A205	FM STUDIO	201	9'-6"
A206	STUDIO	201	9'-6"
A207	CONTROL ROOM	201	9'-6"
A208	CONTROL ROOM	510	9'-6"
A209	ON STUDIO	510	9'-6"
A210	ON STUDIO	240	9'-6"
A211	STUDY AREA	121	9'-6"
A212	OFFICE	121	9'-6"
A213	OFFICE	121	9'-6"
A214	STUDIO	124	9'-6"
A215	STUDIO	135	9'-6"
A216	STUDIO	131	9'-6"
A217	STORAGE	191	9'-6"
A218	CORRIDOR	239	9'-6"
A219	CORRIDOR	239	9'-6"
A220	ELECTRICAL CLOSET	11	10'-0"
A221	ELECTRICAL CLOSET	9	10'-0"
A222	ELECTRICAL CLOSET	183	9'-6"
	CORRIDOR	9	9'-6"

GENERAL PLAN NOTES:

- A. RACEMY, JUNCTION BOXES, CABLE TAPS ARE PROVIDED UNDER EXISTING BUILDING ELECTRICAL CONTRACTOR UNLESS OTHERWISE NOTED, VERIFY LOCATION IN FIELD.
- B. PROVIDE A BLANK COVER PLATE FOR ALL UNUSED JUNCTION BOXES.
- C. PROVIDE A BLANK INSERT FOR ALL UNUSED OPENINGS IN THE DATA/VOICE PLATES.


PLAN NOTES:

- 1 SEE DETAIL 1.5 ON SHEET 1.1 FOR INFORMATION ON DRIVING BETWEEN 1A, (V) LOCATION & TECHNIQUE (V) OR 1/1C LOCATION
- 2 PROVIDE 1" DECK SKIRT, AT EACH CORNER, SECURE PER HANDBOOKER'S RECOMMENDATIONS.
- 3 LOCATION OF (X) JETTED SPRINGING ROUGHNESS, (1) = 100% SPRINGING, (2) = 50% SPRINGING, (3) = 25% SPRINGING, (4) = 10% SPRINGING, (5) = 5% SPRINGING, (6) = NO SPRINGING
- 4 LOCATION OF 1/1C EQUIPMENT.
- 5 PROVIDE SINGLE GATE ACCESS BOX FOR DATA DROPS.
- 6 DESIGNING 18" GATE TRAIL AS SHOWN.
- 7 PROVIDE NEW 24" GATE TRAIL TO CORRIDOR.
- 8 DESIGNING GROUND REMOVAL, PROVIDE COVER PLATES AS REQUIRED.

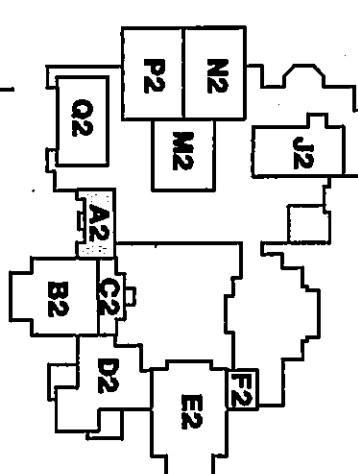

**THE NEW
CHESTERTON HIGH SCHOOL
TECHNOLOGY PACKAGE**
DUNELAND SCHOOL CORPORATION
CHESTERTON, INDIANA

COPYRIGHT 1999 BY FANNING/HOWEY ASSOCIATES, INC.

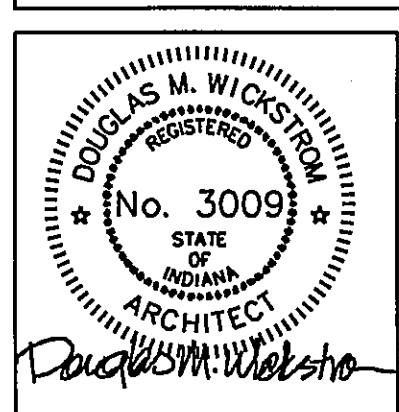

**Fanning/Howey
Associates, Inc.**
Architects Engineers Consultants

TECHNOLOGY PLAN UNIT A2

DRAWN BY:	JED	COMM. NO.:	95067.00
CHECKED BY:	RSB	DATE:	MAY 3, 1999

REVISIONS	NO.	DATE
-----------	-----	------

TE3.2

CHESTERTON HIGH SCHOOL
95067.00