


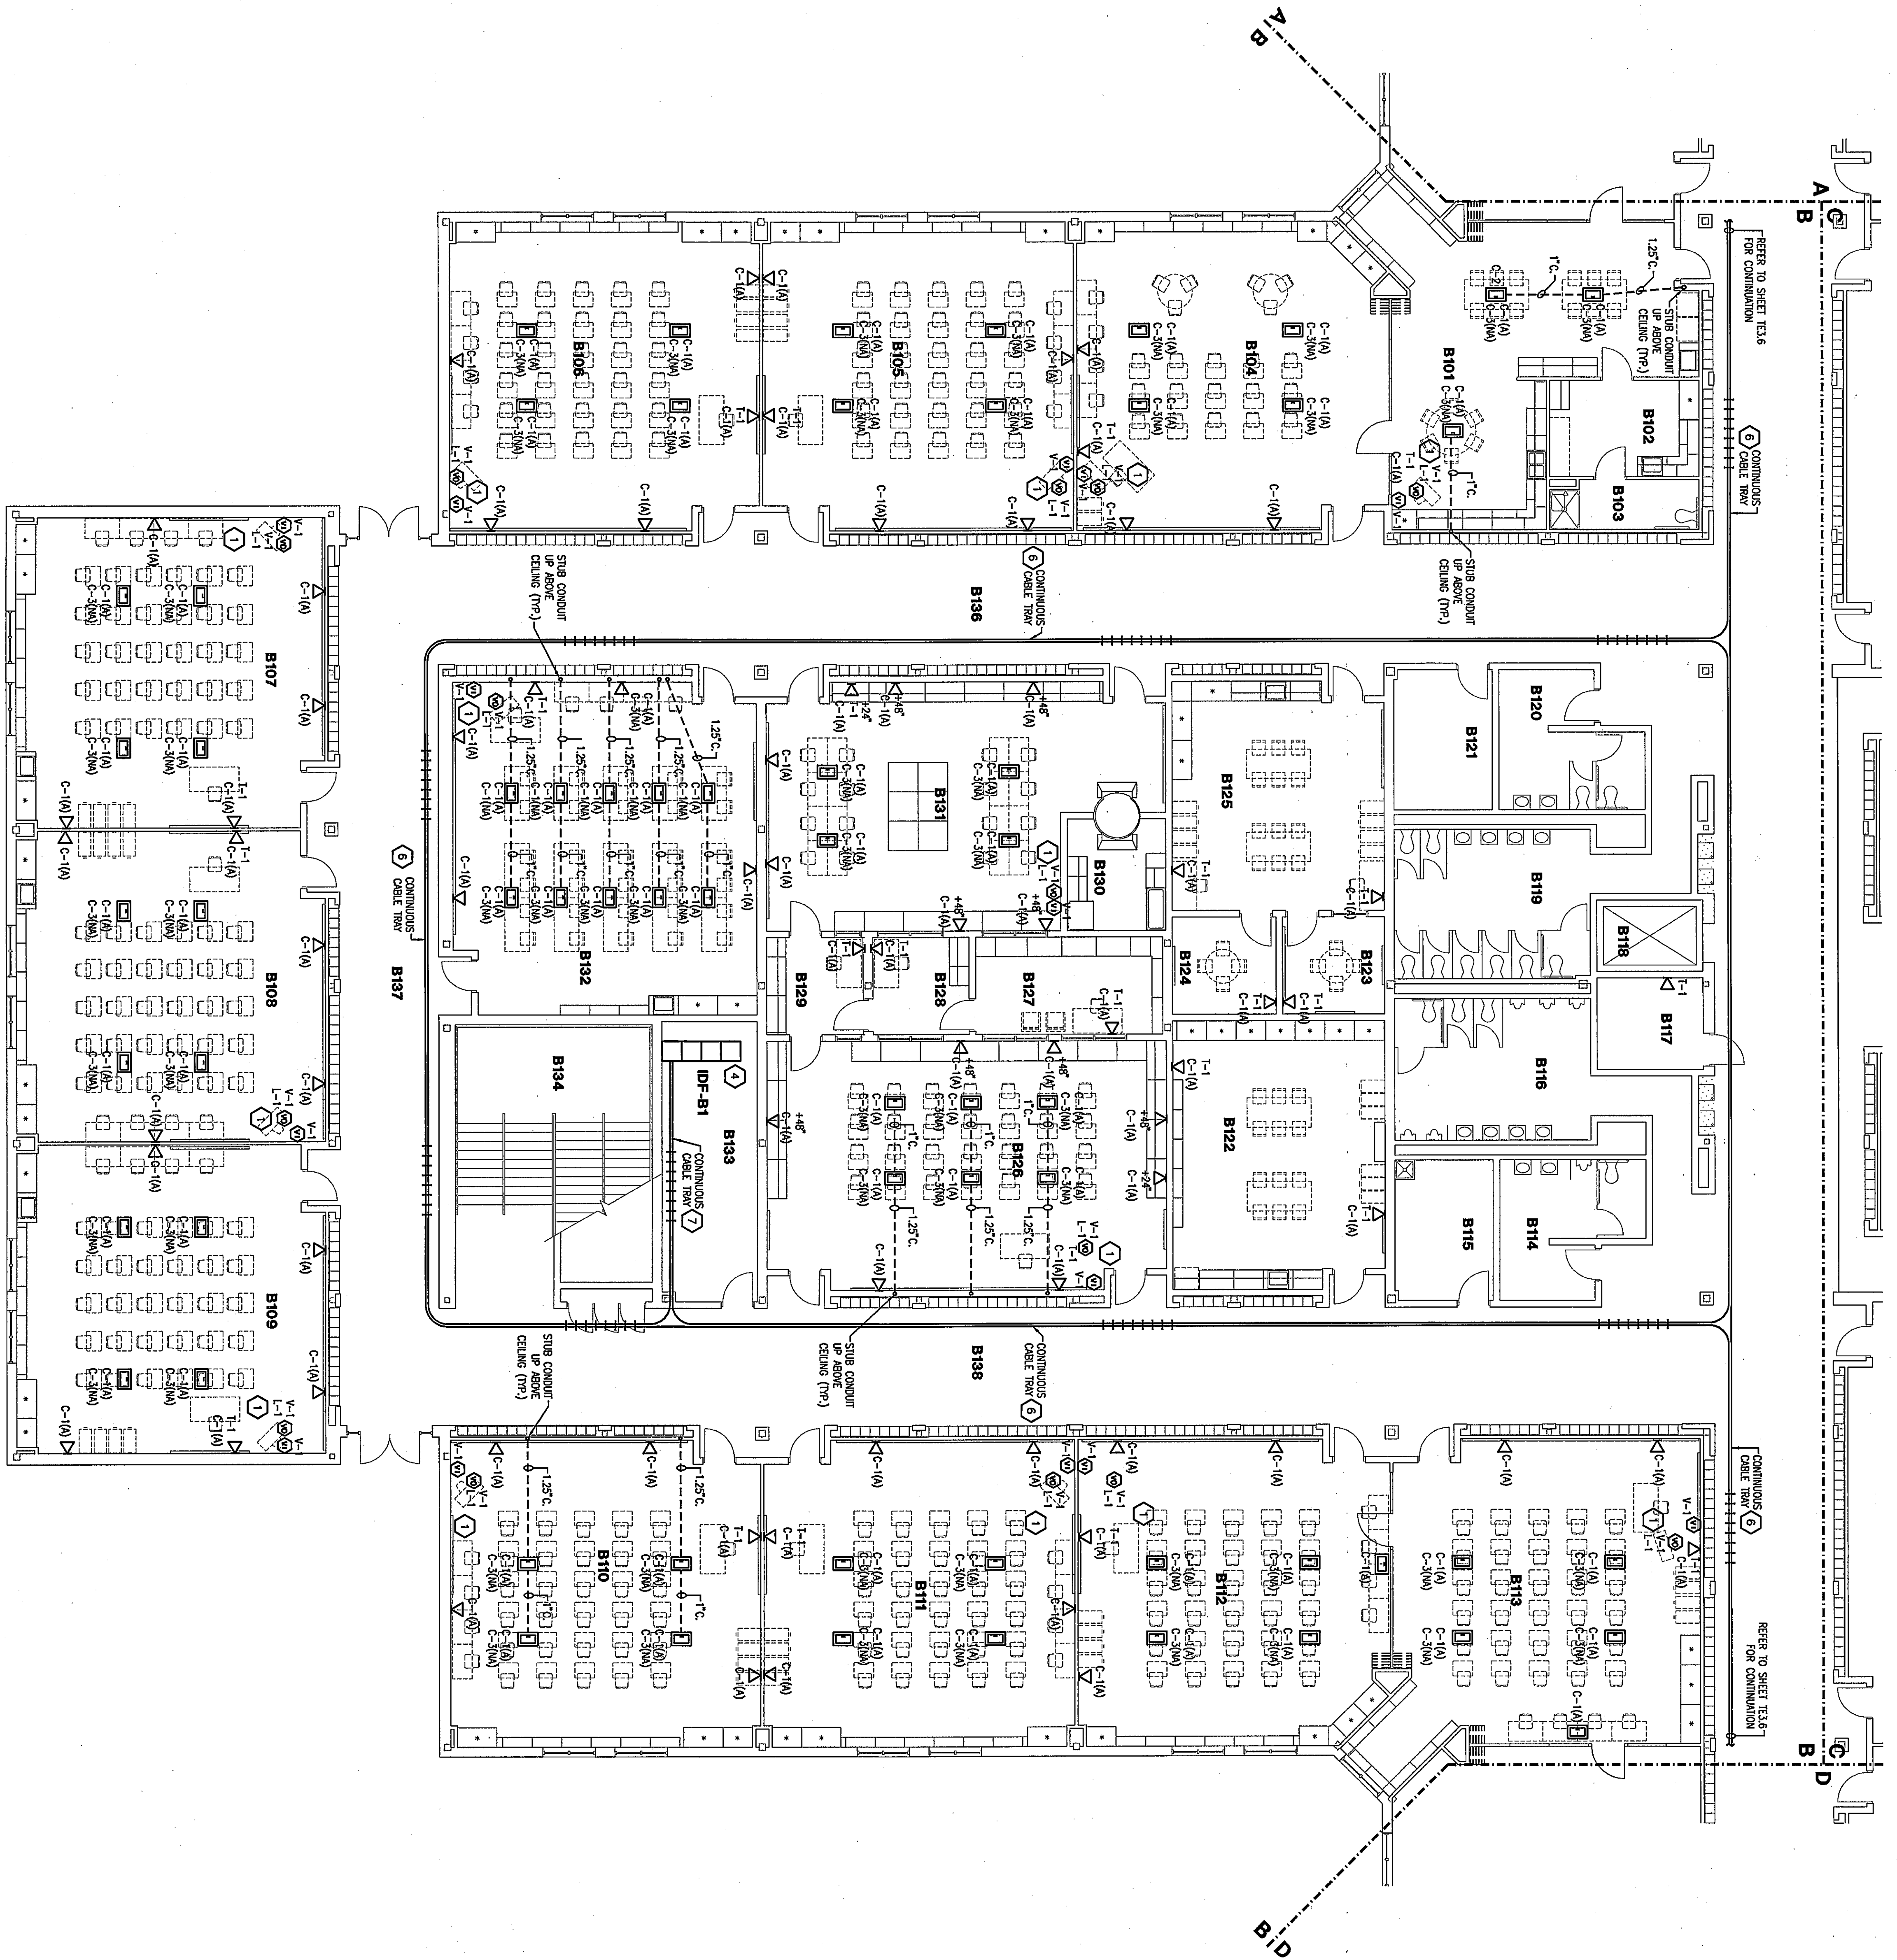

ROOM LEGEND "B1"


ROOM NO.	ROOM NAME	AREA S.F.	CEILING HEIGHT
B101	UPE SKILLS	753	9'-4"
B102	HEALTH MAINTENANCE	149	9'-4"
B103	TOILET	230	9'-4"
B104	CLASSROOM	972	9'-4"
B105	CLASSROOM	967	9'-4"
B106	CLASSROOM	967	9'-4"
B107	CLASSROOM	967	9'-4"
B108	CLASSROOM	967	9'-4"
B109	CLASSROOM	967	9'-4"
B110	CLASSROOM	967	9'-4"
B111	CLASSROOM	967	9'-4"
B112	CLASSROOM	967	9'-4"
B113	CLASSROOM	967	9'-4"
B114	CLASSROOM	967	9'-4"
B115	CLASSROOM	967	9'-4"
B116	CLASSROOM	967	9'-4"
B117	CLASSROOM	967	9'-4"
B118	CLASSROOM	967	9'-4"
B119	CLASSROOM	967	9'-4"
B120	CLASSROOM	967	9'-4"
B121	CLASSROOM	967	9'-4"
B122	CLASSROOM	967	9'-4"
B123	CLASSROOM	967	9'-4"
B124	CLASSROOM	967	9'-4"
B125	CLASSROOM	967	9'-4"
B126	CLASSROOM	967	9'-4"
B127	CLASSROOM	967	9'-4"
B128	CLASSROOM	967	9'-4"
B129	CLASSROOM	967	9'-4"
B130	CLASSROOM	967	9'-4"
B131	CLASSROOM	967	9'-4"
B132	CLASSROOM	967	9'-4"
B133	CLASSROOM	967	9'-4"
B134	CLASSROOM	967	9'-4"
B135	CLASSROOM	967	9'-4"
B136	CLASSROOM	967	9'-4"
B137	CLASSROOM	967	9'-4"
B138	CLASSROOM	967	9'-4"

GENERAL PLAN NOTES:

1. ROOMING JUNCTION BOXES, CABLE TRAYS, AND POWER UNITS ARE SHOWN IN FIELD.
2. PROVIDE A BLANK COVER PLATE FOR ALL UNUSED JUNCTION BOXES.
3. PROVIDE A BLANK INSERT FOR ALL UNUSED OPENINGS IN THE DATA/VOICE PLATES.

PLAN NOTES:

1. SET DATA TEL. ON SHEET T-1 FOR INFORMATION.
2. PROVIDE TV. TEST SIGNAL AT EACH CORNER, STORE PER MANUFACTURER'S REQUIREMENTS.
3. LOCATION OF (V)-VIDEO DISTRIBUTION EQUIPMENT, (T)-TELEPHONE SYSTEM, (D)-DATA BACKS & (S)-SOUND STRIKE (MAY).
4. PROVIDE SINGLE GANG RECESSED BOX FOR DATA DROPS.
5. EXISTING 16" CABLE TRAY AS SHOWN.
6. PROVIDE NEW 24" CABLE TRAY TO CORRIDOR.
7. EXISTING 4000 W/4000. PROVIDE COVER PLATES AS REQUIRED.

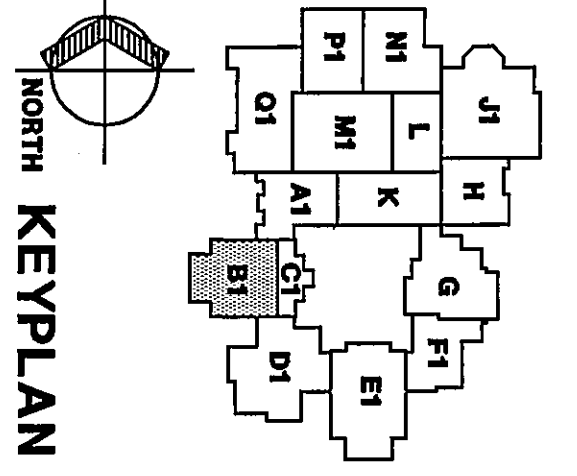

THE NEW
CHESTERTON HIGH SCHOOL
TECHNOLOGY PACKAGE
DUNELAND SCHOOL CORPORATION
CHESTERTON, INDIANA

COPYRIGHT 1999 BY FANNING/HOWEY ASSOCIATES, INC.

NO. 3009

ARCHITECT

TECHNOLOGY PLAN UNIT B1

Fanning/Howey Associates, Inc.
Architects Engineers Consultants

TECHNOLOGY PLAN UNIT B1

DRAWN BY: JED COMM. NO.: 95067.00
CHECKED BY: RSB DATE: MAY 3, 1999

TE3.3

REVISIONS NO. DATE