


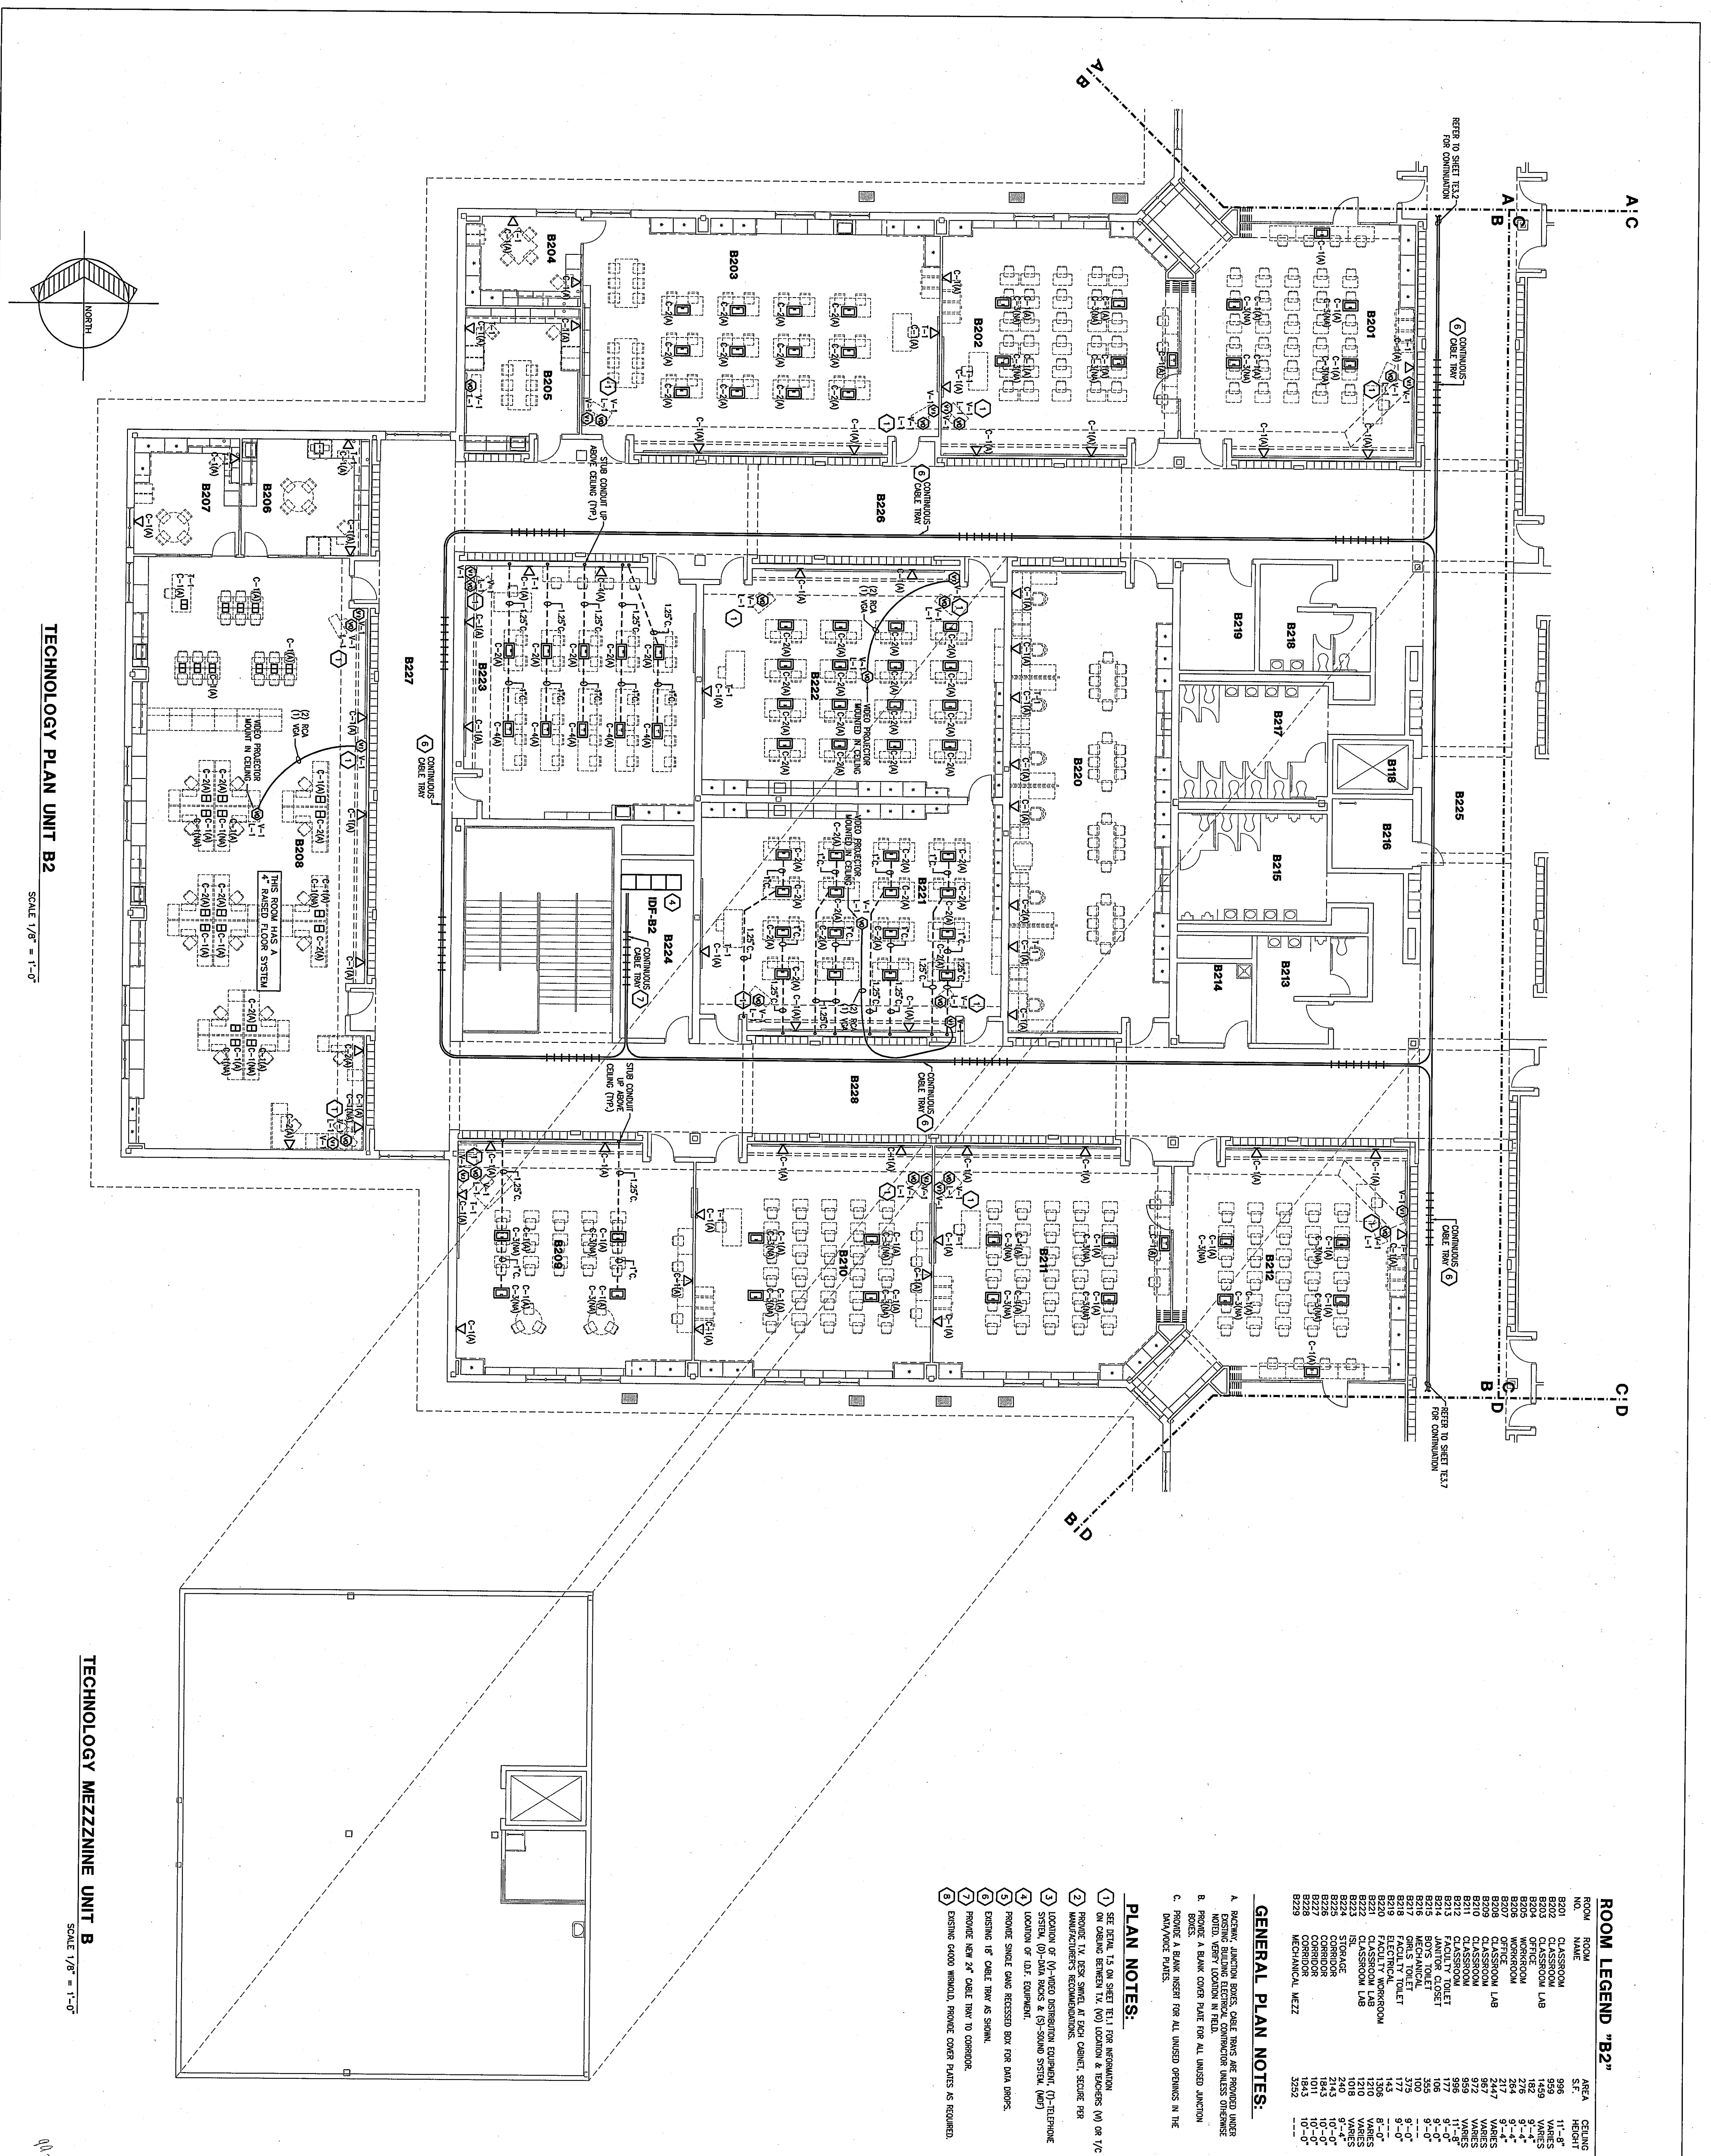

ROOM LEGEND "B2"


ROOM NO.	ROOM NAME	AREA S.F.	CEILING HEIGHT
B201	CLASSROOM	966	11'-8"
B202	CLASSROOM	966	11'-8"
B203	CLASSROOM	966	11'-8"
B204	CLASSROOM	966	11'-8"
B205	CLASSROOM	966	11'-8"
B206	CLASSROOM	966	11'-8"
B207	CLASSROOM	966	11'-8"
B208	CLASSROOM	966	11'-8"
B209	LAB	2447	9'-4"
B210	LAB	2447	9'-4"
B211	CLASSROOM	966	11'-8"
B212	CLASSROOM	966	11'-8"
B213	CLASSROOM	966	11'-8"
B214	CLASSROOM	966	11'-8"
B215	CLASSROOM	966	11'-8"
B216	CLASSROOM	966	11'-8"
B217	CLASSROOM	966	11'-8"
B218	CLASSROOM	966	11'-8"
B219	LAB	2447	9'-4"
B220	LAB	2447	9'-4"
B221	CLASSROOM	966	11'-8"
B222	CLASSROOM	966	11'-8"
B223	CLASSROOM	966	11'-8"
B224	CLASSROOM	966	11'-8"
B225	CLASSROOM	966	11'-8"
B226	CLASSROOM	966	11'-8"
B227	CLASSROOM	966	11'-8"
B228	CLASSROOM	966	11'-8"
B229	MEZZANINE	3252	10'-0"

GENERAL PLAN NOTES:


1. PROVIDE JUNCTION BOXES, CABLE TRAYS ARE PROVIDED UNDER FLOORING. PROVIDE A BLANK COVER PLATE FOR ALL UNUSED JUNCTION BOXES.
2. PROVIDE A BLANK COVER PLATE FOR ALL UNUSED JUNCTION BOXES.
3. PROVIDE A BLANK INSERT FOR ALL UNUSED OPENINGS IN THE DATA/VOICE PLATES.

PLAN NOTES:

1. SEE DETAIL T3 ON SHEET T3.1 FOR INFORMATION ON CABLE TRAYING. PROVIDE A BLANK COVER PLATE FOR ALL UNUSED JUNCTION BOXES.
2. PROVIDE TV, DESK SWITCHEL AT EACH CABINET. SECURE PER MANUFACTURER'S RECOMMENDATIONS.
3. LOCATION OF (V)-VIDEO DISTRIBUTION EQUIPMENT, (T)-TELEPHONE SYSTEM, (D)-DATA RACKS & (S)-SOUND SYSTEM, (W)-WIRELESS LOCATION OF DLT EQUIPMENT.
4. PROVIDE SINGLE GANG RECESSED BOX FOR DATA GROUPS.
5. EXISTING 18" CABLE TRAY AS SHOWN.
6. PROVIDE NEW 24" CABLE TRAY TO CORRIDOR.
7. EXISTING CABLE TRAY. PROVIDE COVER PLATES AS REQUIRED.

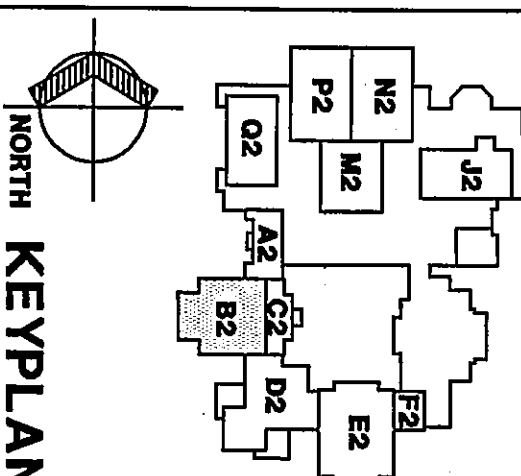

THE NEW
CHESTERTON HIGH SCHOOL
TECHNOLOGY PACKAGE
DUNELAND SCHOOL CORPORATION
CHESTERTON, INDIANA

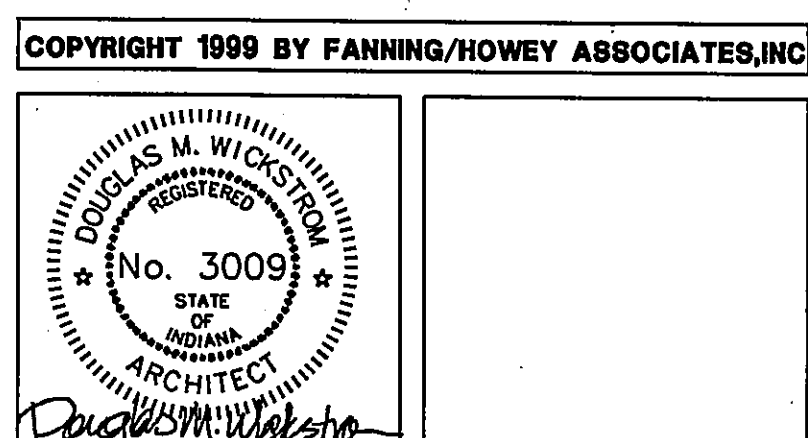

Fanning/Howey
Associates, Inc.
Architects Engineers Consultants

TECHNOLOGY PLAN UNIT B2	
DRAWN BY: MRS	COMM. NO.: 95067.00
CHECKED BY: RSB	DATE: MAY 3, 1999
REVISIONS NO. DATE	
TE3.4	