

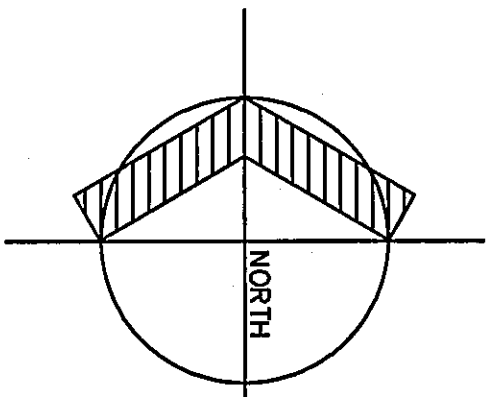
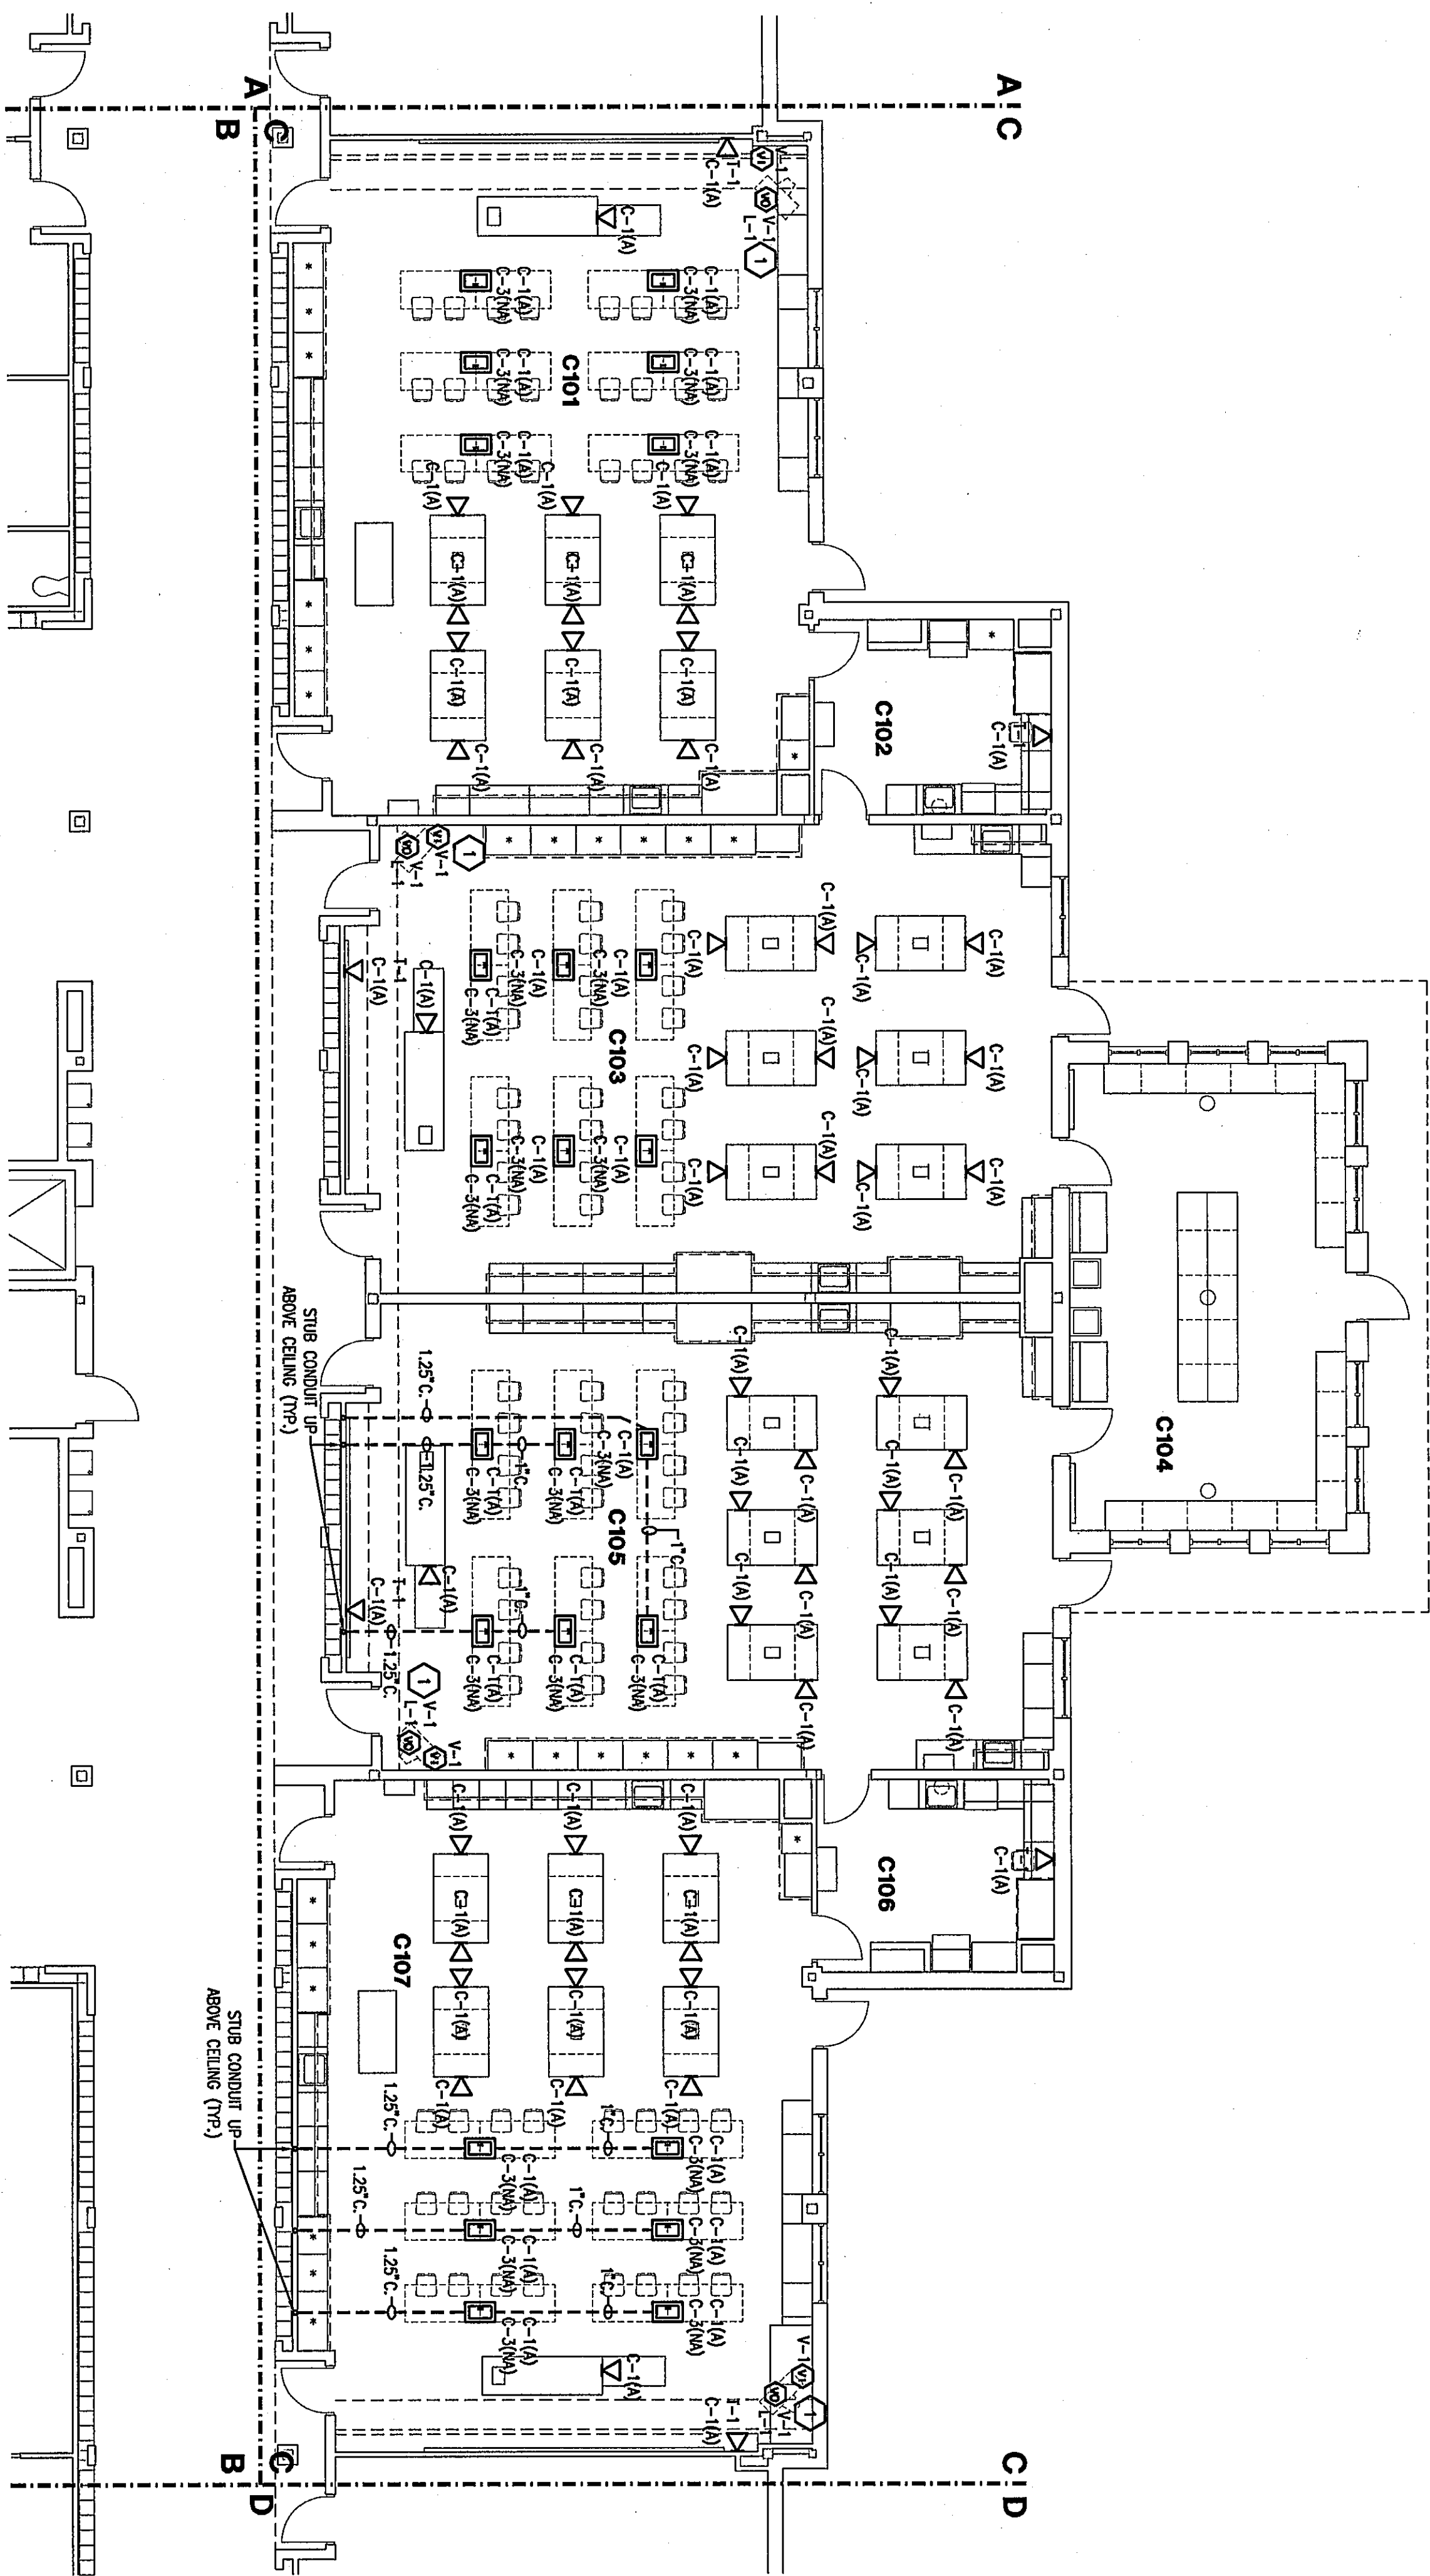


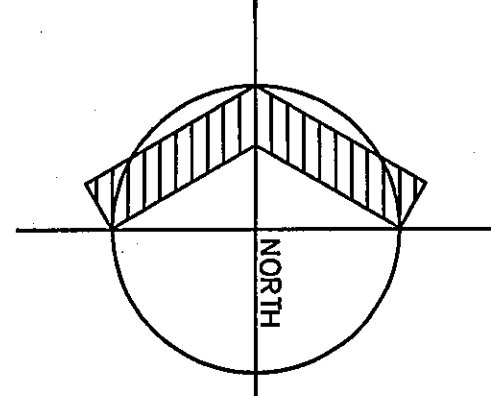

TECHNOLOGY PLAN UNIT C1

SCALE: 1/8" = 1'-0"

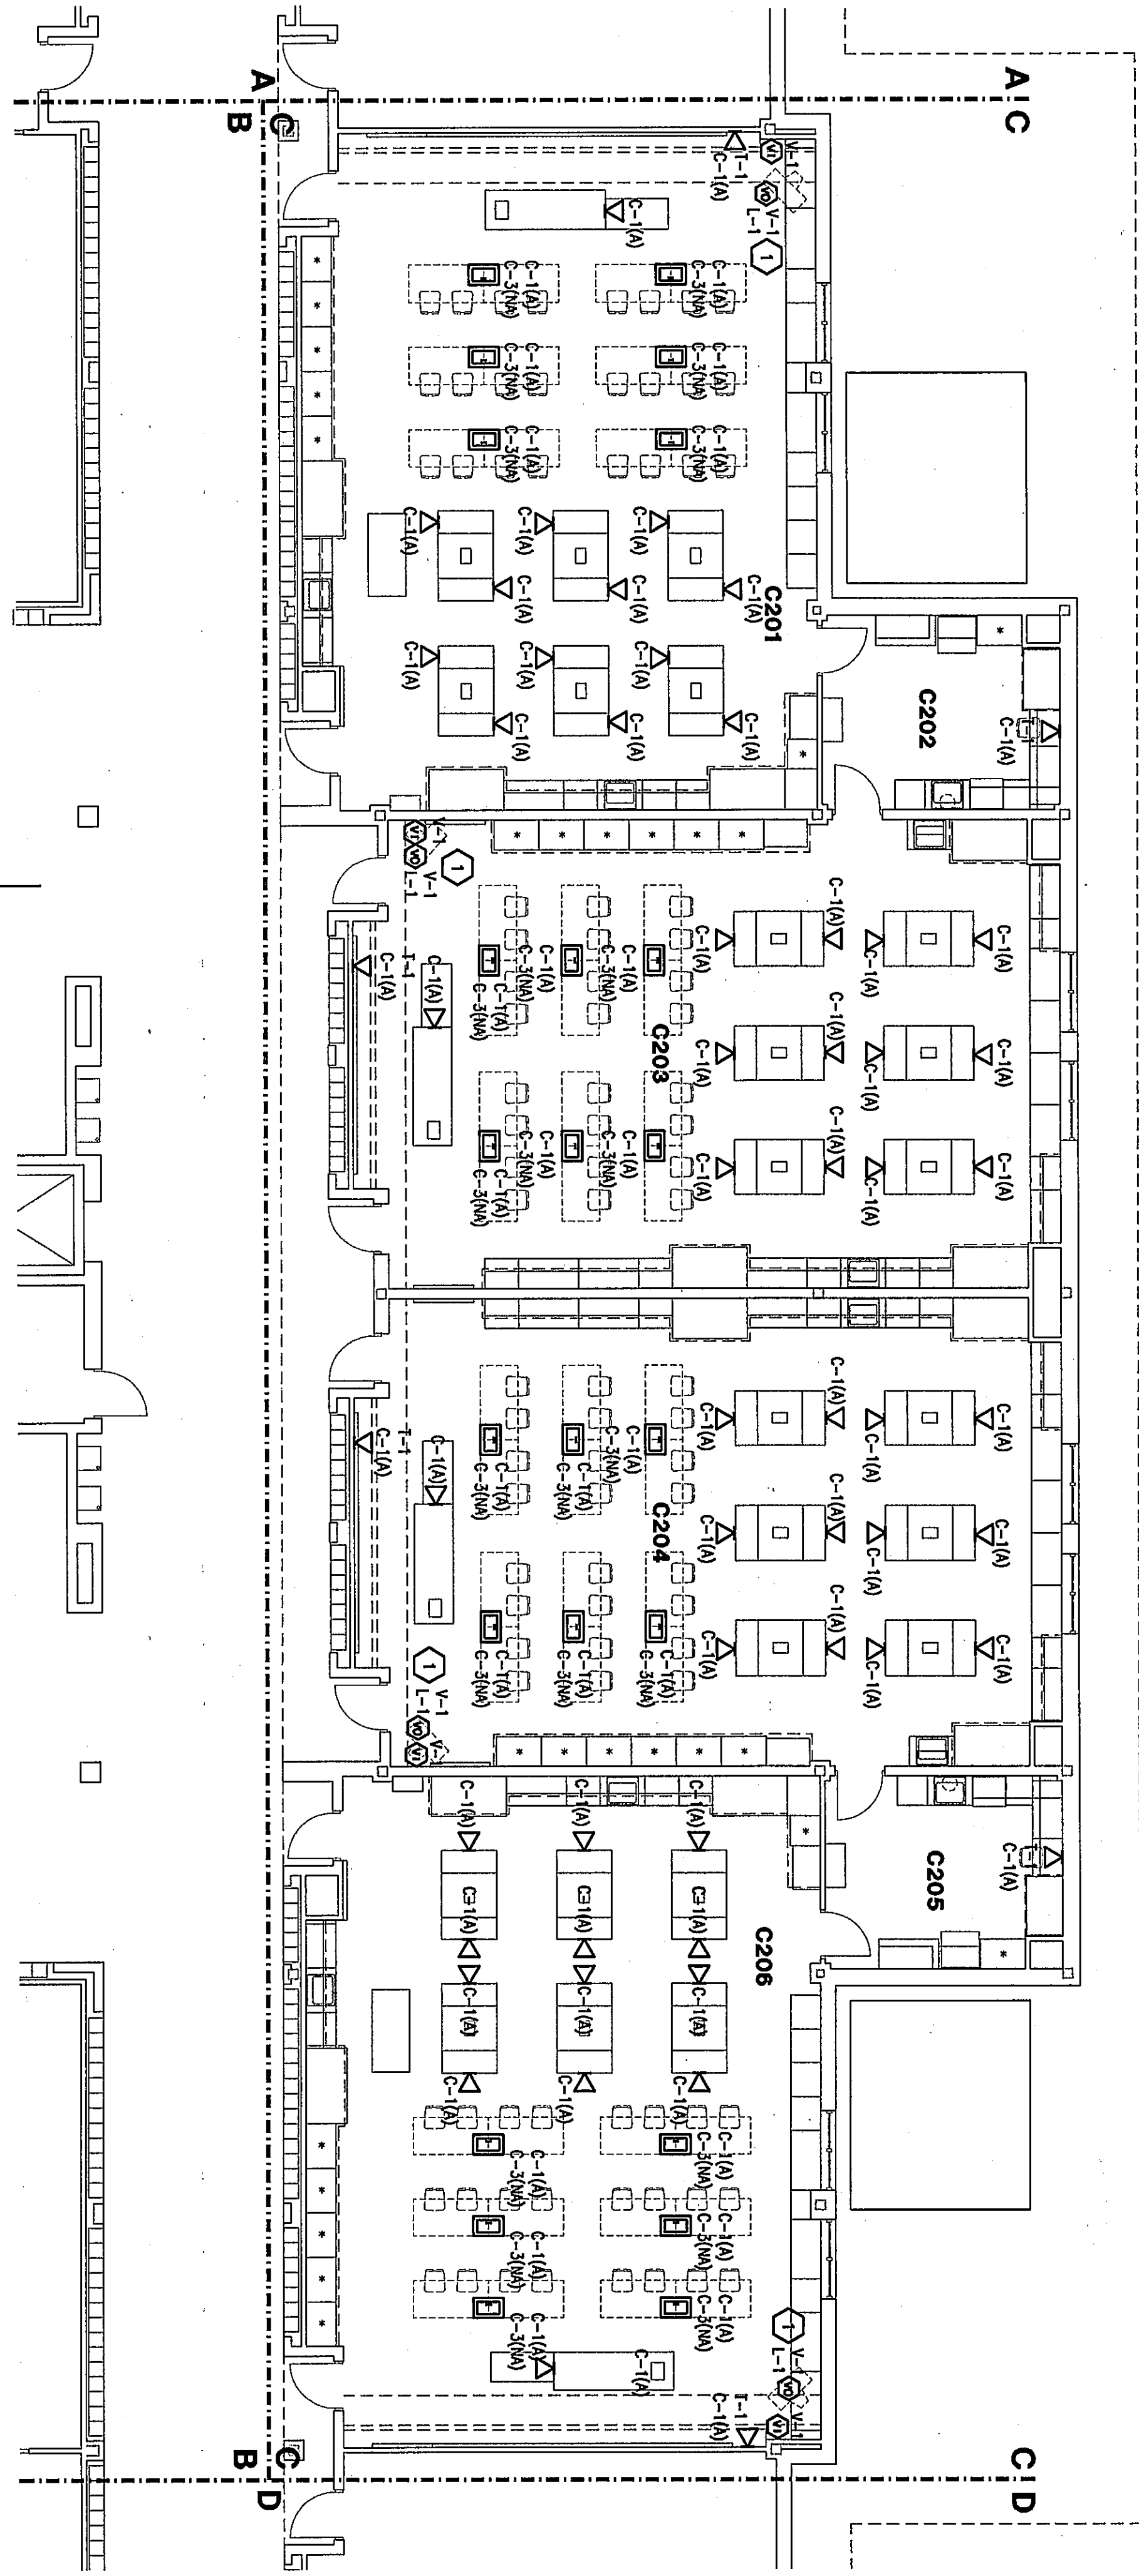

TECHNOLOGY PLAN UNIT C2

SCALE: 1/8" = 1'-0"

ROOM LEGEND "C1"			
ROOM NO.	ROOM NAME	AREA S.F.	CEILING HEIGHT
C101	SCIENCE LAB	1505	VARIES
C102	SCIENCE LAB	1505	VARIES
C103	SCIENCE LAB	1505	VARIES
C104	PREP ROOM	1436	VARIES
C105	SCIENCE LAB	1505	VARIES
C106	SCIENCE LAB	1505	VARIES
C107	SCIENCE LAB	1505	VARIES


ROOM LEGEND "C2"			
ROOM NO.	ROOM NAME	AREA S.F.	CEILING HEIGHT
C201	SCIENCE LAB	1505	VARIES
C202	SCIENCE LAB	1505	VARIES
C203	SCIENCE LAB	1505	VARIES
C204	PREP ROOM	1436	VARIES
C205	SCIENCE LAB	1505	VARIES
C206	SCIENCE LAB	1505	VARIES

GENERAL PLAN NOTES:

- A. ROOMS, JUNCTION BOXES, CABLE TRAYS ARE PROVIDED UNDER FLOOR. SEE DETAIL T-1 ON SHEET T-1 FOR INFORMATION ON CABLE TRAYING. (V) LOCATION & TEACHERS (V) OR 1/2 LOCATION.
- B. PROVIDE A BLANK COVER PLATE FOR ALL UNUSED JUNCTION BOXES.
- C. PROVIDE A BLANK INSERT FOR ALL UNUSED OPENINGS IN THE DATA/VOICE PLATES.


PLAN NOTES:

1. SEE DETAIL T-1 ON SHEET T-1 FOR INFORMATION ON CABLE TRAYING. (V) LOCATION & TEACHERS (V) OR 1/2 LOCATION.
2. PROVIDE T.V. DESK SINGLE AT EACH CABINET, SECURE PER MANUFACTURER'S RECOMMENDATIONS.
3. LOCATION OF (V)-VIDEO DISTRIBUTION EQUIPMENT, (T)-TELEPHONE SYSTEM, (D)-DATA RACKS & (S)-SOUND SYSTEM (MUT).
4. PROVIDE SINGLE CABLE RECESSED BOX FOR DATA RACKS.
5. EXISTING 1/2" CABLE TRAY AS SHOWN.
6. PROVIDE NEW 2" CABLE TRAY TO CORRIDOR.
7. EXISTING GOOD WINDO. PROVIDE COVER PLATES AS REQUIRED.

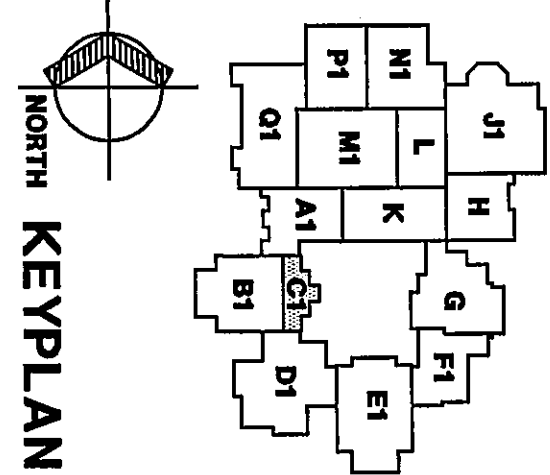

NORTH KEYPLAN

THE NEW
CHESTERTON HIGH SCHOOL
TECHNOLOGY PACKAGE
DUNELAND SCHOOL CORPORATION
CHESTERTON, INDIANA

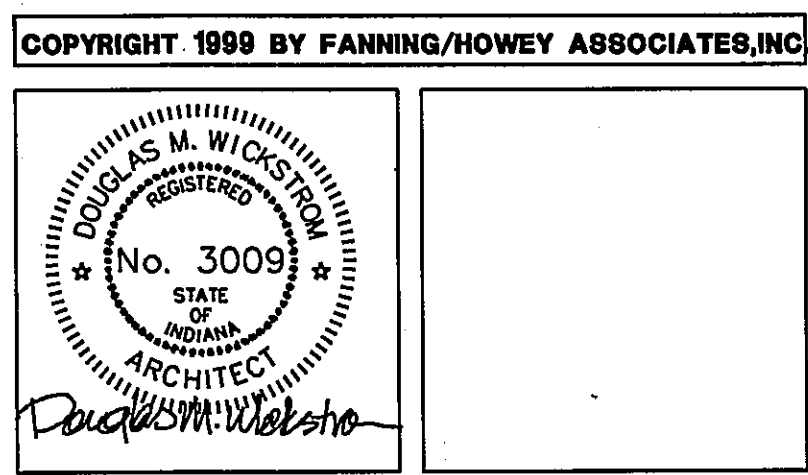

Fanning/Howey
Associates, Inc.
Architects Engineers Consultants

TECHNOLOGY PLAN UNIT C1,C2

DRAWN BY: JED COMM. NO.: 95067.00
CHECKED BY: RSB DATE: MAY 3, 1999

TE3.5

REVISIONS NO. DATE