


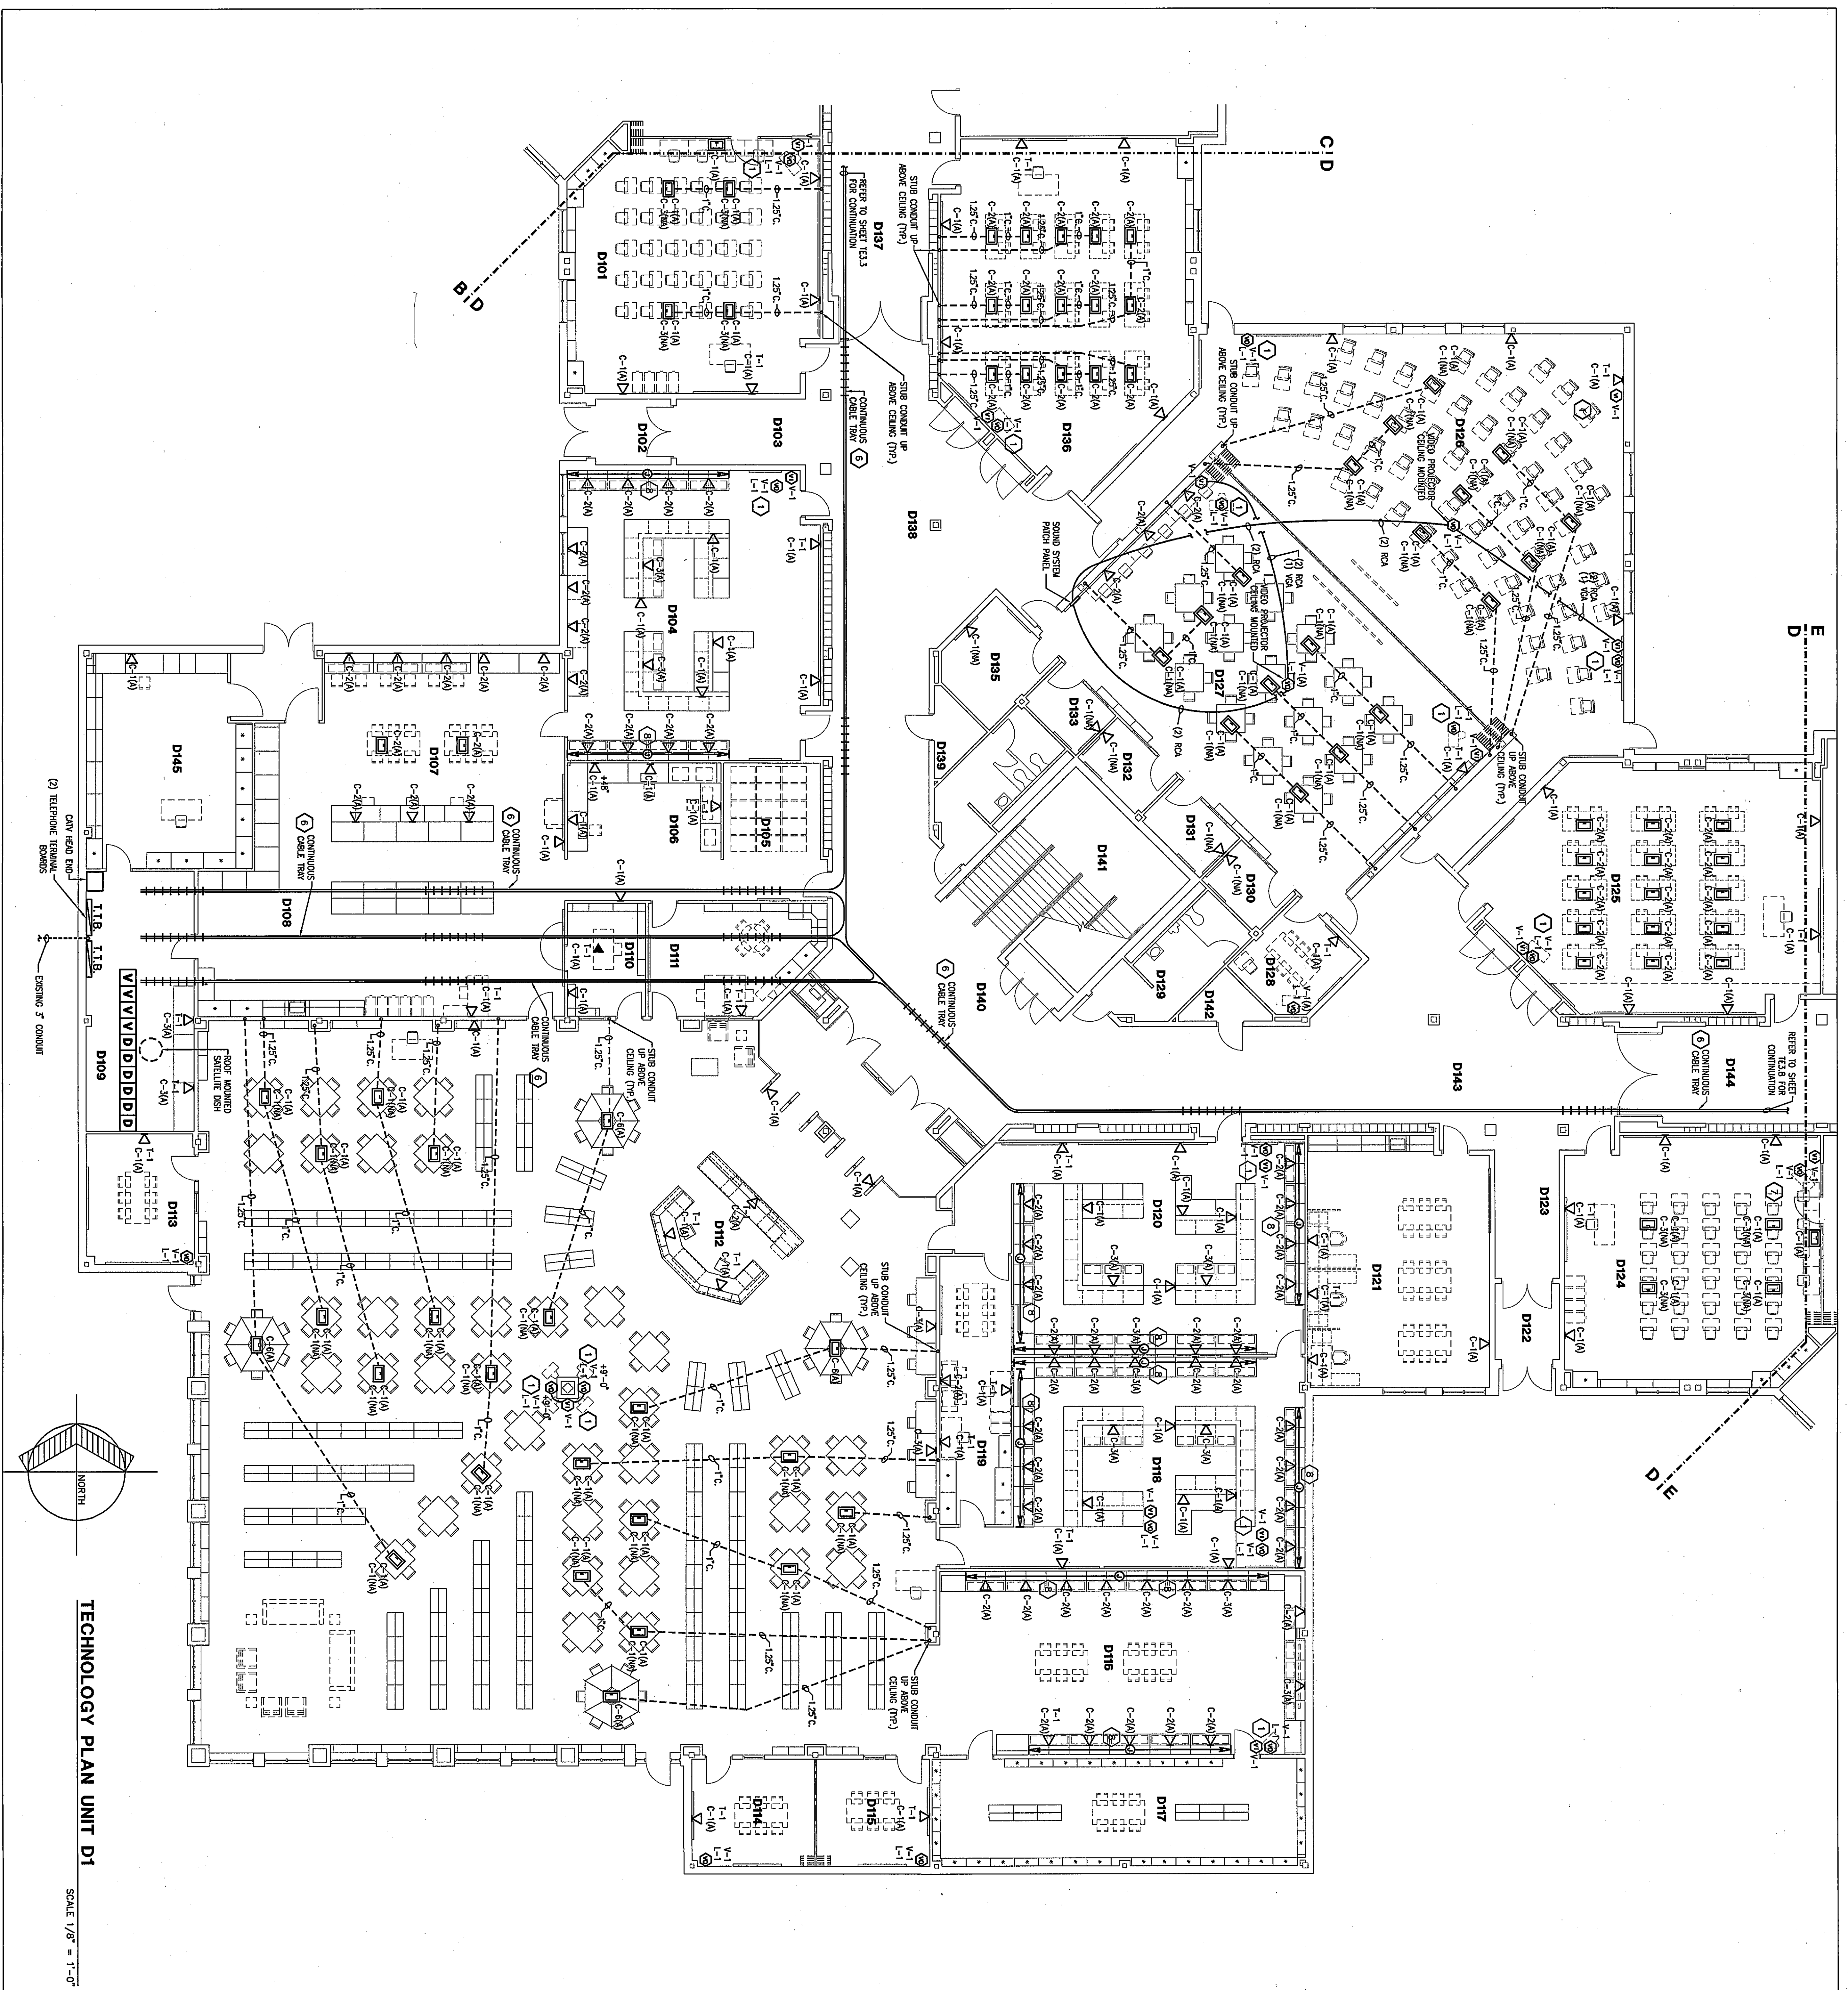

TECHNOLOGY PLAN UNIT D1

SCALE 1/8" = 1'-0"

ROOM LEGEND "D1"		
ROOM NO.	ROOM NAME	AREA, CEILING HEIGHT
D101	CLASSROOM	325, 10'-0"
D102	CLASSROOM	325, 10'-0"
D103	CLASSROOM	325, 10'-0"
D104	CLASSROOM	325, 10'-0"
D105	CLASSROOM	325, 10'-0"
D106	CLASSROOM	325, 10'-0"
D107	CLASSROOM	325, 10'-0"
D108	CLASSROOM	325, 10'-0"
D109	CLASSROOM	325, 10'-0"
D110	CLASSROOM	325, 10'-0"
D111	CLASSROOM	325, 10'-0"
D112	CLASSROOM	325, 10'-0"
D113	CLASSROOM	325, 10'-0"
D114	CLASSROOM	325, 10'-0"
D115	CLASSROOM	325, 10'-0"
D116	CLASSROOM	325, 10'-0"
D117	CLASSROOM	325, 10'-0"
D118	CLASSROOM	325, 10'-0"
D119	CLASSROOM	325, 10'-0"
D120	CLASSROOM	325, 10'-0"
D121	CLASSROOM	325, 10'-0"
D122	CLASSROOM	325, 10'-0"
D123	CLASSROOM	325, 10'-0"
D124	CLASSROOM	325, 10'-0"
D125	CLASSROOM	325, 10'-0"
D126	CLASSROOM	325, 10'-0"
D127	CLASSROOM	325, 10'-0"
D128	CLASSROOM	325, 10'-0"
D129	CLASSROOM	325, 10'-0"
D130	CLASSROOM	325, 10'-0"
D131	CLASSROOM	325, 10'-0"
D132	CLASSROOM	325, 10'-0"
D133	CLASSROOM	325, 10'-0"
D134	CLASSROOM	325, 10'-0"
D135	CLASSROOM	325, 10'-0"
D136	CLASSROOM	325, 10'-0"
D137	CLASSROOM	325, 10'-0"
D138	CLASSROOM	325, 10'-0"
D139	CLASSROOM	325, 10'-0"
D140	CLASSROOM	325, 10'-0"
D141	CLASSROOM	325, 10'-0"
D142	CLASSROOM	325, 10'-0"
D143	CLASSROOM	325, 10'-0"
D144	CLASSROOM	325, 10'-0"
D145	CLASSROOM	325, 10'-0"

- GENERAL PLAN NOTES:**
1. ROOMING, JUNCTION BOXES, CABLE RAYS ARE PROVIDED UNDER FLOOR.
 2. EXISTING BUILDING ELECTRICAL CONTRACTOR UNLESS OTHERWISE NOTED.
 3. PROVIDE A BLANK COVER PLATE FOR ALL UNUSED JUNCTION BOXES.
 4. PROVIDE A BLANK INSERT FOR ALL UNUSED OPENINGS IN THE DATA/VOICE PATHS.
- PLAN NOTES:**
1. SEE DETAIL 1.5 ON SHEET E1.1 FOR INFORMATION ON CABLES BETWEEN TX (V) LOCATION & TEACHERS (V) OR T/C LOCATION.
 2. PROVIDE TV, DESK SIGNAL, AT EACH CABINET, SECURE PER MANUFACTURER'S RECOMMENDATIONS.
 3. LOCATION OF (V)-VIDEO DISTRIBUTION EQUIPMENT (V)-TELEPHONE SYSTEM, (D)-DATA RACKS & (S)-SOUND SYSTEM (V/S).
 4. LOCATION OF LDE EQUIPMENT.
 5. PROVIDE SINGLE GANG RECESSED BOX FOR DATA BROWS.
 6. EXISTING 16" CABLE TRAY AS SHOWN.
 7. PROVIDE NEW 24" CABLE TRAY TO CORRIDOR.
 8. EXISTING 6000 WINDUP, PROVIDE COVER PLATES AS REQUIRED.

TECHNOLOGY PLAN UNIT D1

DRAWN BY: JED

COMM. NO.: 95067.00

CHECKED BY: RSB

DATE: MAY 3, 1999

TE3.6

REVISIONS NO. DATE

Fanning/Howey Associates, Inc.

Architects Engineers Consultants

KEYPLAN

THE NEW

CHESTERTON HIGH SCHOOL

TECHNOLOGY PACKAGE

DUNELAND SCHOOL CORPORATION

CHESTERTON, INDIANA

COPYRIGHT 1999 BY FANNING/HOWEY ASSOCIATES, INC.

DOUGLAS M. WILSON

No. 3009

STATE OF INDIANA

ARCHITECT

DAVID M. WILSON