


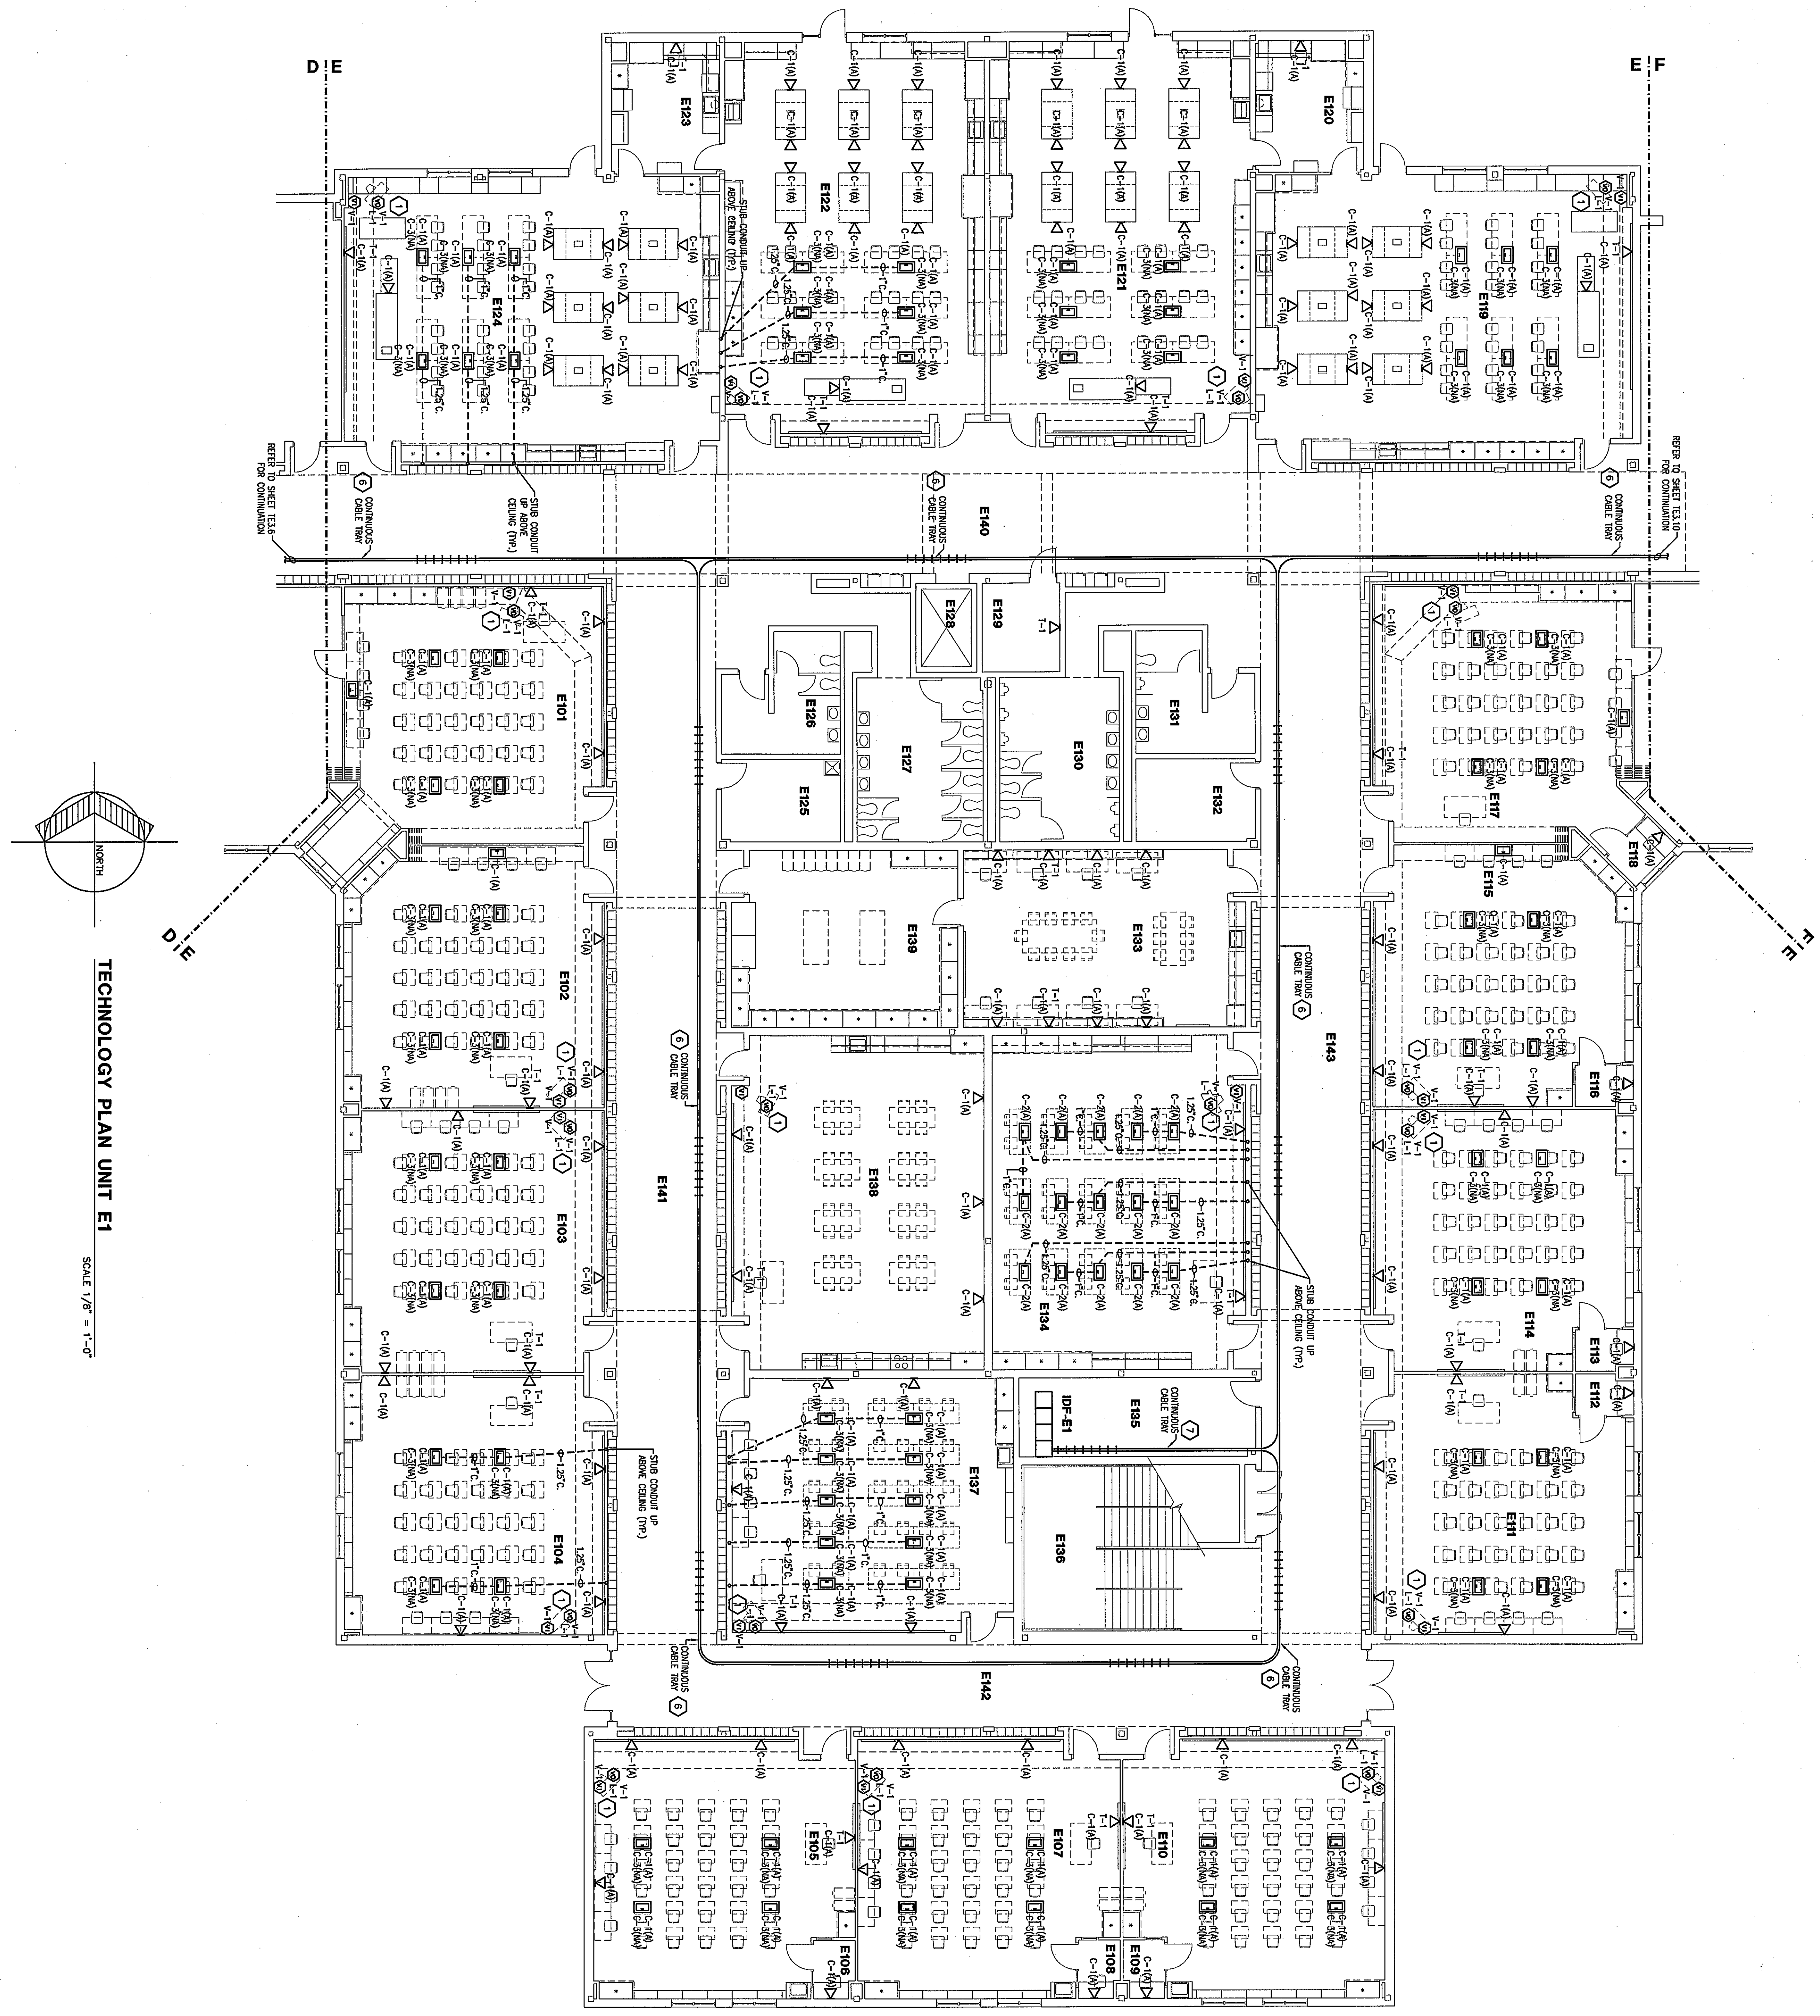

ROOM LEGEND "E1"			
ROOM NO.	ROOM NAME	AREA S.F.	CEILING HEIGHT
E101	CLASSROOM	968	11'-8"
E102	CLASSROOM	968	11'-8"
E103	CLASSROOM	968	11'-8"
E104	CLASSROOM	968	11'-8"
E105	CLASSROOM	968	11'-8"
E106	CLASSROOM	968	11'-8"
E107	CLASSROOM	968	11'-8"
E108	CLASSROOM	968	11'-8"
E109	CLASSROOM	968	11'-8"
E110	CLASSROOM	968	11'-8"
E111	CLASSROOM	968	11'-8"
E112	CLASSROOM	968	11'-8"
E113	CLASSROOM	968	11'-8"
E114	CLASSROOM	968	11'-8"
E115	CLASSROOM	968	11'-8"
E116	CLASSROOM	968	11'-8"
E117	CLASSROOM	968	11'-8"
E118	CLASSROOM	968	11'-8"
E119	CLASSROOM	968	11'-8"
E120	CLASSROOM	968	11'-8"
E121	CLASSROOM	968	11'-8"
E122	CLASSROOM	968	11'-8"
E123	CLASSROOM	968	11'-8"
E124	CLASSROOM	968	11'-8"
E125	CLASSROOM	968	11'-8"
E126	CLASSROOM	968	11'-8"
E127	CLASSROOM	968	11'-8"
E128	CLASSROOM	968	11'-8"
E129	CLASSROOM	968	11'-8"
E130	CLASSROOM	968	11'-8"
E131	CLASSROOM	968	11'-8"
E132	CLASSROOM	968	11'-8"
E133	CLASSROOM	968	11'-8"
E134	CLASSROOM	968	11'-8"
E135	CLASSROOM	968	11'-8"
E136	CLASSROOM	968	11'-8"
E137	CLASSROOM	968	11'-8"
E138	CLASSROOM	968	11'-8"
E139	CLASSROOM	968	11'-8"
E140	CLASSROOM	968	11'-8"
E141	CLASSROOM	968	11'-8"
E142	CLASSROOM	968	11'-8"
E143	CLASSROOM	968	11'-8"
E144	CLASSROOM	968	11'-8"
E145	CLASSROOM	968	11'-8"

GENERAL PLAN NOTES:

1. SEE DETAIL 1.5 ON SHEET T-1 FOR INFORMATION ON CABLE TRAY LOCATIONS AND TYPICAL DETAILS.
2. PROVIDE A BANK COVER PLATE FOR ALL UNUSED JUNCTIONS.
3. PROVIDE A BANK INSERT FOR ALL UNUSED OPENINGS IN THE DATA/CABLE TRAYS.

PLAN NOTES:

1. SEE DETAIL 1.5 ON SHEET T-1 FOR INFORMATION ON CABLE TRAY LOCATIONS AND TYPICAL DETAILS.
2. PROVIDE A BANK COVER PLATE FOR ALL UNUSED JUNCTIONS.
3. PROVIDE A BANK INSERT FOR ALL UNUSED OPENINGS IN THE DATA/CABLE TRAYS.

TECHNOLOGY PLAN UNIT E1
SCALE 1/8" = 1'-0"

9/10/13

TECHNOLOGY PLAN UNIT E1


DRAWN BY: JED
CHECKED BY: RSB

COMM. NO.: 95067.00
DATE: MAY 3, 1999

TE3.8

REVISIONS NO. DATE

Fanning/Howey Associates, Inc.
Architects Engineers Consultants

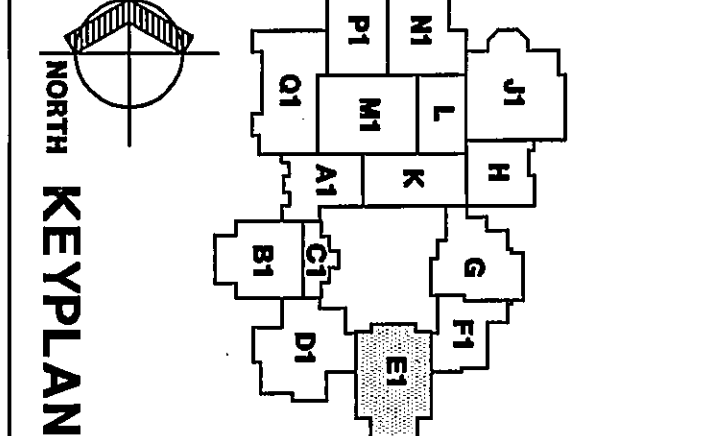

THE NEW
CHESTERTON HIGH SCHOOL
TECHNOLOGY PACKAGE

DUNELAND SCHOOL CORPORATION
CHESTERTON, INDIANA

COPYRIGHT 1999 BY FANNING/HOWEY ASSOCIATES, INC.

Douglas M. Wolske