


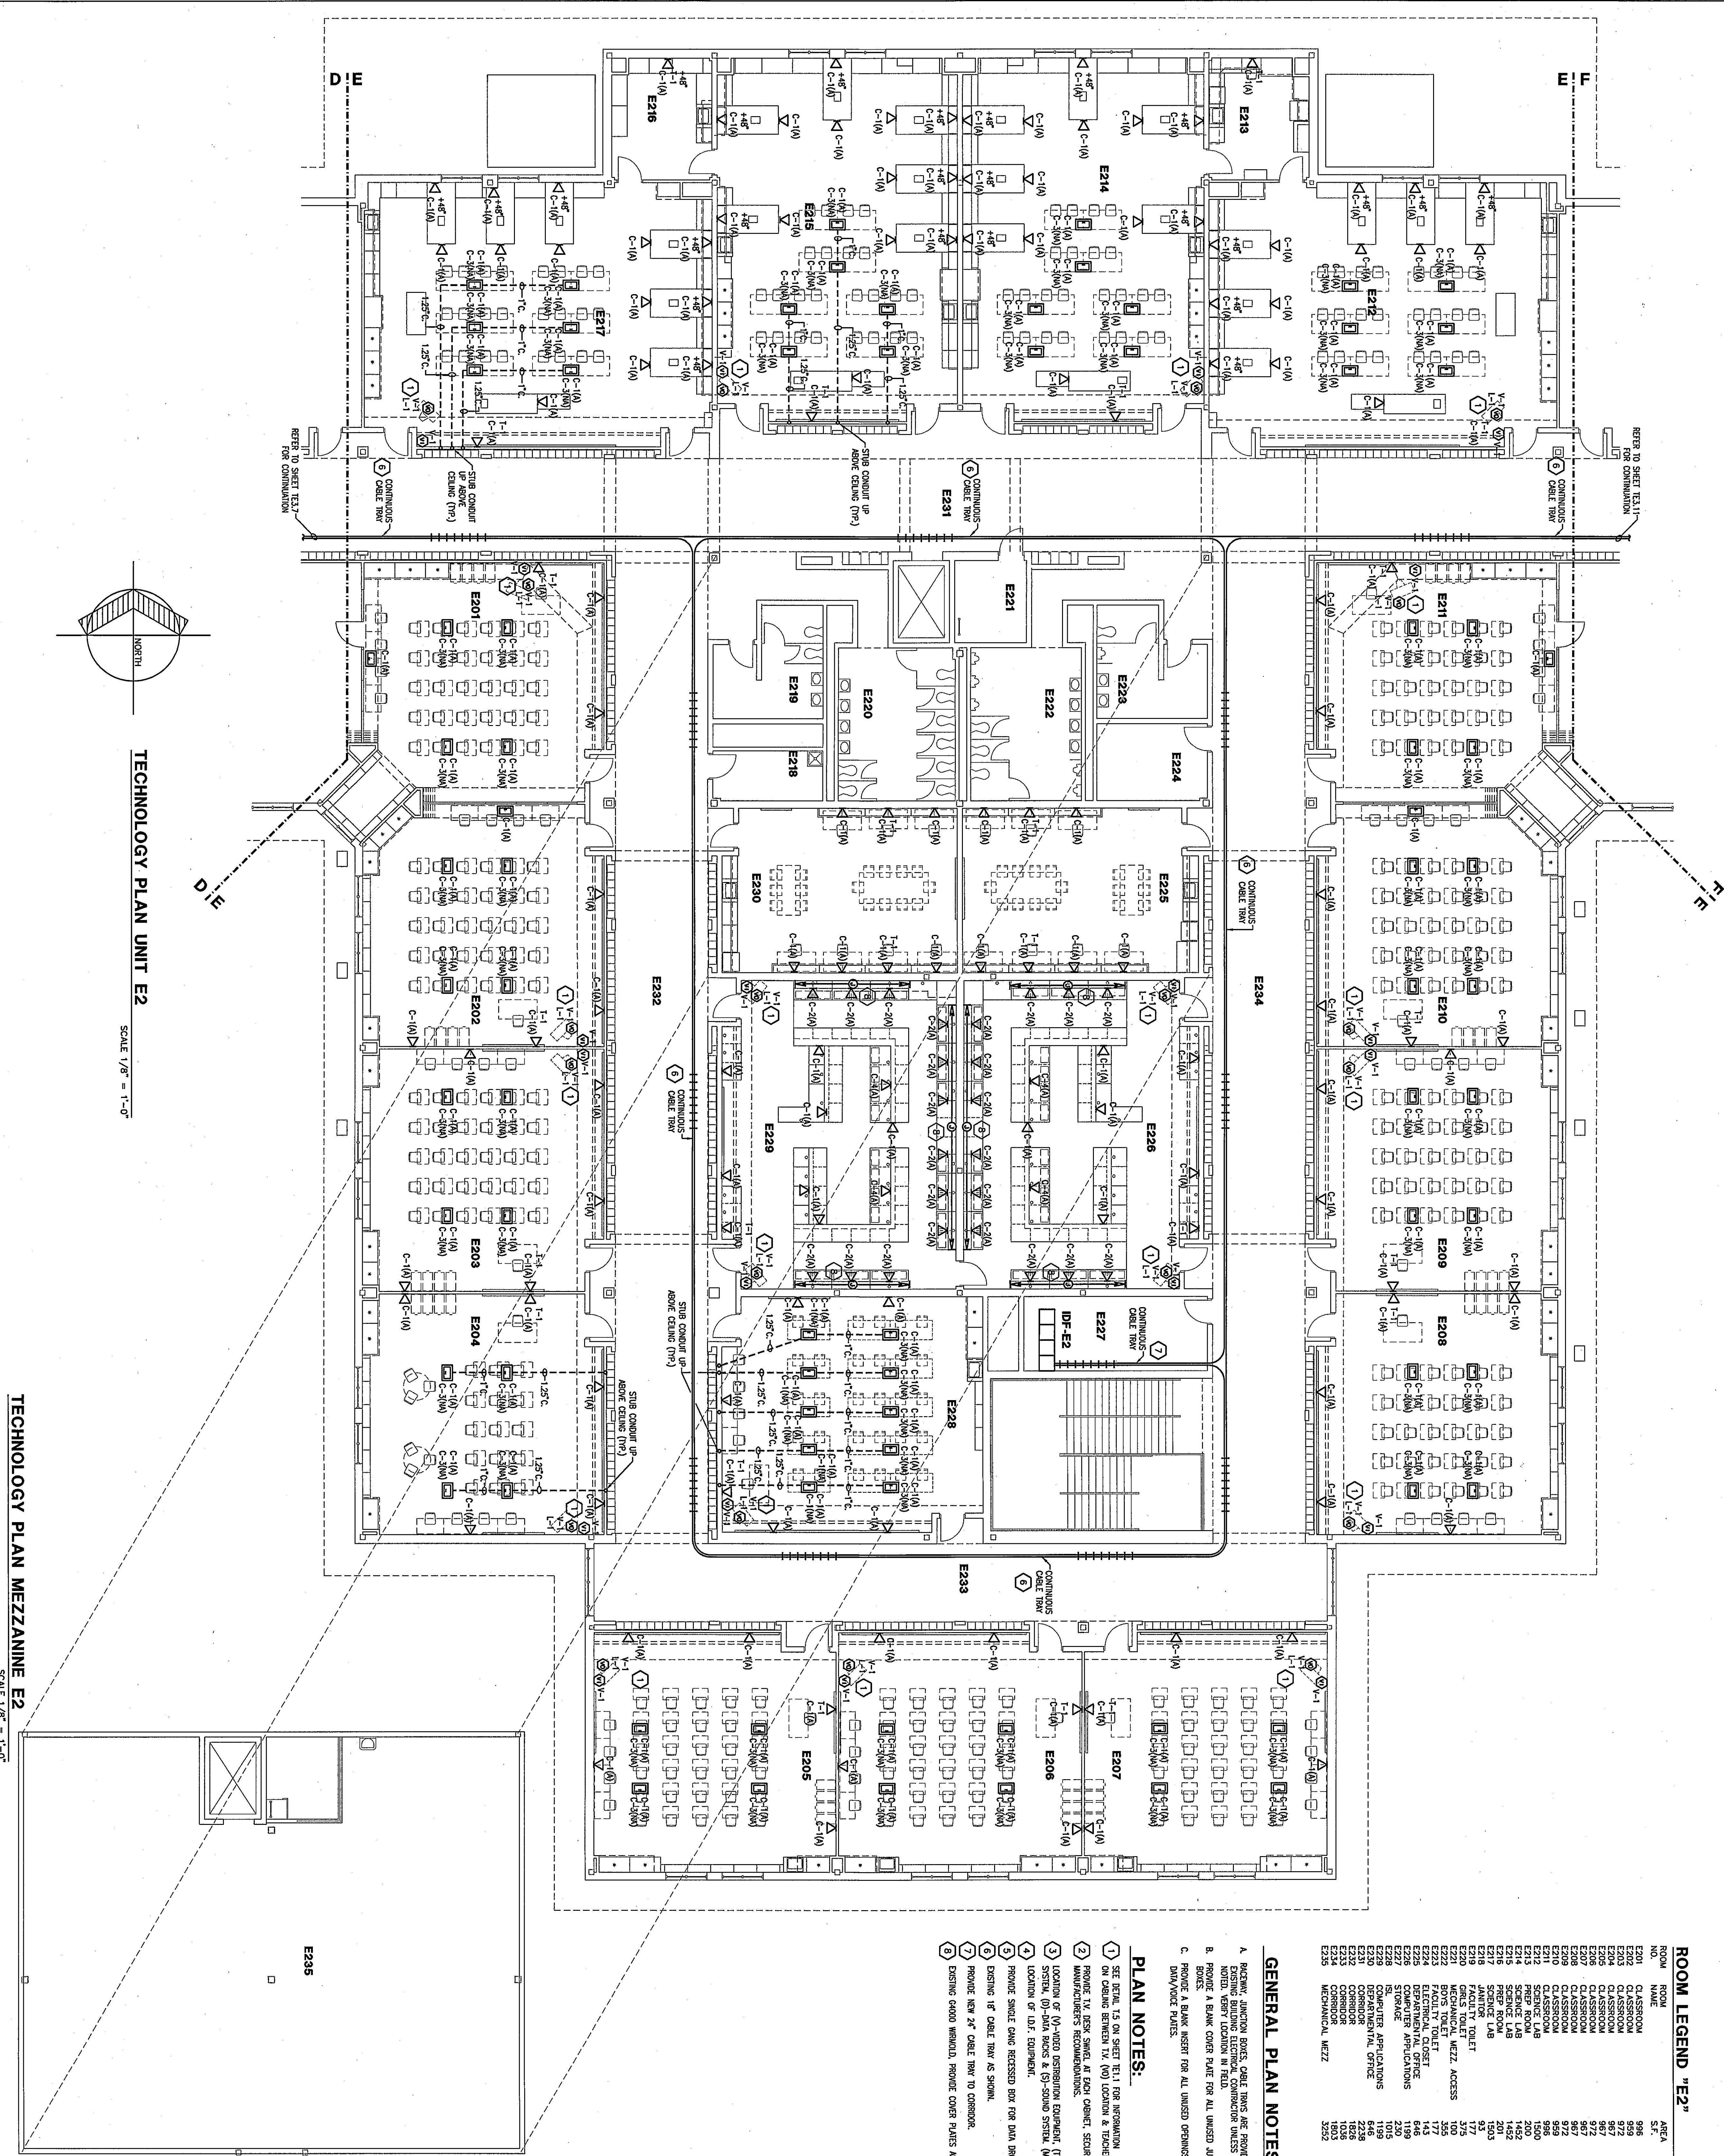

ROOM LEGEND "E2"				
ROOM NO.	ROOM NAME	AREA	CEILING HEIGHT	
E201	CLASSROOM	996	11'-8"	
E202	CLASSROOM	959	11'-8"	
E203	CLASSROOM	959	11'-8"	
E204	CLASSROOM	967	11'-8"	
E205	CLASSROOM	967	11'-8"	
E206	CLASSROOM	972	11'-8"	
E207	CLASSROOM	967	11'-8"	
E208	CLASSROOM	959	11'-8"	
E209	CLASSROOM	967	11'-8"	
E210	CLASSROOM	959	11'-8"	
E211	SCIENCE LAB	1500	15'-0"	
E212	SCIENCE LAB	1500	15'-0"	
E213	PREP ROOM	400	9'-0"	
E214	SCIENCE LAB	1462	14'-6"	
E215	SCIENCE LAB	1462	14'-6"	
E216	PREP ROOM	303	9'-0"	
E217	PREP ROOM	303	9'-0"	
E218	JANITOR	93	9'-0"	
E219	JANITOR	93	9'-0"	
E220	TOILET	100	9'-0"	
E221	MECHANICAL WZ22. ACCESS	100	9'-0"	
E222	MECHANICAL WZ22. ACCESS	100	9'-0"	
E223	FACILITY TOILET	1777	17'-7"	
E224	TECHNICAL DISTRICT	1149	11'-4"	
E225	TECHNICAL DISTRICT	1149	11'-4"	
E226	COMPUTER APPLICATIONS	1149	11'-4"	
E227	COMPUTER APPLICATIONS	1149	11'-4"	
E228	COMPUTER APPLICATIONS	1149	11'-4"	
E278	COMPUTER APPLICATIONS	1149	11'-4"	
E279	COMPUTER APPLICATIONS	114		

GENERAL PLAN NOTES:

- A. RACEWAY, JUNCTION BOXES, CABLE TRAYS ARE PROVIDED UNDER EXISTING BUILDING ELECTRICAL CONTRACTOR UNLESS OTHERWISE NOTED, VERIFY LOCATION IN FIELD.
- B. PROVIDE A BLANK COVER PLATE FOR ALL UNUSED JUNCTION BOXES.
- C. PROVIDE A BLANK INSERT FOR ALL UNUSED OPENINGS IN THE DATA/VOICE PLATES.

PLAN NOTES:

- 1 SEE ITEM 15 ON SHEET 111, FOR INFORMATION ON CHAINS BELONGING TO (U) LOCATION & TECHNIQUES (V) OR T/C LOCATION.
- 2 PROVIDE 1X BEST DATA AT EACH CHAINST. SCORE PER MANUFACTURER'S RECOMMENDATIONS.
- 3 LOCATION OF (V)-USED DISTRIBUTION EQUIPMENT, (T)-TELEPHONE SYSTEM, (U)-DRAIN HOLE, & (S)-SOUND STRIKE, (W)-LOCATION OF 100'S EQUIPMENT.
- 4 PROVIDE SINGLE GIVE RECESSED BOX FOR PAID DROPS.
- 5 EXISTING 18" CABLE MAY BE SHOWN.
- 6 PROVIDE NEW 24" CABLE NEW TO CONDUIT.
- 7 EXISTING 60/60 WHIRL, PROVIDE COVER PLATES AS REQUIRED.

 
CHESTER HIGH SCHOOL 55067.00	TECHNOLOGY PLAN UNIT E2	
	DRAWN BY: JED	COMM. NO.: 95067.00
	CHECKED BY: RSB	DATE: MAY 3, 1999
	TE3.9 REVISIONS NO. DATE	



**Fanning/Howey
Associates, Inc.**
Architects Engineers Consultants

**THE NEW
CHESTERTON HIGH SCHOOL
TECHNOLOGY PACKAGE**
DUNELAND SCHOOL CORPORATION
CHESTERTON, INDIANA

Copyright 1999 by Fanning/Howey Associates, Inc.

 DAVID M. WICSTRO REGISTERED No. 3009 STATE OF INDIANA ARCHITECT DAVID M. WICSTRO	
---	--