


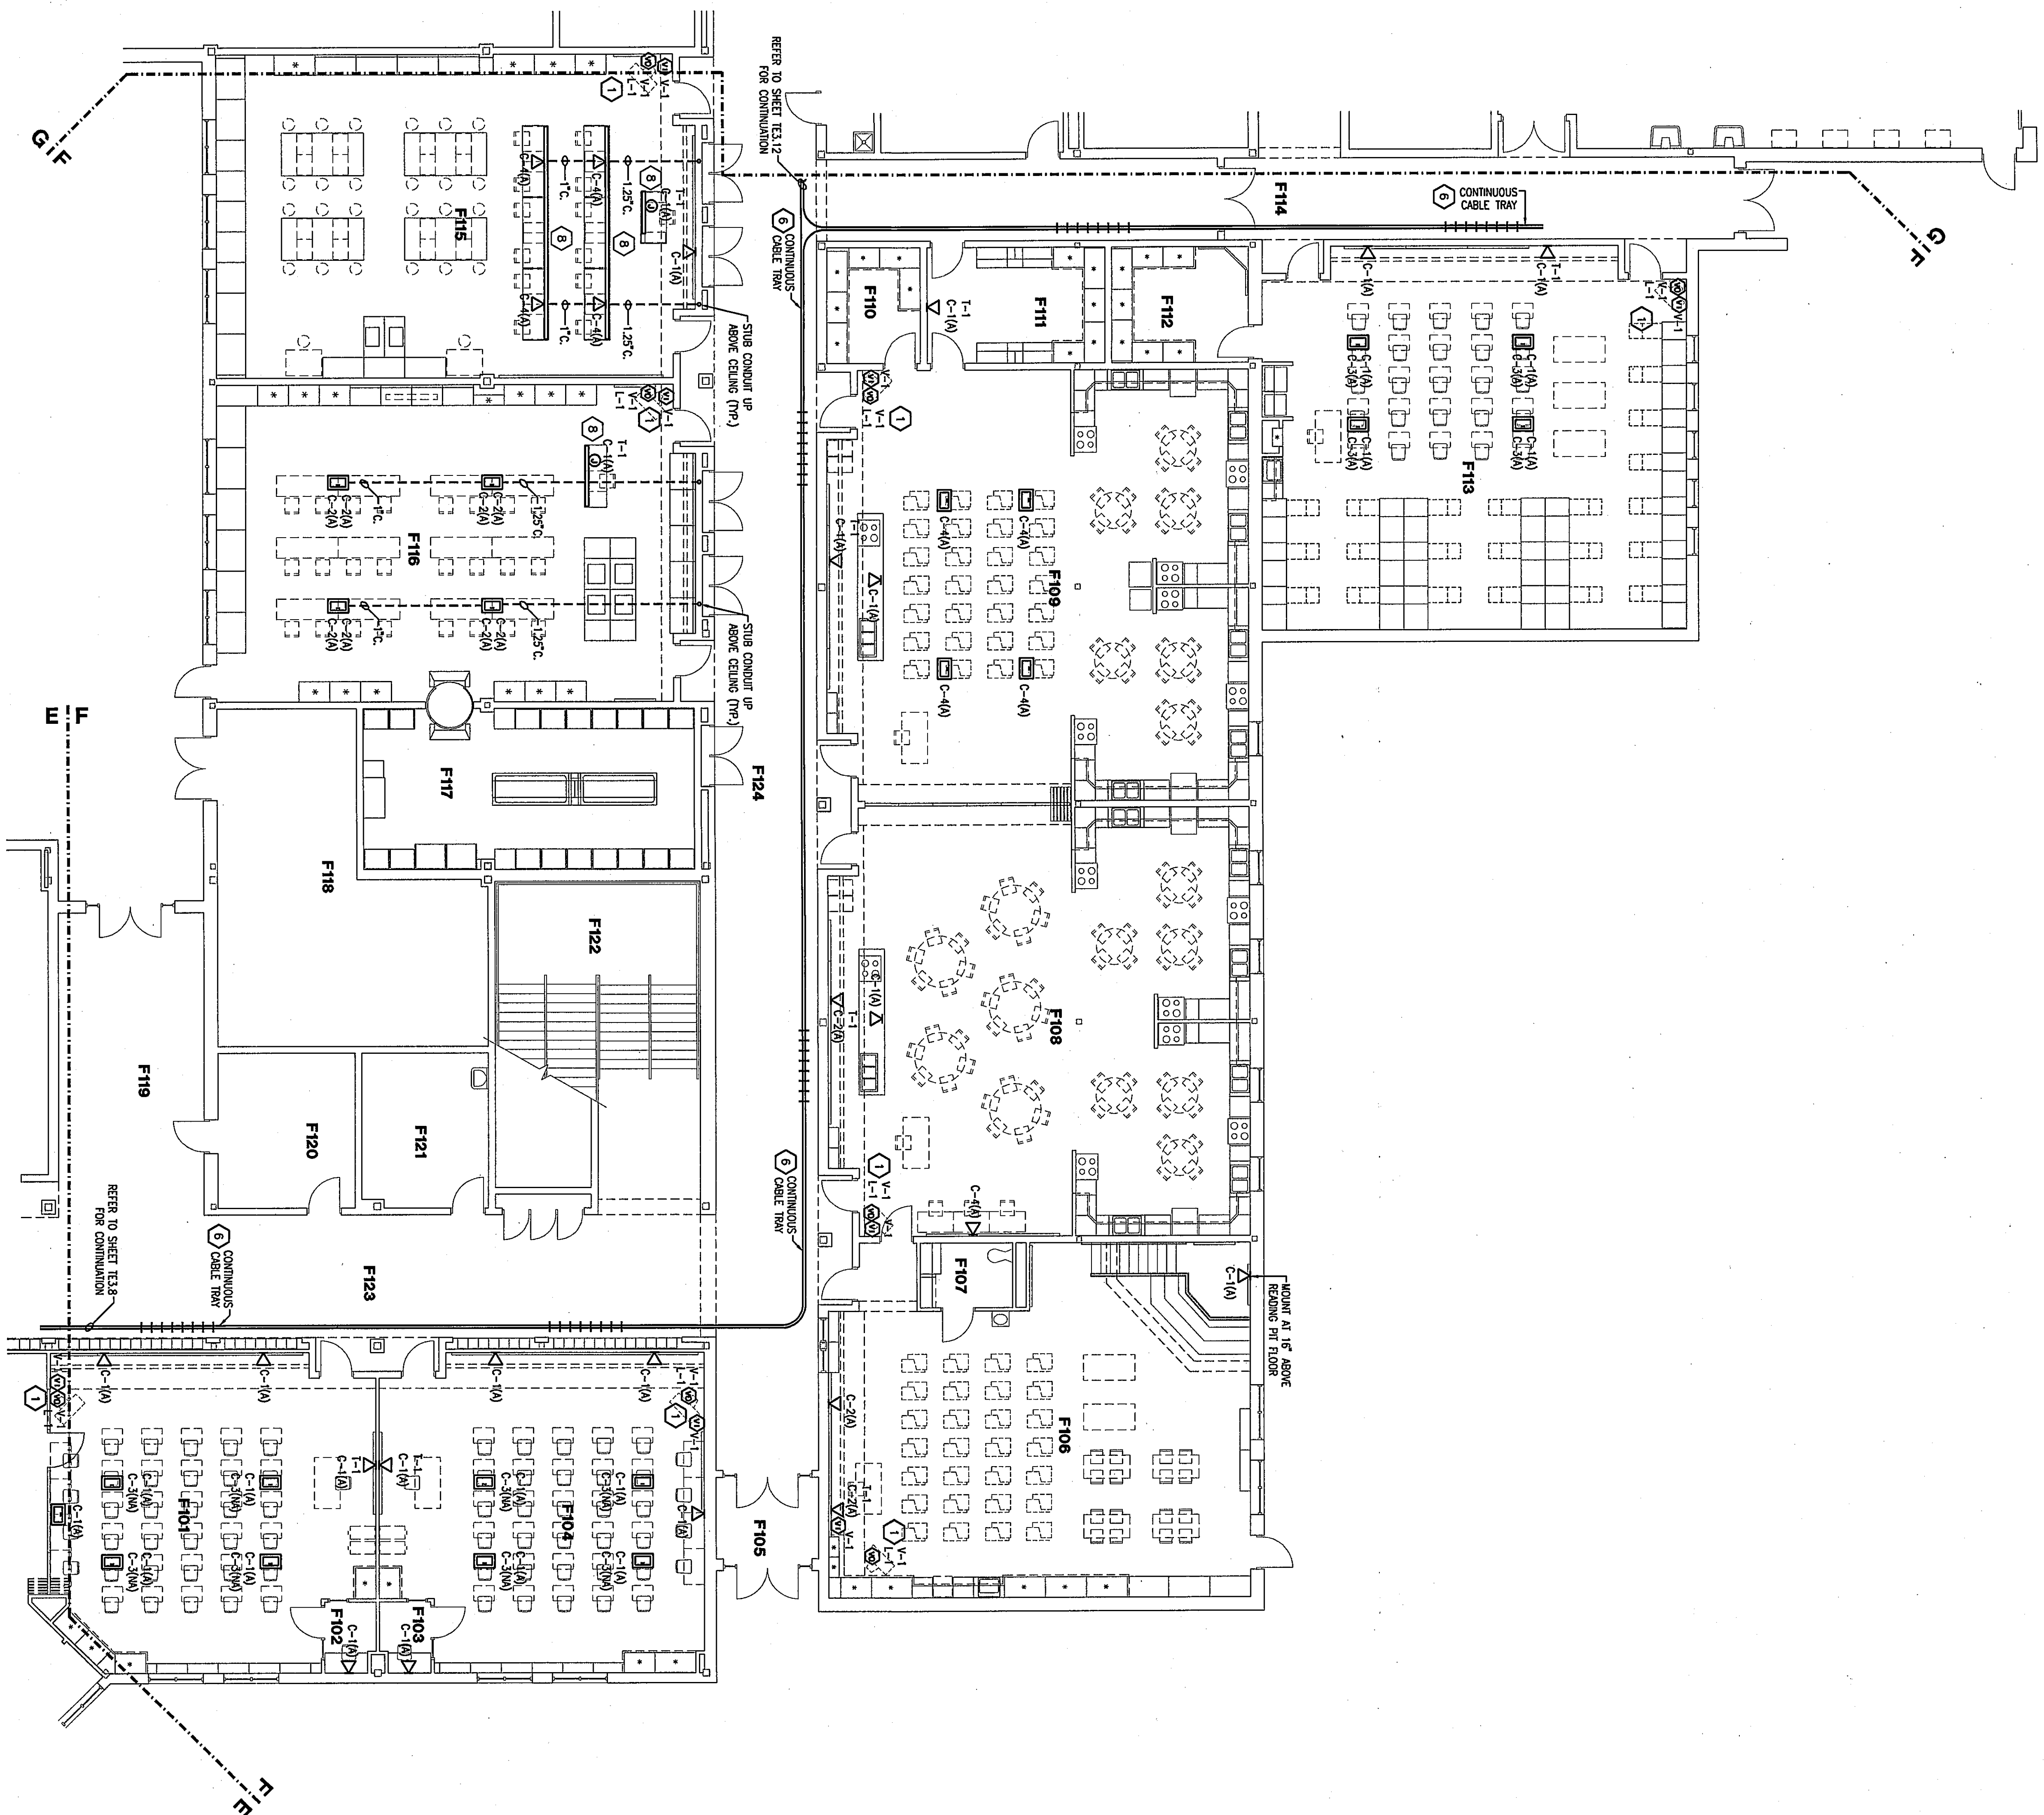


ROOM LEGEND "F1"			
ROOM NO.	ROOM NAME	AREA S.F.	CEILING HEIGHT
F101	CLASSROOM	923	9'-4"
F102	CLASSROOM	923	9'-4"
F103	RECORDING	33	9'-4"
F104	CLASSROOM	923	9'-4"
F105	CLASSROOM	923	9'-4"
F106	CLASSROOM	923	9'-4"
F107	CHILD DEVELOPMENT	1234	9'-4"
F108	TOILET	57	9'-4"
F109	TOILET	57	9'-4"
F110	TOILET	57	9'-4"
F111	TOILET	57	9'-4"
F112	TOILET	57	9'-4"
F113	TOILET	57	9'-4"
F114	TOILET	57	9'-4"
F115	TOILET	57	9'-4"
F116	TOILET	57	9'-4"
F117	TOILET	57	9'-4"
F118	TOILET	57	9'-4"
F119	TOILET	57	9'-4"
F120	TOILET	57	9'-4"
F121	TOILET	57	9'-4"
F122	TOILET	57	9'-4"
F123	TOILET	57	9'-4"

GENERAL PLAN NOTES:

- A. RACKING, JUNCTION BOXES, CABLE TRAYS ARE PROVIDED UNDER EXISTING BUILDING. ELECTRICAL CONTRACTOR TO PROVIDE UNDER EXISTING BUILDING. ELECTRICAL CONTRACTOR TO PROVIDE UNDER EXISTING BUILDING.
- B. PROVIDE A BLANK COVER PLATE FOR ALL UNUSED JUNCTION BOXES.
- C. PROVIDE A BLANK INSERT FOR ALL UNUSED OPENINGS IN THE DATA/VOICE PLATES.

PLAN NOTES:

- 1. SEE DETAIL T3 ON SHEET TE3.11 FOR INFORMATION ON CHASING BETWEEN T.V. (V) LOCATION & TEACHERS (V) OR T.V. LOCATION.
- 2. PROVIDE T.V. DESK SWITCHEL AT EACH CABINET. SECURE PER MANUFACTURER'S RECOMMENDATIONS.
- 3. LOCATION OF (M)-VIDEO DISTRIBUTION EQUIPMENT, (T)-TELEPHONE SYSTEM, (D)-DATA RACKS & (S)-SOUND SYSTEM (M/F).
- 4. LOCATION OF I.D.F. EQUIPMENT.
- 5. PROVIDE SINGLE GANG RECESSED BOX FOR DATA RACKS.
- 6. EXISTING 18" CABLE TRAY AS SHOWN.
- 7. PROVIDE NEW 24" CABLE TRAY TO CORRIDOR.
- 8. EXISTING 6000 WINDUOL. PROVIDE COVER PLATES AS REQUIRED.

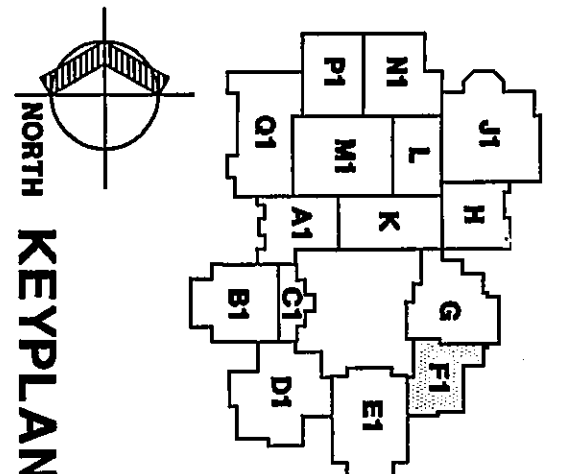

THE NEW
CHESTERTON HIGH SCHOOL
TECHNOLOGY PACKAGE
DUNELAND SCHOOL CORPORATION
CHESTERTON, INDIANA

COPYRIGHT 1999 BY FANNING/HOWEY ASSOCIATES, INC.

DOUGLAS M. WILSON
No. 3009
STATE OF INDIANA
ARCHITECT
D. WILSON

Fanning/Howey Associates, Inc.
Architects Engineers Consultants

TECHNOLOGY PLAN UNIT F1

DRAWN BY: JED COMM. NO.: 95067.00
CHECKED BY: RSB DATE: MAY 3, 1999

TE3.10

REVISIONS NO. DATE