



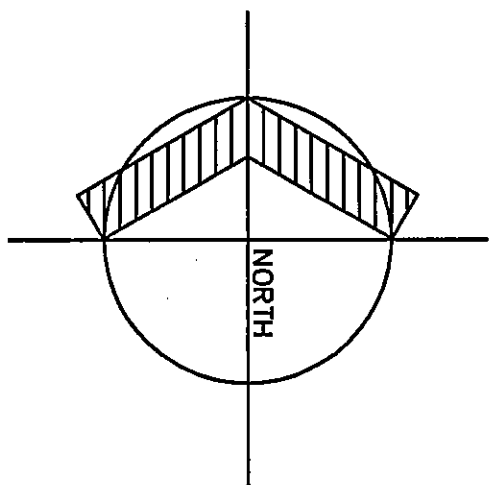

TECHNOLOGY PLAN UNIT F2

SCALE 1/8" = 1'-0"

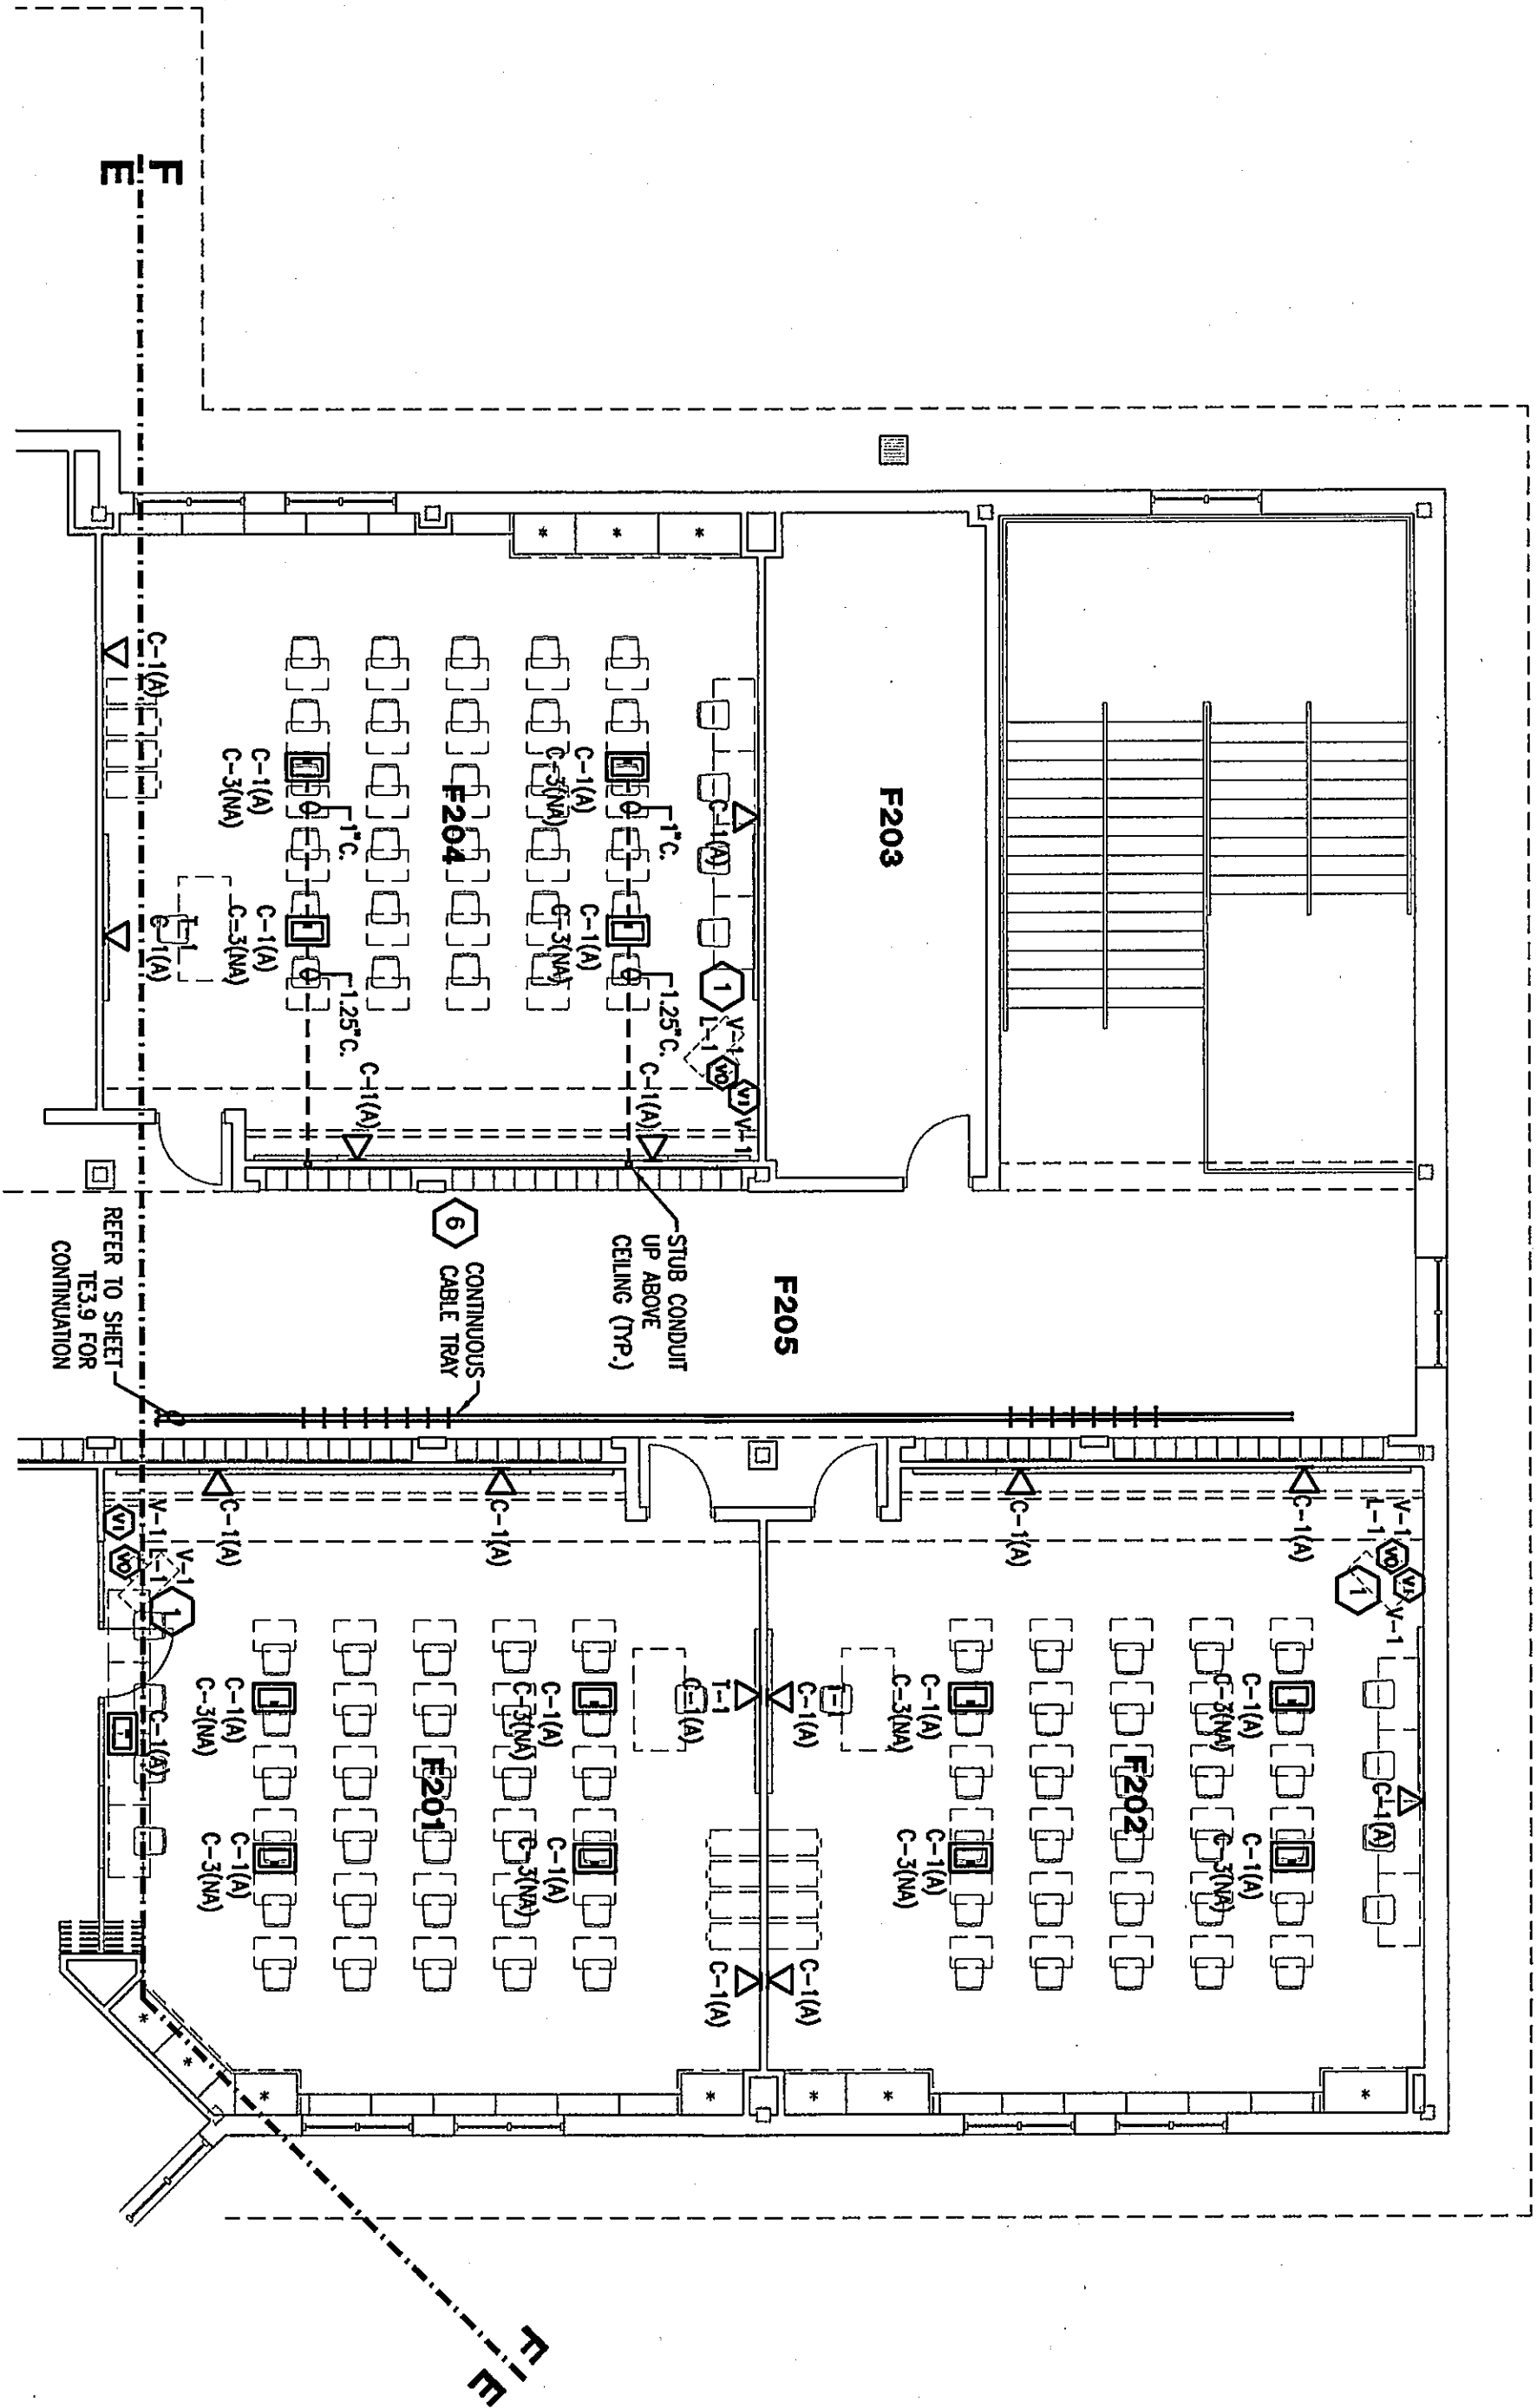

| ROOM LEGEND "F1" |           |           |                |
|------------------|-----------|-----------|----------------|
| ROOM NO.         | NAME      | AREA S.F. | CEILING HEIGHT |
| F201             | CLASSROOM | 980       | VARIES         |
| F202             | CLASSROOM | 342       | 9'-4"          |
| F203             | CLASSROOM | 972       | 9'-4"          |
| F204             | CLASSROOM | 823       | 10'-0"         |
| F205             | CORRIDOR  |           |                |


GENERAL PLAN NOTES:

- PACKING, JUNCTION BOXES, CABLE TRAYS ARE PROVIDED UNDER EXISTING BUILDING. ELECTRICAL CONNECTIONS UNLESS OTHERWISE NOTED ARE TO BE MADE BY THE CONTRACTOR.
- PROVIDE A BLANK COVER PLATE FOR ALL UNUSED JUNCTION BOXES.
- PROVIDE A BLANK INSERT FOR ALL UNUSED OPENINGS IN THE DATA/VOICE PLATES.


PLAN NOTES:

- SEE DETAIL 1.5 ON SHEET TE3.1 FOR INFORMATION ON CABLING BETWEEN T.V. (V) LOCATION & TEACHERS (W) OR T.V. LOCATION.
- PROVIDE T.V. DESK SWIVEL AT EACH CABINET. SECURE PER MANUFACTURER'S RECOMMENDATIONS.
- LOCATION OF V-WIND DISTRIBUTION EQUIPMENT, (T)-TELEPHONE SYSTEM, (D)-DATA RACKS & (S)-SOUND SYSTEM, (IMP) LOCATION OF I.D.E. EQUIPMENT.
- PROVIDE SINGLE GANG RECESSED BOX FOR DATA GROUPS.
- EXISTING 18" CABLE TRAY AS SHOWN.
- PROVIDE NEW 24" CABLE TRAY TO CORRIDOR.
- EXISTING 2400 WINDOOL. PROVIDE COVER PLATES AS REQUIRED.

THE NEW  
**CHESTERTON HIGH SCHOOL**  
TECHNOLOGY PACKAGE  
DUNELAND SCHOOL CORPORATION  
CHESTERTON, INDIANA

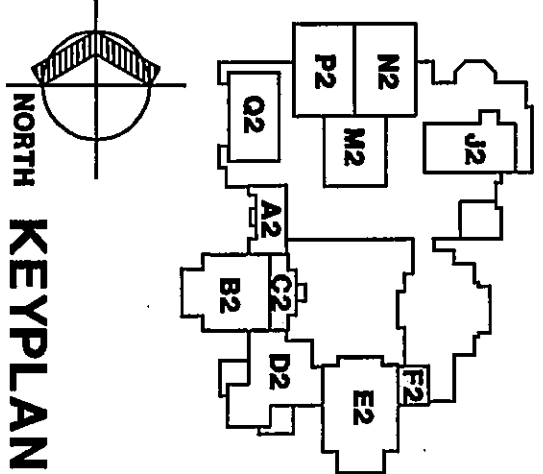

KEYPLAN

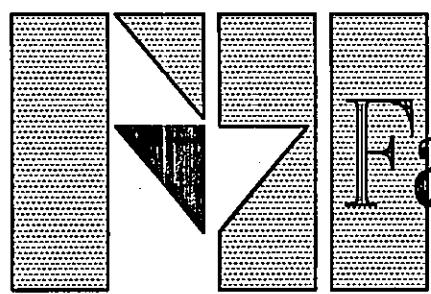

Architects Engineers Consultants


TECHNOLOGY PLAN UNIT F2

DRAWN BY: MRS. COMM. NO.: 95067.00  
CHECKED BY: RSB DATE: MAY 3, 1999

TE3.11

REVISIONS NO. DATE

COPYRIGHT 1999 BY FANNING/HOWEY ASSOCIATES, INC.

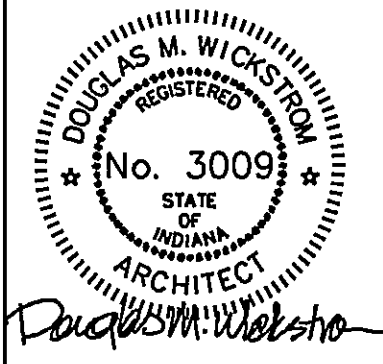

CHESTERTON HIGH SCHOOL  
95067.00

9/14/99