



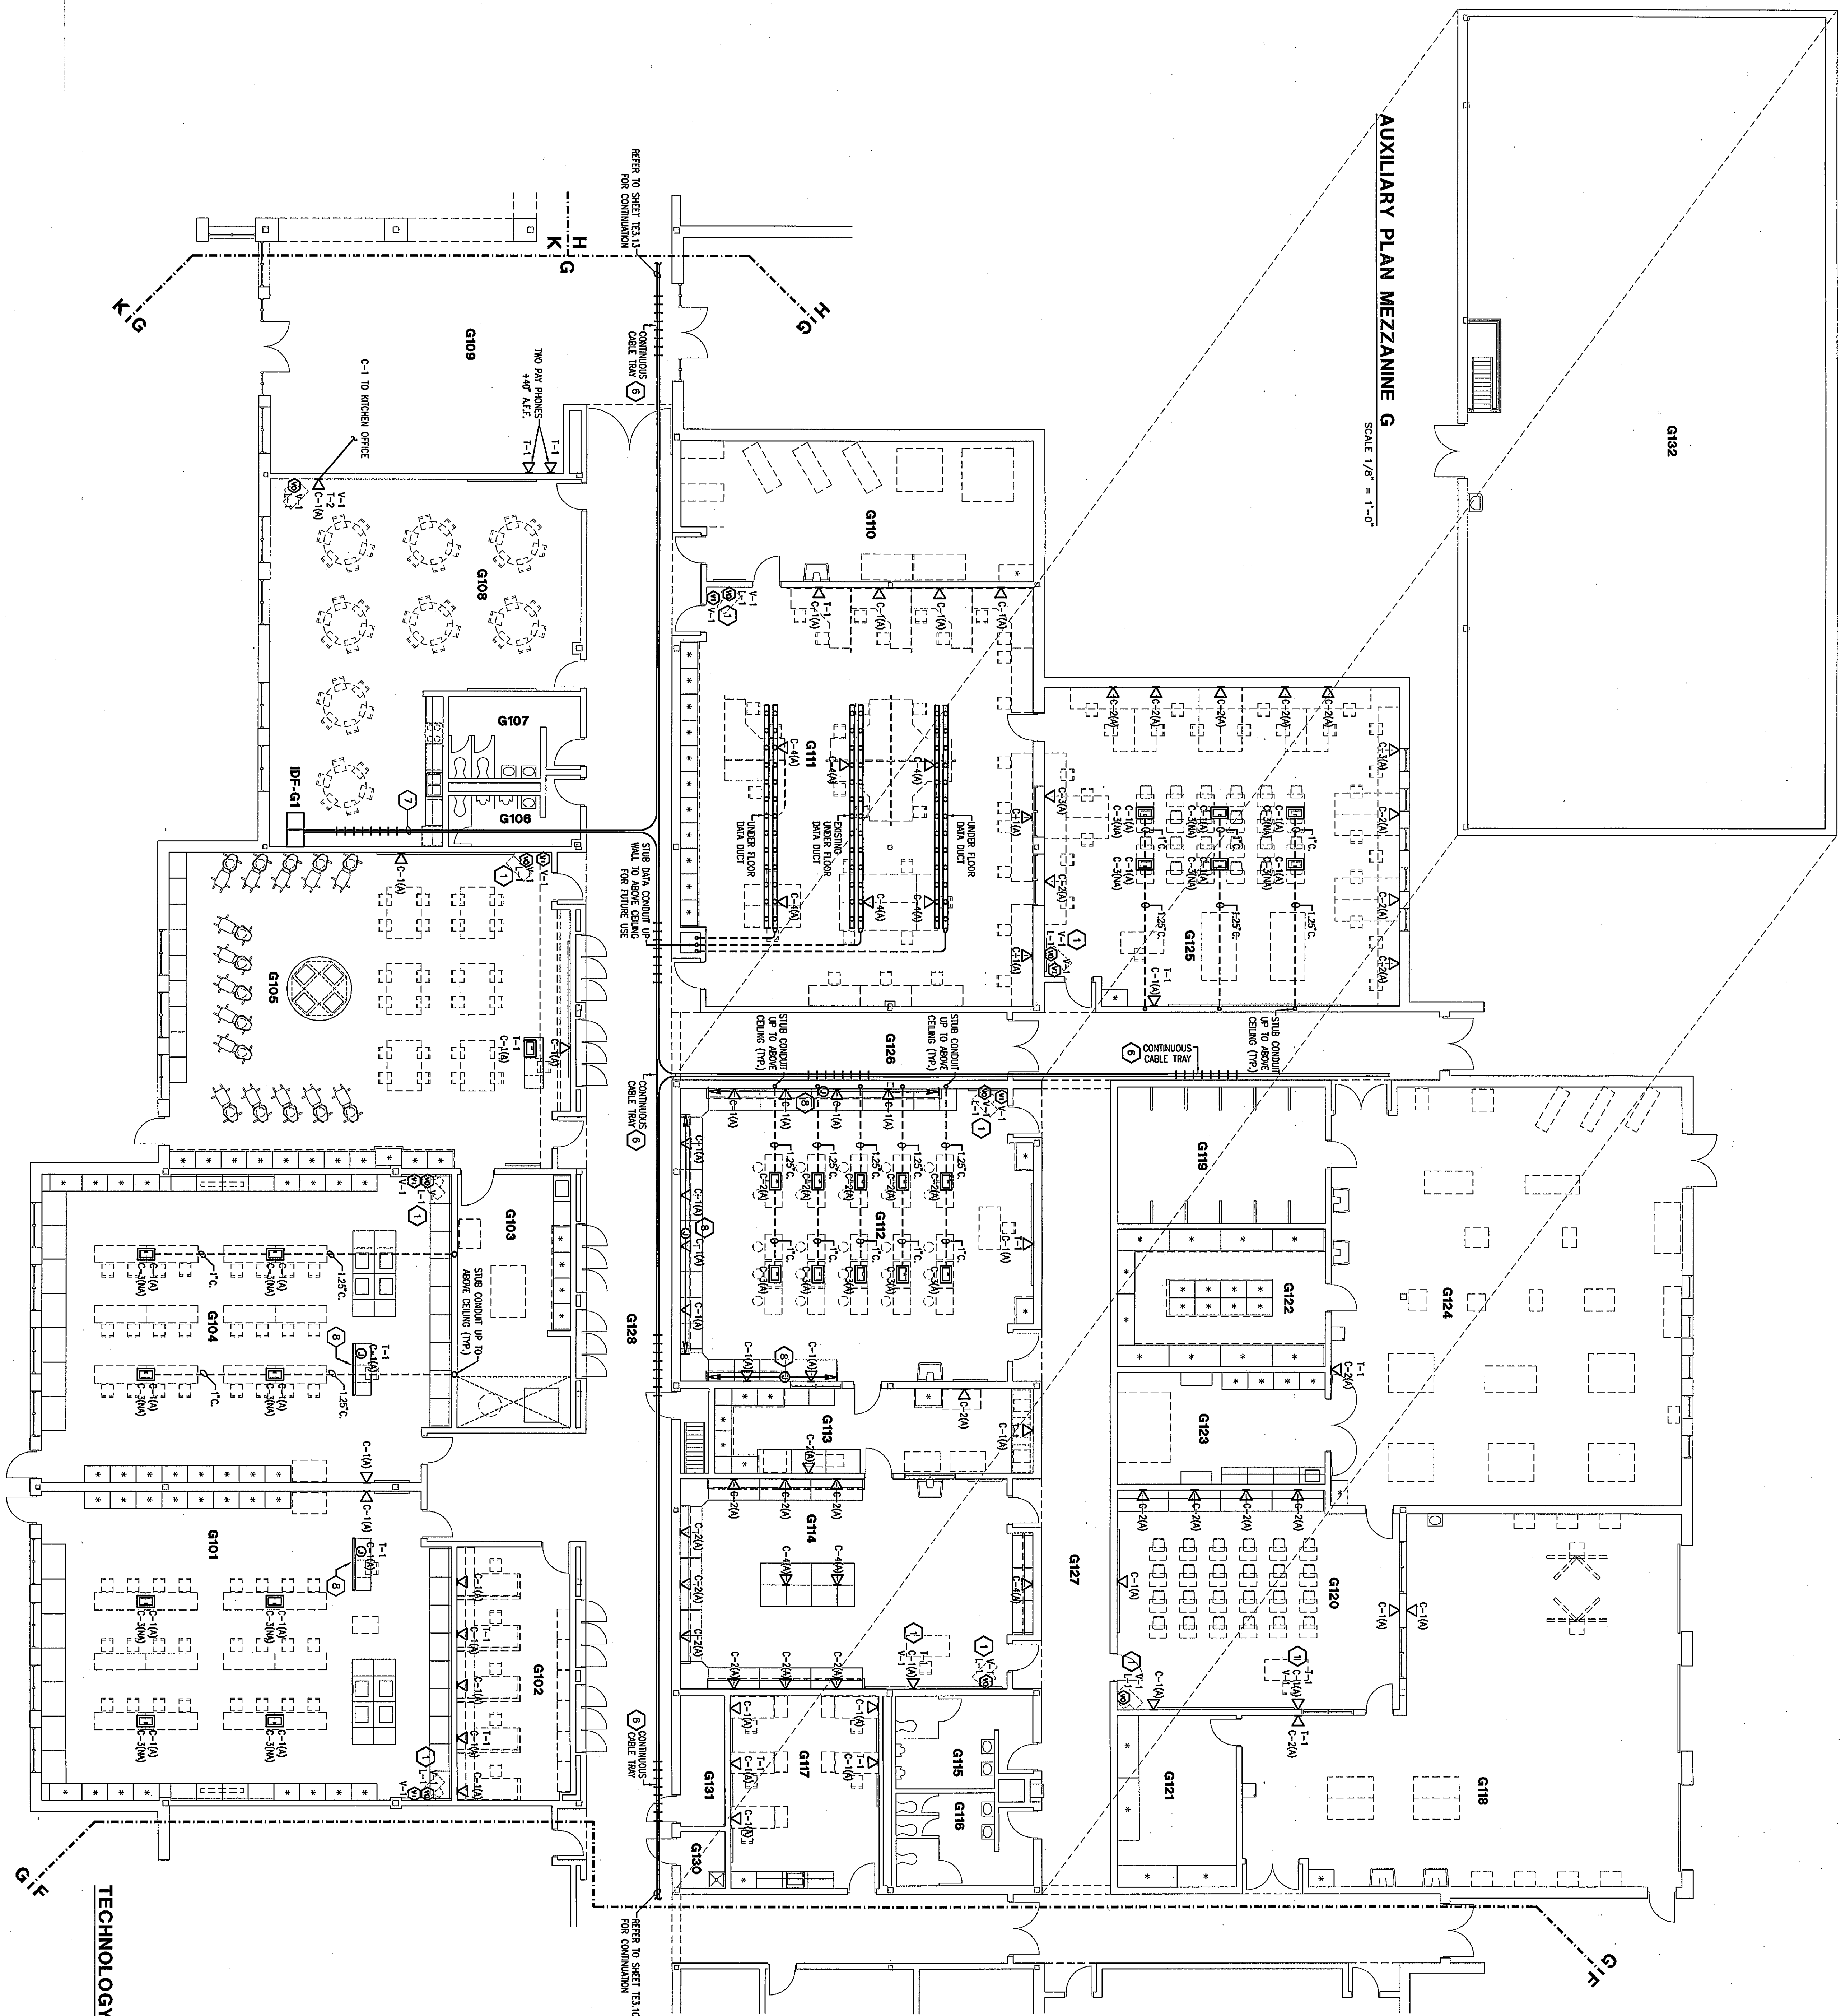

AUXILIARY PLAN MEZZANINE G
SCALE 1/8" = 1'-0"

TECHNOLOGY PLAN UNIT G

SCALE 1/8" = 1'-0"

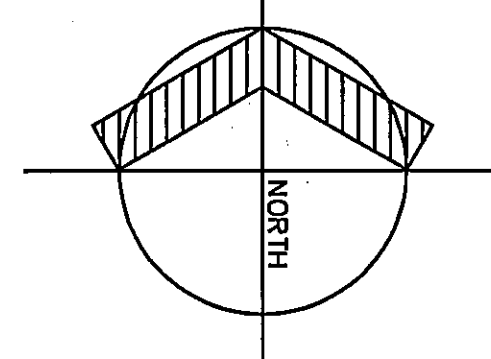


ROOM LEGEND "G"		
ROOM	AREA	CEILING
G101	20' x 20' LAB	9'-4"
G102	OFFICE	9'-4"
G103	KITCHEN	9'-4"
G104	RESTROOM	9'-4"
G105	MEANS TOILET	9'-4"
G106	MEANS TOILET	9'-4"
G107	STAFF DINING	9'-4"
G108	COMMONS	10'-0"
G109	COMMONS	10'-0"
G110	COMMONS	10'-0"
G111	COMMONS	10'-0"
G112	COMMONS	10'-0"
G113	COMMONS	10'-0"
G114	COMMONS	10'-0"
G115	COMMONS	10'-0"
G116	COMMONS	10'-0"
G117	COMMONS	10'-0"
G118	COMMONS	10'-0"
G119	COMMONS	10'-0"
G120	COMMONS	10'-0"
G121	COMMONS	10'-0"
G122	COMMONS	10'-0"
G123	COMMONS	10'-0"
G124	COMMONS	10'-0"
G125	COMMONS	10'-0"
G126	COMMONS	10'-0"
G127	COMMONS	10'-0"
G128	COMMONS	10'-0"
G129	COMMONS	10'-0"
G130	COMMONS	10'-0"
G131	COMMONS	10'-0"
G132	COMMONS	10'-0"
G133	COMMONS	10'-0"

- GENERAL PLAN NOTES:**
1. SEE DETAIL 12 ON SHEET TE3.1 FOR INFORMATION ON CEILING BETWEEN 12, (V) LOCATION & TOILETS (V) OR 1/2 LOCATION.
 2. PROVIDE 1/2" REBAR SPACING AT EACH CORNER, SECURE PER MANUFACTURER'S RECOMMENDATIONS.
 3. LOCATION OF (V)-WALL DISTRIBUTION EQUIPMENT, (T)-TELEPHONE SYSTEM, (D)-DATA RACKS & (S)-SOUND SYSTEM, (W)-LOCATION OF L.D.F. EQUIPMENT.
 4. PROVIDE SINGLE GANG RECESSED BOX FOR DATA DROPS.
 5. DESIGN 1/2" CABLE TRAY AS SHOWN.
 6. PROVIDE NEW 2" CABLE TRAY TO CORRIDOR.
 7. DESIGN CROWN MOLDING, PROVIDE COVER PLATES AS REQUIRED.
 8. PROVIDE A BLANK RESET FOR ALL UNUSED OPENINGS IN THE DRY/WALL FLOORS.

PLAN NOTES:

1. SEE DETAIL 12 ON SHEET TE3.1 FOR INFORMATION ON CEILING BETWEEN 12, (V) LOCATION & TOILETS (V) OR 1/2 LOCATION.
2. PROVIDE 1/2" REBAR SPACING AT EACH CORNER, SECURE PER MANUFACTURER'S RECOMMENDATIONS.
3. LOCATION OF (V)-WALL DISTRIBUTION EQUIPMENT, (T)-TELEPHONE SYSTEM, (D)-DATA RACKS & (S)-SOUND SYSTEM, (W)-LOCATION OF L.D.F. EQUIPMENT.
4. PROVIDE SINGLE GANG RECESSED BOX FOR DATA DROPS.
5. DESIGN 1/2" CABLE TRAY AS SHOWN.
6. PROVIDE NEW 2" CABLE TRAY TO CORRIDOR.
7. DESIGN CROWN MOLDING, PROVIDE COVER PLATES AS REQUIRED.
8. PROVIDE A BLANK RESET FOR ALL UNUSED OPENINGS IN THE DRY/WALL FLOORS.

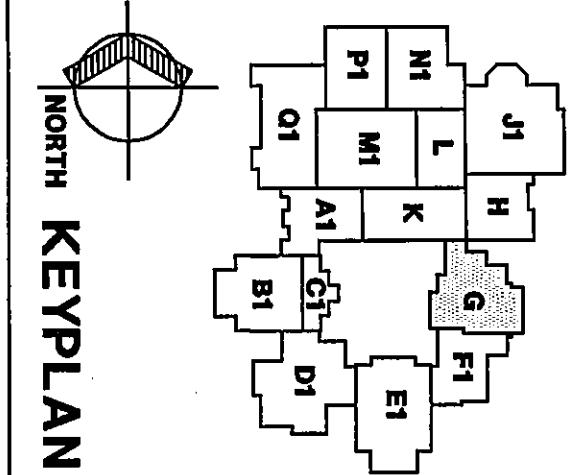

Fanning/Howey Associates, Inc.
Architects Engineers Consultants

TECHNOLOGY PLAN UNIT G	
DRAWN BY: JED	COMM. NO.: 95067.00
CHECKED BY: RSB	DATE: MAY 3, 1999
REVISIONS NO. DATE	
TE3.12	

THE NEW
CHESTERTON HIGH SCHOOL
TECHNOLOGY PACKAGE
DUNELAND SCHOOL CORPORATION
CHESTERTON, INDIANA

