


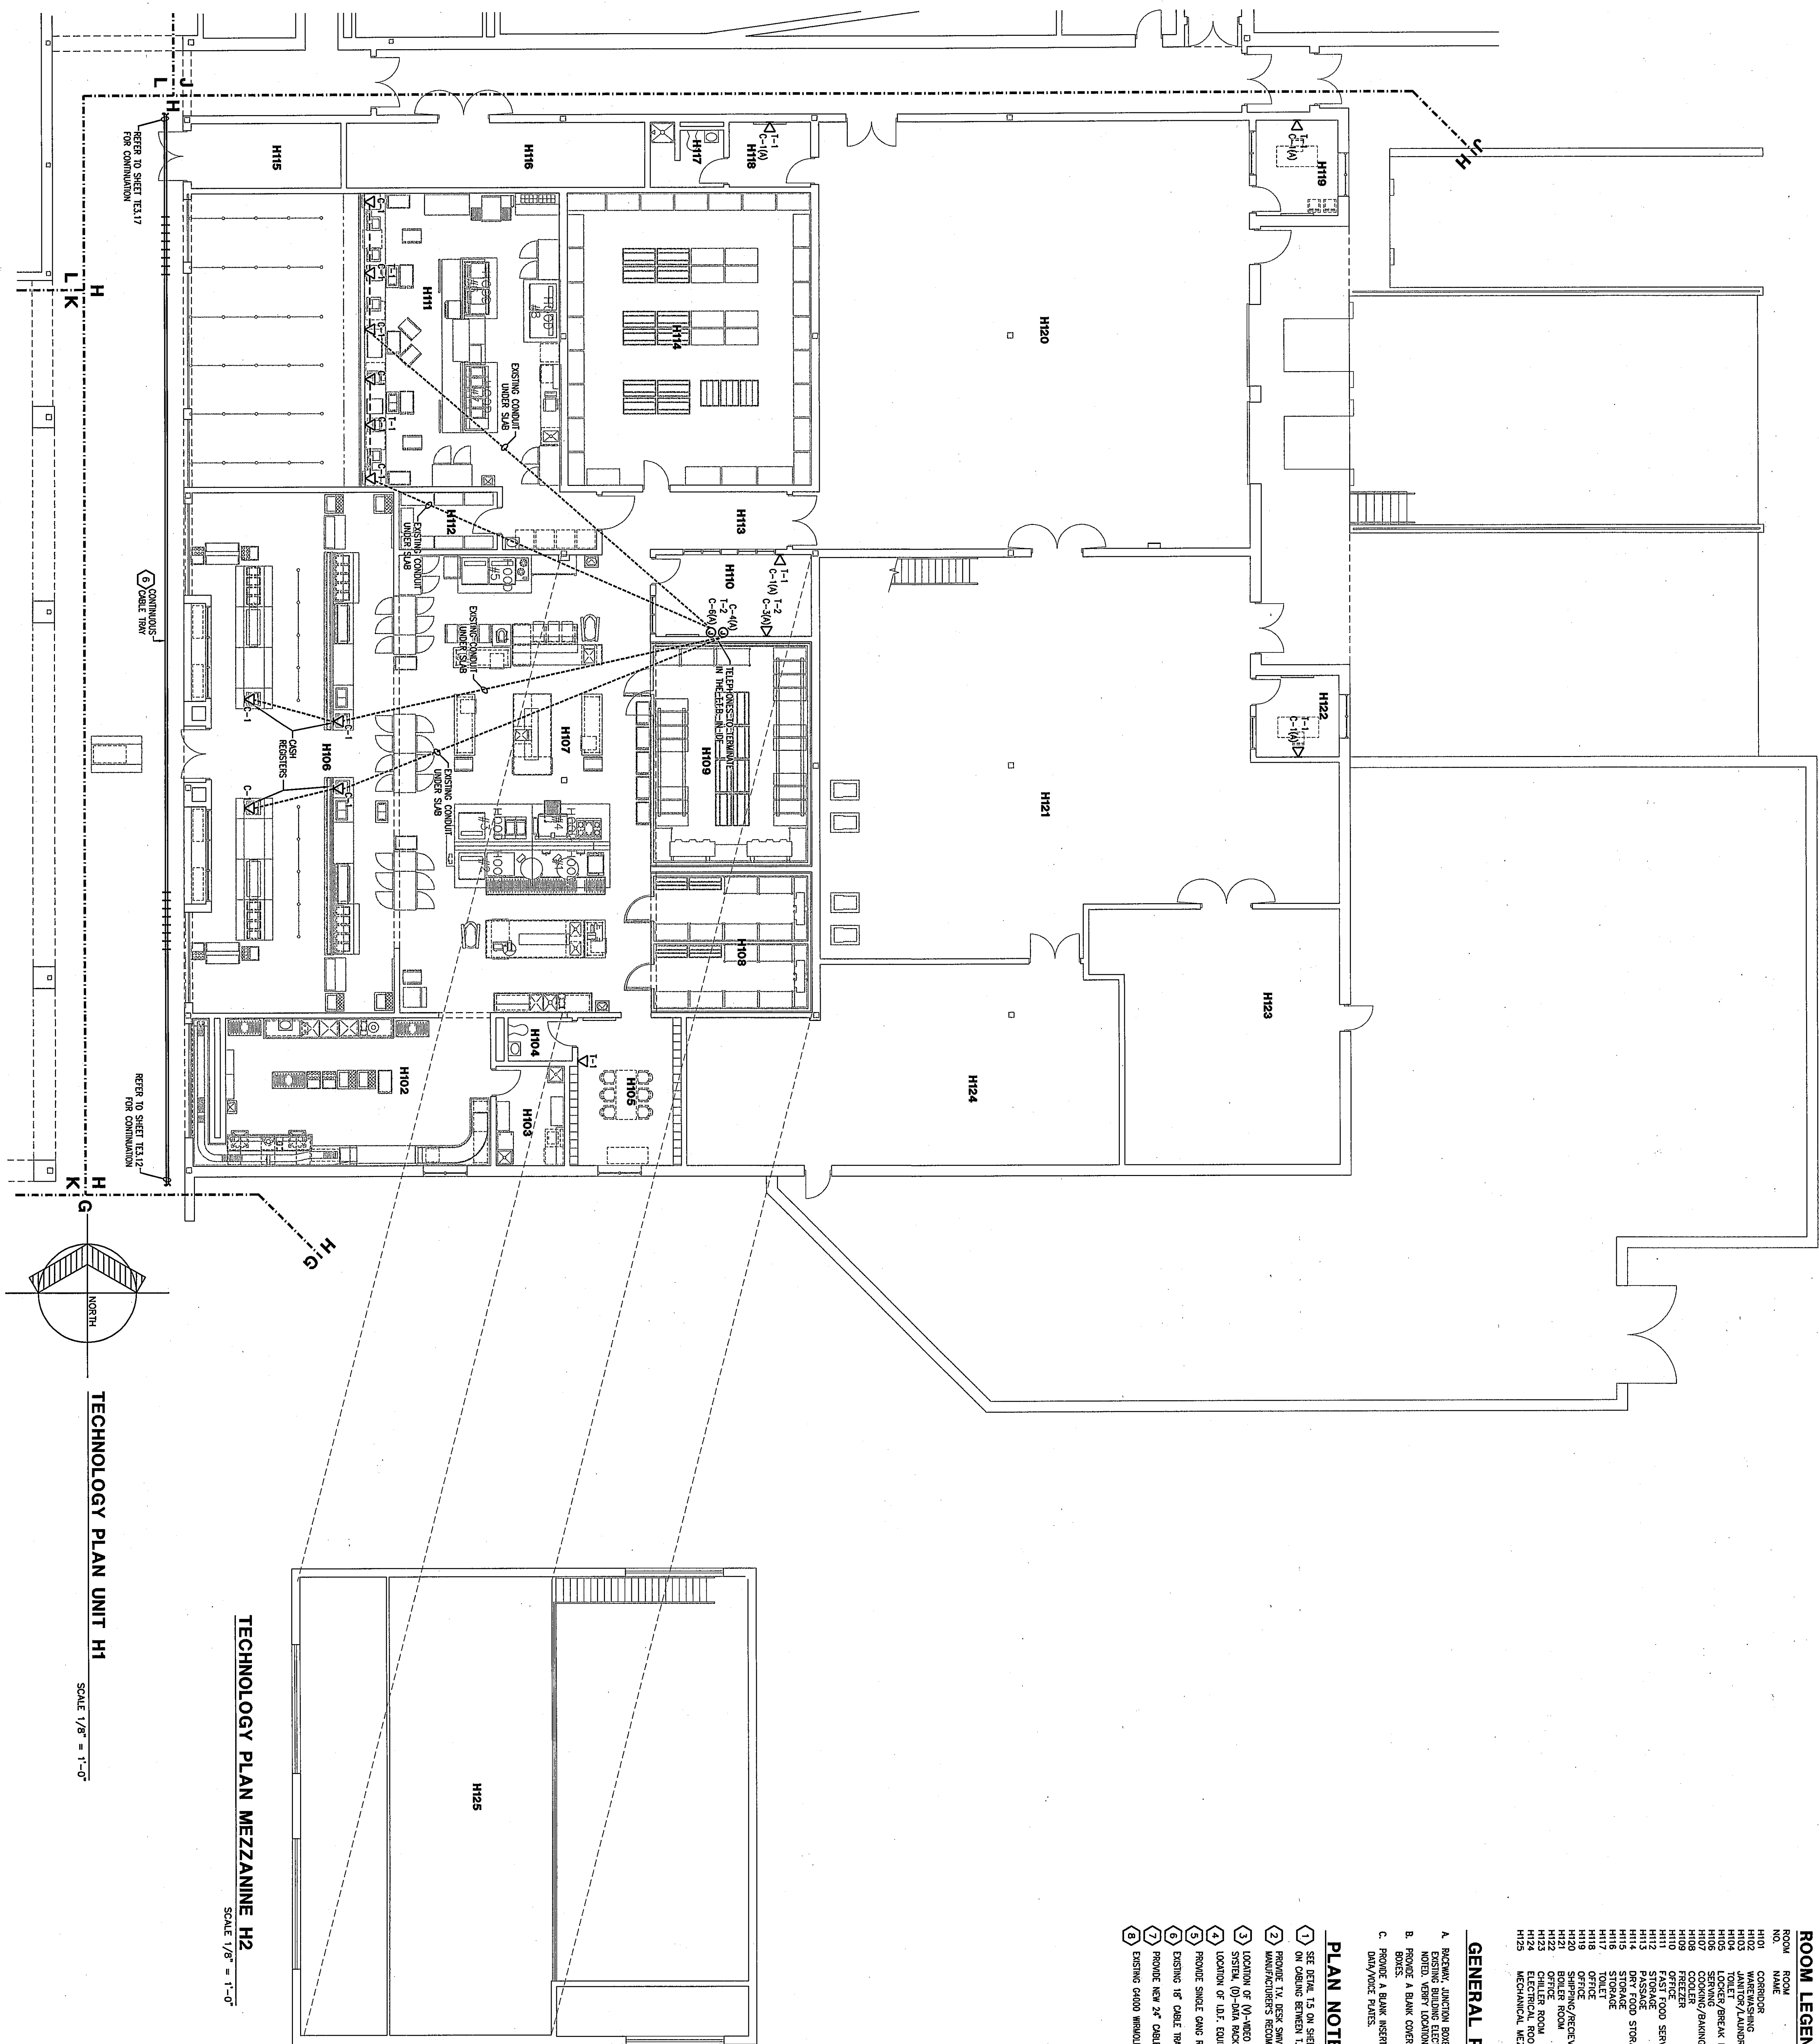

| ROOM LEGEND "H" |                   |           |                |
|-----------------|-------------------|-----------|----------------|
| ROOM NO.        | ROOM NAME         | AREA S.F. | CEILING HEIGHT |
| H101            | CORRIDOR          | 2240      | 10'-0"         |
| H102            | CORRIDOR          | 2240      | 10'-0"         |
| H103            | JANITOR/LAUNDRY   | 101       | 9'-4"          |
| H104            | TOILET/BREAK ROOM | 42        | 9'-4"          |
| H105            | TOILET/BREAK ROOM | 42        | 9'-4"          |
| H106            | TOILET/BREAK ROOM | 42        | 9'-4"          |
| H107            | TOILET/BREAK ROOM | 42        | 9'-4"          |
| H108            | TOILET/BREAK ROOM | 42        | 9'-4"          |
| H109            | TOILET/BREAK ROOM | 42        | 9'-4"          |
| H110            | TOILET/BREAK ROOM | 42        | 9'-4"          |
| H111            | TOILET/BREAK ROOM | 42        | 9'-4"          |
| H112            | TOILET/BREAK ROOM | 42        | 9'-4"          |
| H113            | TOILET/BREAK ROOM | 42        | 9'-4"          |
| H114            | TOILET/BREAK ROOM | 42        | 9'-4"          |
| H115            | TOILET/BREAK ROOM | 42        | 9'-4"          |
| H116            | TOILET/BREAK ROOM | 42        | 9'-4"          |
| H117            | TOILET/BREAK ROOM | 42        | 9'-4"          |
| H118            | TOILET/BREAK ROOM | 42        | 9'-4"          |
| H119            | TOILET/BREAK ROOM | 42        | 9'-4"          |
| H120            | TOILET/BREAK ROOM | 42        | 9'-4"          |
| H121            | TOILET/BREAK ROOM | 42        | 9'-4"          |
| H122            | TOILET/BREAK ROOM | 42        | 9'-4"          |
| H123            | TOILET/BREAK ROOM | 42        | 9'-4"          |
| H124            | TOILET/BREAK ROOM | 42        | 9'-4"          |
| H125            | TOILET/BREAK ROOM | 42        | 9'-4"          |


GENERAL PLAN NOTES:

- BACKLASH, JUNCTION BOXES, CABLE TRAYS ARE PROVIDED UNDER FLOOR.
- PROVIDE A BLANK COVER PLATE FOR ALL UNUSED JUNCTION BOXES.
- PROVIDE A BLANK INSERT FOR ALL UNUSED OPENINGS IN THE DRY/VOICE PLATES.

PLAN NOTES:

- SEE DETAIL T1 ON SHEET T11 FOR INFORMATION.
- ON CHASE BETWEEN T1, (W) LOCATION & T12, (W) OR T1/C LOCATION.
- PROVIDE T1, DESK SWIVEL AT EACH CHASE, SECURE PER MANUFACTURER'S RECOMMENDATIONS.
- LOCATION OF (V)-VIDEO DISTRIBUTION EQUIPMENT, (T)-TELEPHONE SYSTEM, (D)-DATA RACKS & (S)-SOUND SYSTEM (M/F).
- LOCATION OF L.D.F. EQUIPMENT.
- PROVIDE SINGLE GANG RECESSED BOX FOR DATA DROPS.
- EXISTING 18" CABLE TRAY AS SHOWN.
- PROVIDE NEW 24" CABLE TRAY TO CORRIDOR.
- EXISTING GROUND WINDLID, PROVIDE COVER PLATES AS REQUIRED.

THE NEW  
**CHESTERTON HIGH SCHOOL**  
TECHNOLOGY PACKAGE  
DUNELAND SCHOOL CORPORATION  
CHESTERTON, INDIANA

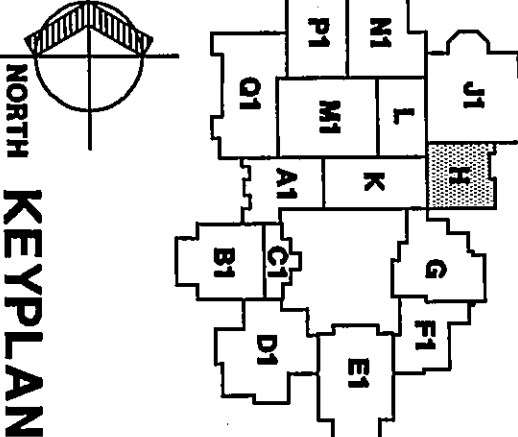

**Fanning/Howey**  
Associates, Inc.  
Architects Engineers Consultants

**TECHNOLOGY PLAN UNIT H1,H2**

DRAWN BY: MRS. RSB COMM. NO.: 95067.00  
CHECKED BY: DATE: MAY 3, 1999

REVISIONS NO. DATE

**TE3.13**

CHESTERTON HIGH SCHOOL  
95067.00

COPYRIGHT 1989 BY FANNING/HOWEY ASSOCIATES, INC.

REGISTERED PROFESSIONAL ARCHITECT  
No. 3009  
STATE OF INDIANA

*David M. Wick*