



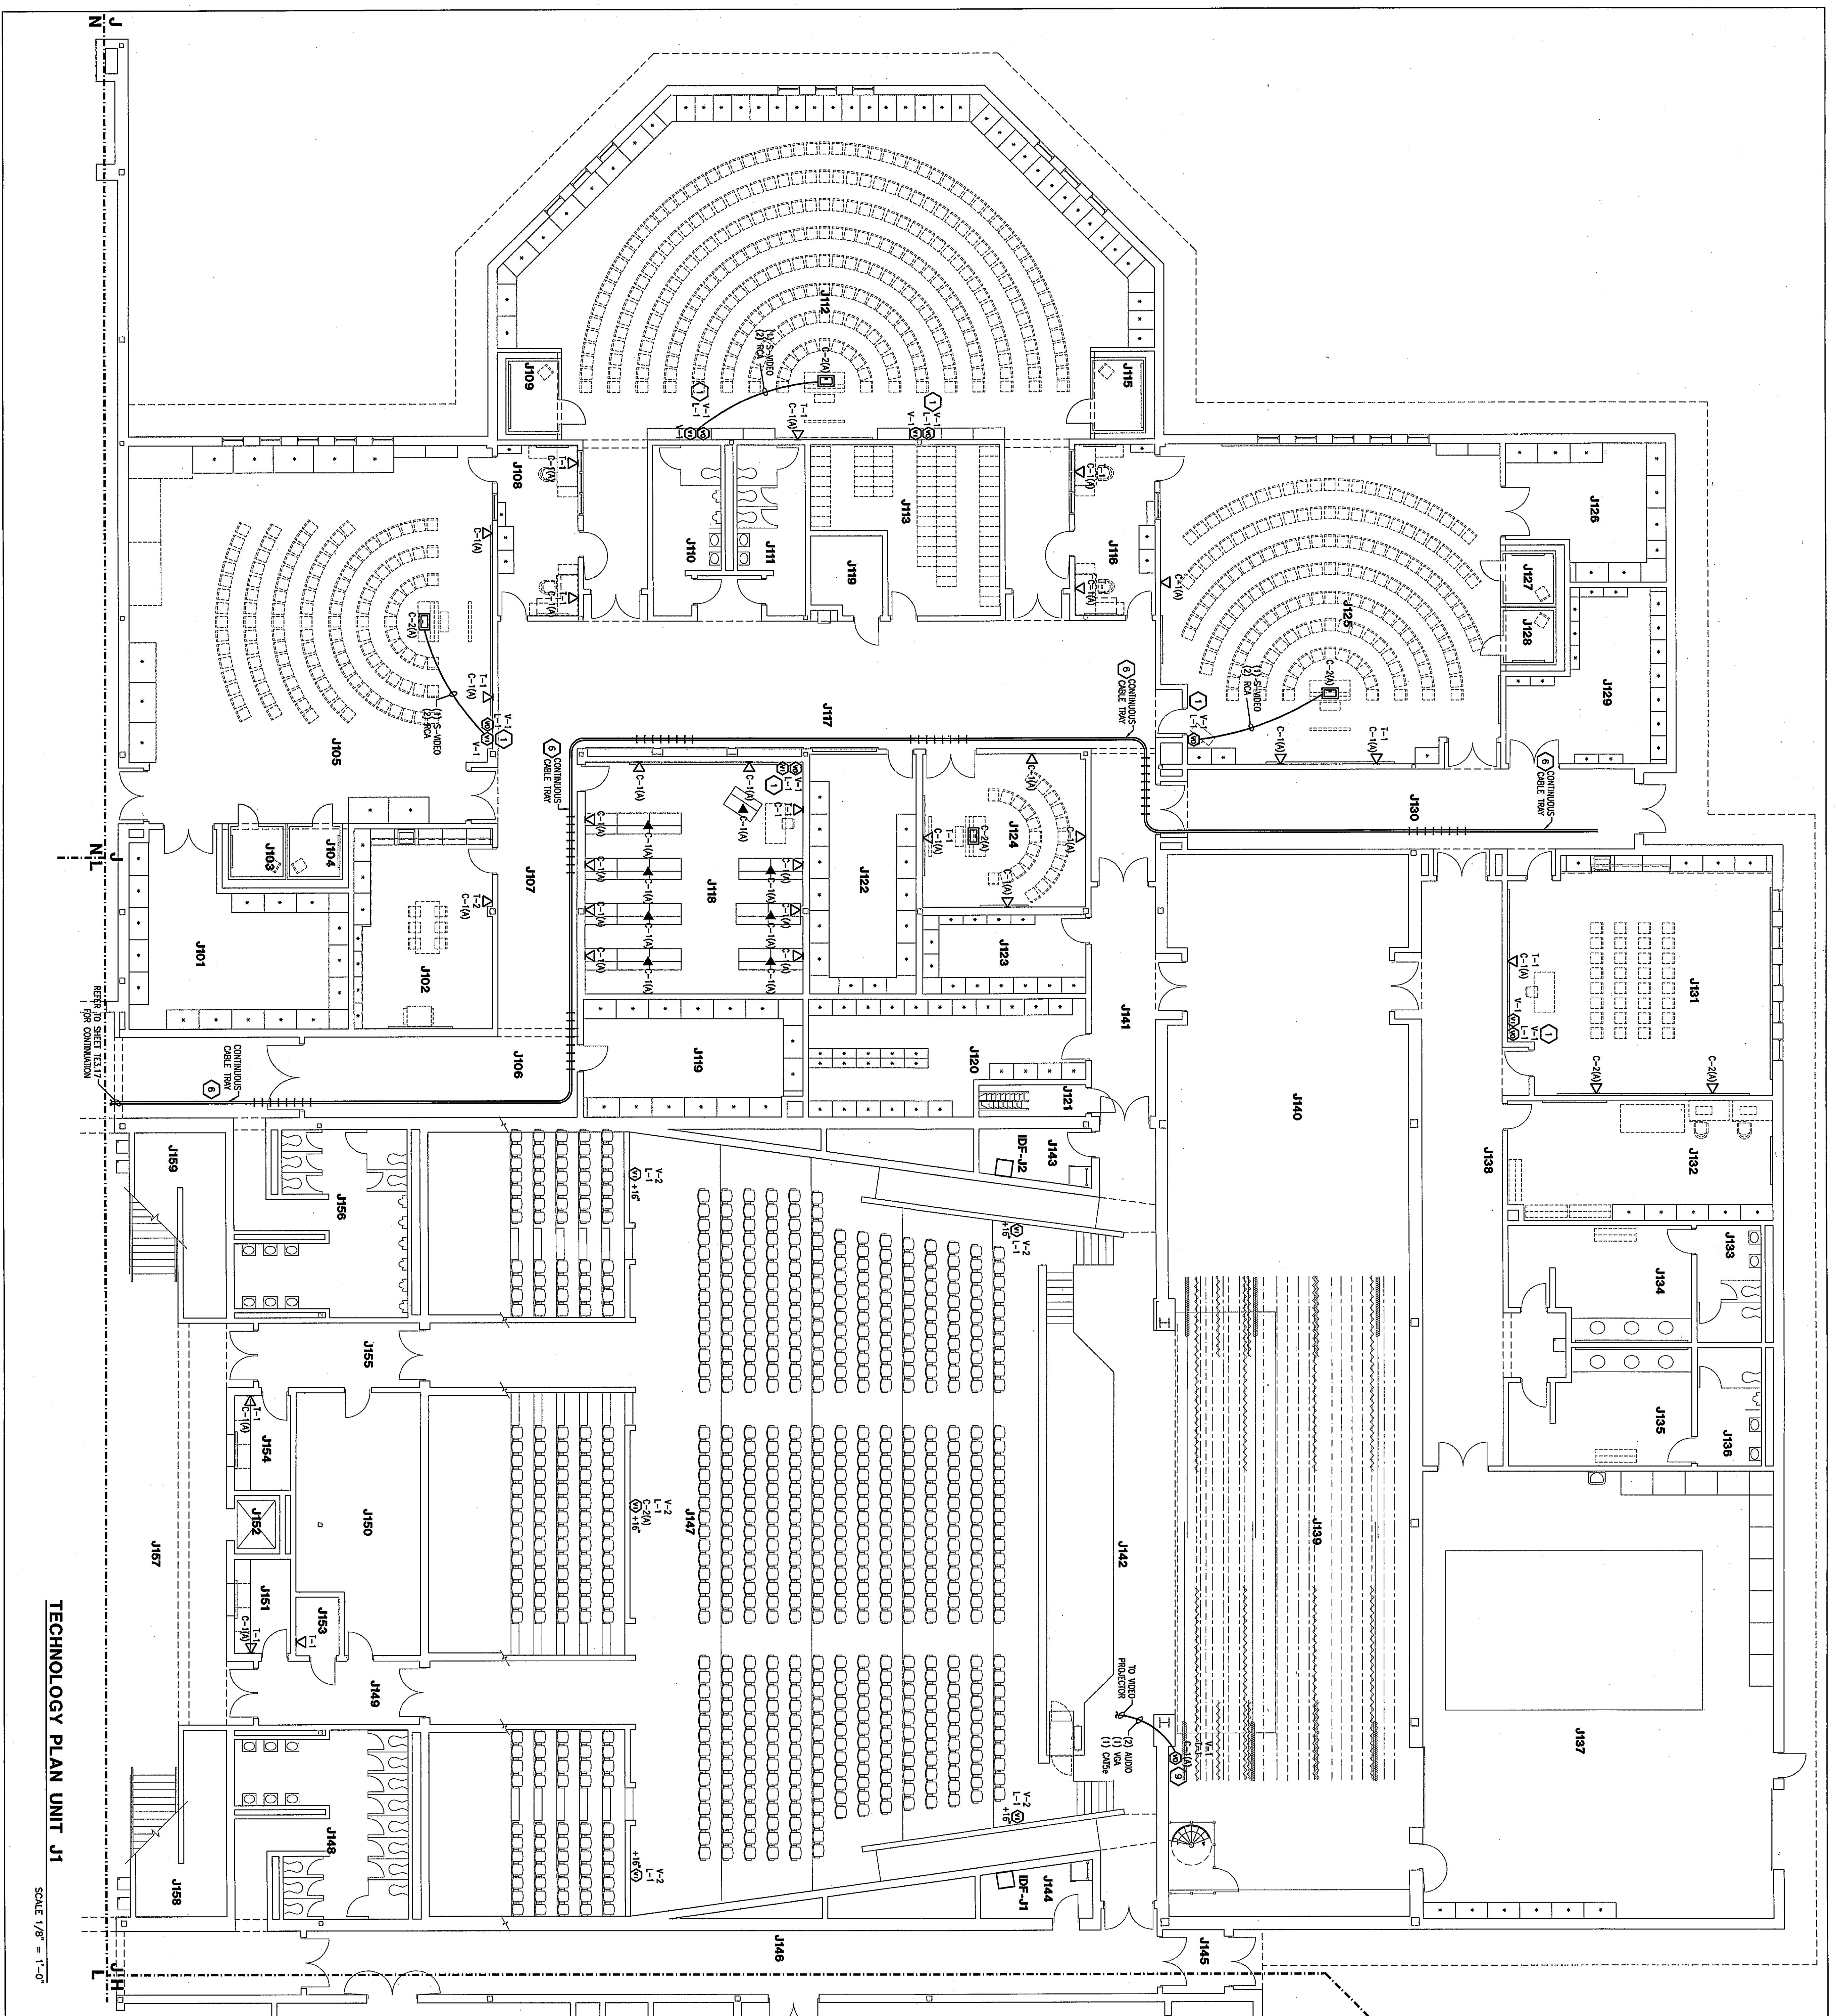

TECHNOLOGY PLAN UNIT J1

SCALE 1/8" = 1'-0"

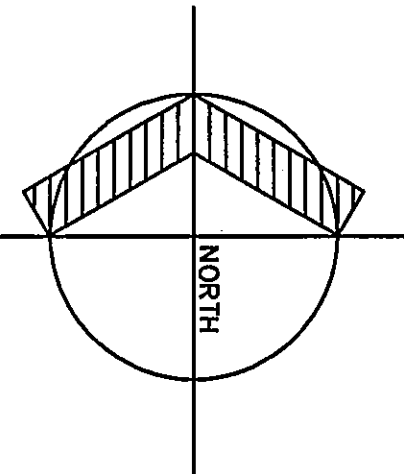

GENERAL PLAN NOTES:


- 1. SEE REVISIONS FOR ALL CHANGES.
- 2. PROVIDE 1/2" RISE GRATE AT EACH CABLE TRAY, SECURE FOR MANUFACTURER'S RECOMMENDATIONS.
- 3. LOCATION OF (V)-VIDEO DISTRIBUTION EQUIPMENT, (T)-TELEPHONE SYSTEM, (D)-DATA RACKS & (S)-SOUND SYSTEM (W&S).
- 4. PROVIDE SINGLE GANG RECESSED BOX FOR DATA PRODS.
- 5. DESIGN 1/2" CABLE TRAY AS SHOWN.
- 6. PROVIDE NEW 2" CABLE TRAY TO CORRIDOR.
- 7. DESIGN CABLE TRAY WITH 1/2" RISE GRATE.
- 8. PROVIDE NEW CABLE TRAY WITH 1/2" RISE GRATE.
- 9. PROVIDE NEW CABLE TRAY WITH 1/2" RISE GRATE.

PLAN NOTES:

- 1. SEE REVISIONS FOR ALL CHANGES.
- 2. PROVIDE 1/2" RISE GRATE AT EACH CABLE TRAY, SECURE FOR MANUFACTURER'S RECOMMENDATIONS.
- 3. LOCATION OF (V)-VIDEO DISTRIBUTION EQUIPMENT, (T)-TELEPHONE SYSTEM, (D)-DATA RACKS & (S)-SOUND SYSTEM (W&S).
- 4. PROVIDE SINGLE GANG RECESSED BOX FOR DATA PRODS.
- 5. DESIGN 1/2" CABLE TRAY AS SHOWN.
- 6. PROVIDE NEW 2" CABLE TRAY TO CORRIDOR.
- 7. DESIGN CABLE TRAY WITH 1/2" RISE GRATE.
- 8. PROVIDE NEW CABLE TRAY WITH 1/2" RISE GRATE.
- 9. PROVIDE NEW CABLE TRAY WITH 1/2" RISE GRATE.

ROOM LEGEND "J1"

ROOM NO.	ROOM NAME	AREA	CEILING	FLOOR
J101	RECEPTION STORAGE	250	9'-4"	9'-4"
J102	RECEPTION	250	9'-4"	9'-4"
J103	PRACTICE ROOM	63	10'-0"	10'-0"
J104	INSTRUMENT I	238	10'-0"	10'-0"
J105	OFFICE	213	9'-4"	9'-4"
J106	PRACTICE ROOM	160	9'-4"	9'-4"
J107	PRACTICE ROOM	160	9'-4"	9'-4"
J108	INSTRUMENT I	305	10'-0"	10'-0"
J109	PRACTICE ROOM	63	10'-0"	10'-0"
J110	RECEPTION	250	9'-4"	9'-4"
J111	RECEPTION	250	9'-4"	9'-4"
J112	RECEPTION	250	9'-4"	9'-4"
J113	RECEPTION	250	9'-4"	9'-4"
J114	RECEPTION	250	9'-4"	9'-4"
J115	RECEPTION	250	9'-4"	9'-4"
J116	RECEPTION	250	9'-4"	9'-4"
J117	RECEPTION	250	9'-4"	9'-4"
J118	RECEPTION	250	9'-4"	9'-4"
J119	RECEPTION	250	9'-4"	9'-4"
J120	RECEPTION	250	9'-4"	9'-4"
J121	RECEPTION	250	9'-4"	9'-4"
J122	RECEPTION	250	9'-4"	9'-4"
J123	RECEPTION	250	9'-4"	9'-4"
J124	RECEPTION	250	9'-4"	9'-4"
J125	RECEPTION	250	9'-4"	9'-4"
J126	RECEPTION	250	9'-4"	9'-4"
J127	RECEPTION	250	9'-4"	9'-4"
J128	RECEPTION	250	9'-4"	9'-4"
J129	RECEPTION	250	9'-4"	9'-4"
J130	RECEPTION	250	9'-4"	9'-4"
J131	RECEPTION	250	9'-4"	9'-4"
J132	RECEPTION	250	9'-4"	9'-4"
J133	RECEPTION	250	9'-4"	9'-4"
J134	RECEPTION	250	9'-4"	9'-4"
J135	RECEPTION	250	9'-4"	9'-4"
J136	RECEPTION	250	9'-4"	9'-4"
J137	RECEPTION	250	9'-4"	9'-4"
J138	RECEPTION	250	9'-4"	9'-4"
J139	RECEPTION	250	9'-4"	9'-4"
J140	RECEPTION	250	9'-4"	9'-4"
J141	RECEPTION	250	9'-4"	9'-4"
J142	RECEPTION	250	9'-4"	9'-4"
J143	RECEPTION	250	9'-4"	9'-4"
J144	RECEPTION	250	9'-4"	9'-4"
J145	RECEPTION	250	9'-4"	9'-4"
J146	RECEPTION	250	9'-4"	9'-4"
J147	RECEPTION	250	9'-4"	9'-4"
J148	RECEPTION	250	9'-4"	9'-4"
J149	RECEPTION	250	9'-4"	9'-4"
J150	RECEPTION	250	9'-4"	9'-4"
J151	RECEPTION	250	9'-4"	9'-4"
J152	RECEPTION	250	9'-4"	9'-4"
J153	RECEPTION	250	9'-4"	9'-4"
J154	RECEPTION	250	9'-4"	9'-4"
J155	RECEPTION	250	9'-4"	9'-4"
J156	RECEPTION	250	9'-4"	9'-4"
J157	RECEPTION	250	9'-4"	9'-4"
J158	RECEPTION	250	9'-4"	9'-4"
J159	RECEPTION	250	9'-4"	9'-4"

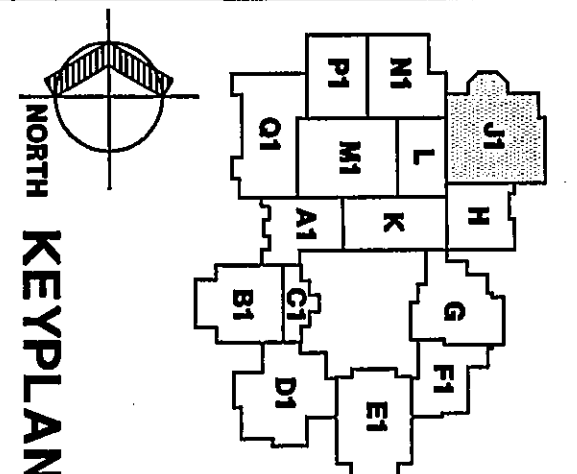

TECHNOLOGY PLAN UNIT J1

DRAWN BY: JED COMM. NO.: 95067.00
CHECKED BY: RSB DATE: MAY 3, 1999

REVISIONS NO. DATE

TE3.14

Fanning/Howey Associates, Inc.
Architects Engineers Consultants

THE NEW
CHESTERTON HIGH SCHOOL
TECHNOLOGY PACKAGE

DUNELAND SCHOOL CORPORATION
CHESTERTON, INDIANA

COPYRIGHT 1999 BY FANNING/HOWEY ASSOCIATES, INC.

REGISTERED PROFESSIONAL ARCHITECT
No. 3009
STATE OF INDIANA
D. Fanning/Howey