


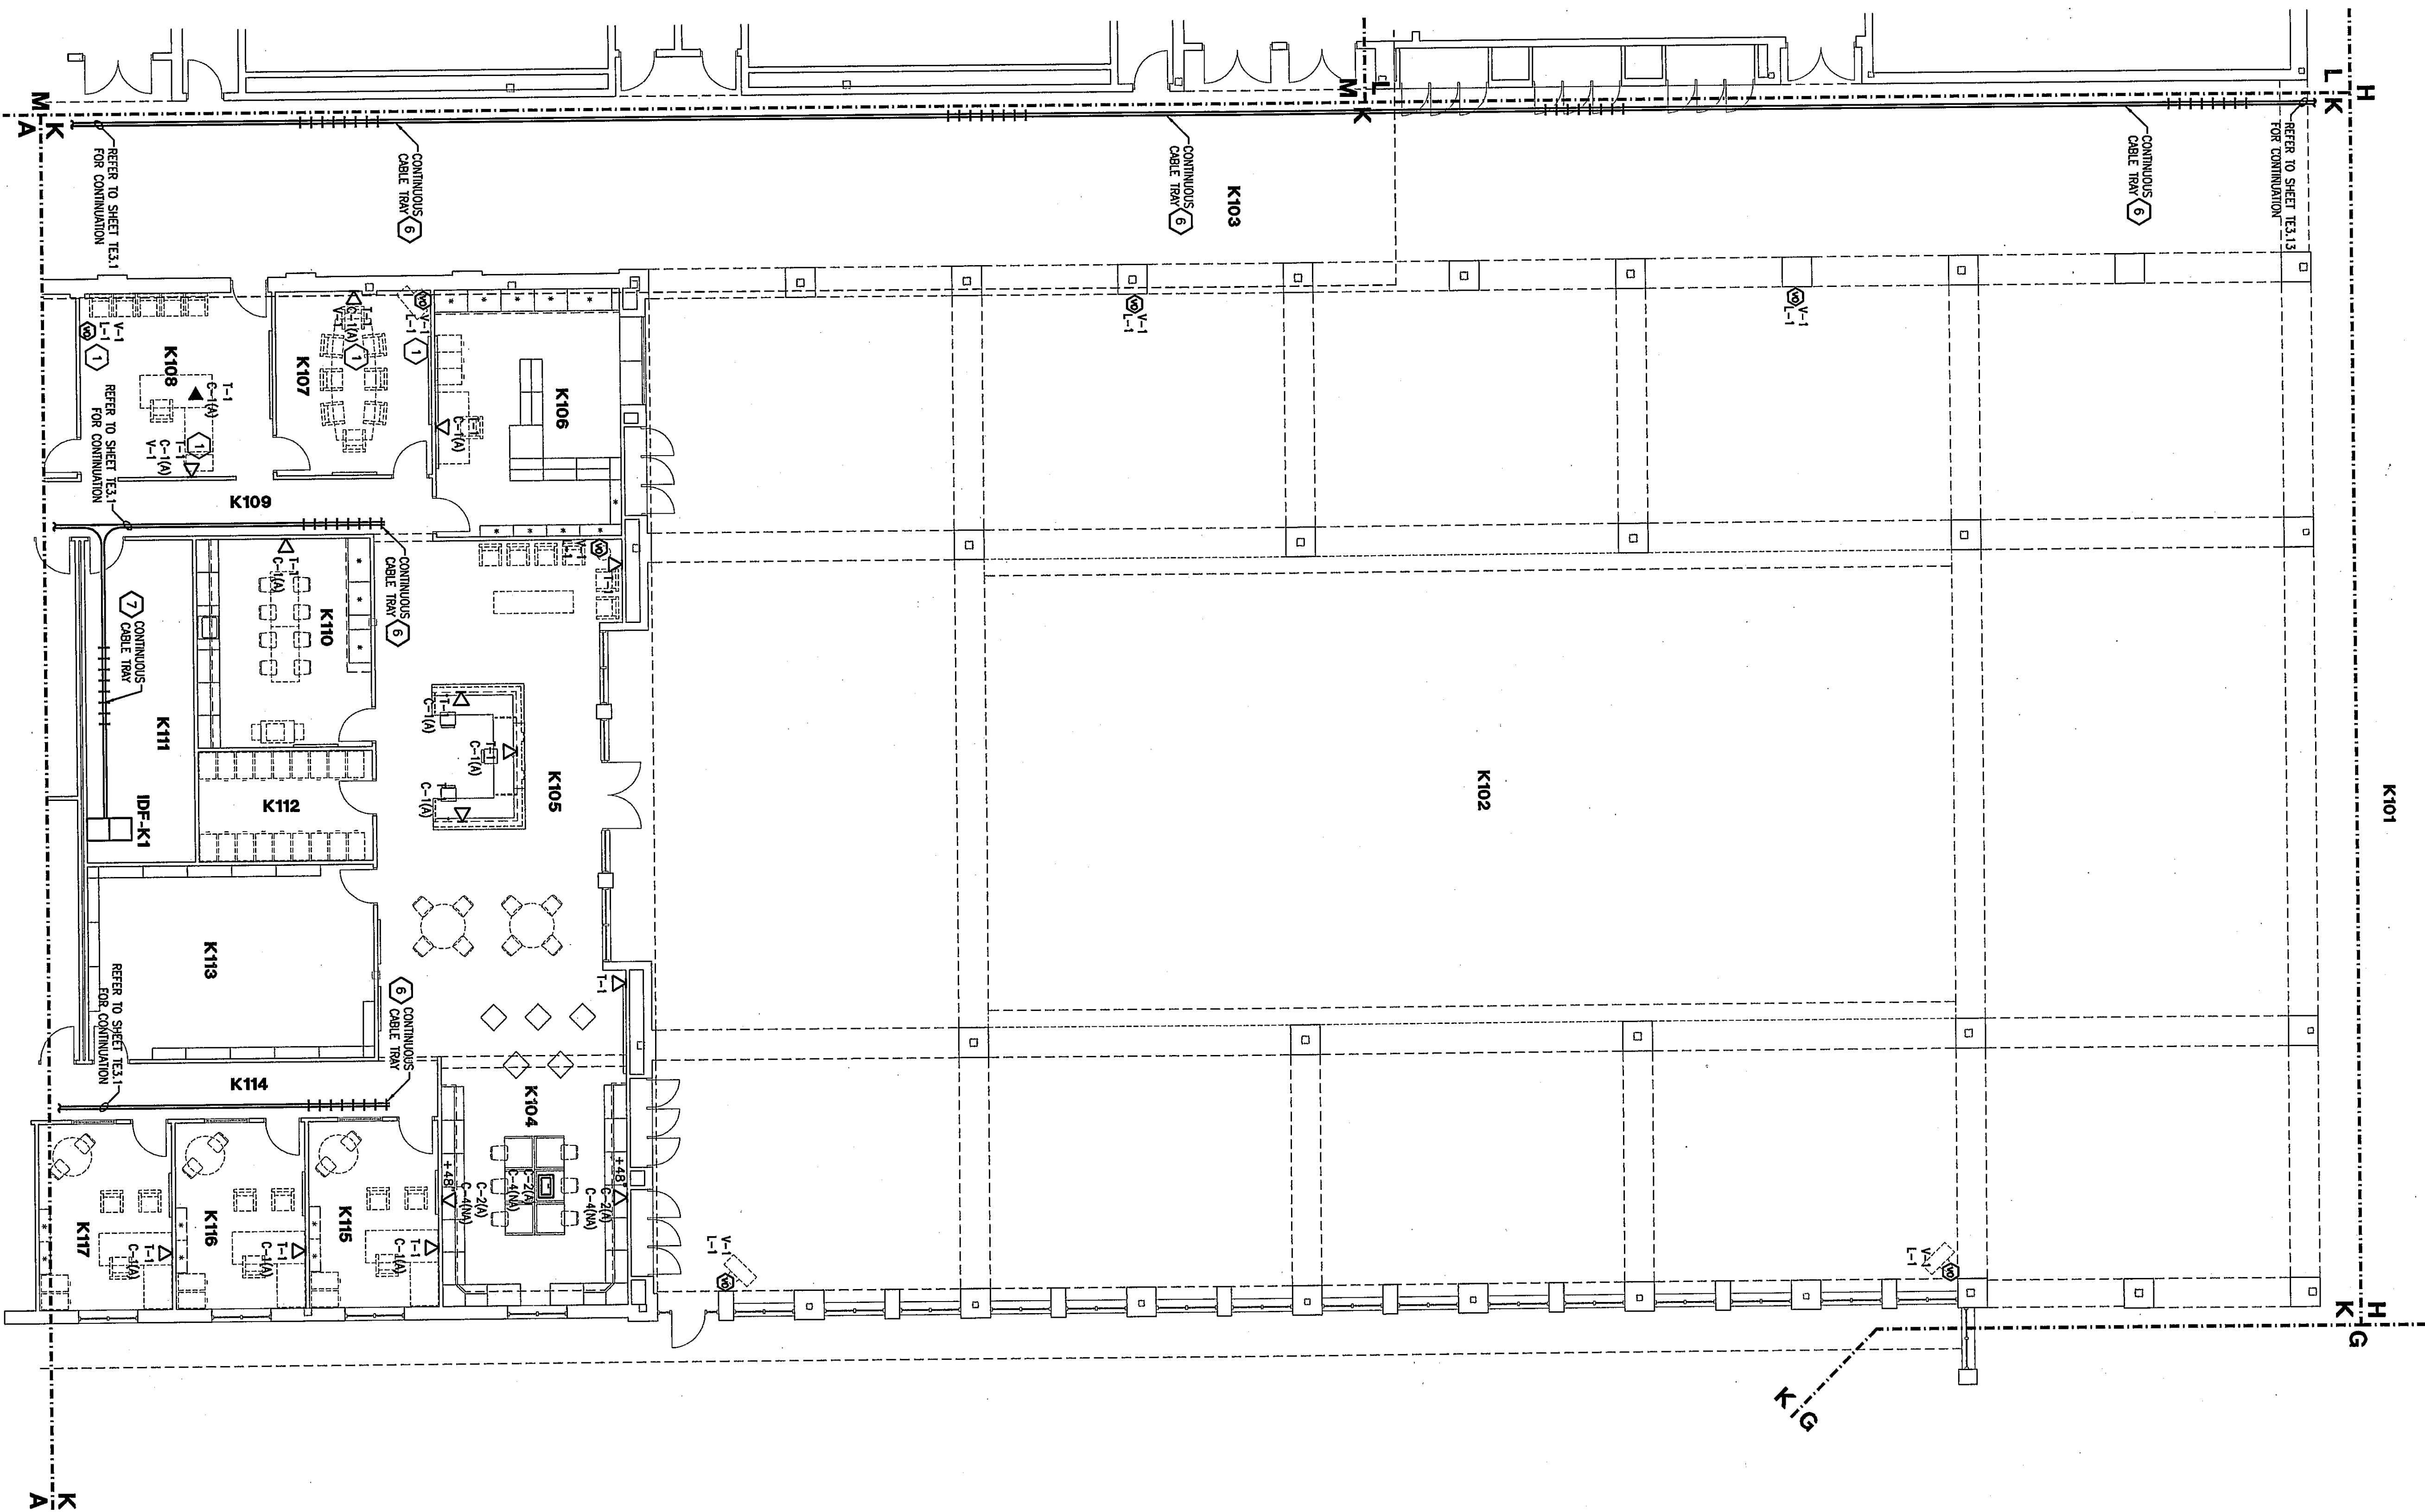

TECHNOLOGY PLAN UNIT K

SCALE 1/8" = 1'-0"


ROOM LEGEND "K"			
ROOM NO.	ROOM NAME	SQ. FT.	CEILING HEIGHT
K101	NOT USED		
K102	STUDENT DINING	13466	9'-4"
K103	CORRIDOR / CARRIER CENTER	3251	9'-4"
K104	RECEPTIONIST	981	9'-4"
K105	BOOKSTORE	2732	9'-4"
K106	BOOKSTORE	2732	9'-4"
K107	SECRETARY	2885	9'-4"
K108	STORAGE	446	9'-4"
K109	STORAGE	155	9'-4"
K110	STORAGE	155	9'-4"
K111	STORAGE	155	9'-4"
K112	STORAGE	155	9'-4"
K113	STORAGE	155	9'-4"
K114	STORAGE	155	9'-4"
K115	STORAGE	155	9'-4"
K116	STORAGE	155	9'-4"
K117	STORAGE	155	9'-4"

GENERAL PLAN NOTES:

- BACKWALL, JUNCTION BOXES, CABLE TRAYS ARE PROVIDED UNDER EXISTING BUILDING ELECTRICAL CONTRACTOR UNLESS OTHERWISE NOTED. VERIFY LOCATION IN FIELD.
- PROVIDE A BLANK COVER PLATE FOR ALL UNUSED JUNCTION BOXES.
- PROVIDE A BLANK INSERT FOR ALL UNUSED OPENINGS IN THE DATA/VOICE PLATES.

PLAN NOTES:

- SEE DETAIL T-5 ON SHEET T-1 FOR INFORMATION ON CABLEING BETWEEN T-1, (V) LOCATION & T-5 (V) OR T-7/C LOCATION.
- PROVIDE T-1, DESK SIMUL, AT EACH CABLE, SECURE PER MANUFACTURER'S RECOMMENDATIONS.
- LOCATION OF (V)-JACK DISTRIBUTION EQUIPMENT, (T)-TELEPHONE SYSTEM, (D)-DATA RACKS & (S)-SOUND SYSTEM, (W)-LOCATION OF T-1, EQUIPMENT.
- PROVIDE SINGLE GANG RECESSED BOX FOR DATA RACKS.
- EXISTING 18" CABLE TRAY AS SHOWN.
- PROVIDE NEW 24" CABLE TRAY TO CORRIDOR.
- EXISTING GROUND WIRING, PROVIDE COVER PLATES AS REQUIRED.

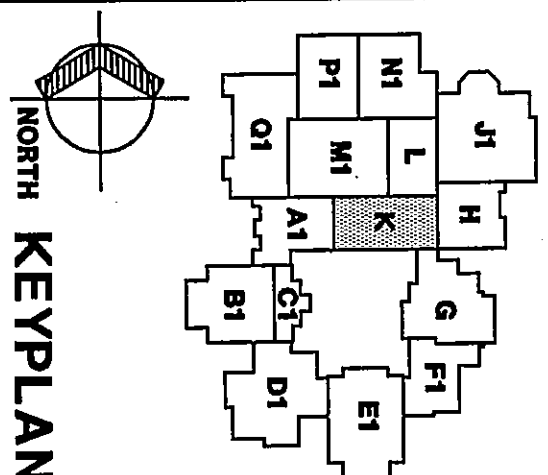

KEYPLAN

THE NEW
CHESTERTON HIGH SCHOOL
TECHNOLOGY PACKAGE
DUNELAND SCHOOL CORPORATION
CHESTERTON, INDIANA

COPYRIGHT 1999 BY FANNING/HOWEY ASSOCIATES, INC.

REGISTERED
No. 3009
ARCHITECTS
ENGINEERS
CONSULTANTS

David M. Howey

Fanning/Howey Associates, Inc.
Architects Engineers Consultants

TECHNOLOGY PLAN UNIT K

DRAWN BY: JED COMM. NO.: 95067.00
CHECKED BY: RSB DATE: MAY 3, 1999

REVISIONS NO. DATE

TE3.16

CHESTERTON HIGH SCHOOL
95067.00