
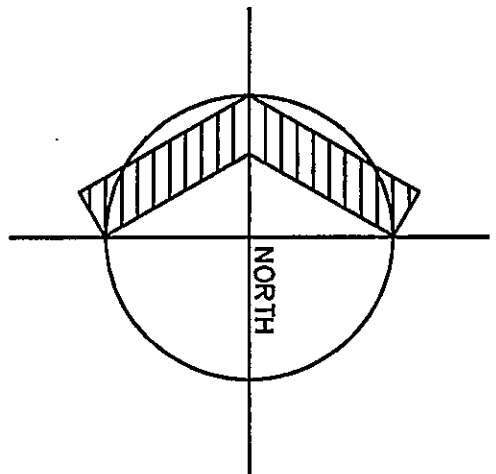


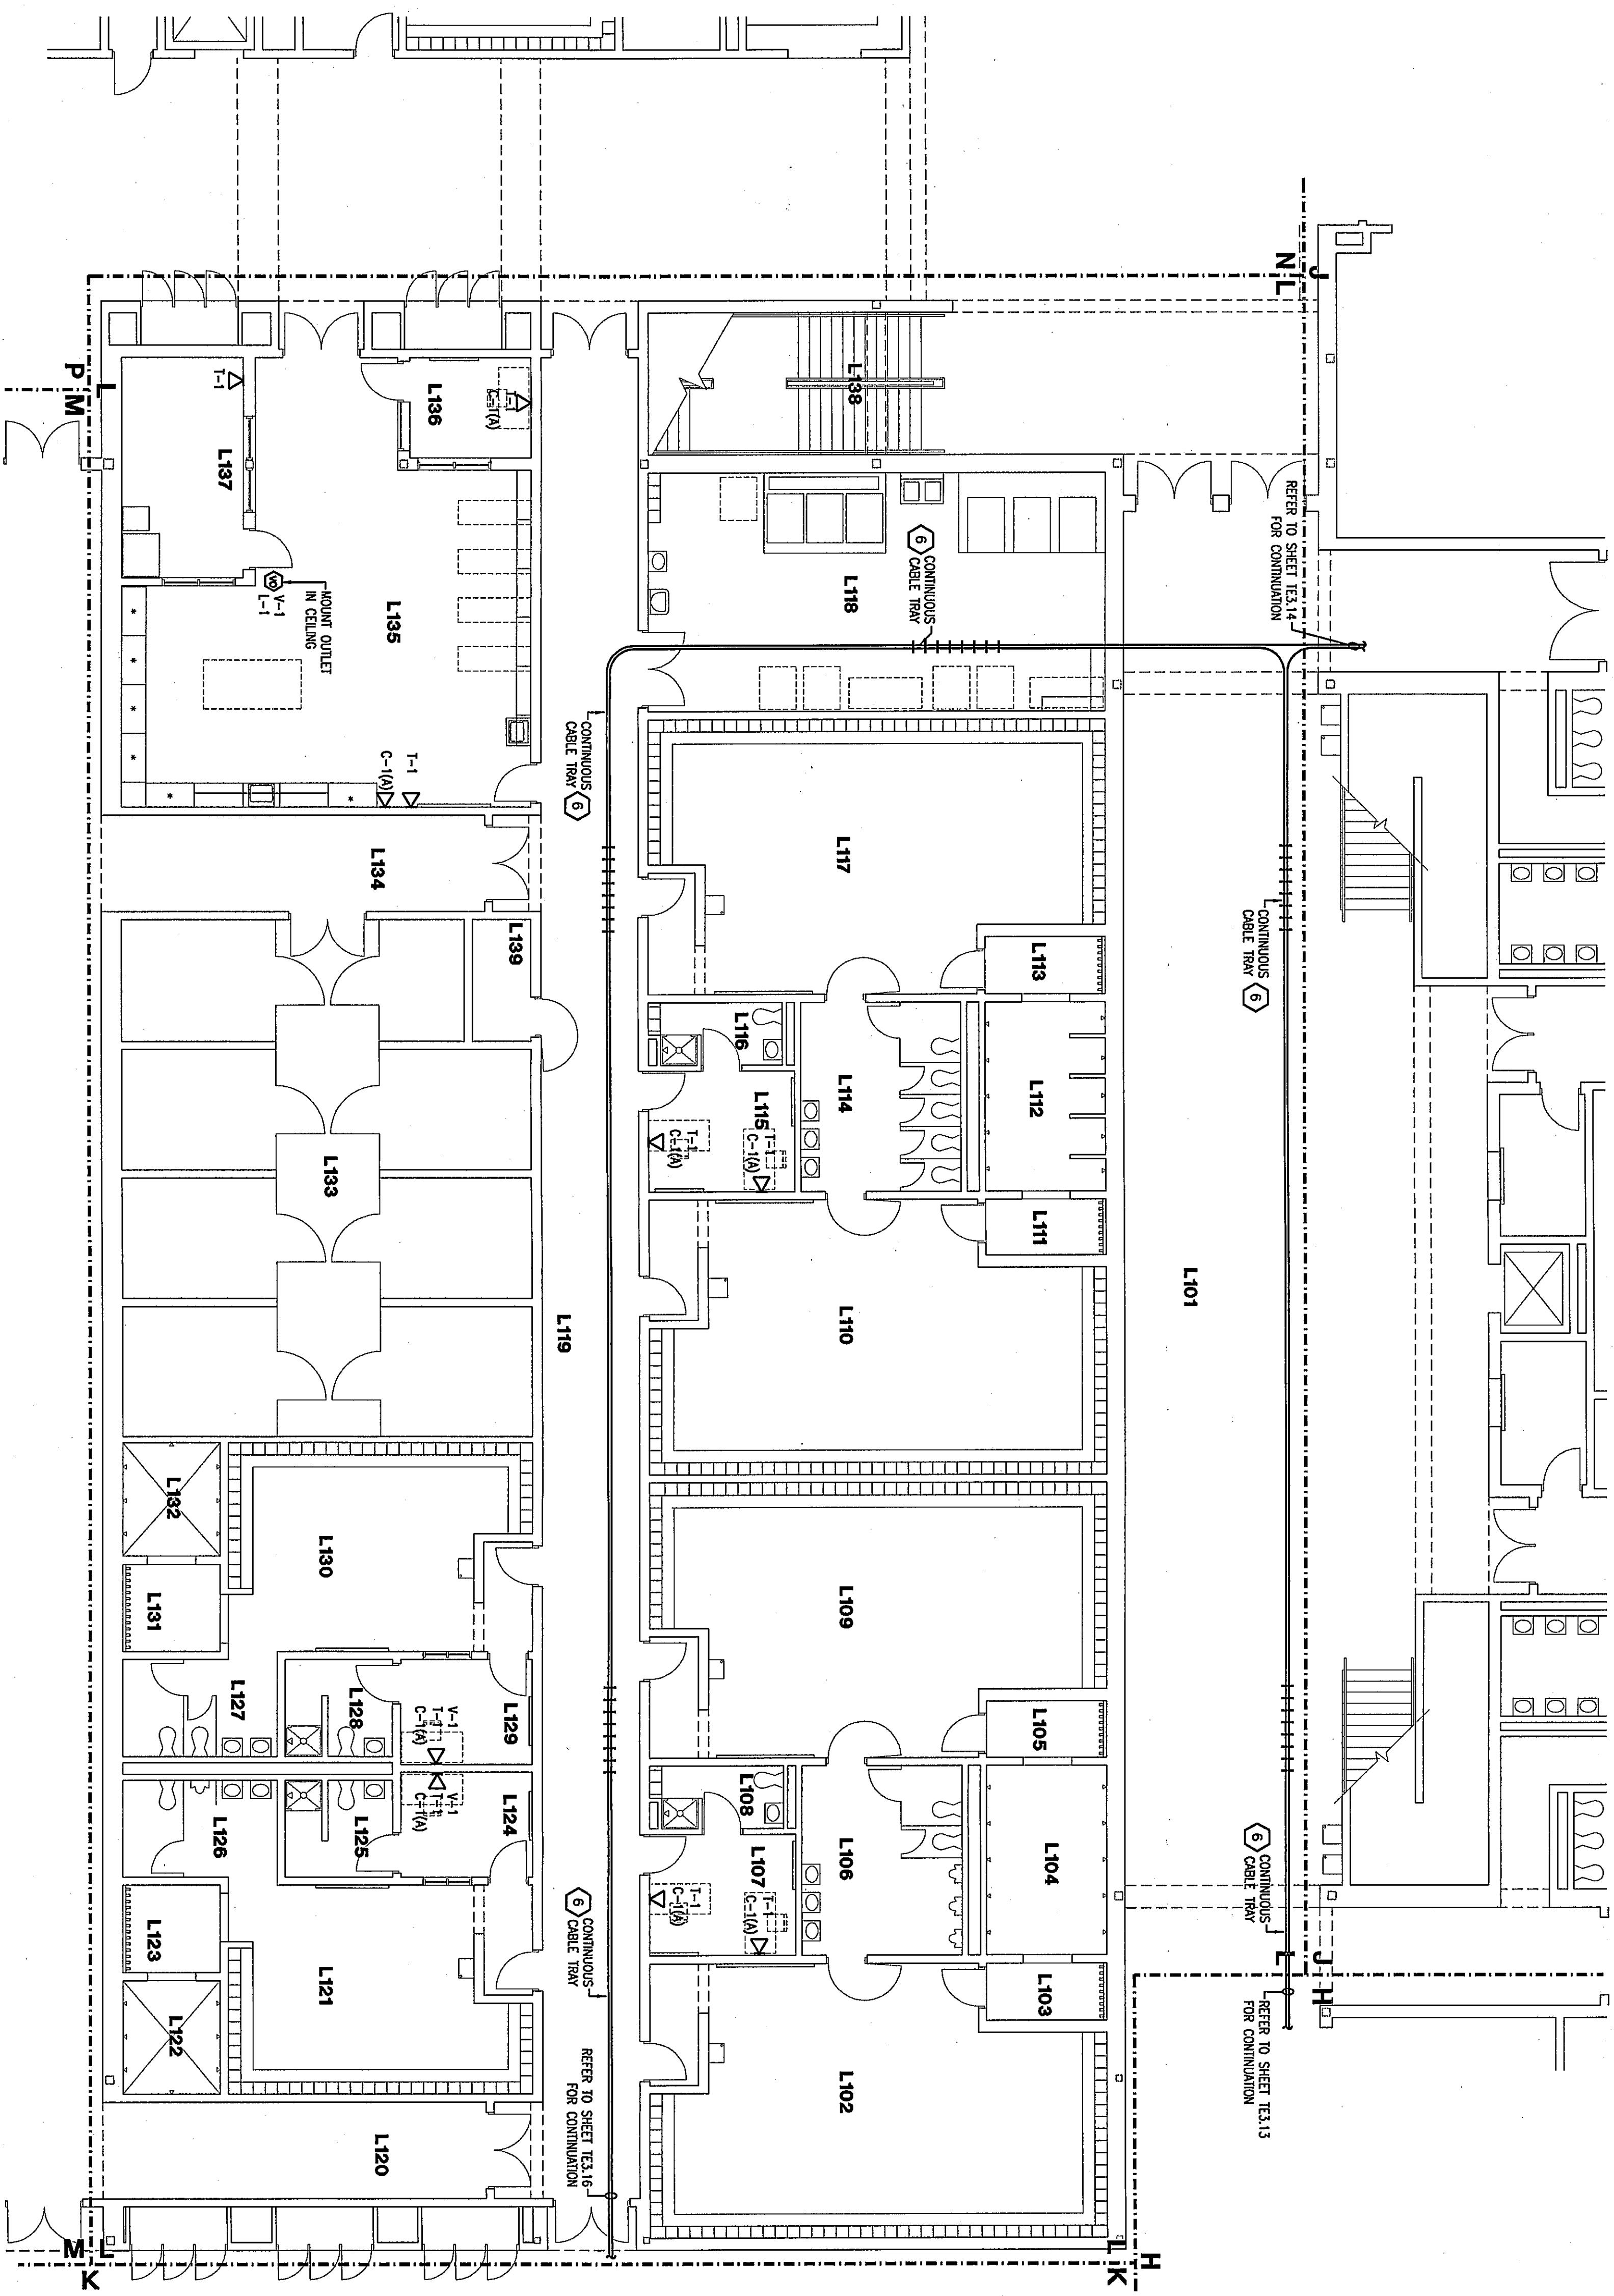

TECHNOLOGY PLAN UNIT L

SCALE 1/8" = 1'-0"


ROOM LEGEND "L1"			
ROOM NO.	ROOM NAME	AREA S.F.	CEILING HEIGHT
L101	CORRIDOR	1892	9'-4"
L102	ATHLETIC LOCKER	48	9'-4"
L103	DRINKING ROOM	154	9'-4"
L104	SHOWER	154	9'-4"
L105	TOILET	206	9'-4"
L106	TOILET	206	9'-4"
L107	ATHLETIC OFFICE	120	9'-4"
L108	BOYS' ATHLETIC LOCKER	782	9'-4"
L109	GIRLS' ATHLETIC LOCKER	782	9'-4"
L110	DRINKING ROOM	150	9'-4"
L111	SHOWER	150	9'-4"
L112	TOILET	46	9'-4"
L113	ATHLETIC OFFICE	120	9'-4"
L114	TOILET	54	9'-4"
L115	ATHLETIC LOCKER	731	9'-4"
L116	CORRIDOR	1213	10'-0"
L117	BOYS' ATHLETIC LOCKER	427	9'-4"
L118	GIRLS' ATHLETIC LOCKER	427	9'-4"
L119	DRINKING ROOM	75	9'-4"
L120	SHOWER	75	9'-4"
L121	TOILET	68	9'-4"
L122	TOILET	68	9'-4"
L123	ATHLETIC OFFICE	104	9'-4"
L124	TOILET	104	9'-4"
L125	ATHLETIC LOCKER	104	9'-4"
L126	DRINKING ROOM	150	9'-4"
L127	SHOWER	150	9'-4"
L128	TOILET	46	9'-4"
L129	ATHLETIC OFFICE	120	9'-4"
L130	TOILET	54	9'-4"
L131	ATHLETIC LOCKER	731	9'-4"
L132	CORRIDOR	1213	10'-0"
L133	BOYS' ATHLETIC LOCKER	427	9'-4"
L134	GIRLS' ATHLETIC LOCKER	427	9'-4"
L135	DRINKING ROOM	75	9'-4"
L136	SHOWER	75	9'-4"
L137	TOILET	68	9'-4"
L138	TOILET	68	9'-4"
L139	ATHLETIC OFFICE	104	9'-4"

GENERAL PLAN NOTES:

- SEE DETAIL 15 ON SHEET TE3.1 FOR INFORMATION ON CABLE TRAY, (N) LOCATION & TIE-INS (N) OR 1/2" LOCATION.
- PROVIDE 1/2" RISE SLOPE AT EACH CORNER, SECURE PER MANUFACTURER'S RECOMMENDATIONS.
- LOCATION OF (A) VIDEO PRESENTATION EQUIPMENT, (D) TELEPHONE SYSTEM, (O) DATA RACKS & (S) SOUND SYSTEM, (W) LOCATION OF D.I.F. EQUIPMENT.
- PROVIDE SINGLE GANG RECESSED BOX FOR DATA RACKS.
- EXISTING 1/2" CABLE TRAY AS SHOWN.
- PROVIDE NEW 2" CABLE TRAY TO CORRIDOR.
- EXISTING CHASE WINDOW, PROVIDE COVER PLATES AS REQUIRED.
- PROVIDE A BLANK INSERT FOR ALL UNUSED OPENINGS IN THE DATA/VOICE PLATES.


PLAN NOTES:

- SEE DETAIL 15 ON SHEET TE3.1 FOR INFORMATION ON CABLE TRAY, (N) LOCATION & TIE-INS (N) OR 1/2" LOCATION.
- PROVIDE 1/2" RISE SLOPE AT EACH CORNER, SECURE PER MANUFACTURER'S RECOMMENDATIONS.
- LOCATION OF (A) VIDEO PRESENTATION EQUIPMENT, (D) TELEPHONE SYSTEM, (O) DATA RACKS & (S) SOUND SYSTEM, (W) LOCATION OF D.I.F. EQUIPMENT.
- PROVIDE SINGLE GANG RECESSED BOX FOR DATA RACKS.
- EXISTING 1/2" CABLE TRAY AS SHOWN.
- PROVIDE NEW 2" CABLE TRAY TO CORRIDOR.
- EXISTING CHASE WINDOW, PROVIDE COVER PLATES AS REQUIRED.
- PROVIDE A BLANK INSERT FOR ALL UNUSED OPENINGS IN THE DATA/VOICE PLATES.

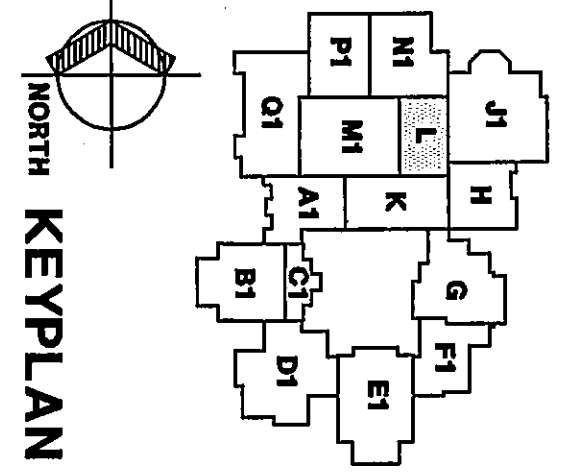

KEY PLAN

THE NEW
CHESTERTON HIGH SCHOOL
TECHNOLOGY PACKAGE
DUNELAND SCHOOL CORPORATION
CHESTERTON, INDIANA

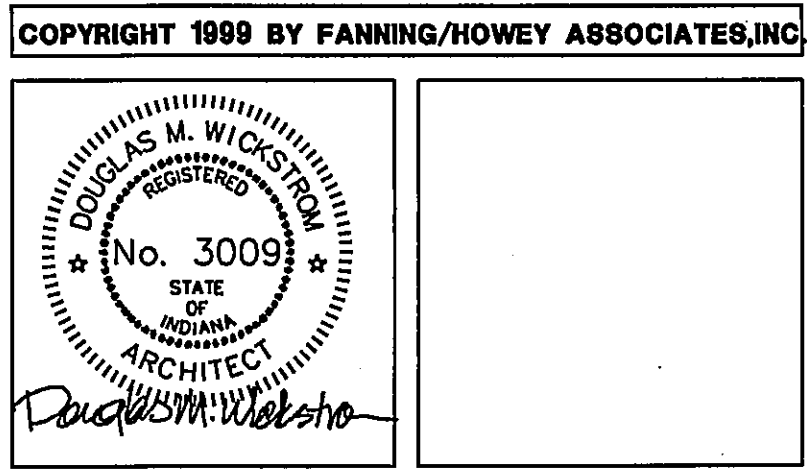

TECHNOLOGY PLAN UNIT L

DRAWN BY: JED COMM. NO.: 95067.00
CHECKED BY: RSB DATE: MAY 3, 1999

TE3.17

REVISIONS NO. DATE

Fanning/Howey
Associates, Inc.
Architects Engineers Consultants