



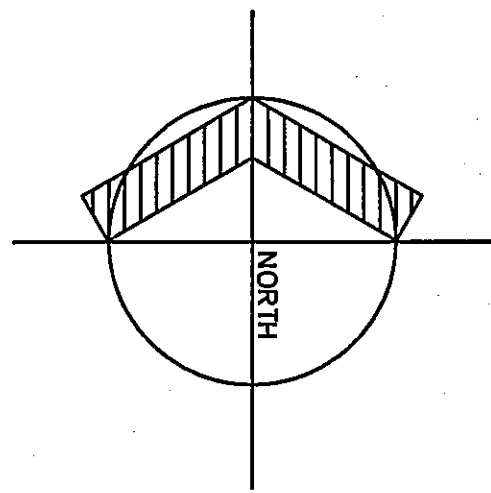

TECHNOLOGY PLAN UNIT M2

SCALE 1/8" = 1'-0"

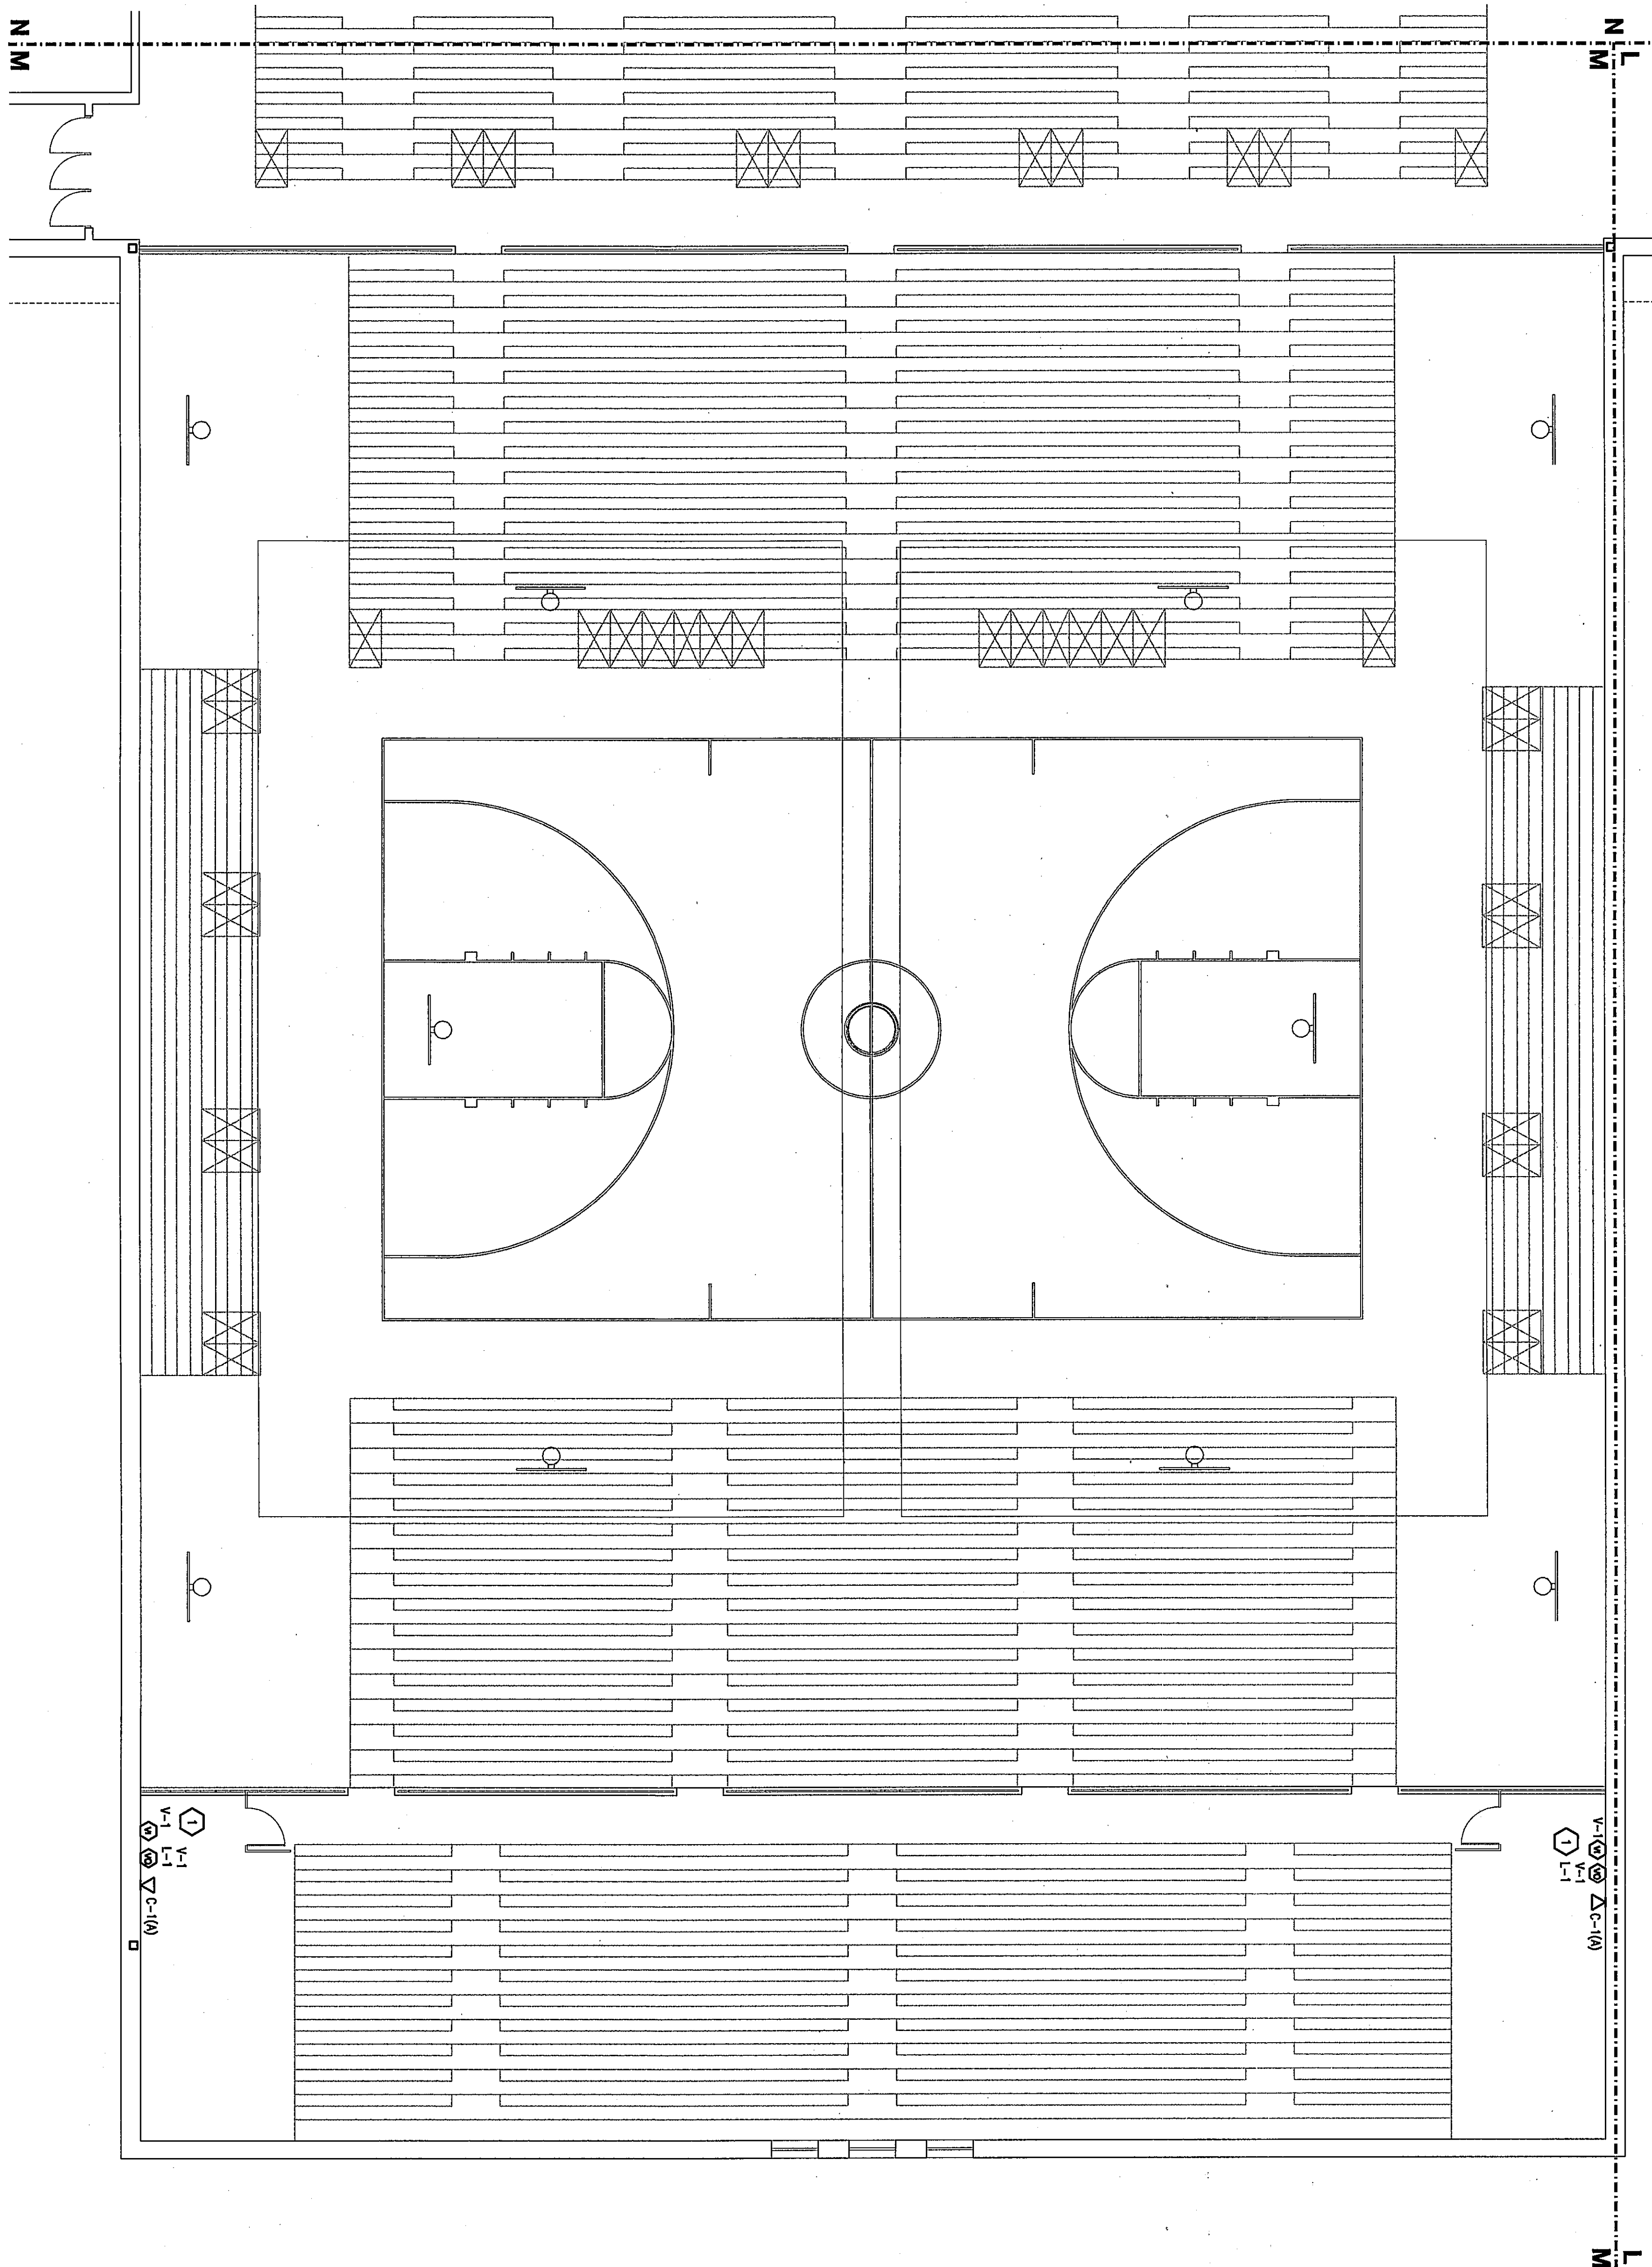


ROOM LEGEND "M2"			
ROOM	AREA	CEILING	FLOOR
M201	SEATING MEZZANINE	3746	---

GENERAL PLAN NOTES:

- PLACEMENT, JUNCTION BOXES, CABLE TRAYS ARE PROVIDED UNDER EXISTING BUILDING ELECTRICAL CONTRACTOR UNLESS OTHERWISE NOTED. VERIFY LOCATION IN FIELD.
- PROVIDE A BLANK COVER PLATE FOR ALL UNUSED JUNCTION BOXES.
- PROVIDE A BLANK INSERT FOR ALL UNUSED OPENINGS IN THE DATA/VOICE PLATES.


PLAN NOTES:

- SEE DETAIL T3 ON SHEET T3.1 FOR INFORMATION ON CHASING BETWEEN T.V. (V0) LOCATION & TEACHERS (M) OR T/C LOCATION.
- PROVIDE T.V. RACK SINGS AT EACH CORNER. SECURE PER MANUFACTURER'S RECOMMENDATIONS.
- LOCATION OF (V) VIDEO PRESENTATION EQUIPMENT (V) TELEPHONE SYSTEM (V) DATA RACKS & (S) SOUND SYSTEM (M07)
- LOCATION OF LATE EQUIPMENT.
- PROVIDE SINGLE GANG RECESSED BOX FOR DATA GROUPS.
- PROVIDE NEW 2" CABLE TRAY TO CORRIDOR.
- EXISTING 18" CABLE TRAY AS SHOWN.
- EXISTING 6000 WINDOW. PROVIDE COVER PLATES AS REQUIRED.

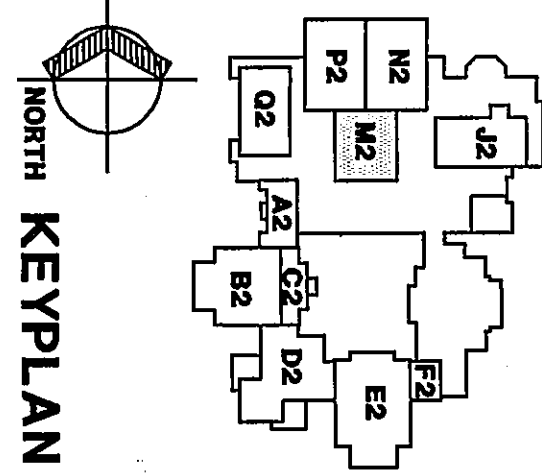

KEYPLAN

THE NEW
CHESTERTON HIGH SCHOOL
TECHNOLOGY PACKAGE
DUNELAND SCHOOL CORPORATION
CHESTERTON, INDIANA

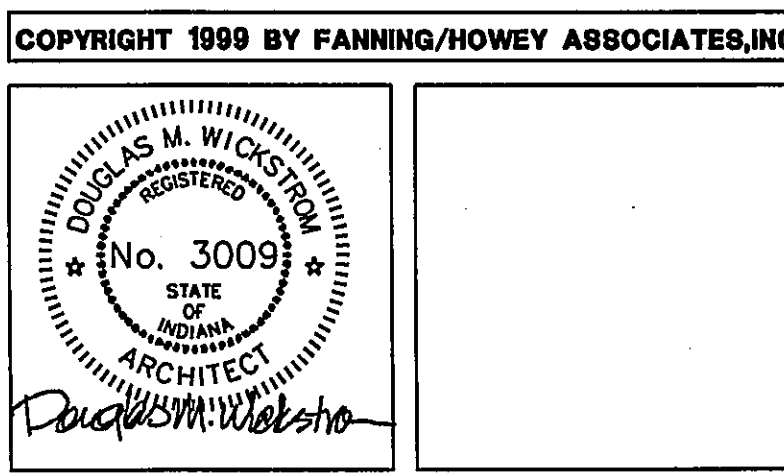

TECHNOLOGY PLAN UNIT M2	
DRAWN BY: JED	COMM. NO.: 95067.00
CHECKED BY: RSB	DATE: MAY 3, 1999
TE3.19	
REVISIONS NO. DATE	

Fanning/Howey
Associates, Inc.
Architects Engineers Consultants

04-16-24