




TECHNOLOGY PLAN GYMNASIUMS AREA
(ALTERNATE BID)

SCALE 1/8" = 1'-0"

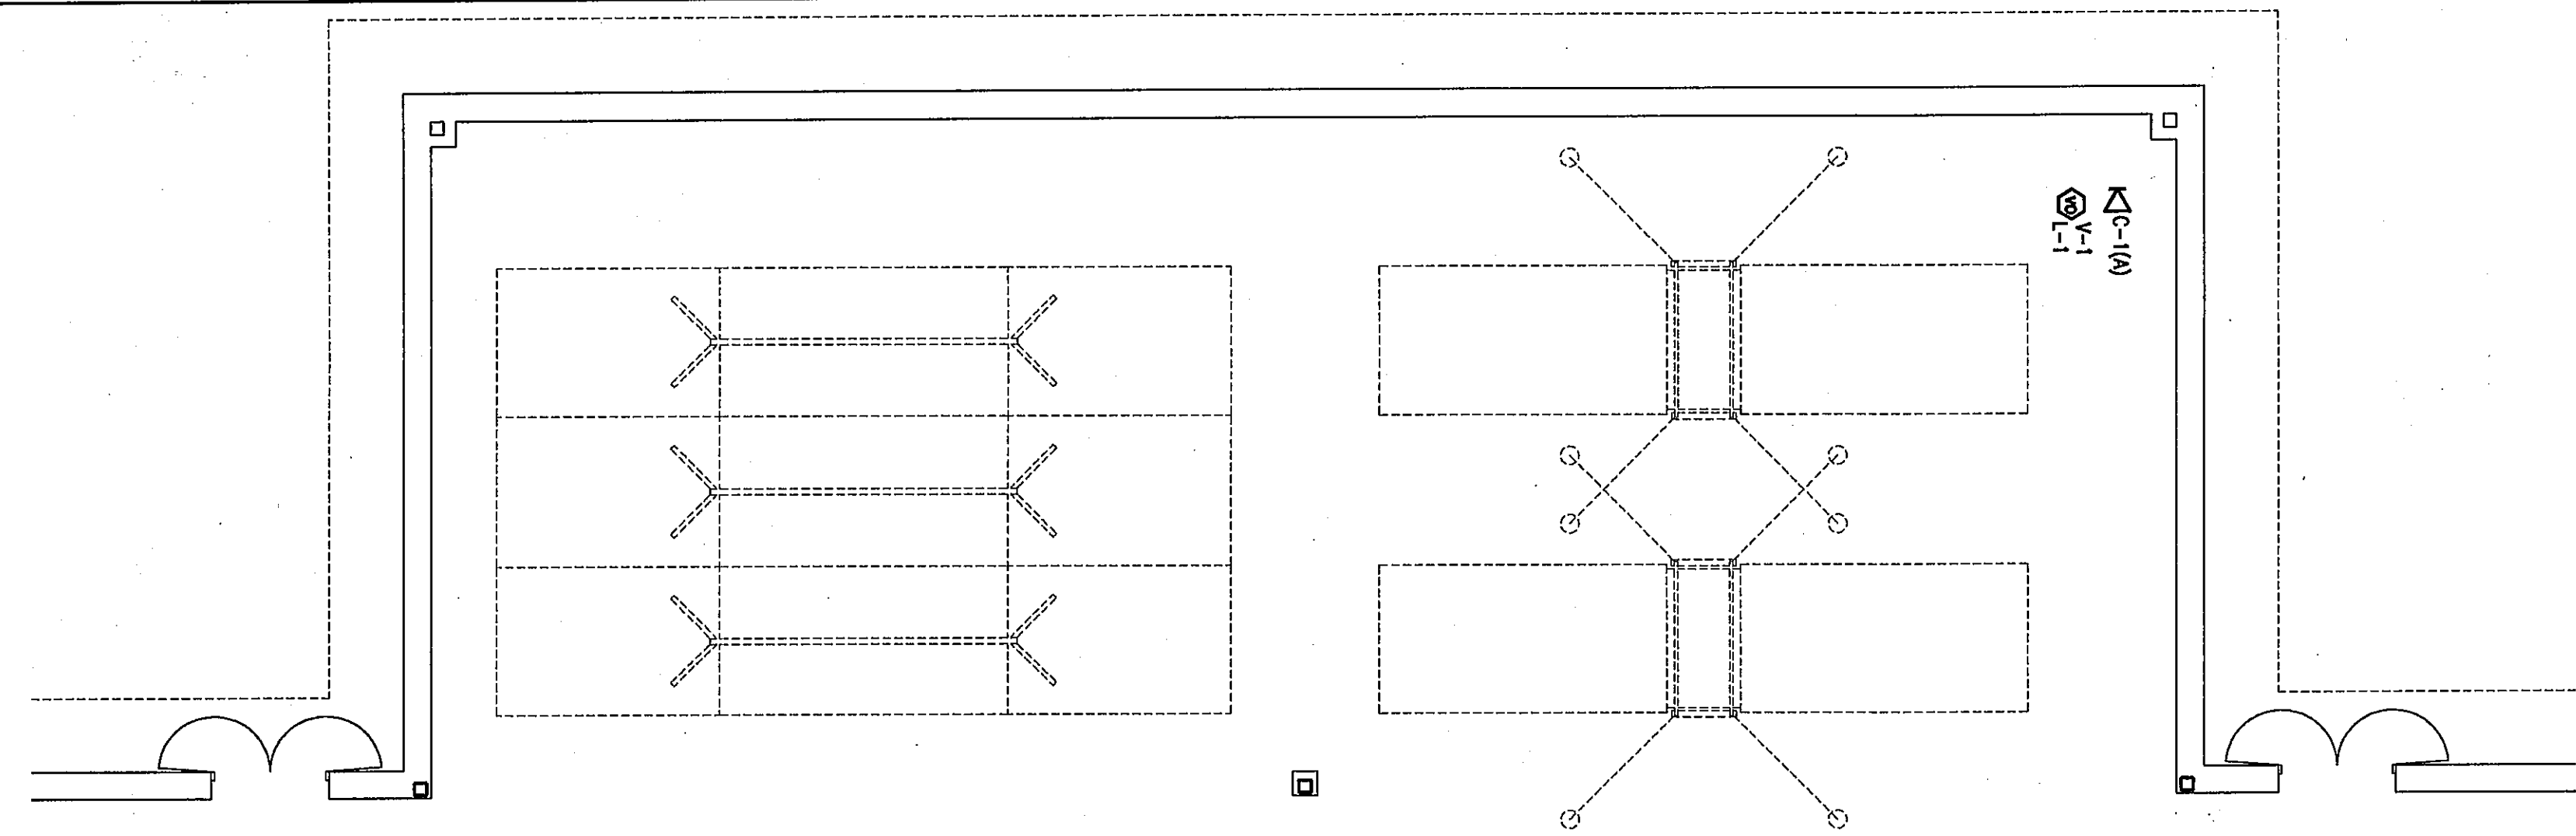

TECHNOLOGY PLAN UNIT N1

SCALE 1/8" = 1'-0"

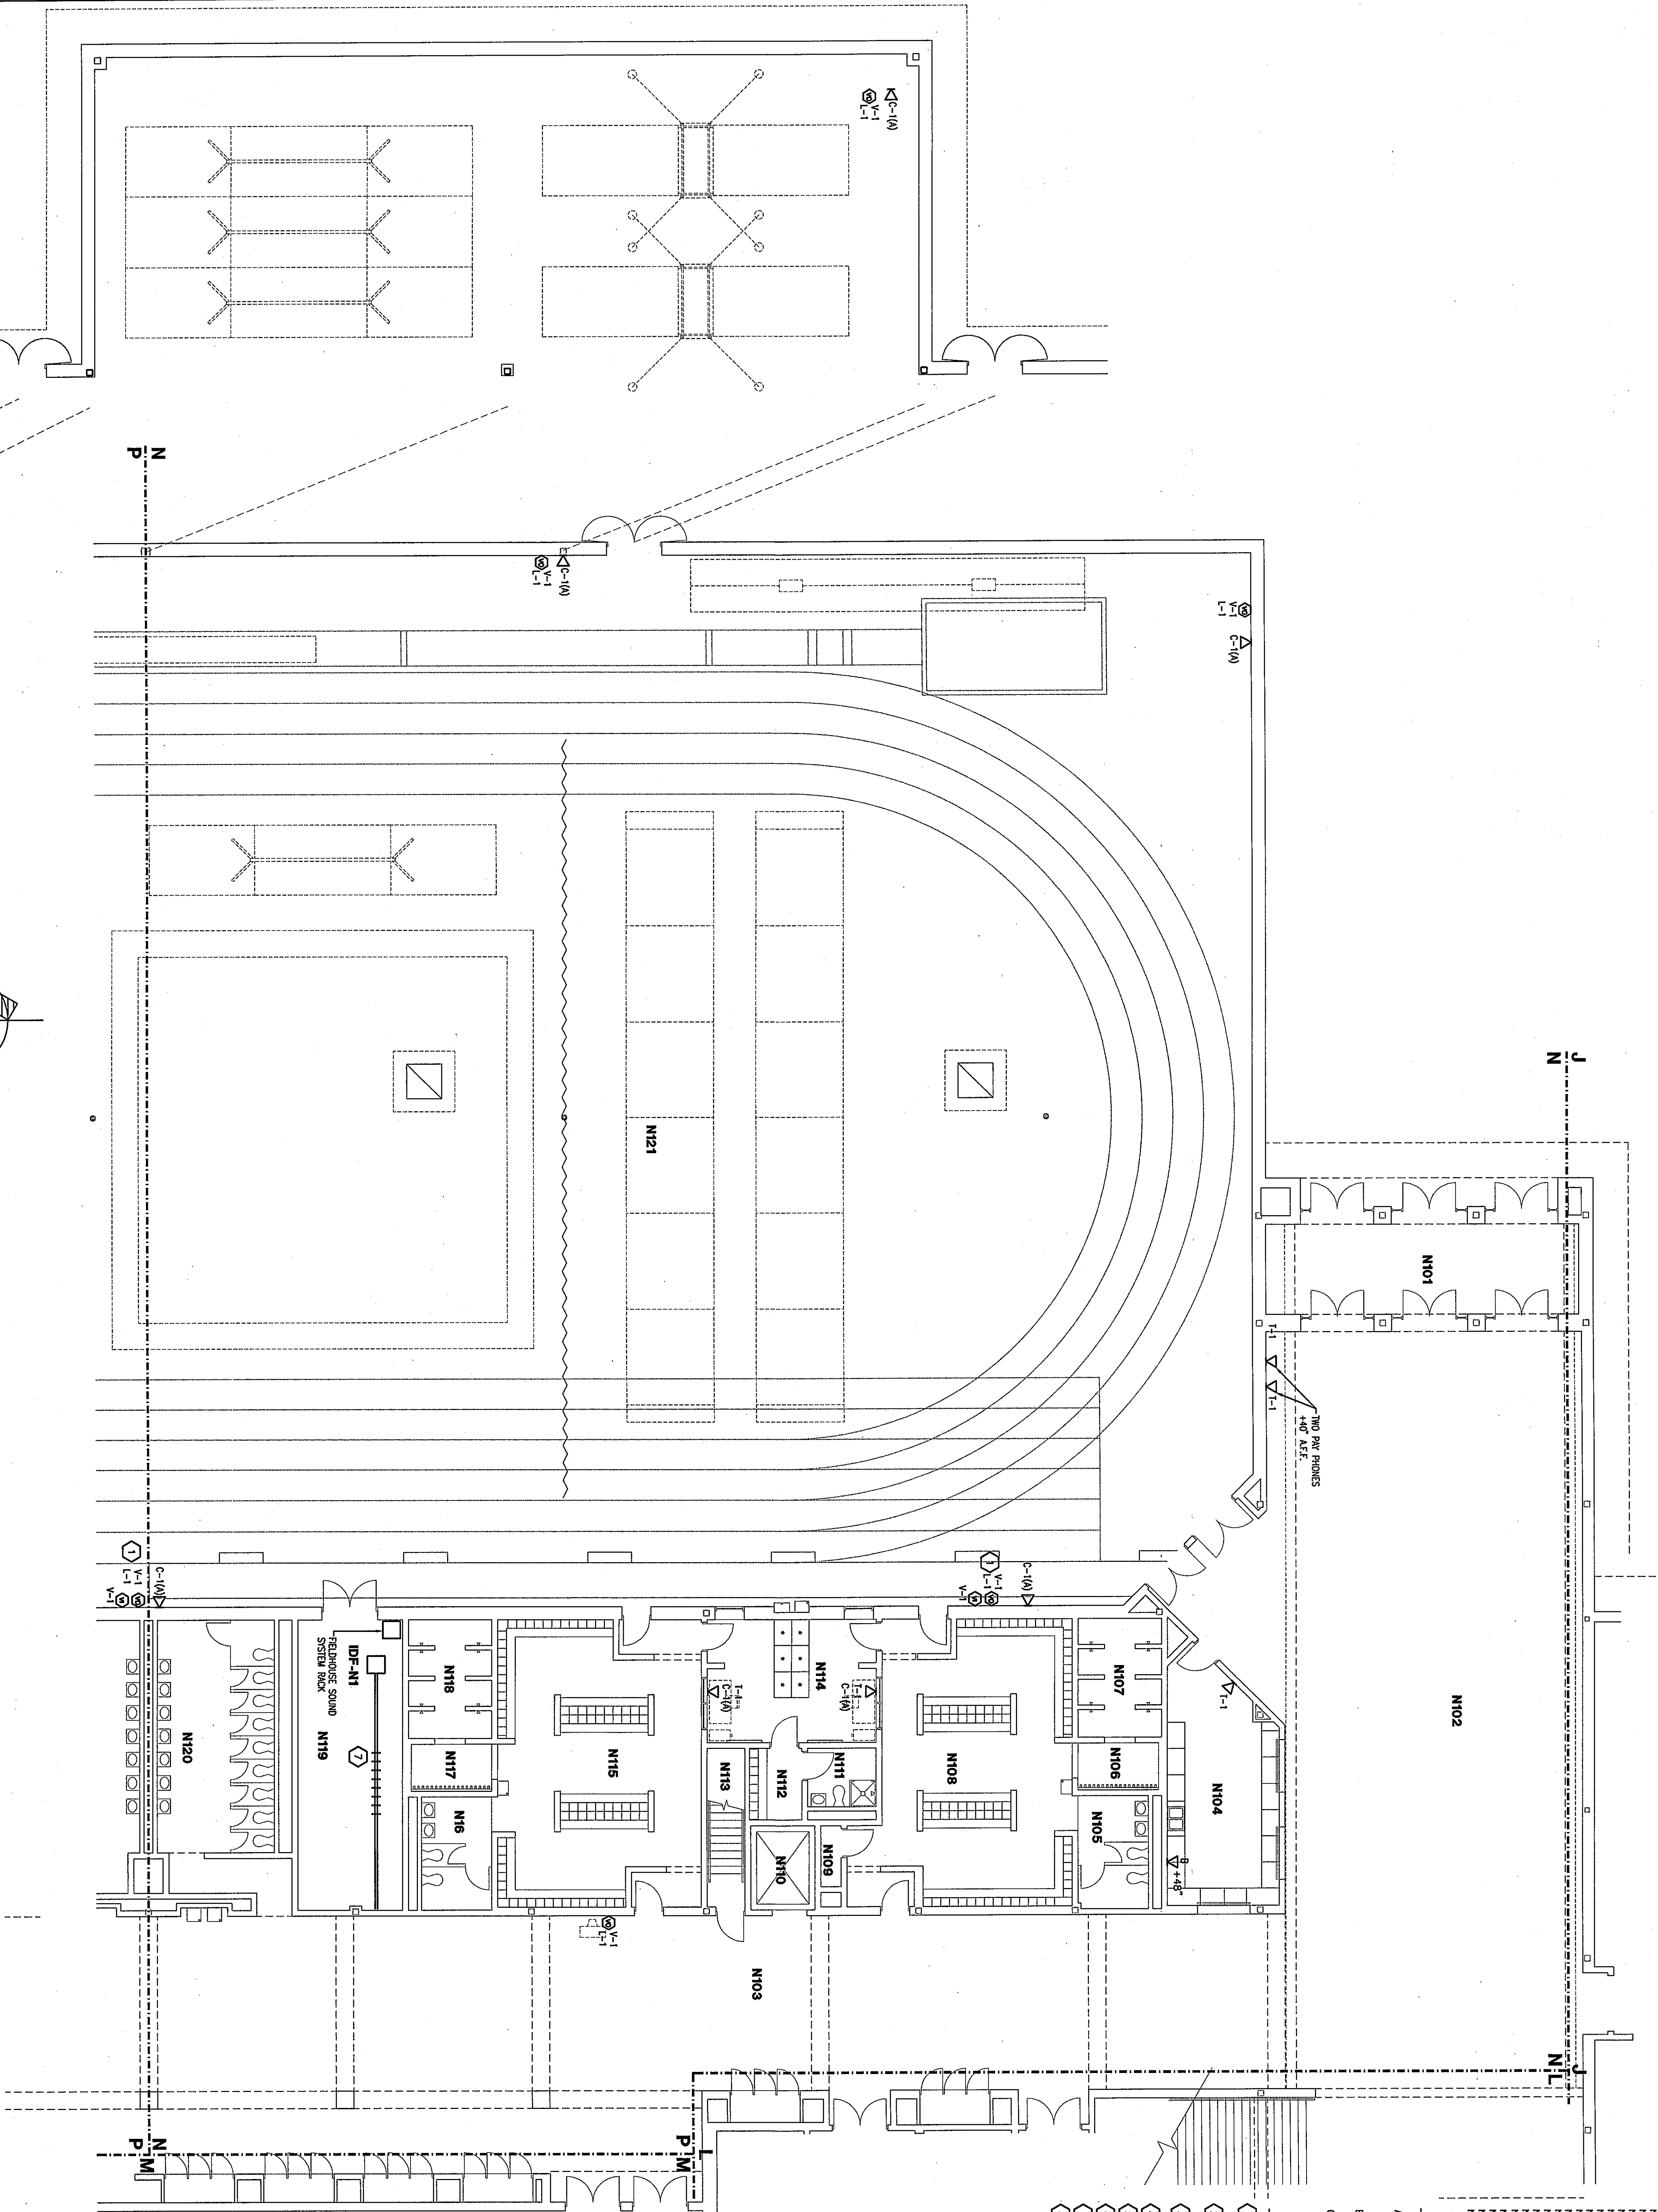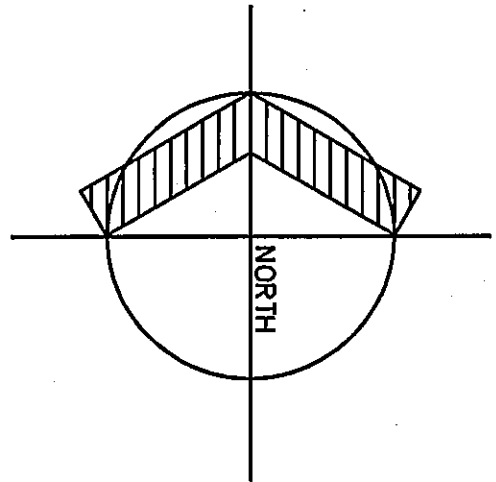


- ROOM LEGEND "N1"**
- | ROOM NO. | ROOM NAME | AREA S.F. | CEILING HEIGHT |
|----------|------------------|-----------|----------------|
| N101 | VESTIBULE | 397 | 10'-0" |
| N102 | CORRIDOR | 3257 | 10'-0" |
| N103 | CORRIDOR | 3257 | 10'-0" |
| N104 | CONCESSION STAND | 337 | 9'-4" |
| N105 | DRINKING ROOM | 48 | 9'-4" |
| N106 | SHOWER | 120 | 9'-4" |
| N107 | LOCKER | 19 | 9'-4" |
| N108 | LOCKER | 19 | 9'-4" |
| N109 | ELEVATOR | 71 | 9'-4" |
| N110 | COACH LOCKER | 32 | 9'-4" |
| N111 | STAIR | 74 | 9'-4" |
| N112 | STAIR | 74 | 9'-4" |
| N113 | TOILET | 763 | 9'-4" |
| N114 | TOILET | 104 | 9'-4" |
| N115 | SHOWER | 130 | 9'-4" |
| N116 | PE STORAGE | 397 | 9'-4" |
| N117 | PE STORAGE | 397 | 9'-4" |
| N118 | PE STORAGE | 397 | 9'-4" |
| N119 | PE STORAGE | 397 | 9'-4" |
| N120 | PE STORAGE | 397 | 9'-4" |
| N121 | PE STORAGE | 397 | 9'-4" |
- GENERAL PLAN NOTES:**
- BACKWALL, JUNCTION BOXES, CABLE TRAYS ARE PROVIDED UNDER FLOOR.
 - PROVIDE 1X DESK SWEL, AT EACH CABINET, SCORE PER MANUFACTURER'S RECOMMENDATIONS.
 - LOCATION OF (V)-VIDEO DISTRIBUTION EQUIPMENT, (T)-TELEPHONE SYSTEM, (D)-DATA BACKS & (S)-SOUND SYSTEM (UNF).
 - LOCATION OF IDF EQUIPMENT.
 - PROVIDE SINGLE GANG RECESSED BOX FOR DATA WIRING.
 - EXISTING 1/2" CABLE TRAY AS SHOWN.
 - PROVIDE NEW 2X CABLE TRAY TO CORRIDOR.
 - EXISTING CABLE WIRING, PROVIDE COVER PLATES AS REQUIRED.
- PLAN NOTES:**
- SEE DETAIL T-1 ON SHEET T-1 FOR INFORMATION ON CABLE TRAY (V) LOCATION & TOLERANCES (V) OR T/C LOCATION.
 - PROVIDE 1X DESK SWEL, AT EACH CABINET, SCORE PER MANUFACTURER'S RECOMMENDATIONS.
 - PROVIDE A BLANK COVER PLATE FOR ALL UNUSED JUNCTION BOXES.
 - PROVIDE A BLANK INSERT FOR ALL UNUSED OPENINGS IN THE DATA/VOICE PLATES.

99-10-05

TECHNOLOGY PLAN UNIT N1	
DRAWN BY: JED	COMM. NO.: 95067.00
CHECKED BY: RSB	DATE: MAY 3, 1999
TE3.20	
REVISIONS NO. DATE	

Fanning/Howey Associates, Inc.
Architects Engineers Consultants

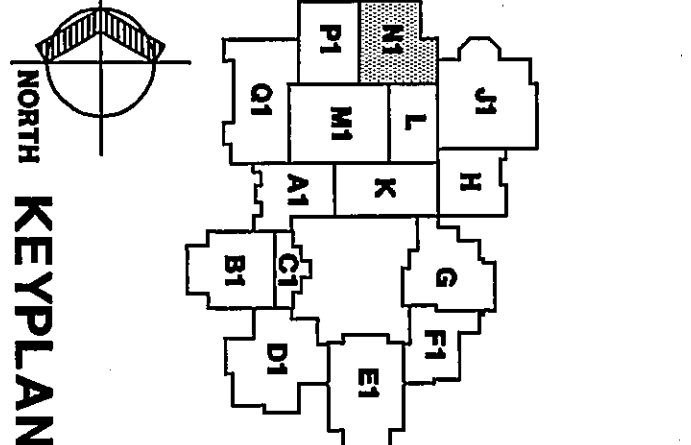

THE NEW
CHESTERTON HIGH SCHOOL
TECHNOLOGY PACKAGE
DUNELAND SCHOOL CORPORATION
CHESTERTON, INDIANA

COPYRIGHT 1999 BY FANNING/HOWEY ASSOCIATES, INC.

DOUGLAS M. WICK
No. 3009
ARCHITECT
Duneland School Corporation
Chesterton, Indiana