



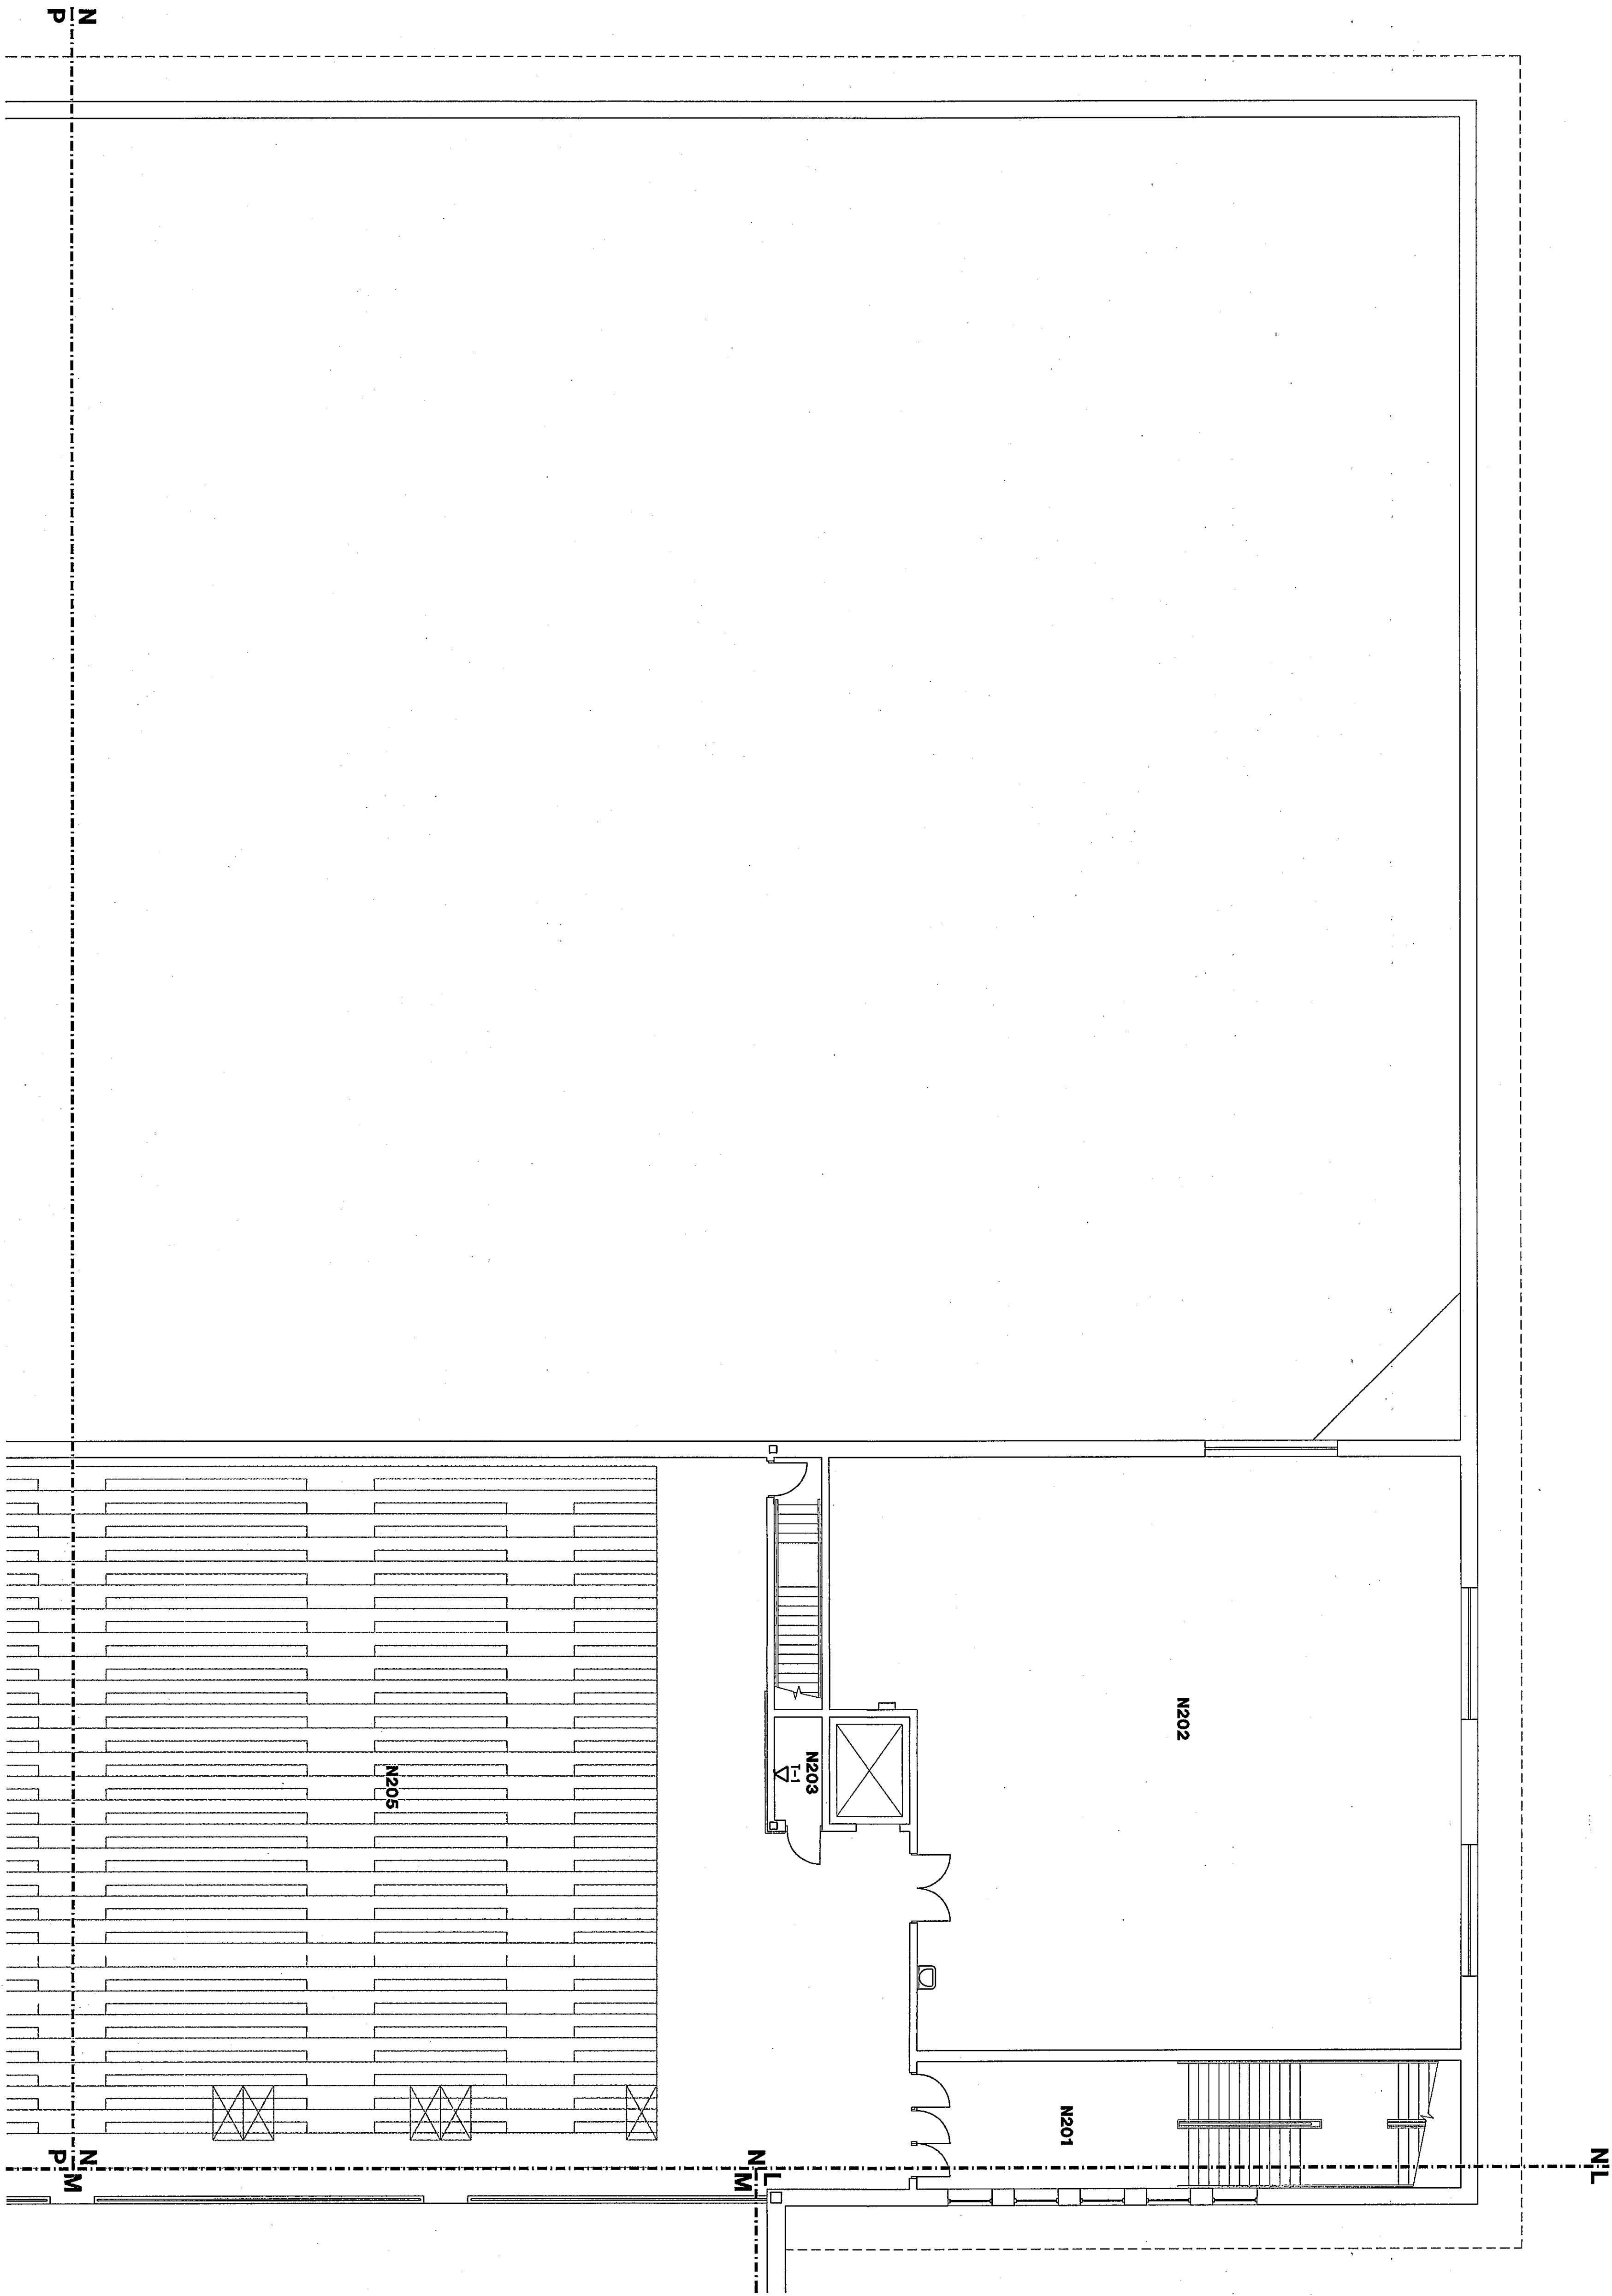

TECHNOLOGY PLAN UNIT N2

SCALE 1/8" = 1'-0"

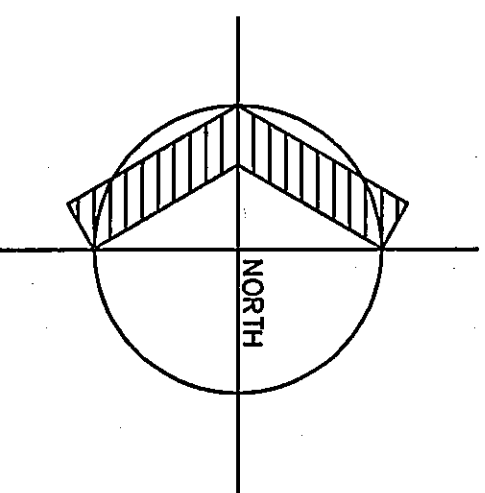

ROOM LEGEND "N2"			
ROOM NO.	ROOM NAME	AREA S.F.	CEILING HEIGHT
N201	STAIR	579	10'-8"
N202	MECHANICAL ROOM	2866	---
N203	ELECTRICAL EQUIPMENT	37	---
N205	BALCONY COURT	4681	---



GENERAL PLAN NOTES:

- RACEWAY, JUNCTION BOXES, CABLE TRAYS ARE PROVIDED UNDER EXISTING BUILDING ELECTRICAL CONTRACTOR UNLESS OTHERWISE NOTED.
- PROVIDE A BLANK COVER PLATE FOR ALL UNUSED JUNCTION BOXES.
- PROVIDE A BLANK RESET FOR ALL UNUSED OPENINGS IN THE DRY/WOOL PLATES.

PLAN NOTES:

- SEE DETAIL T.5 ON SHEET T.1 FOR INFORMATION ON CABLEING BETWEEN T.Y. (N) LOCATION & TEACHERS (N) OR T.Y. LOCATION.
- PROVIDE T.Y. DESK SIGNAL AT EACH CABINET, STORE PER MANUFACTURER'S RECOMMENDATIONS.
- LOCATION OF (N)-JACK DISTRIBUTION EQUIPMENT (T)-TELEPHONE SYSTEM, (D)-DATA RACKS & (S)-SOUND SYSTEM (N/A).
- LOCATION OF I.D.F. EQUIPMENT.
- PROVIDE SINGLE GANG RECESSED BOX FOR DATA DROPS.
- EXISTING 18" CABLE TRAY AS SHOWN.
- PROVIDE NEW 24" CABLE TRAY TO CORRIDOR.
- EXISTING GROUND W/SHIELD, PROVIDE COVER PLATES AS REQUIRED.

THE NEW
CHESTERTON HIGH SCHOOL
TECHNOLOGY PACKAGE
DUNELAND SCHOOL CORPORATION
CHESTERTON, INDIANA

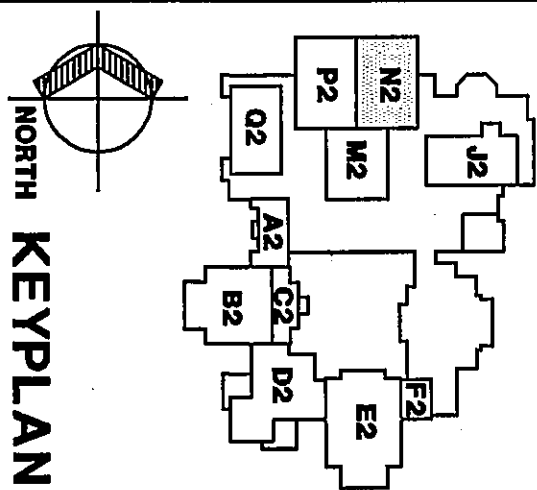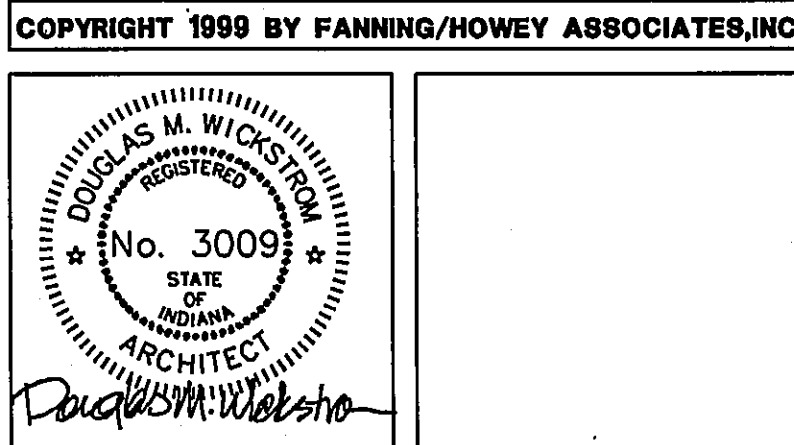

Fanning/Howey
Associates, Inc.
Architects Engineers Consultants

TECHNOLOGY PLAN UNIT N2

DRAWN BY: JED COMM. NO.: 95067.00
CHECKED BY: RSB DATE: MAY 3, 1999

TE3.21

REVISIONS NO. DATE

CHESTERTON HIGH SCHOOL
95067.00

04-75-76