



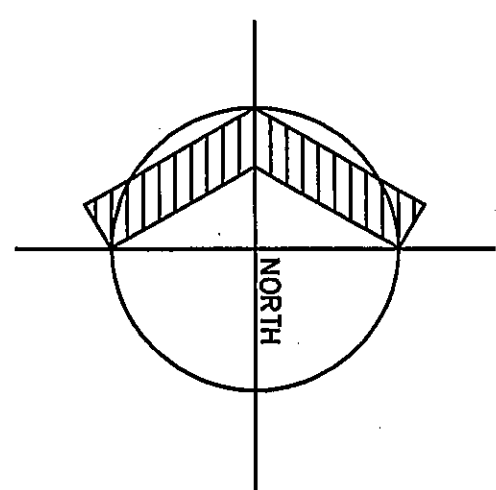

TECHNOLOGY PLAN UNIT P1

SCALE 1/8" = 1'-0"

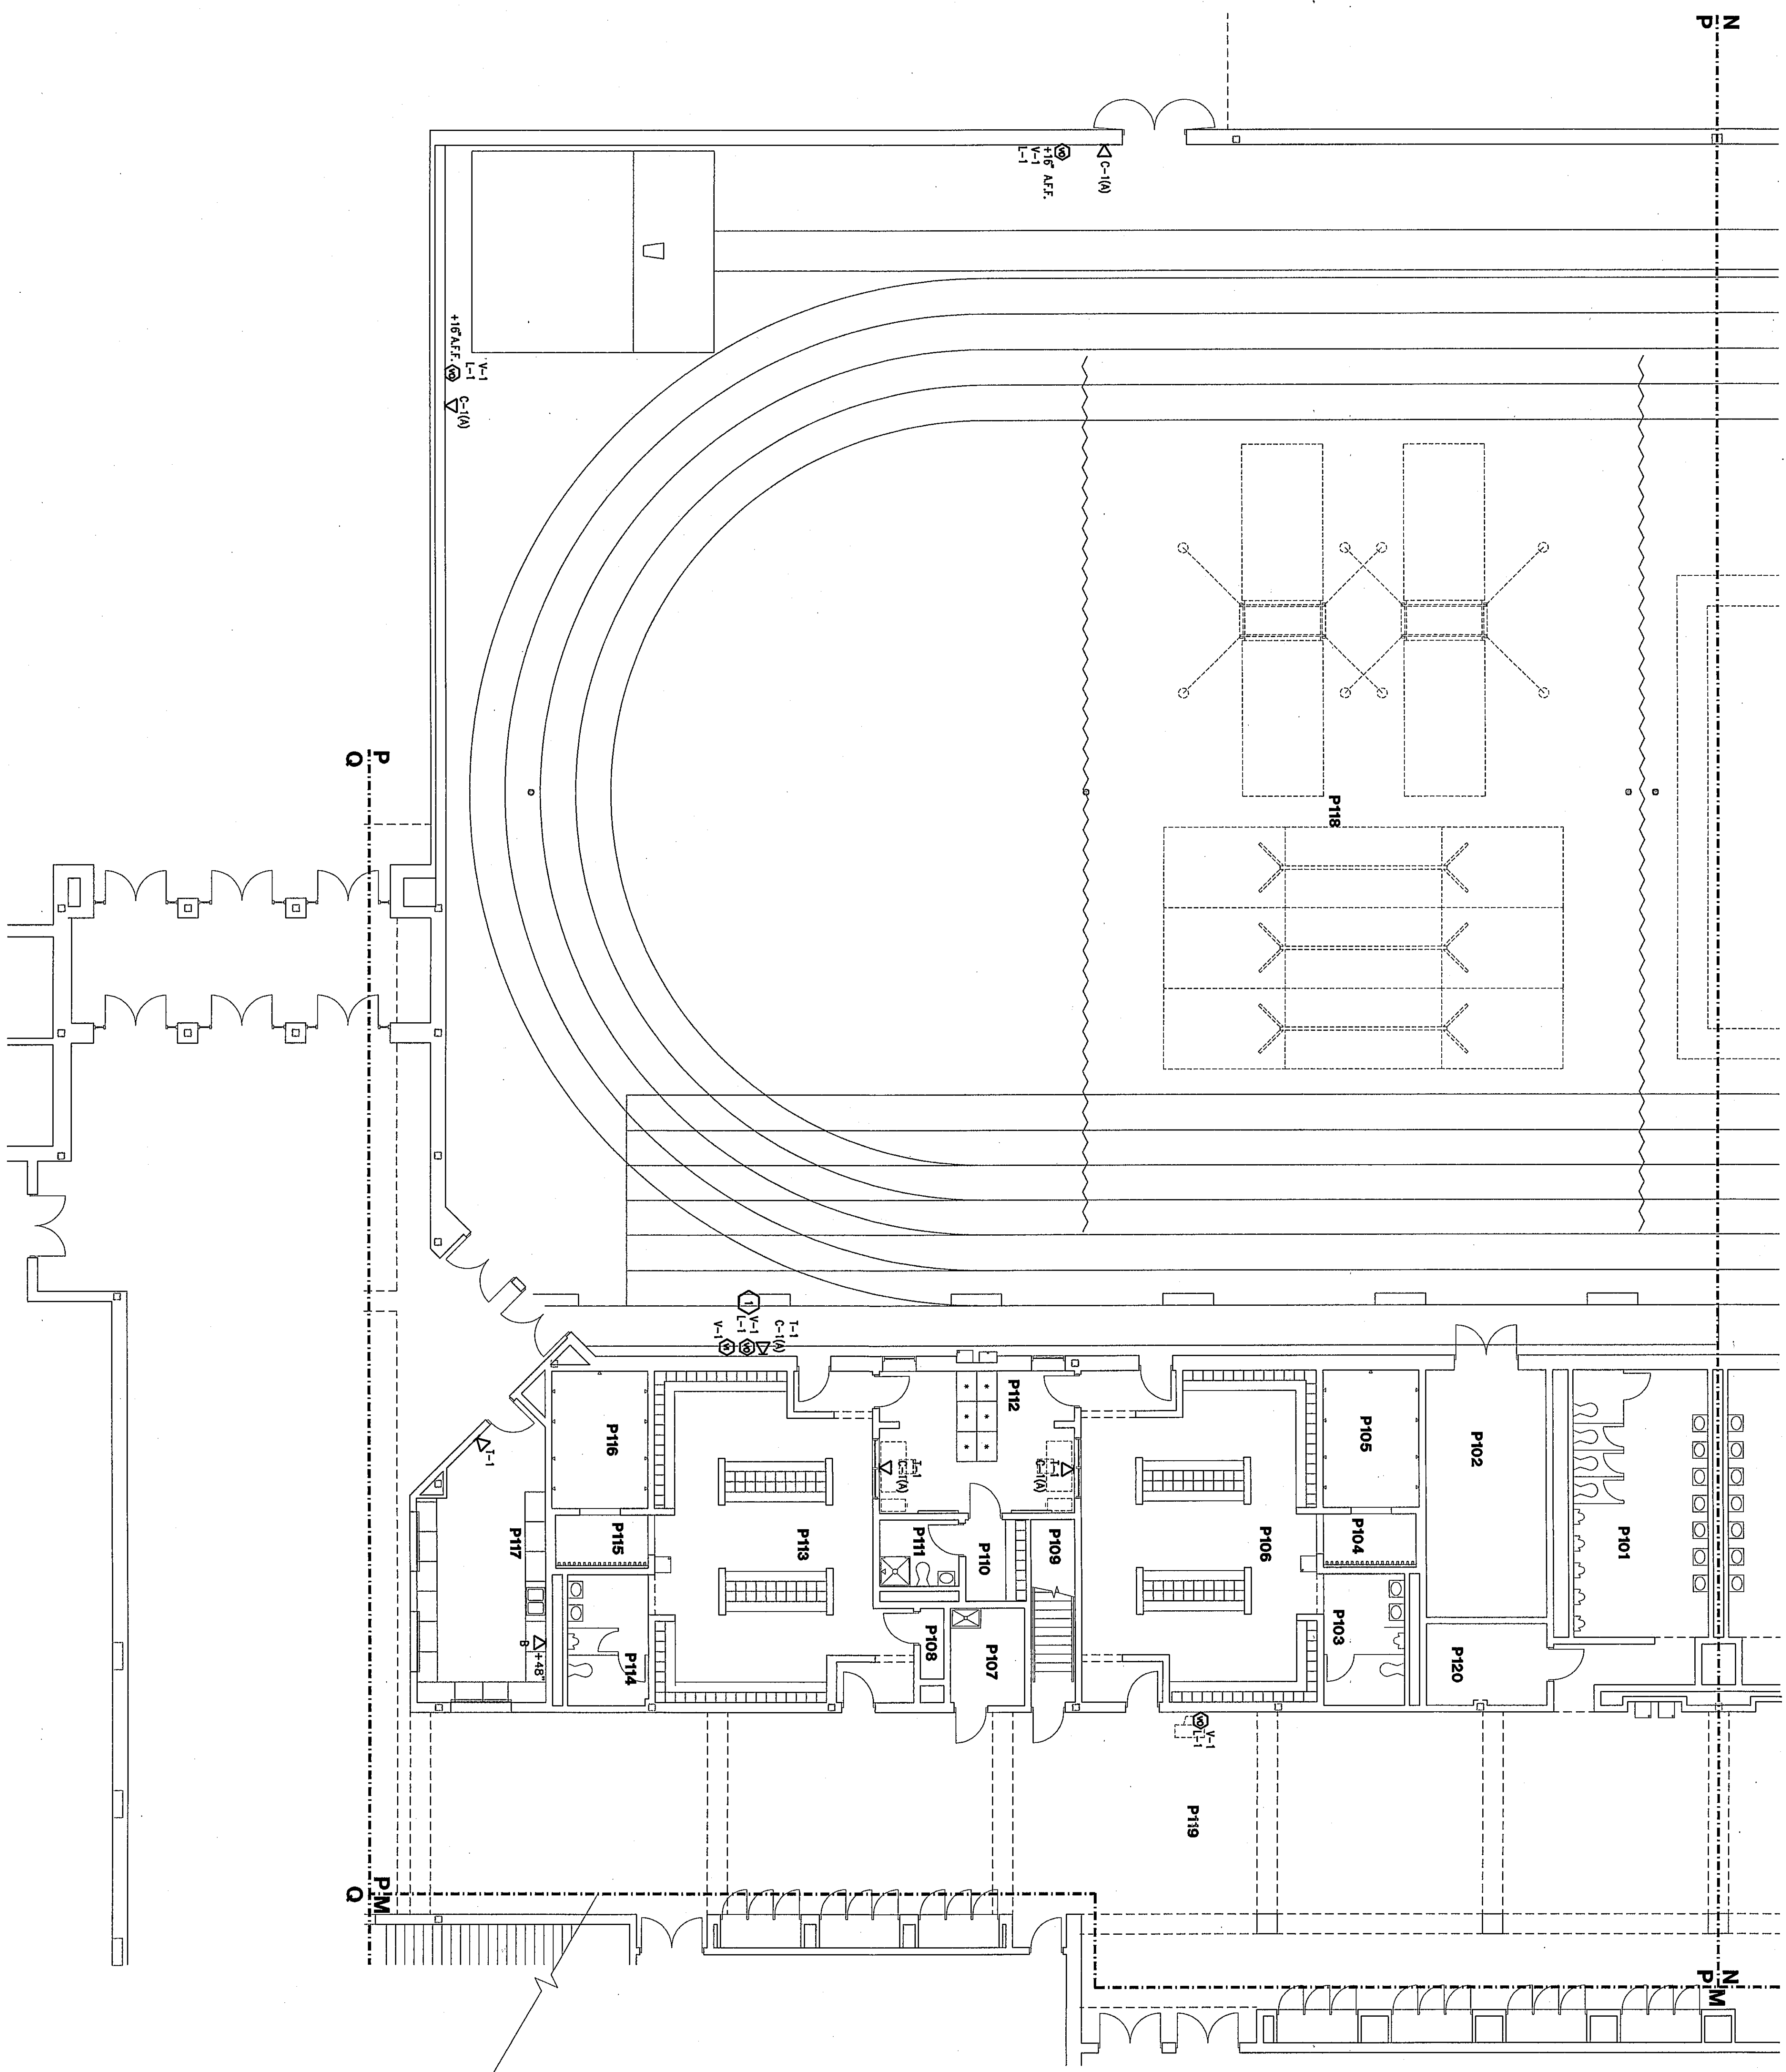


ROOM LEGEND "P1"			
ROOM	AREA	HEIGHT	BEARING
P101	425	9'-4"	9'-4"
P102	294	9'-4"	9'-4"
P103	404	9'-4"	9'-4"
P104	130	9'-4"	9'-4"
P105	130	9'-4"	9'-4"
P106	130	9'-4"	9'-4"
P107	130	9'-4"	9'-4"
P108	130	9'-4"	9'-4"
P109	130	9'-4"	9'-4"
P110	130	9'-4"	9'-4"
P111	130	9'-4"	9'-4"
P112	130	9'-4"	9'-4"
P113	130	9'-4"	9'-4"
P114	130	9'-4"	9'-4"
P115	130	9'-4"	9'-4"
P116	130	9'-4"	9'-4"
P117	130	9'-4"	9'-4"
P118	130	9'-4"	9'-4"
P119	130	9'-4"	9'-4"
P120	130	9'-4"	9'-4"

GENERAL PLAN NOTES:

1. PROVIDE JUNCTION BOXES, CABLE TRAYS ARE PROVIDED UNDER
2. EXISTING BUILDING ELECTRICAL CONDUIT UNLESS OTHERWISE
3. NOTED, VERIFY LOCATION IN FIELD.
4. PROVIDE A BLANK COVER PLATE FOR ALL UNUSED JUNCTION
5. PROVIDE A BLANK INSERT FOR ALL UNUSED OPENINGS IN THE
6. DATA/VOICE PLATES.


PLAN NOTES:

1. SEE DETAIL T3 ON SHEET T3.1 FOR INFORMATION
2. ON CABLE BETWEEN T.V. (V) LOCATION & TEACHERS (N) OR T/C LOCATION
3. PROVIDE TV RACK SWING AT EACH CABINET, SECURE PER
4. MANUFACTURER'S RECOMMENDATIONS.
5. LOCATION OF (N) VIDEO DISTRIBUTION EQUIPMENT (V) TELEPHONE
6. SYSTEM, (D) DATA RACKS & (S) SOUND SYSTEM (N/A)
7. LOCATION OF LDE EQUIPMENT.
8. PROVIDE SINGLE GANG RECESSED BOX FOR DATA DROPS.
9. EXISTING 18" CABLE TRAY AS SHOWN.
10. PROVIDE NEW 24" CABLE TRAY TO CORRIDOR.
11. EXISTING 6000 MINIMUM, PROVIDE COVER PLATES AS REQUIRED.

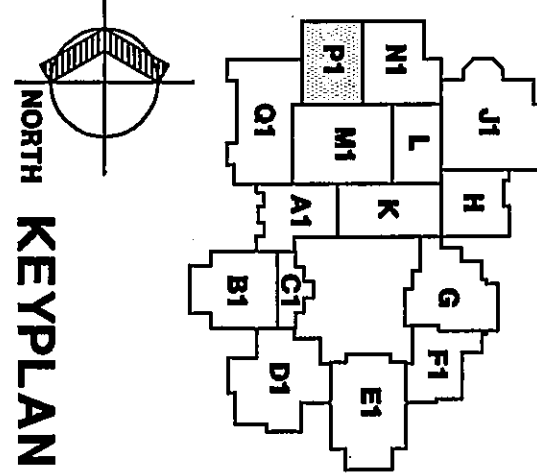

KEY PLAN

THE NEW
CHESTERTON HIGH SCHOOL
TECHNOLOGY PACKAGE
DUNELAND SCHOOL CORPORATION
CHESTERTON, INDIANA

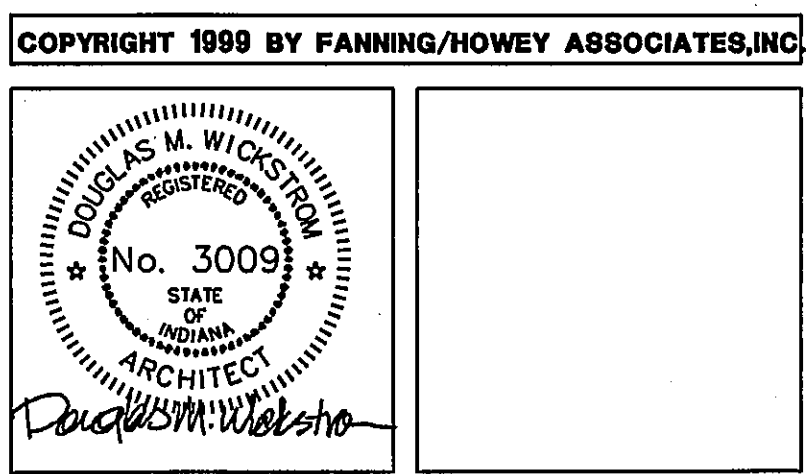

TECHNOLOGY PLAN UNIT P1

DRAWN BY: JED

CHECKED BY: RSB

COMM. NO.: 95067.00

DATE: MAY 3, 1999

TE3.22

REVISIONS NO. DATE

Fanning/Howey

Associates, Inc.

Architects Engineers Consultants

09-18-27