



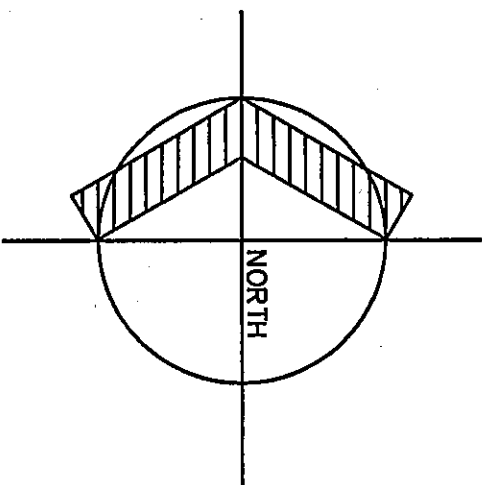

TECHNOLOGY PLAN UNIT P2

SCALE 1/8" = 1'-0"

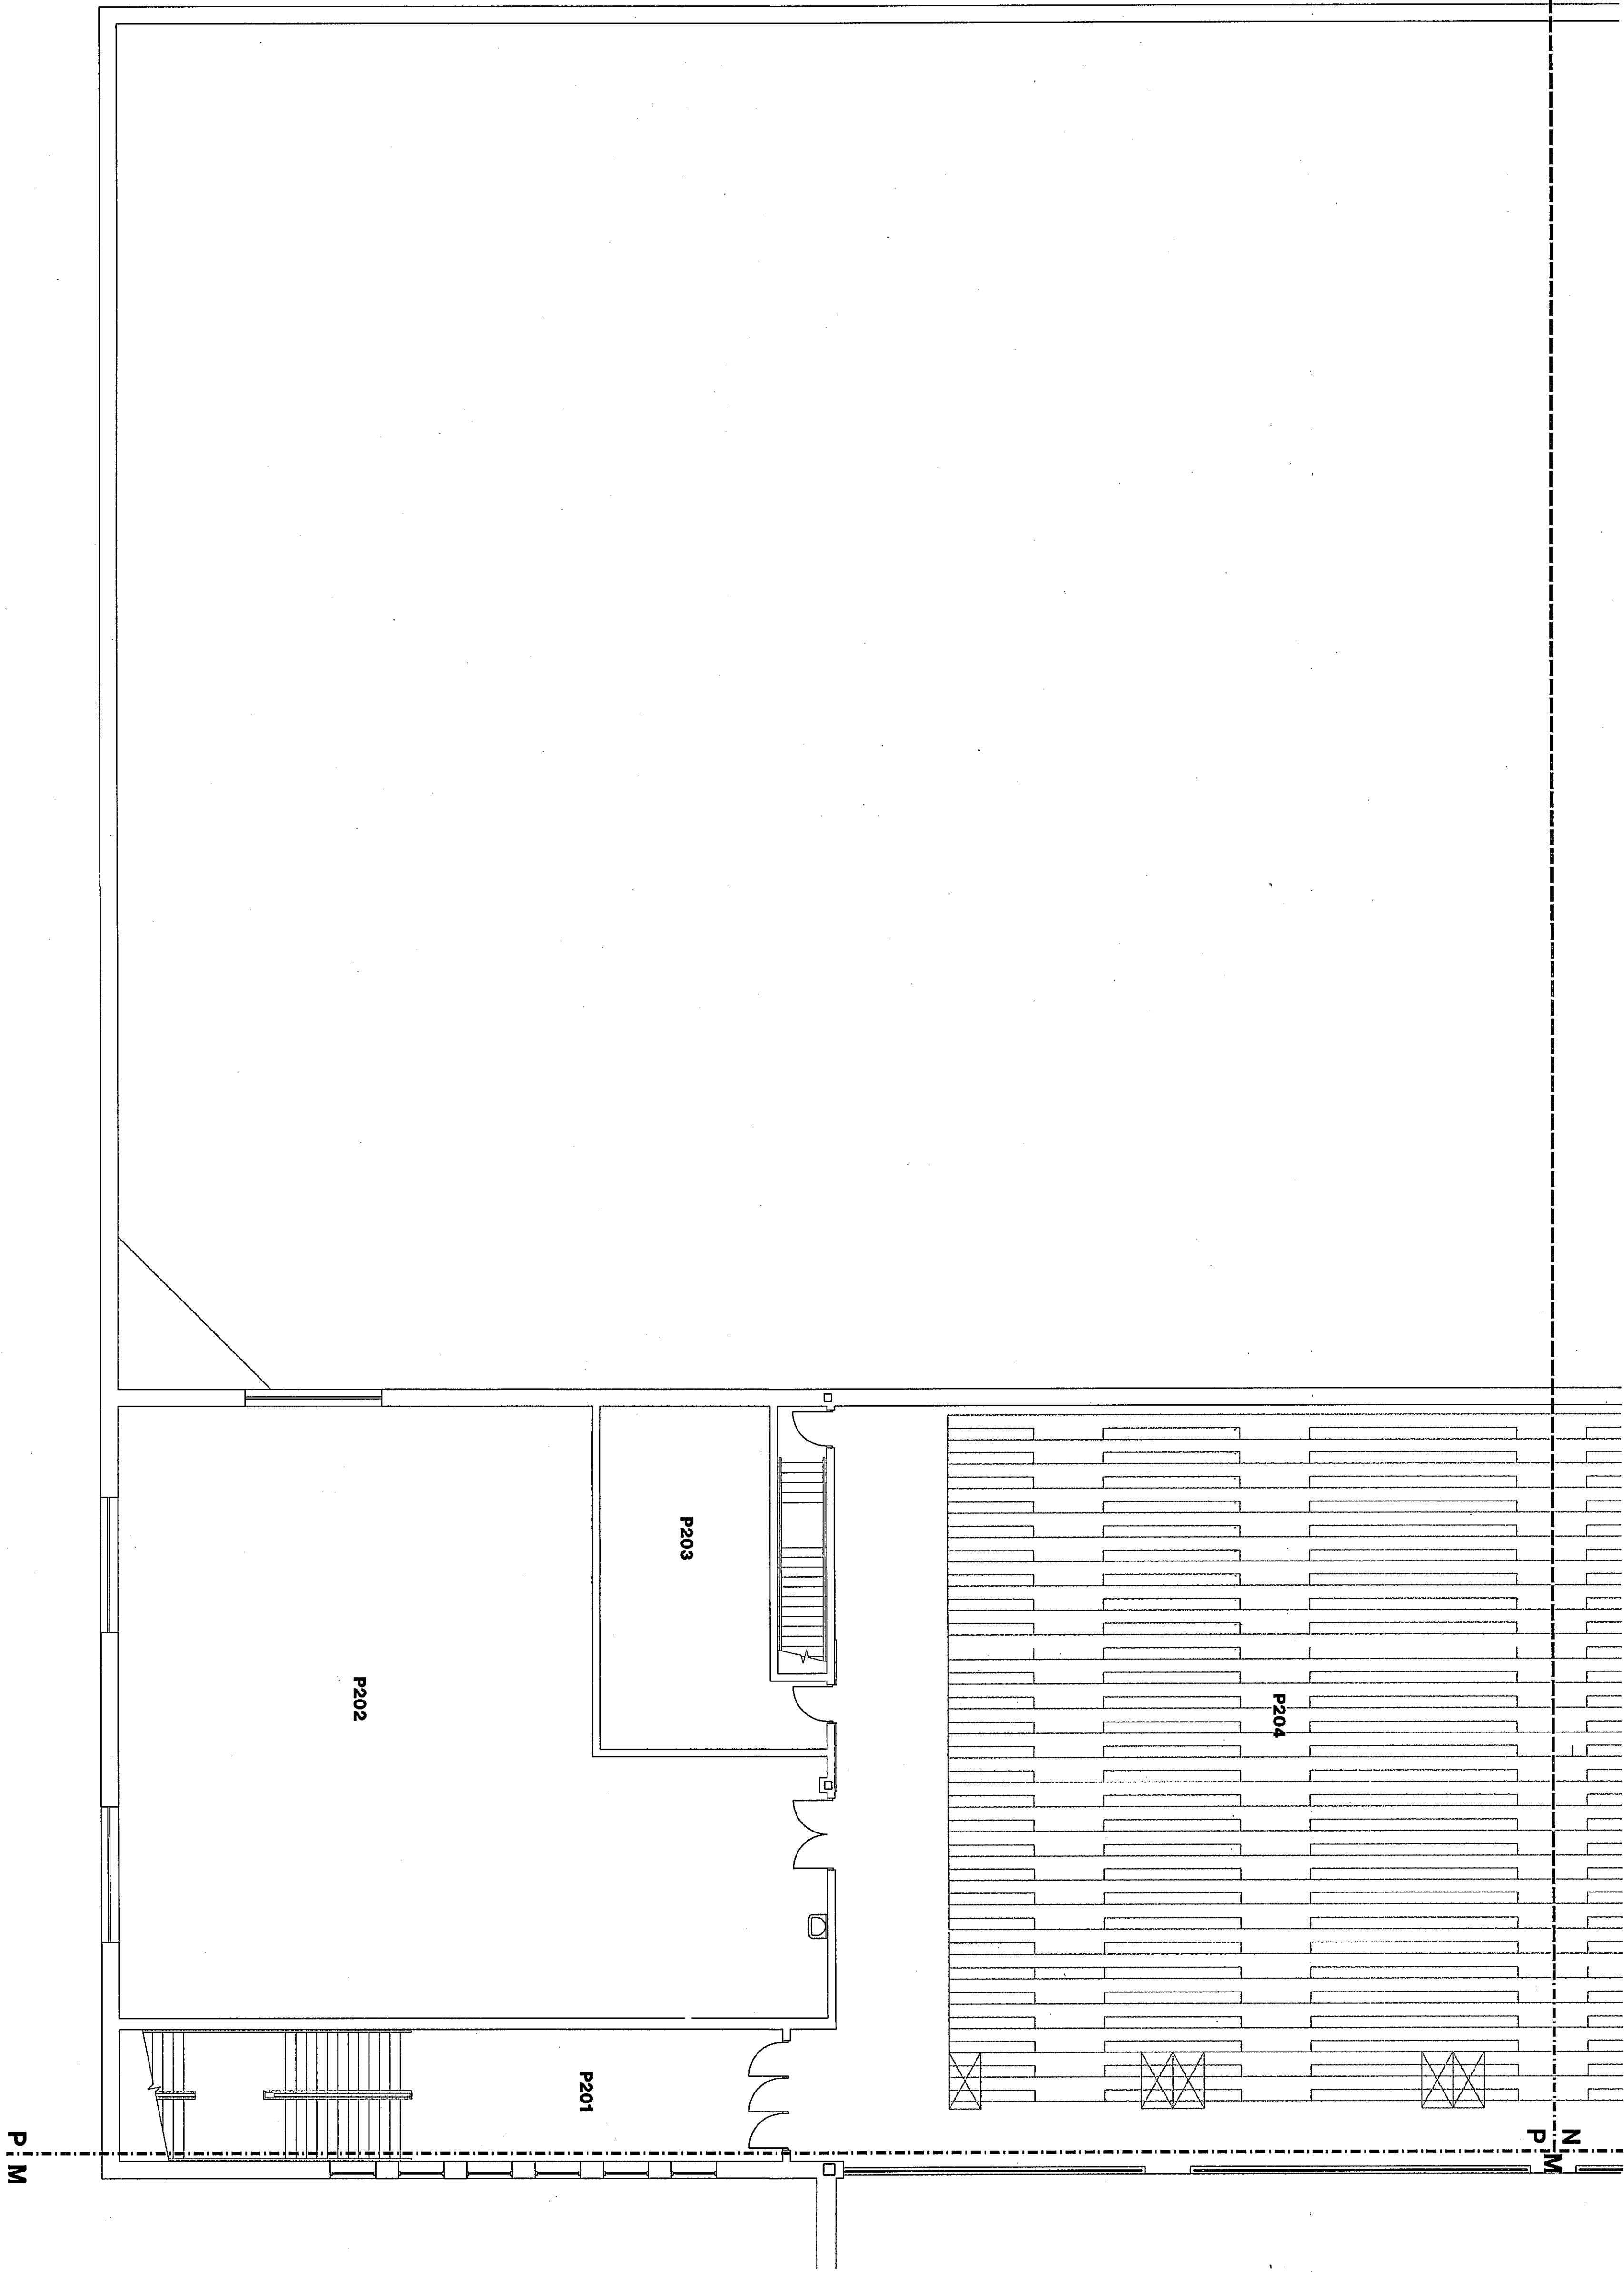

ROOM LEGEND "P2"				
ROOM NO.	NAME	AREA S.F.	CEILING HEIGHT	
P201	STAIR	681.5	10'-6"	
P202	TECHNICAL ROOM	443	9'-4"	
P203	STORAGE	426	9'-4"	
P204	BALCONY COURT	426	9'-4"	

GENERAL PLAN NOTES:


- BACKING, JUNCTION BOXES, CABLE TRAYS ARE PROVIDED UNDER FLOORING. PROVIDE A BLANK COVER PLATE FOR ALL UNUSED JUNCTION BOXES.
- PROVIDE A BLANK COVER PLATE FOR ALL UNUSED JUNCTION BOXES.
- PROVIDE A BLANK INSERT FOR ALL UNUSED OPENINGS IN THE DATA/VOICE PLATES.

PLAN NOTES:

- SEE DETAIL T-15 ON SHEET T-1.1 FOR INFORMATION ON CABLE TRAYING. PROVIDE TYPICAL LOCATION & TYPICAL SECTION FOR MANUFACTURER'S RECOMMENDATIONS.
- PROVIDE TYPICAL SECTION FOR EACH CABLE TRAY. PROVIDE MANUFACTURER'S RECOMMENDATIONS.
- LOCATION OF VIDEO DISTRIBUTION EQUIPMENT (V-TELEPHONE SYSTEM), (D)-DATA BACKS & (S)-SOUND SYSTEM (W/P).
- LOCATION OF I.D.F. EQUIPMENT.
- PROVIDE SINGLE GANG RECESSED BOX FOR DATA BAYS.
- EXISTING 18" CABLE TRAY AS SHOWN.
- PROVIDE NEW 24" CABLE TRAY TO CORRIDOR.
- EXISTING 6000 W/INCH. PROVIDE COVER PLATES AS REQUIRED.

TECHNOLOGY PLAN UNIT P2	
DRAWN BY: JED	COMM. NO.: 95067.00
CHECKED BY: RSB	DATE: MAY 3, 1999
TE3.23	REVISIONS NO. DATE

Fanning/Howey Associates, Inc.
Architects Engineers Consultants

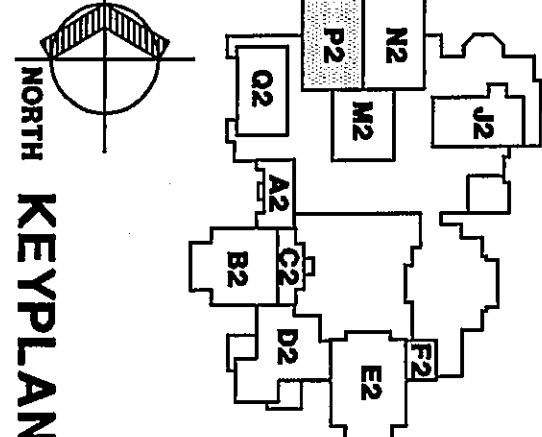

THE NEW
CHESTERTON HIGH SCHOOL
TECHNOLOGY PACKAGE
DUNELAND SCHOOL CORPORATION
CHESTERTON, INDIANA

COPYRIGHT 1999 BY FANNING/HOWEY ASSOCIATES, INC.

Professional Engineer
No. 3009
Indiana
Architect
D. M. Wicks