


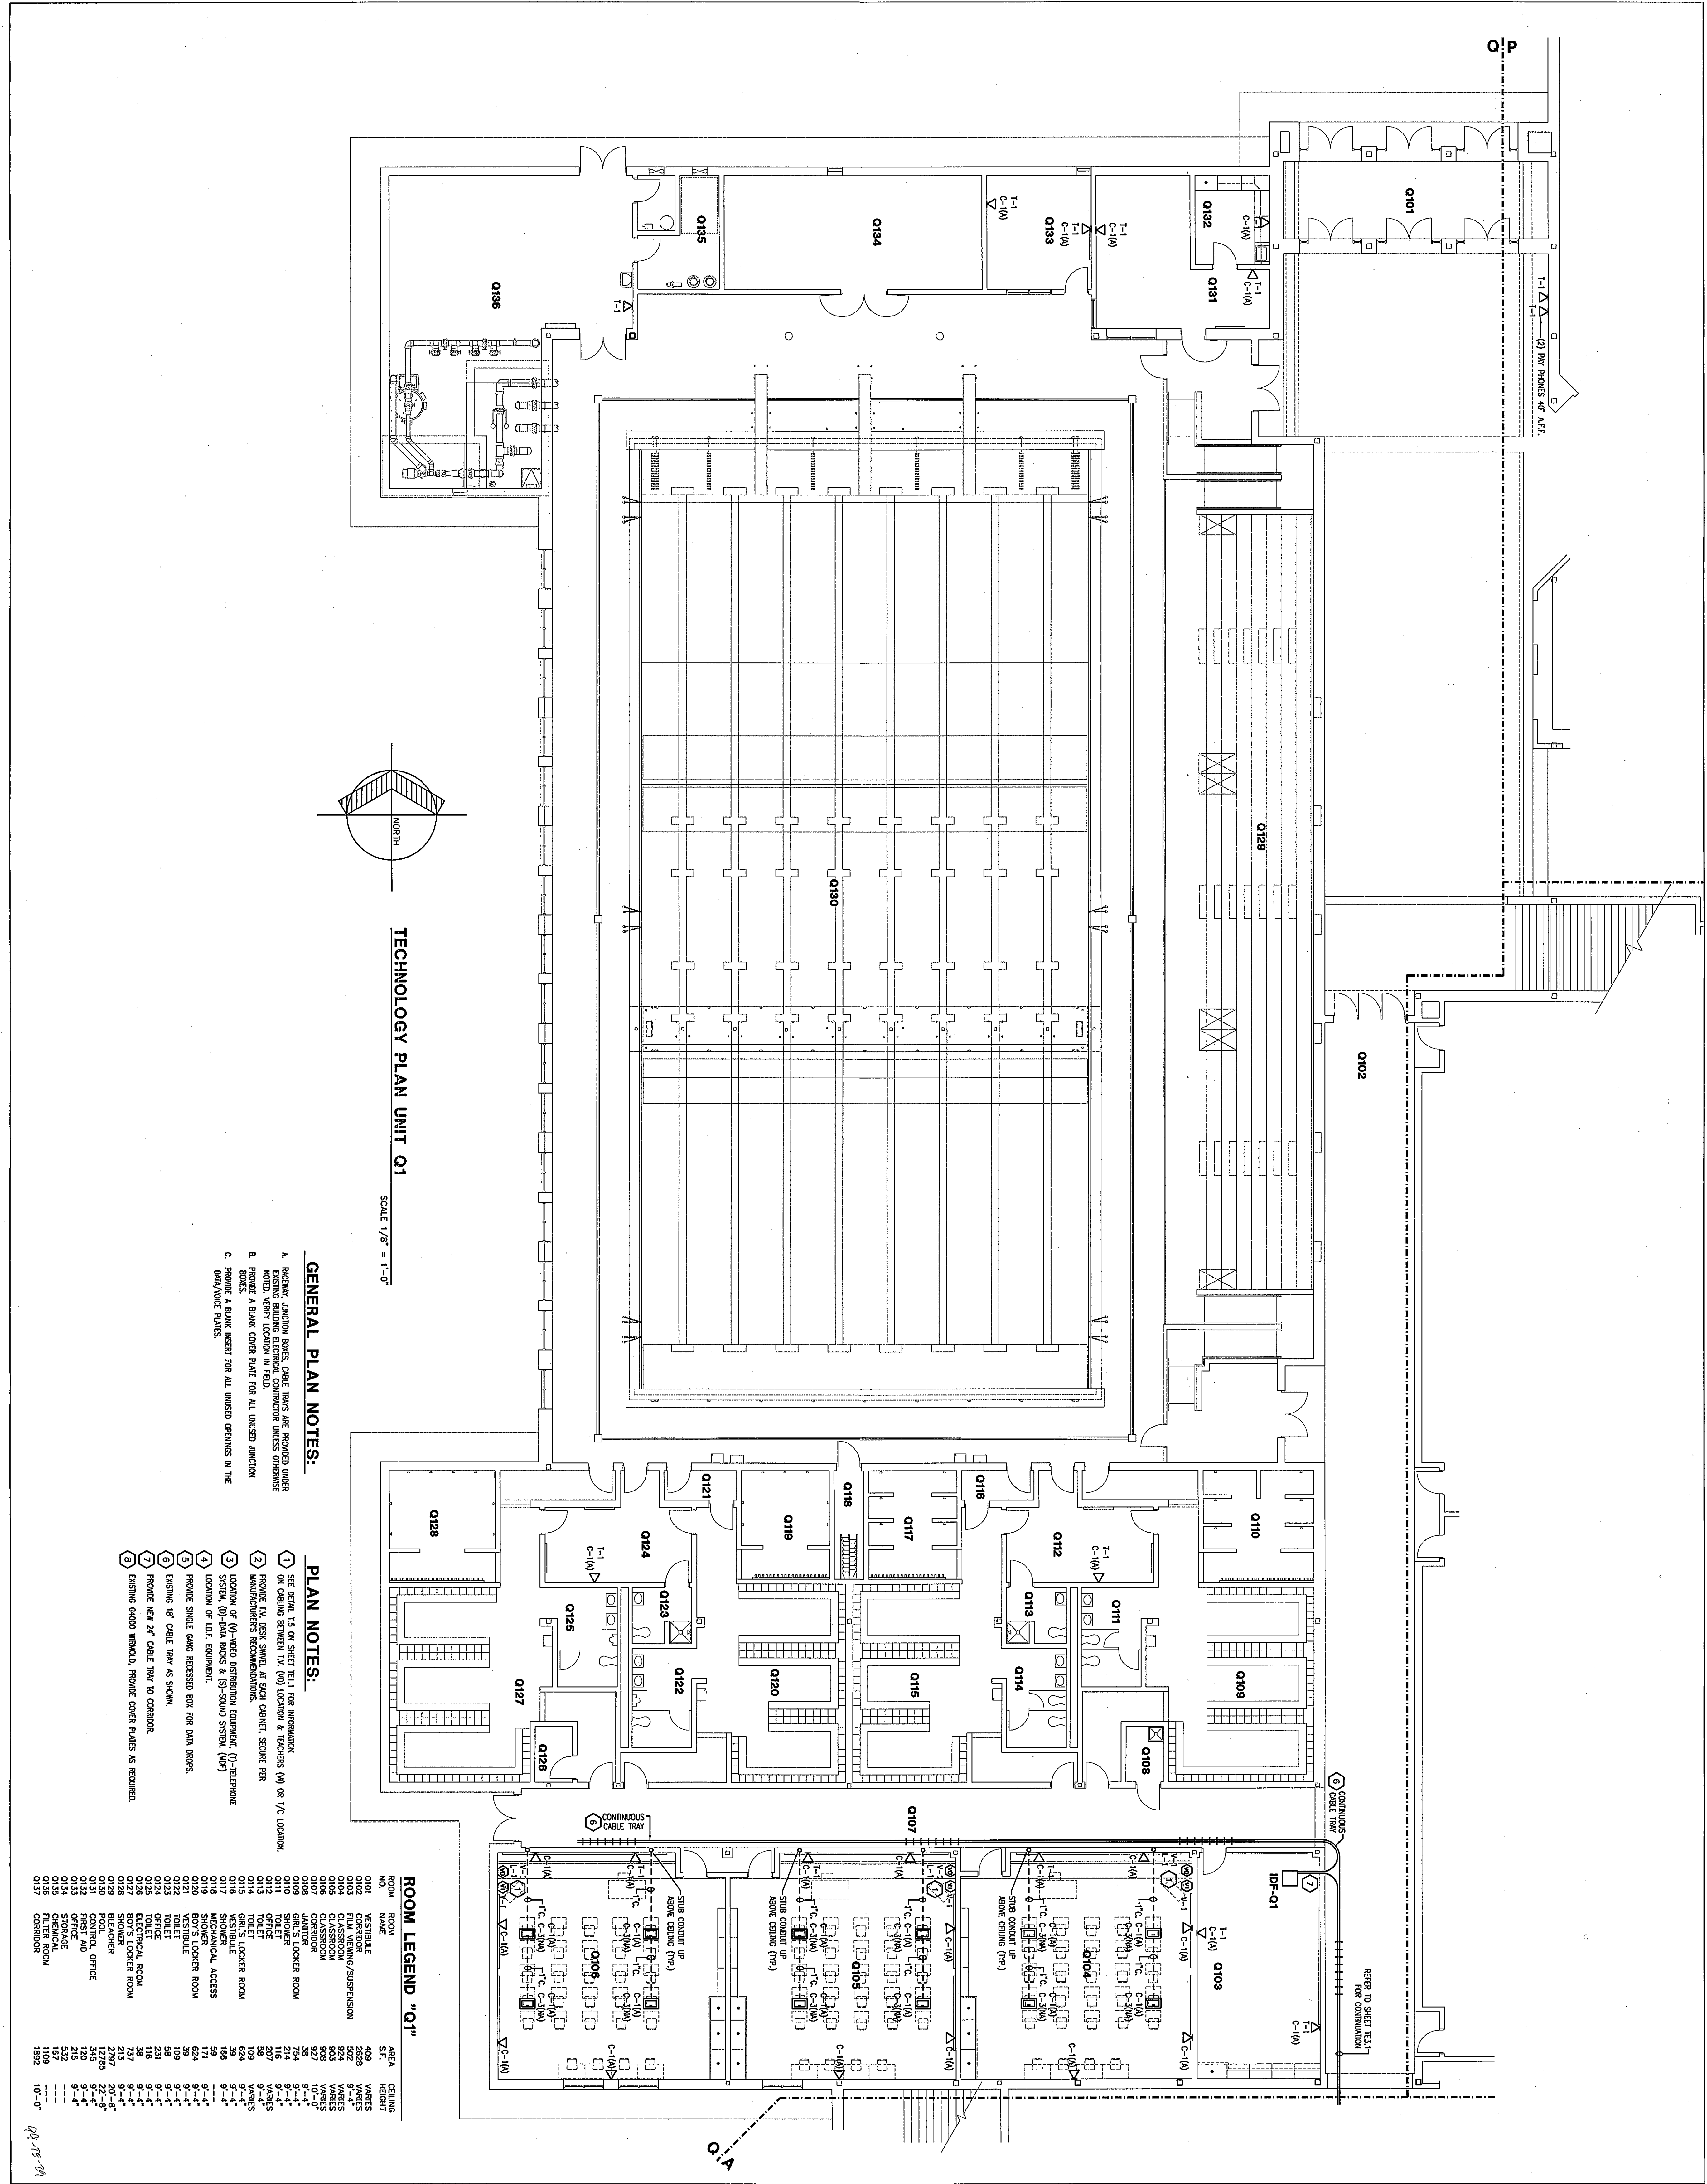

TECHNOLOGY PLAN UNIT Q1

DRAWN BY: JED COMM. NO.: 95067.00

CHECKED BY: RSB DATE: MAY 3, 1999

TE3.24

REVISIONS NO. DATE

Fanning/Howey Associates, Inc.

Architects Engineers Consultants

KEY PLAN

THE NEW CHESTERTON HIGH SCHOOL TECHNOLOGY PACKAGE

DUNELAND SCHOOL CORPORATION CHESTERTON, INDIANA

COPYRIGHT 1999 BY FANNING/HOWEY ASSOCIATES, INC.

NO. 3009

ARCHITECT

REGISTERED