


SECURITY SITE PLAN
SCALE: 1"=100'-0"

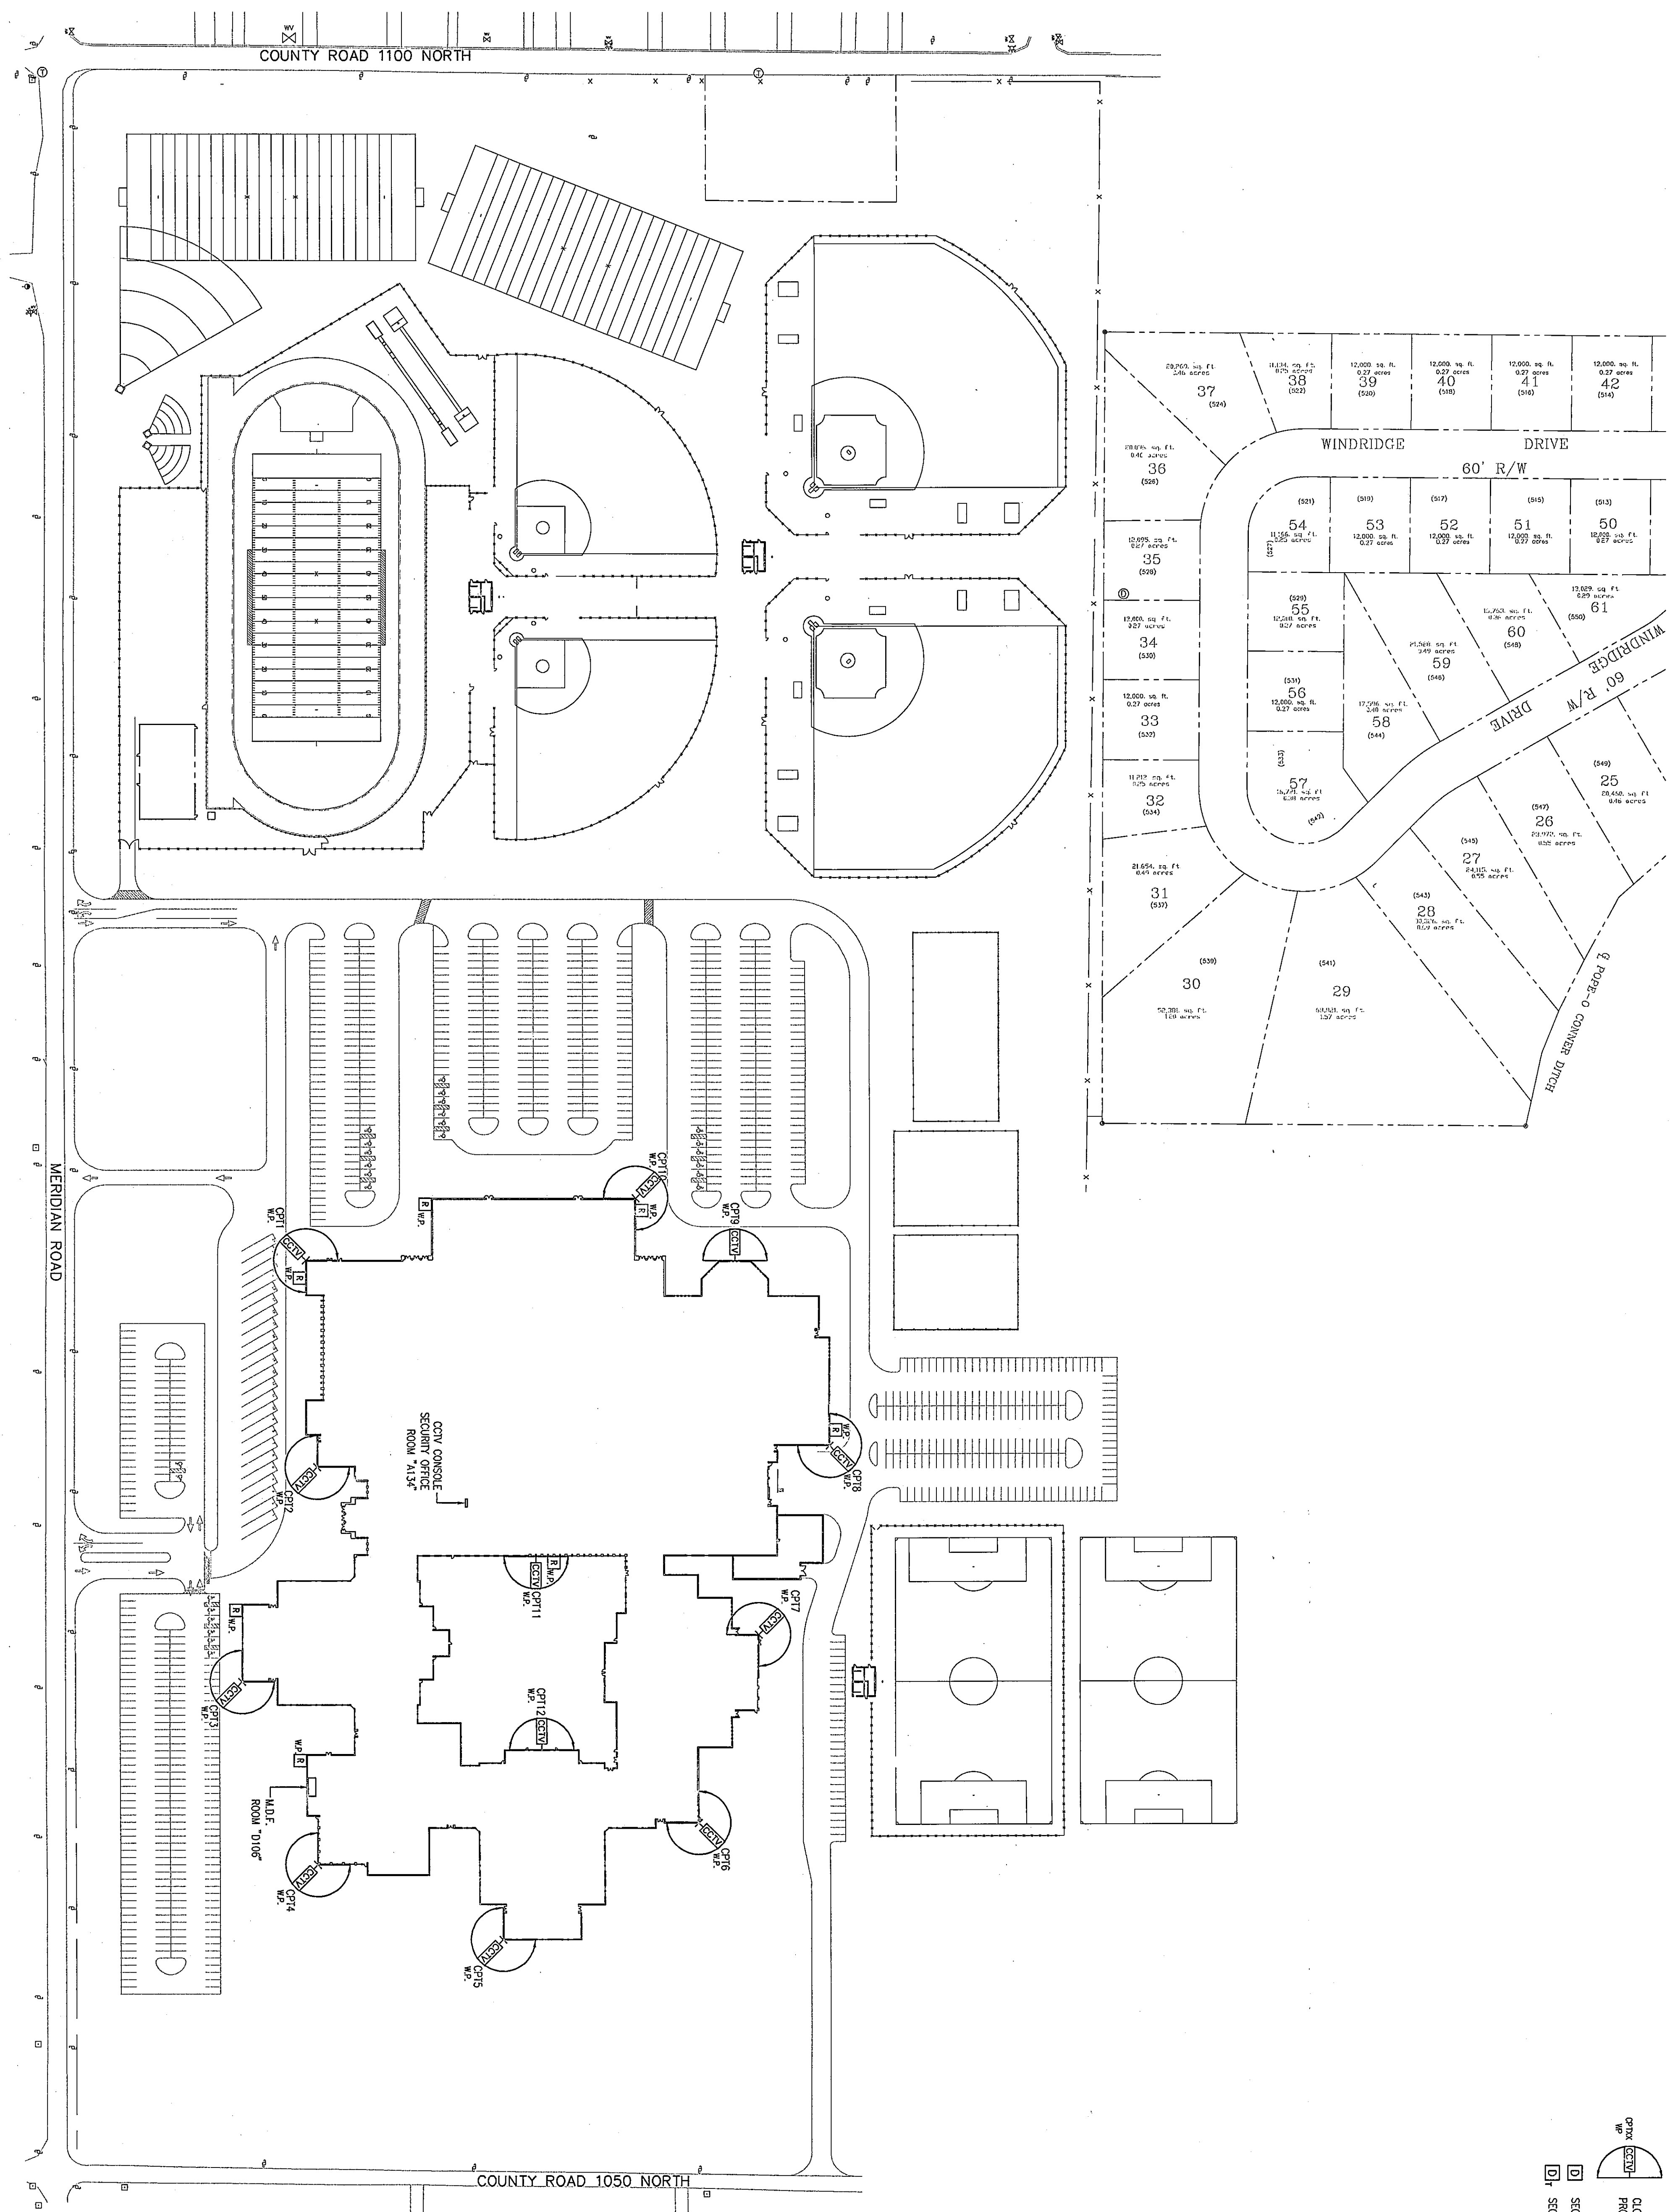


- SECURITY SITE PLAN LEGEND**
- SECURITY SIGNAL RECOVERY/TRANSMITTER RELAY
 - POWER TRANSFORMER
 - CLOSED CIRCUIT SECURITY CAMERA DONE WITH ONE FIXED CAMERA IN DIRECTION OF ARROW (C7X1)
 - CLOSED CIRCUIT SECURITY CAMERA DONE WITH TWO FIXED CAMERAS IN DIRECTION OF ARROWS (C7X2)
 - CLOSED CIRCUIT SECURITY CAMERA DONE WITH THREE FIXED CAMERAS IN DIRECTION OF ARROWS (C7X3)
 - CLOSED CIRCUIT SECURITY CAMERA WITH PAN/TILT HEAD IN WEATHER PROOF HOUSING (C7X4)
 - SECURITY DOOR CONTACT/CLOSER
 - SECURITY DOOR CONTACT/CLOSER TRANSMITTER

CHESTERTON HIGH SCHOOL
99136.01

SECURITY SITE PLAN	
DRAWN BY: JED	COMM. NO.: 99136.01
CHECKED BY: RSB	DATE: NOVEMBER 22, 1999
TE2.1	REVISIONS NO. DATE

Fanning/Howey Associates, Inc.
Architects Engineers Consultants

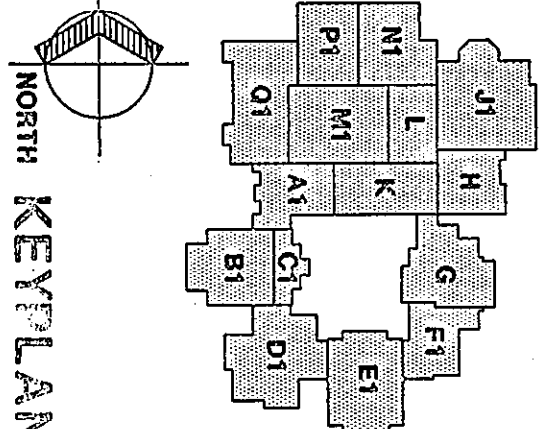

THE NEW
CHESTERTON HIGH SCHOOL
SECURITY PACKAGE
DUNELAND SCHOOL CORPORATION
CHESTERTON, INDIANA

