



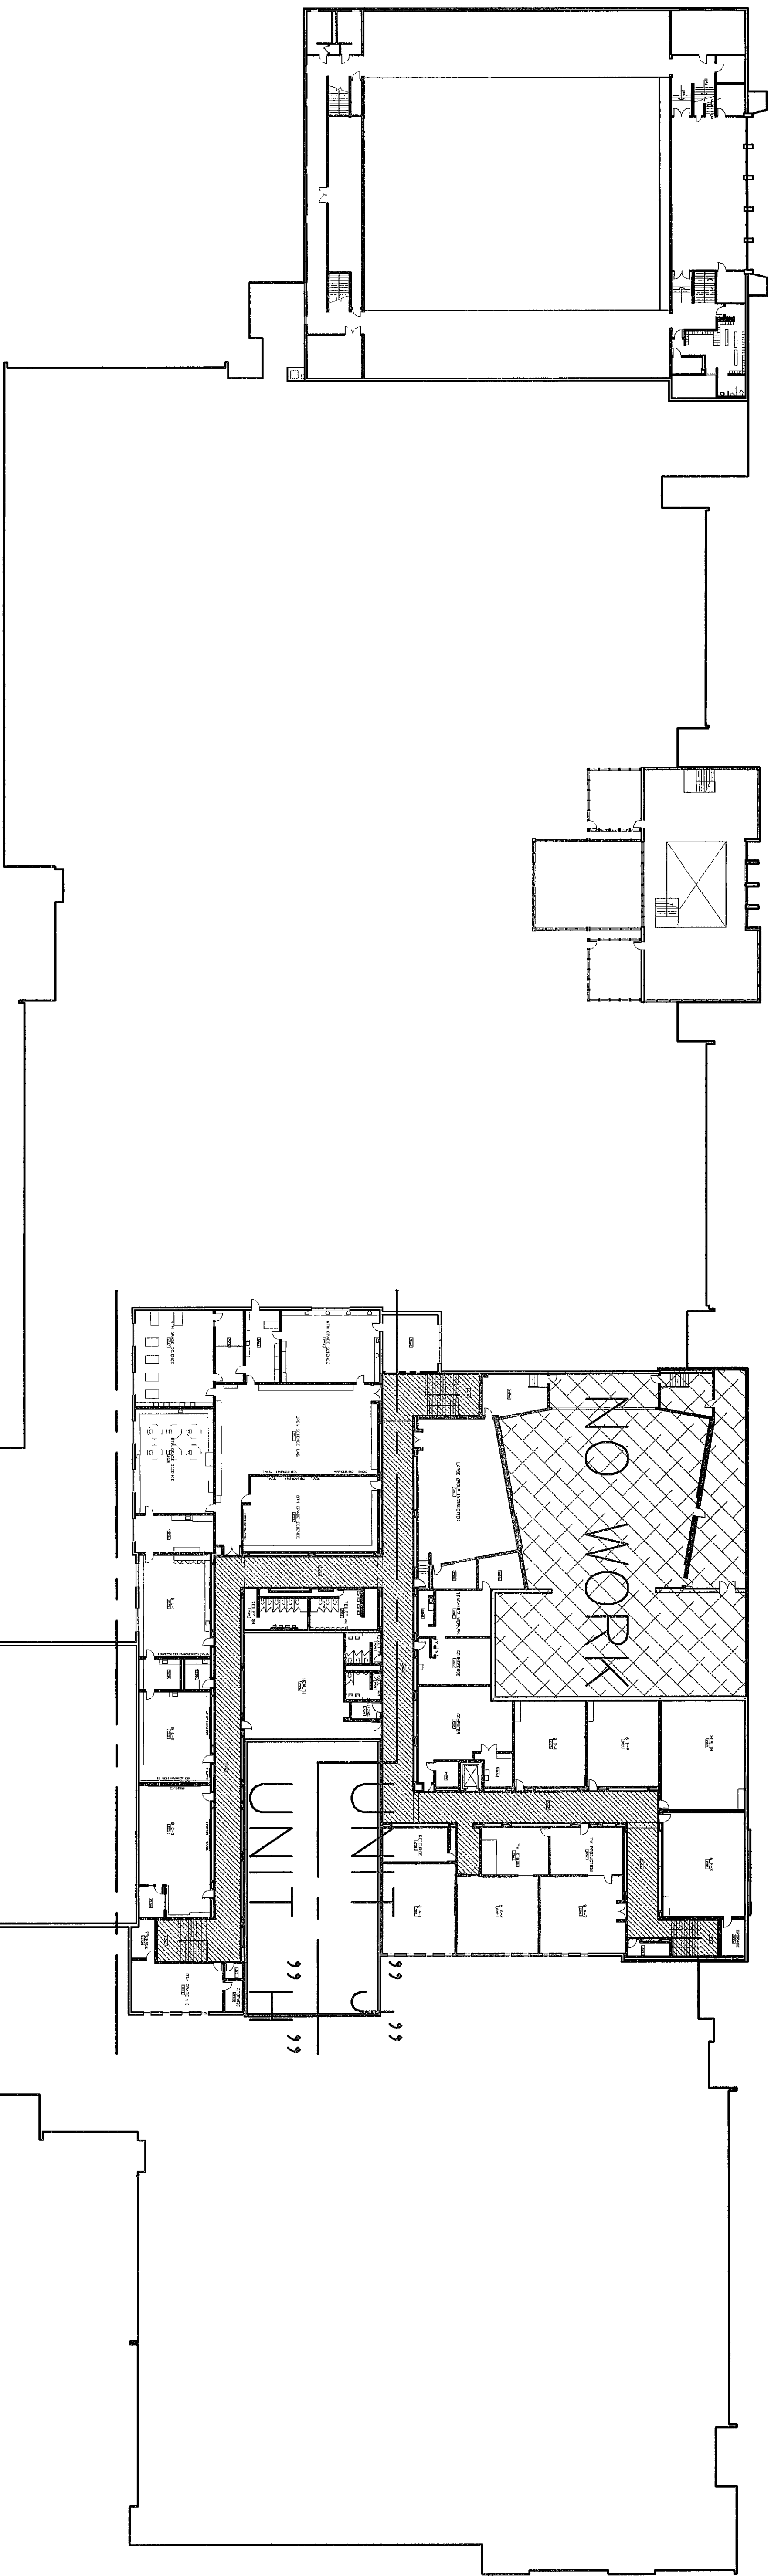

2 SECOND FLOOR PLAN
SCALE 1/32" = 1'-0"

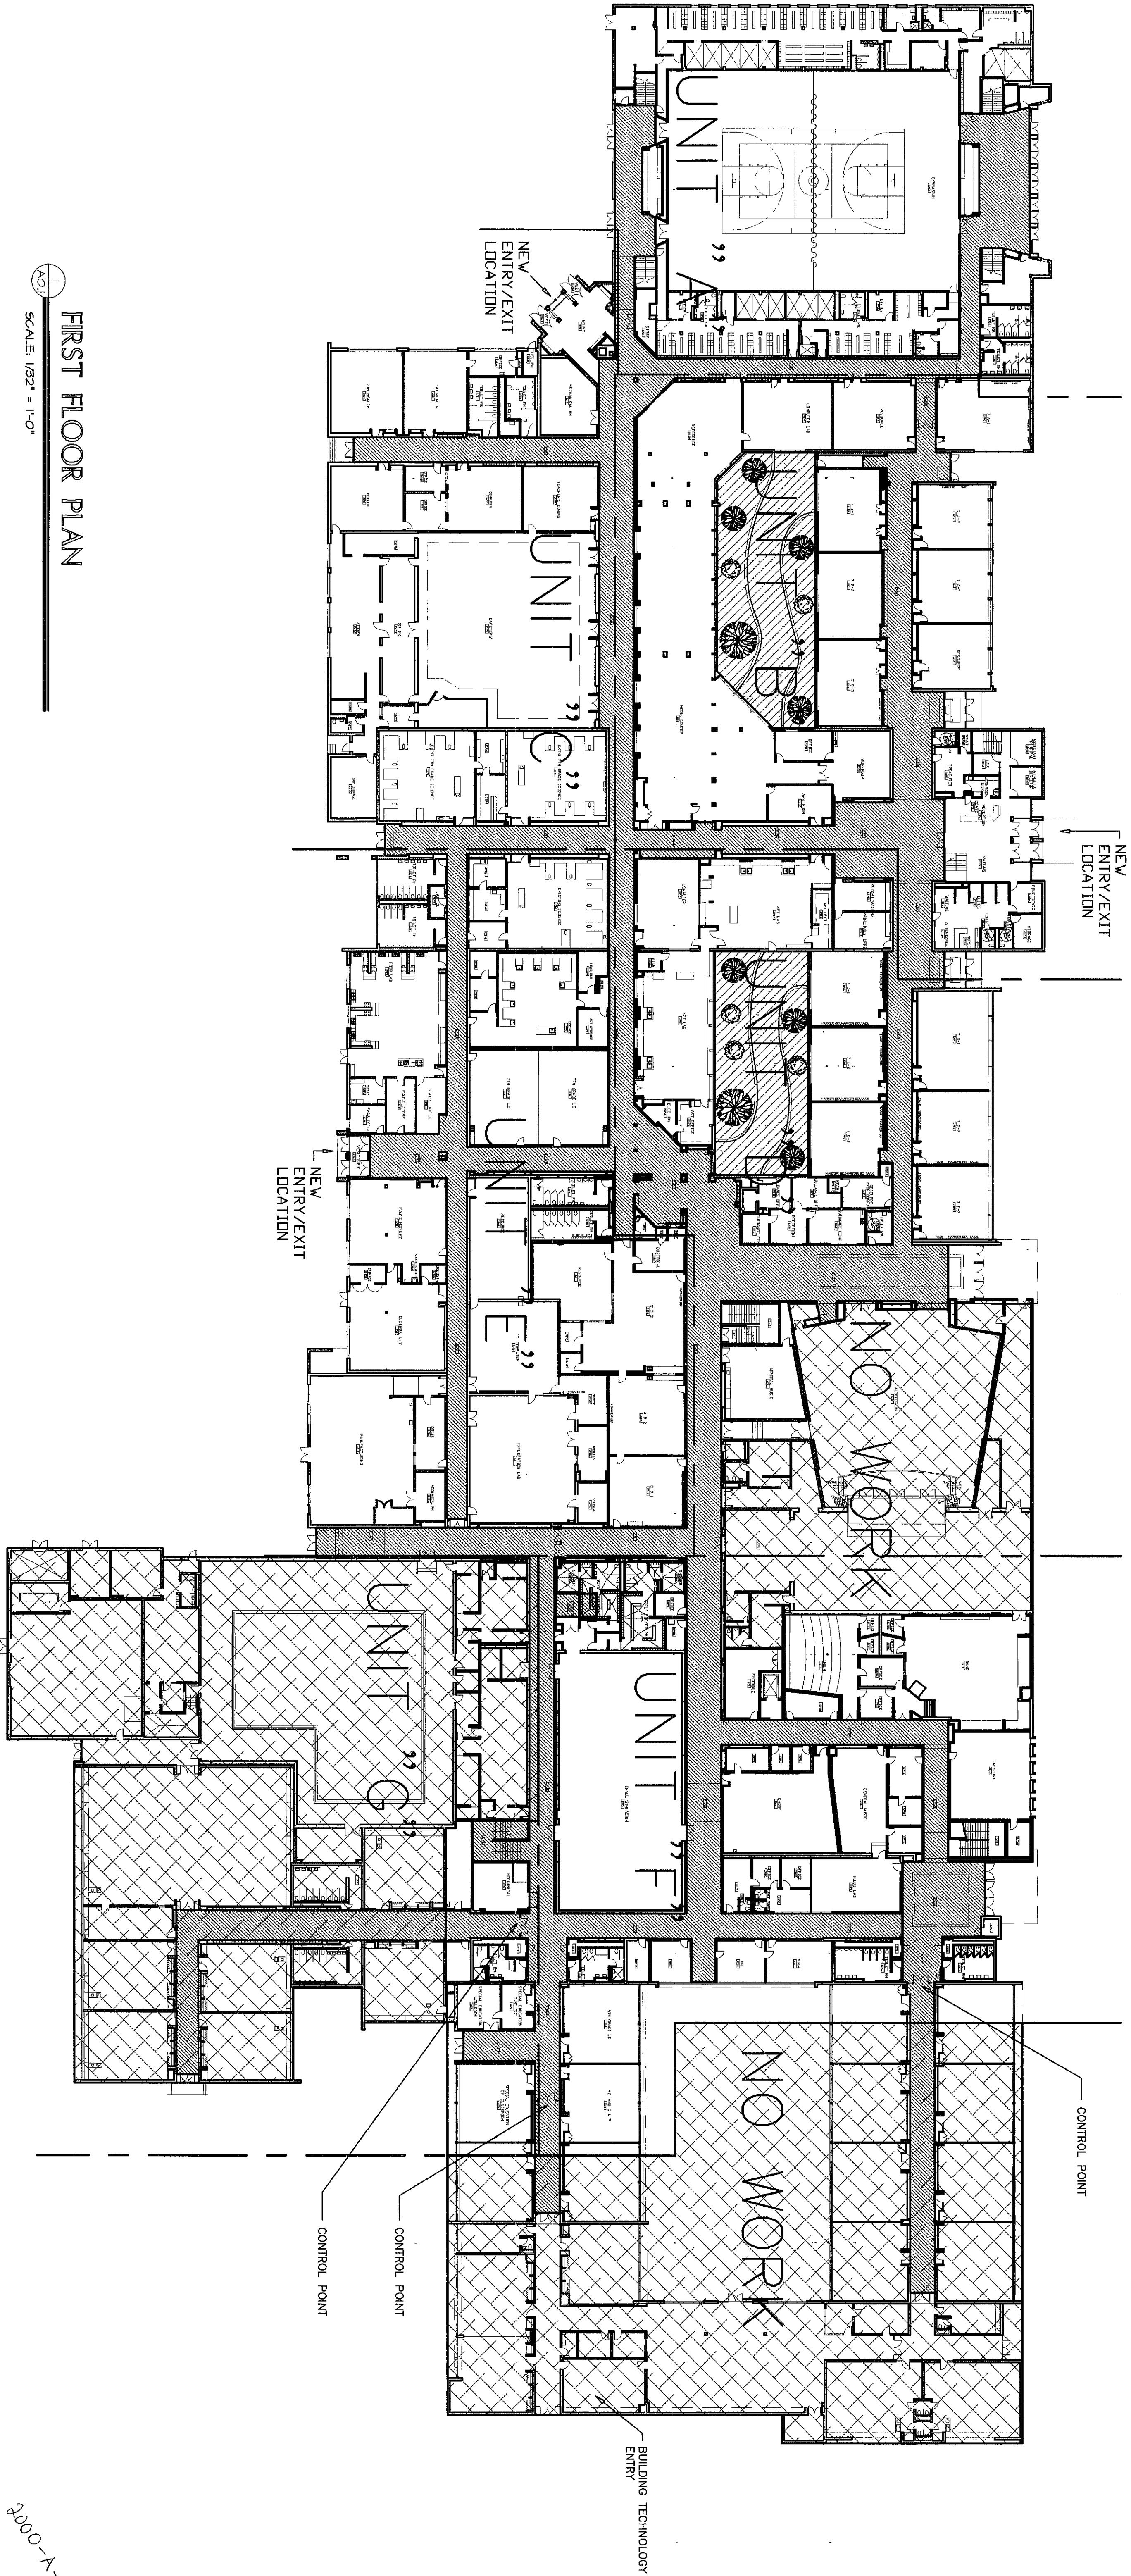

1 FIRST FLOOR PLAN
SCALE 1/32" = 1'-0"

LIFE SAFETY NOTES:

1. NO ADDITIONAL SQUARE FOOTAGE WILL BE ADDED TO THE BUILDING WITH THE EXCEPTION OF THE SOUTH INTERIOR COURTYARDS WILL BE EXPANDED. THIS WILL DECREASE THE TOTAL BUILDING SQUARE FOOTAGE.
2. THREE ADDITIONAL ENTRY/EXIT LOCATIONS WILL BE ADDED TO THE BUILDING. THESE ARE:
 - RECEPTION LOBBY
 - VESTIBULE 1057
 - VESTIBULE 1058
3. THREE CONTROL POINTS WILL BE ADDED TO THE BUILDING. THESE ARE AT DOORS,
 - C125A
 - C125B
 - C125C
4. THESE CONTROL POINTS ARE IMMEDIATELY ADJACENT TO EXISTING EXITS & NEW ENTRY/EXIT LOCATIONS. THESE ARE:
 - A. EXISTING CORRIDORS ARE NOT RATED HOWEVER NEW WALL DOORS OR WINDOWS AT A CORRIDOR WILL BE CONSIDERED AS A RATED CONDITION.
 - B. EXISTING FROM THE BALANCE OF THE BUILDING RESTRICTED.
5. EXISTING CORRIDORS ARE NOT RATED HOWEVER NEW WALL DOORS OR WINDOWS AT A CORRIDOR WILL BE CONSIDERED AS A RATED CONDITION.
6. FIRE EXTINGUISHERS WILL BE PROVIDED AT EACH NEW ENTRY.
7. FIRE ALARM SYSTEM WILL BE BROUGHT INTO ADA COMPLIANCE.
8. EXISTING CORRIDORS, SOME AS VARIATION AS 11/2" FOR MAIN CORRIDOR.
9. SEVERAL EXISTING CLASSROOMS EXCEED 1000 S.F. THESE WILL BE RECONFIGURED & EXISTING WILL REMAIN AS IS.
10. FIRE SPRINKLERS WILL NOT BE INSTALLED.

NOTES: NO WORK REFERS TO NO ARCHITECTURE RENOVATION. SEE MECHANICAL/ELECTRICAL PLANS FOR WORK IN AREAS NOTED AS **NO WORK**.

NORTH
SCALE: 1/16" = 1'-0"

ARCHITECTS
ENGINEERS
PLANNERS


VEAZEY
PARROTT
DURKIN &
SHOULDERS

RENOVATION PROJECT FOR:
DUNELAND SCHOOL
CORPORATION
CHESTERTON MIDDLE SCHOOL
CHESTERTON, INDIANA

KEY FLOOR PLANS

Drawing Title:

Project No:	4420.00
Project Date:	06-12-00
Drawn By:	JPB/PKB
Approved By:	VPS
Drawing No:	A 0.1

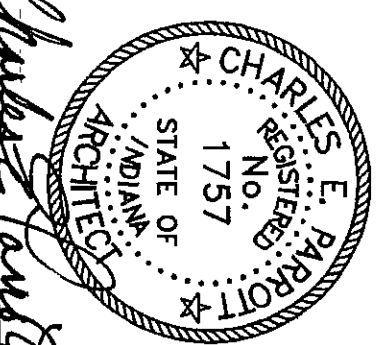

2000-A-02