



CHESTERTON MIDDLE SCHOOL
FFE = 100.00

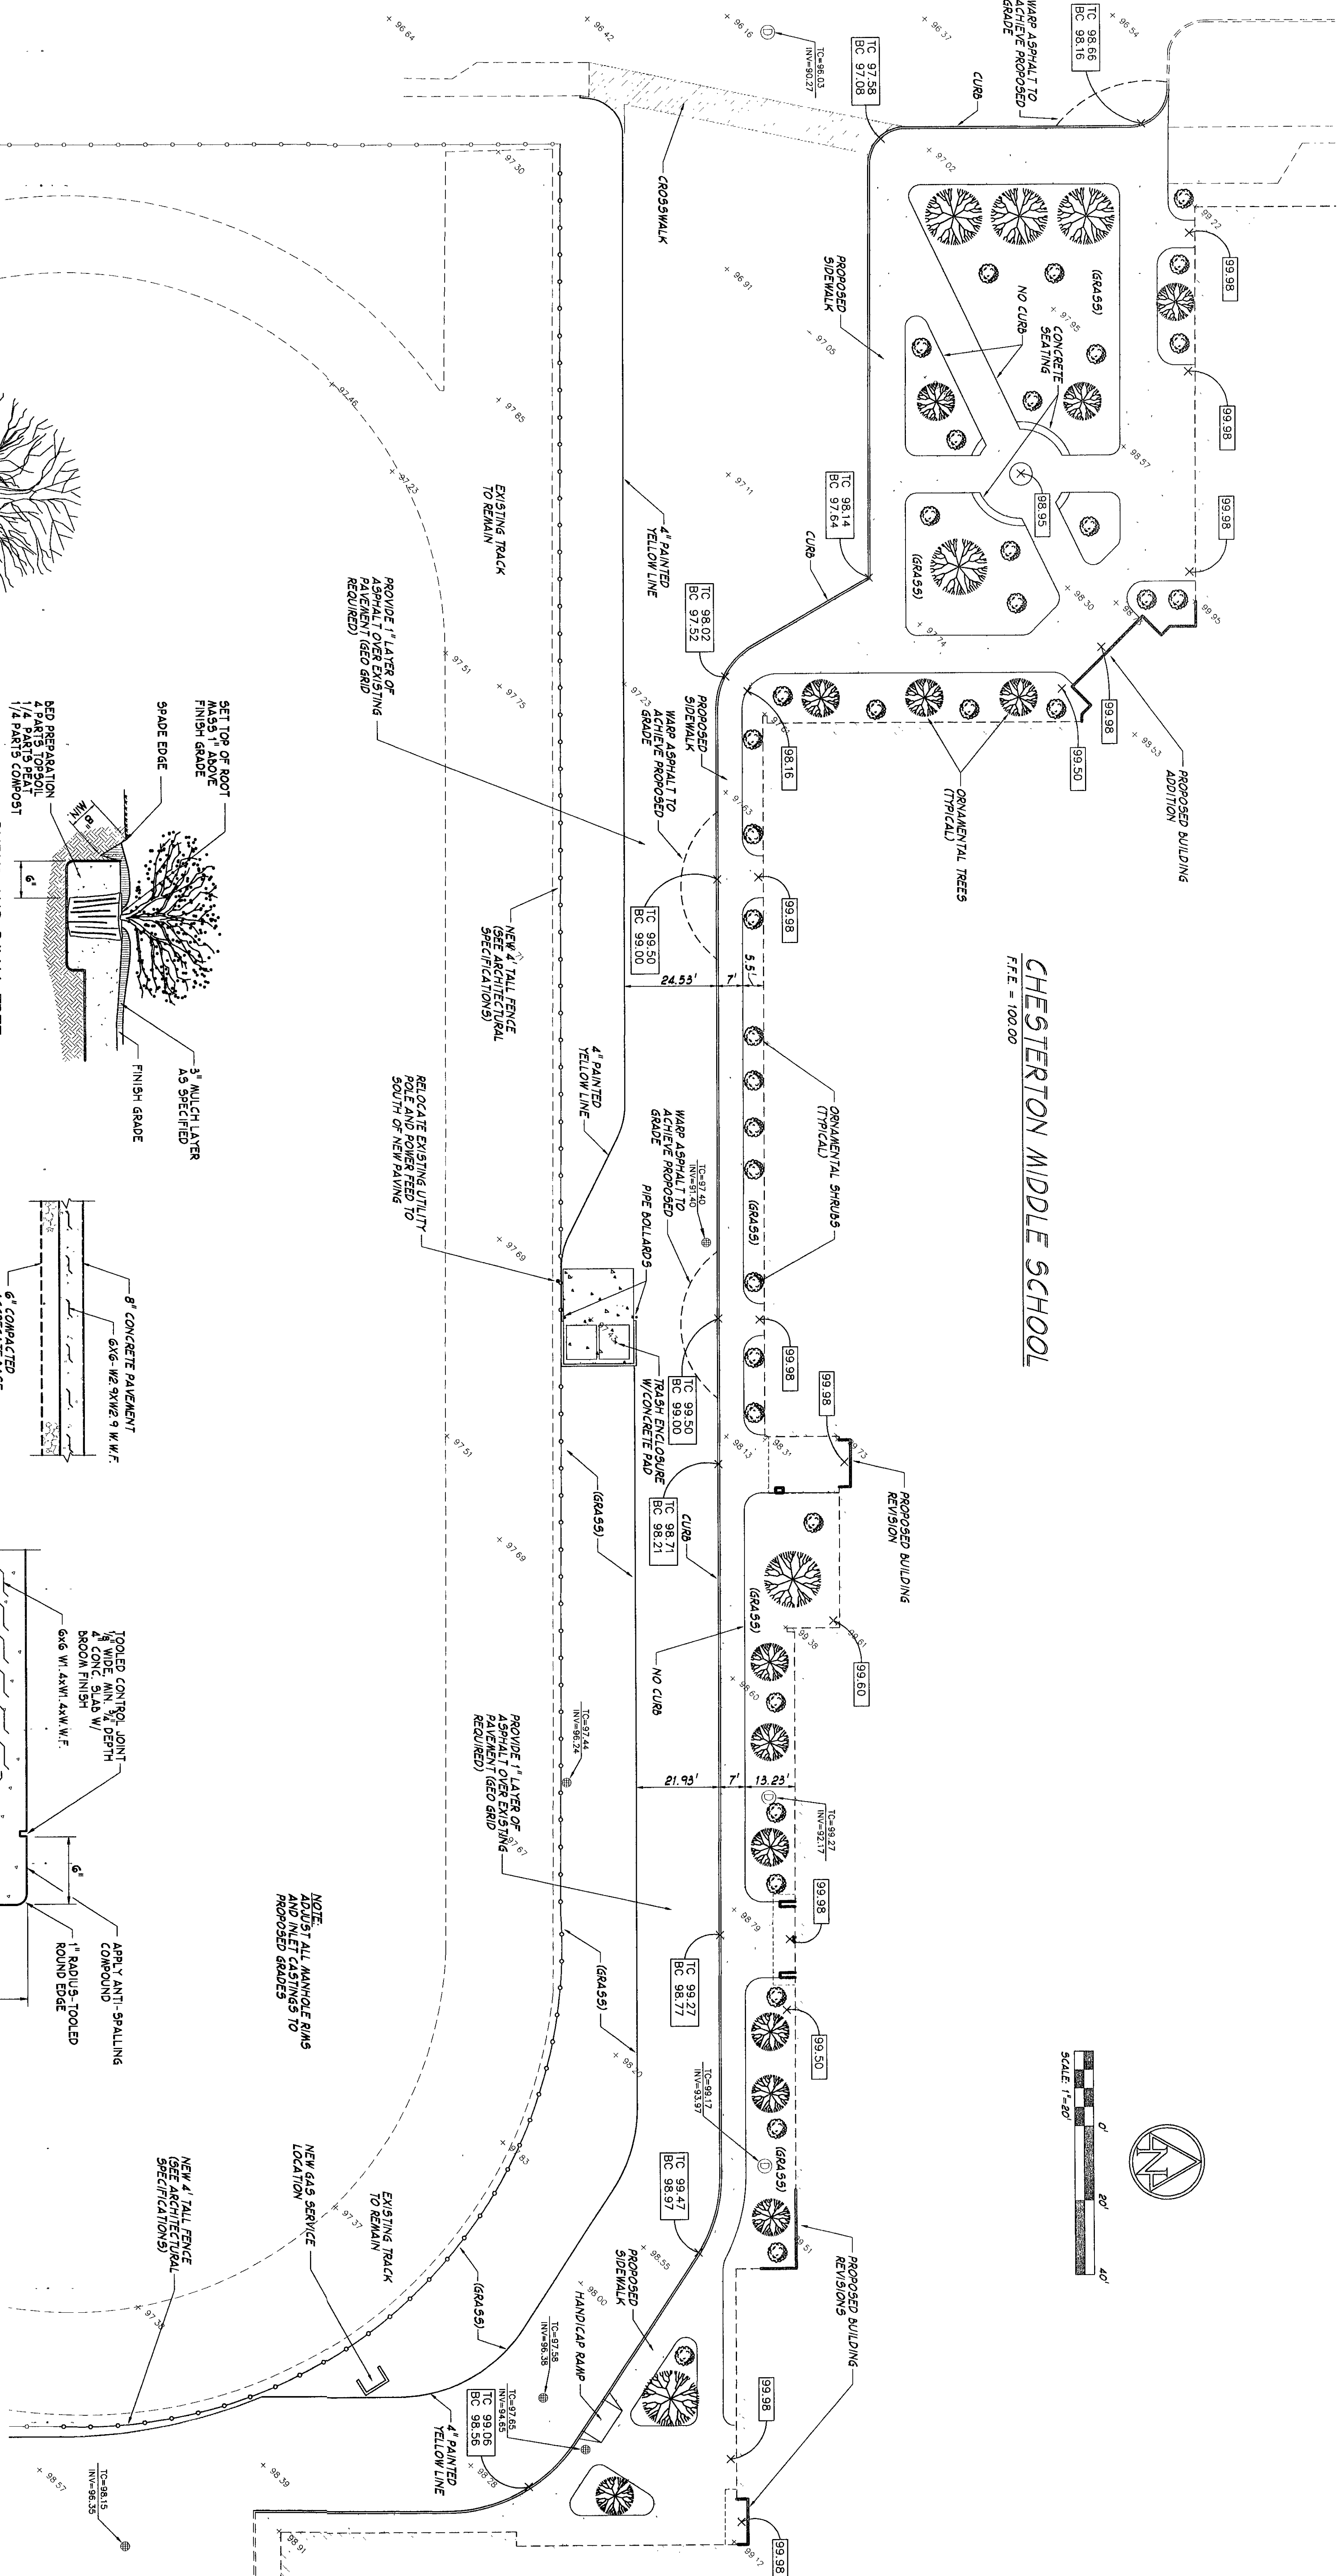


NOTE: ADJUST ALL MANHOLE RIMS AND MET CASTINGS TO PROPOSED GRADES

NEW GAS SERVICE LOCATION
EXISTING TRACK TO REMAIN


NEW 4' TALL FENCE
(SEE ARCHITECTURAL SPECIFICATIONS)

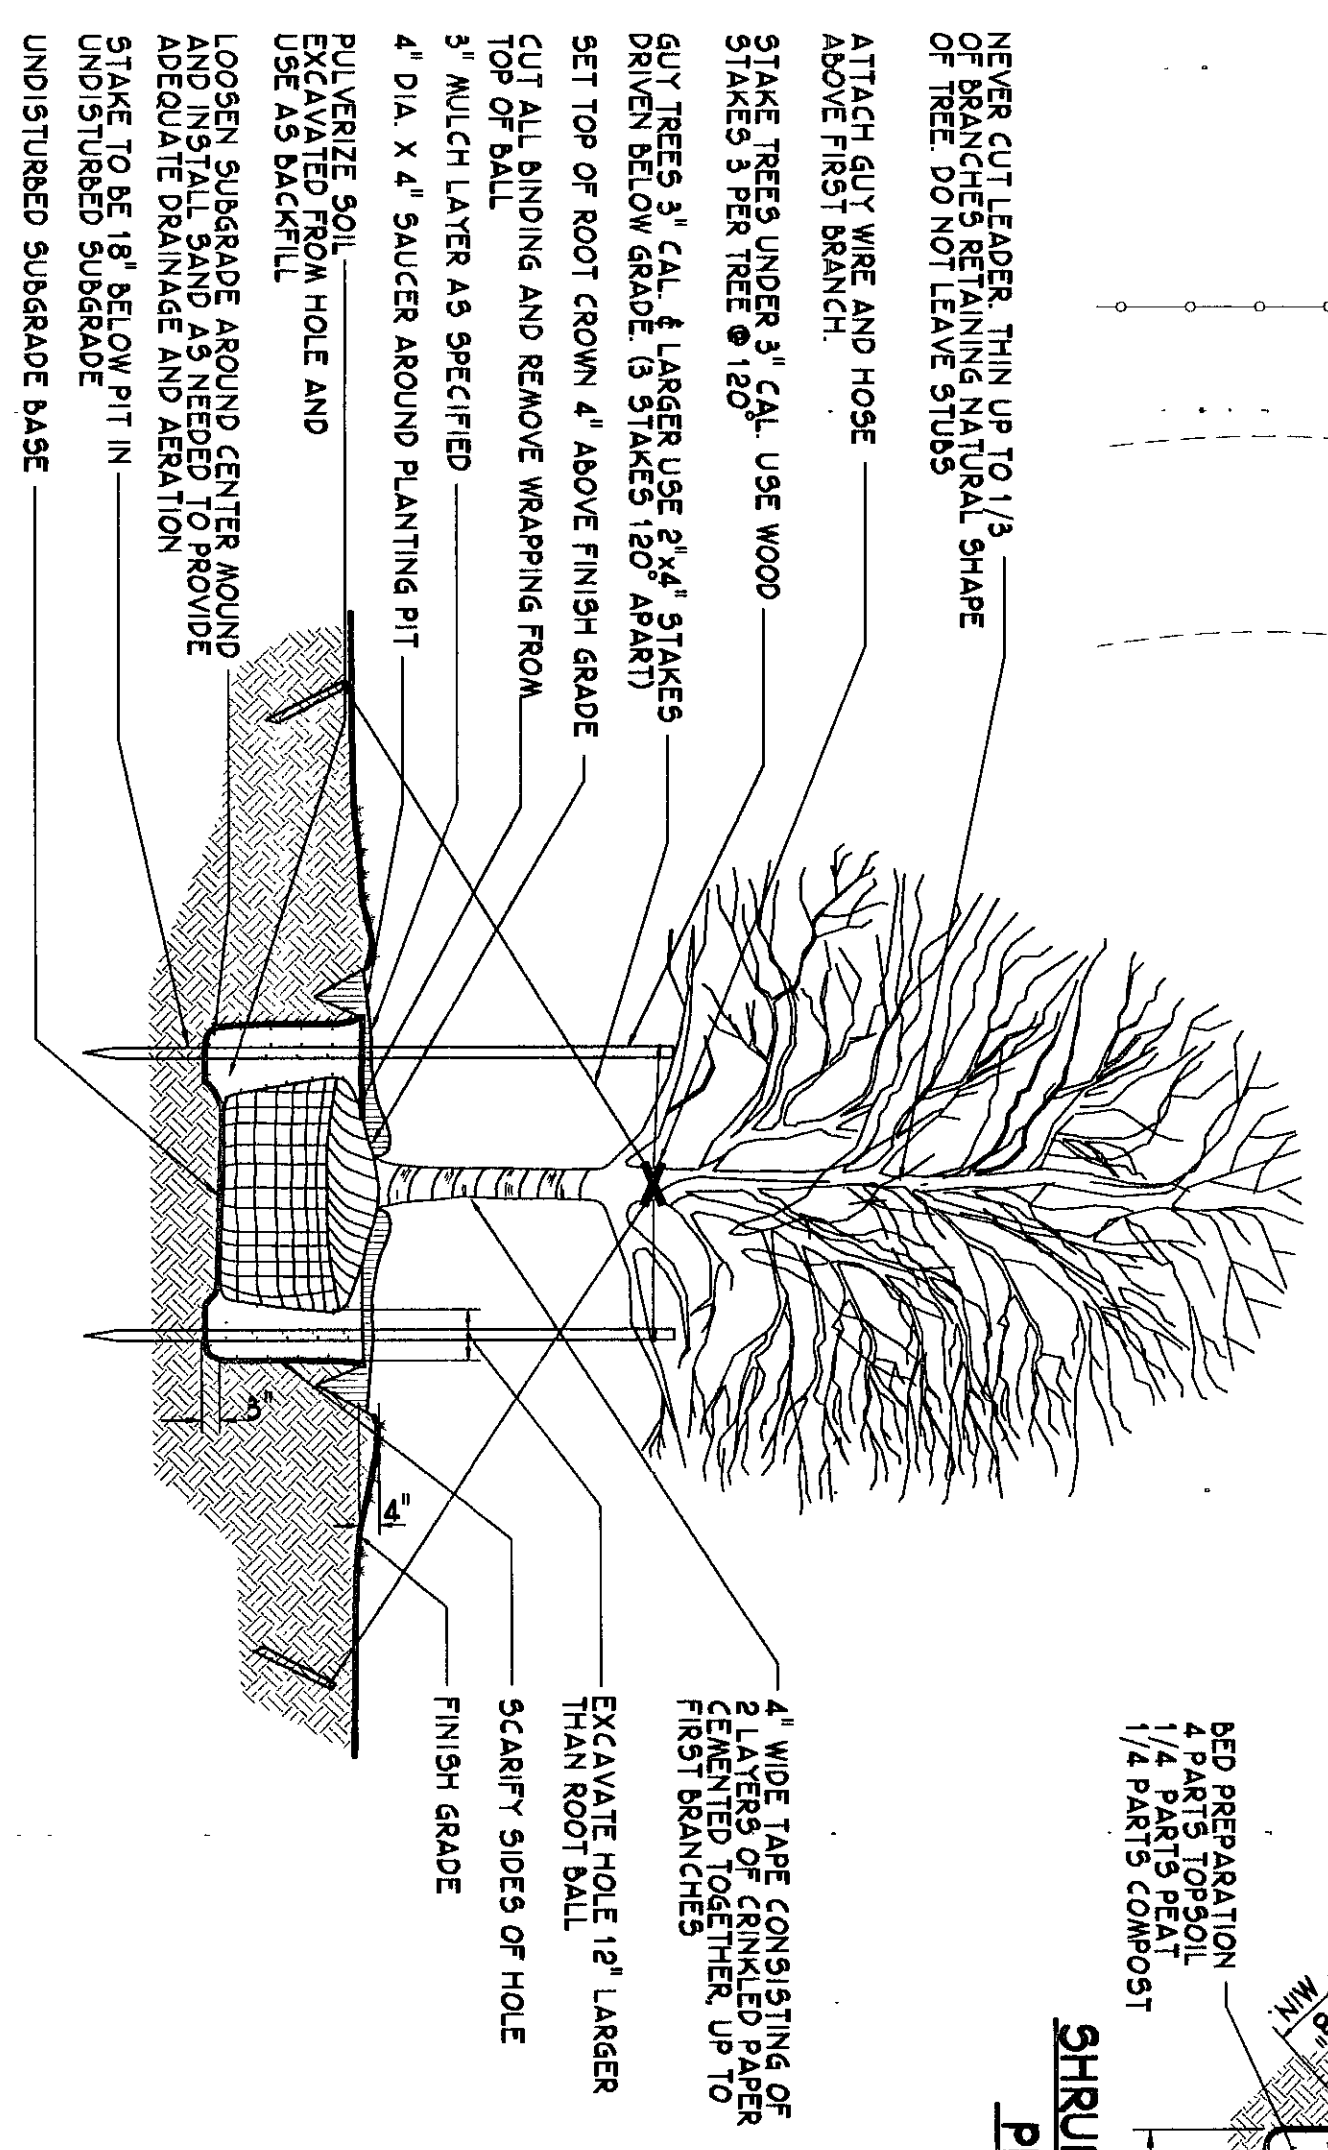


SHADE TREE PLANTING DETAIL
NOT TO SCALE

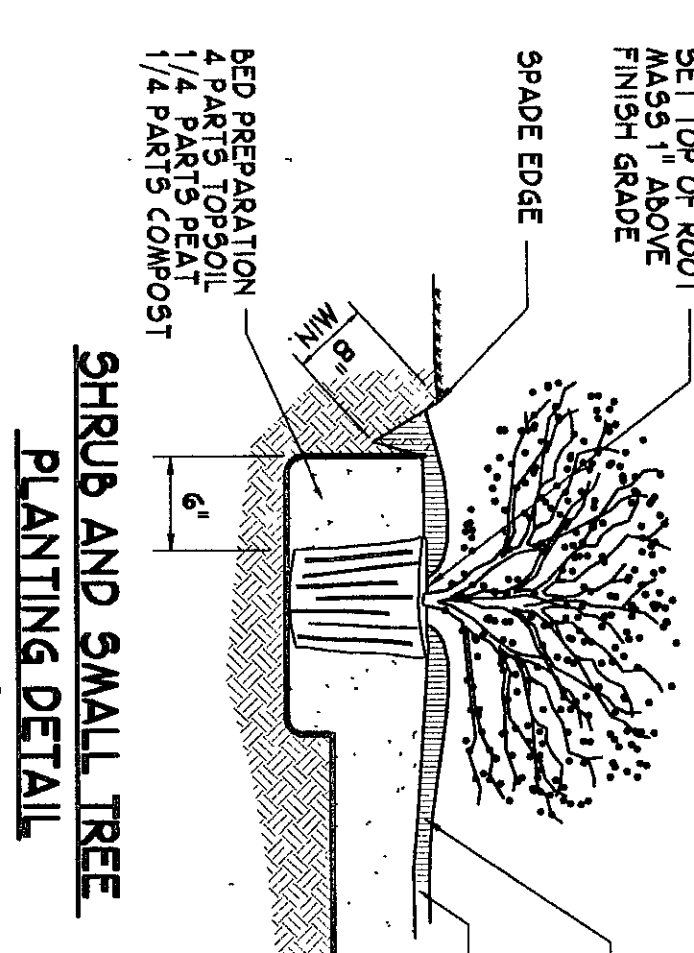


SHRUB AND SMALL TREE
PLANTING DETAIL
NOT TO SCALE

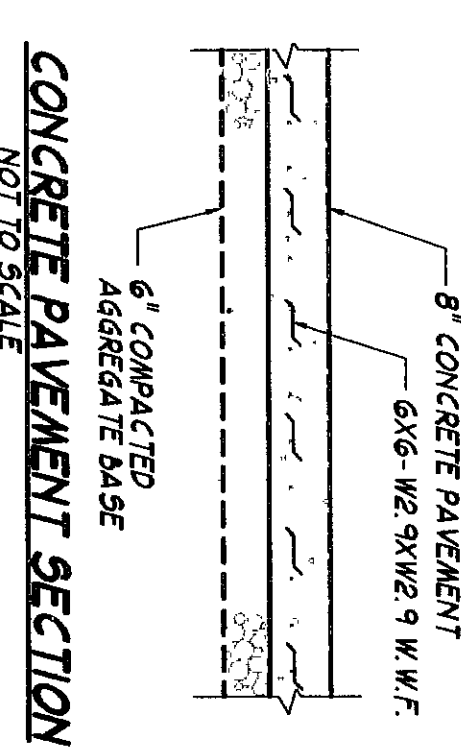


CONCRETE PAVEMENT SECTION
NOT TO SCALE

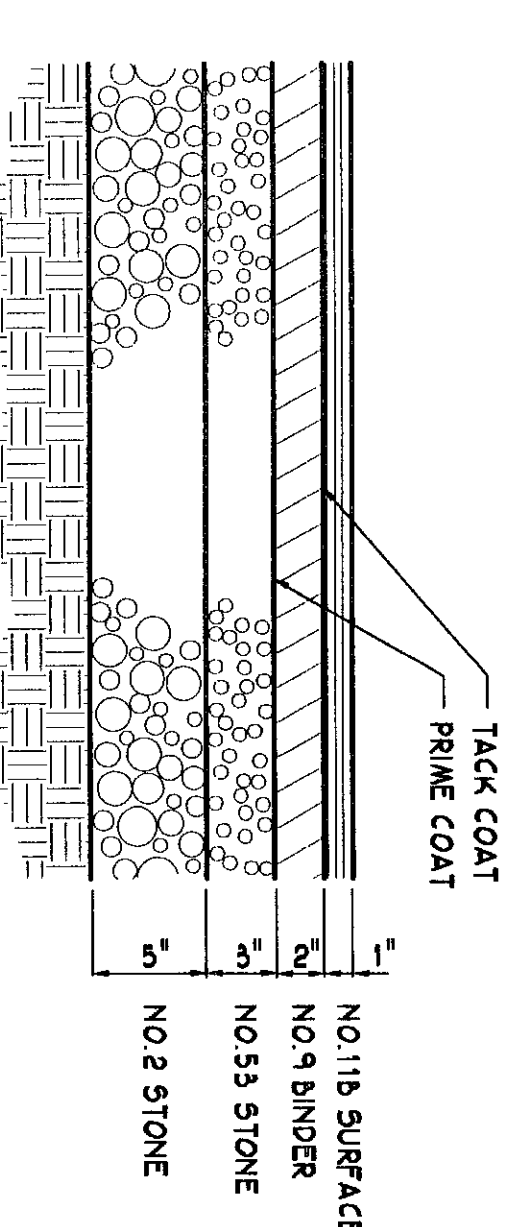


HEAVY DUTY ASPHALT
PAVEMENT SECTION
NOT TO SCALE

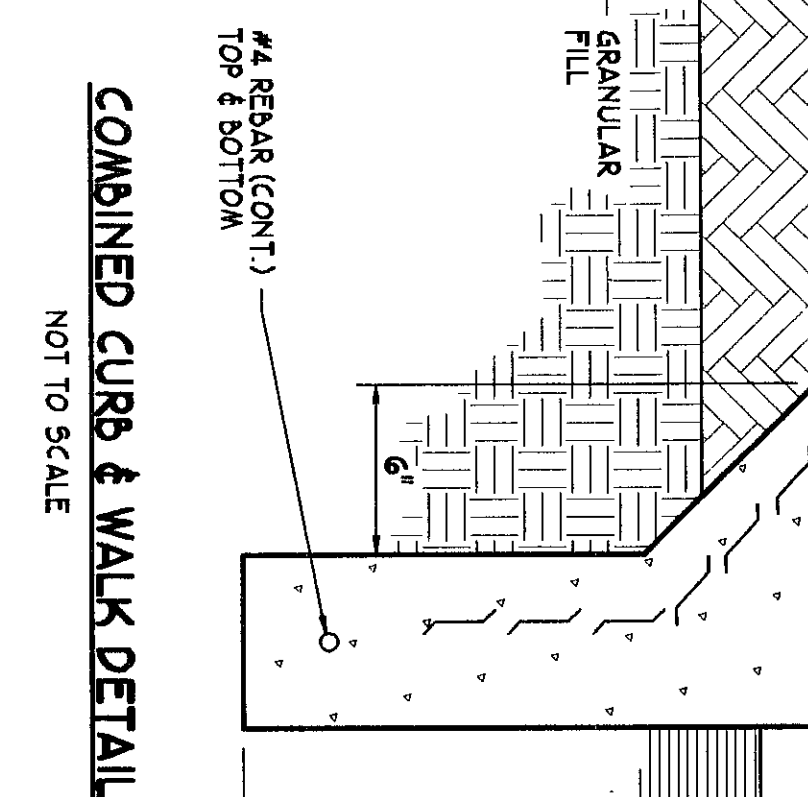


COMBINED CURB & WALK DETAIL
NOT TO SCALE

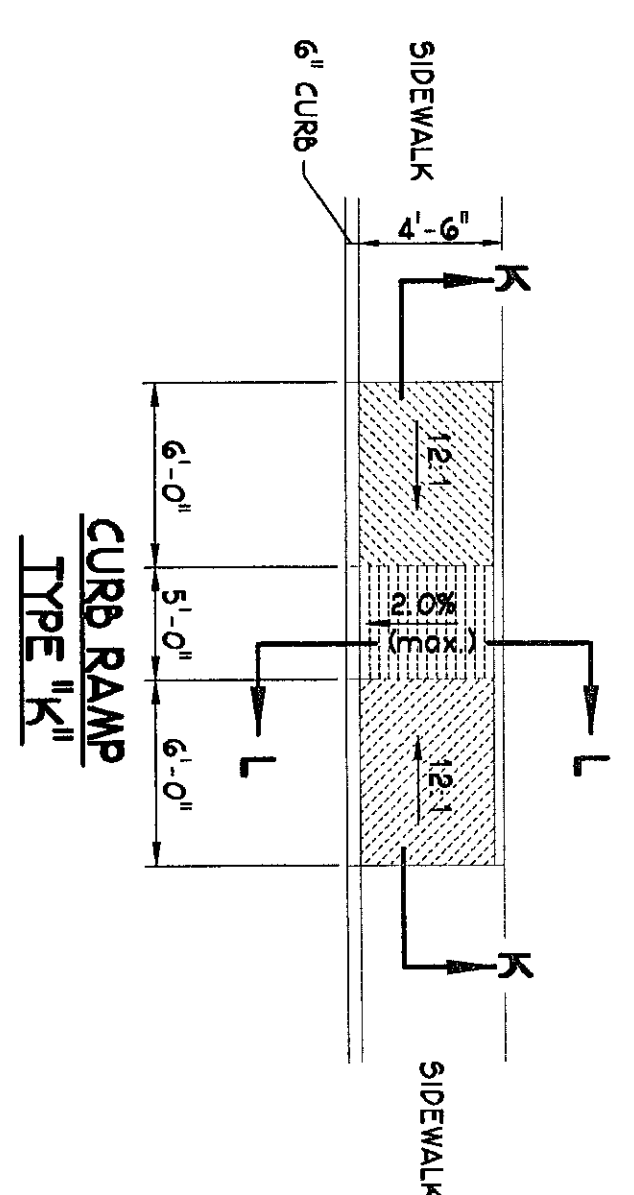


CURB RAMP
TYPE K1

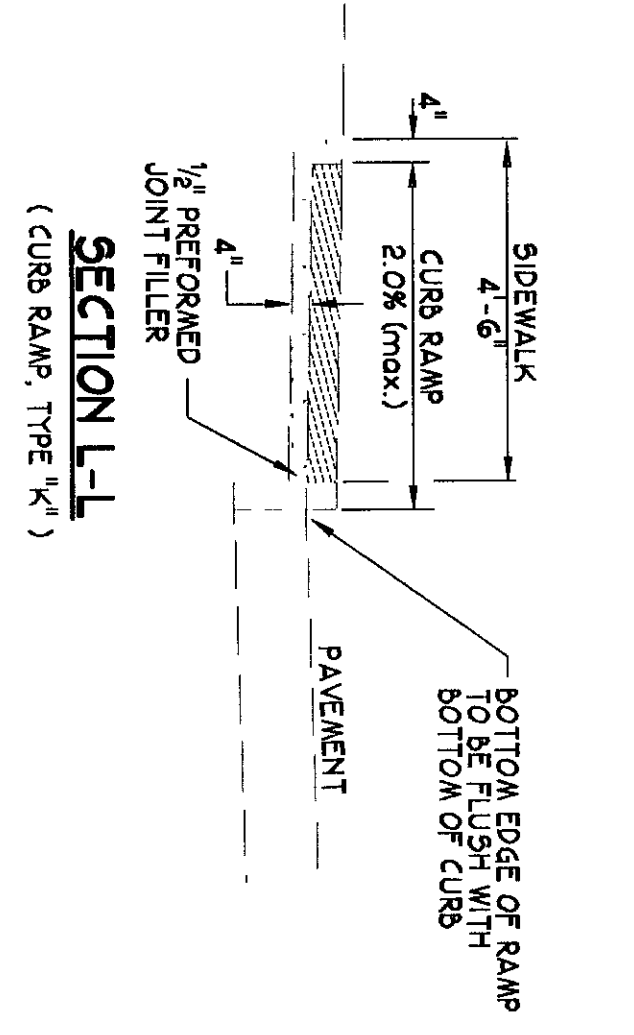

SECTION L-L
(CURB RAMP TYPE K1)

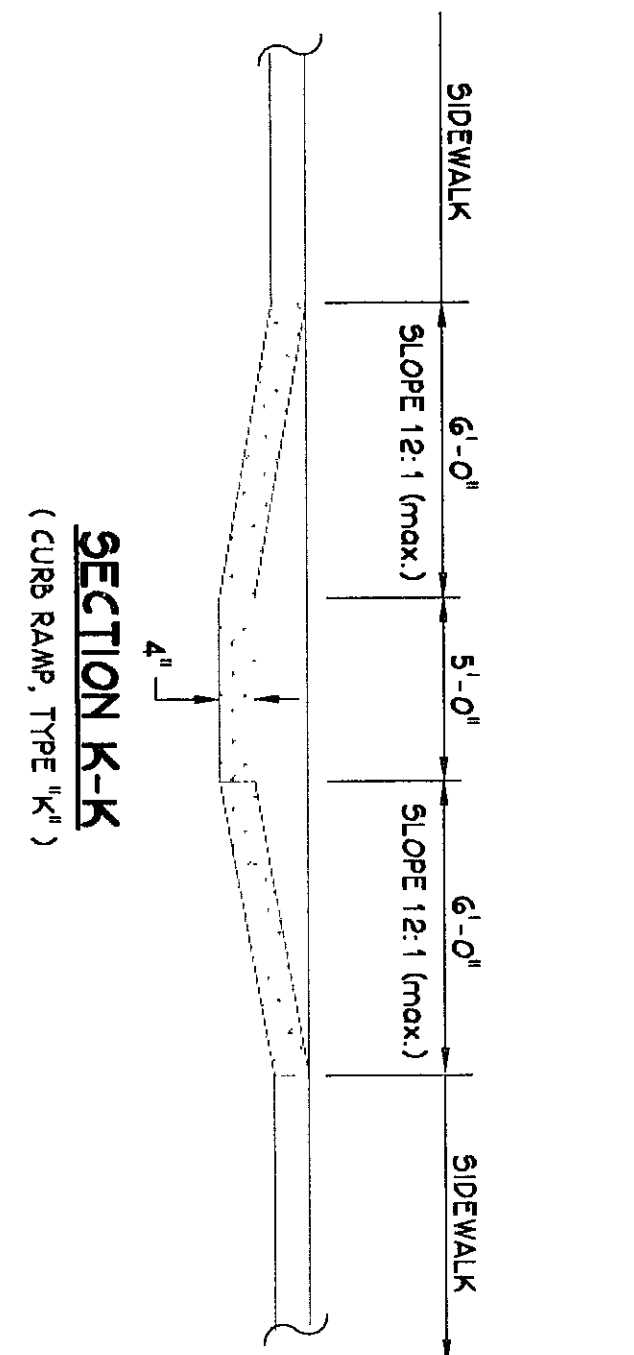

SECTION K-K
(CURB RAMP TYPE K1)

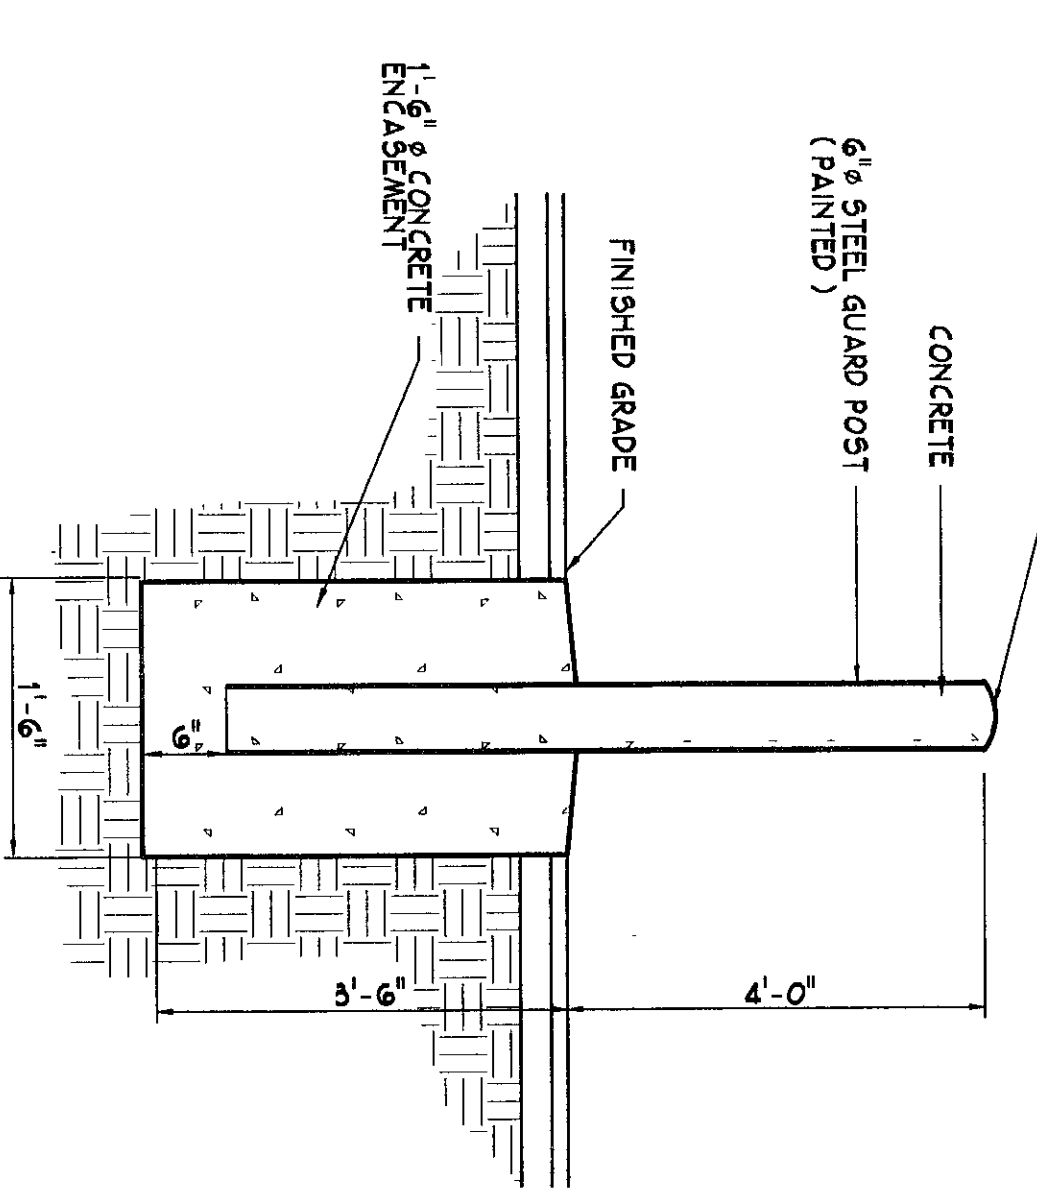

PIPE COLLAR DETAIL
NOT TO SCALE

AMERICAN CONSULTING, INC.
Architects
465 MILLERSVILLE ROAD
INDIANAPOLIS, IN 46205-2988
PH 317-558-0000 FAX 317-544-0070
Copyright (C) 1988-2000 by American Consulting, Inc.
American Consulting, Inc. Project Number IN2000-0200

**VEAZEY
PARROTT
DURKIN &
SHOULDERS**
ARCHITECTS
ENGINEERS
PLANNERS
3000 Century Way, S.W.
Indianapolis, IN 46202

RENOVATION PROJECT FOR:
DUNELAND SCHOOL
CORPORATION
CHESTERTON MIDDLE SCHOOL
CHESTERTON, INDIANA

**SITE/GRADING PLAN
AND TYPICAL DETAILS**
Project No. 2000-0200
Project Date: 06/12/00
Drawn By: BLP
Approved By: MCH
Drawing No. C2.1