

A. CONTRACTOR RESPONSIBLE FOR

NOTES:

- ① INSTALL AND SECURE THE CABLE TO THE METALLIC POLE AND RECONNECT ALL CONDUCTORS AS EXISTING.
- ② PRIMARY METERING ENCLOSURE PROVIDED BY NIPSCO. CONTRACTOR SHALL MAKE CONNECTION FROM THIS ENCLOSURE TO THE ABOVE GROUND FEDERAL CABLE JUNCTION.
- ③ PRIMARY FEDERAL CABLE JUNCTION BY CONTRACTOR TO BE INSTALLED TO THE PERMITS DATA AND TO THE PERMITS DATA.


NORTH
SCALE: 1" = 20'

**VEAZEY
PARROTT
&
DURKIN
SHOULDERS**

**RENOVATION PROJECT FOR:
DUNELAND SCHOOL CORP.
DUNELAND HIGH SCHOOL/MIDDLE SCHOOL
CHESTERBTON HIGH SCHOOL/MIDDLE SCHOOL**

ELECTRICAL SITE PLAN

ELECTRICAL SITE PLAN
SCALE: 1" = 20'-0"

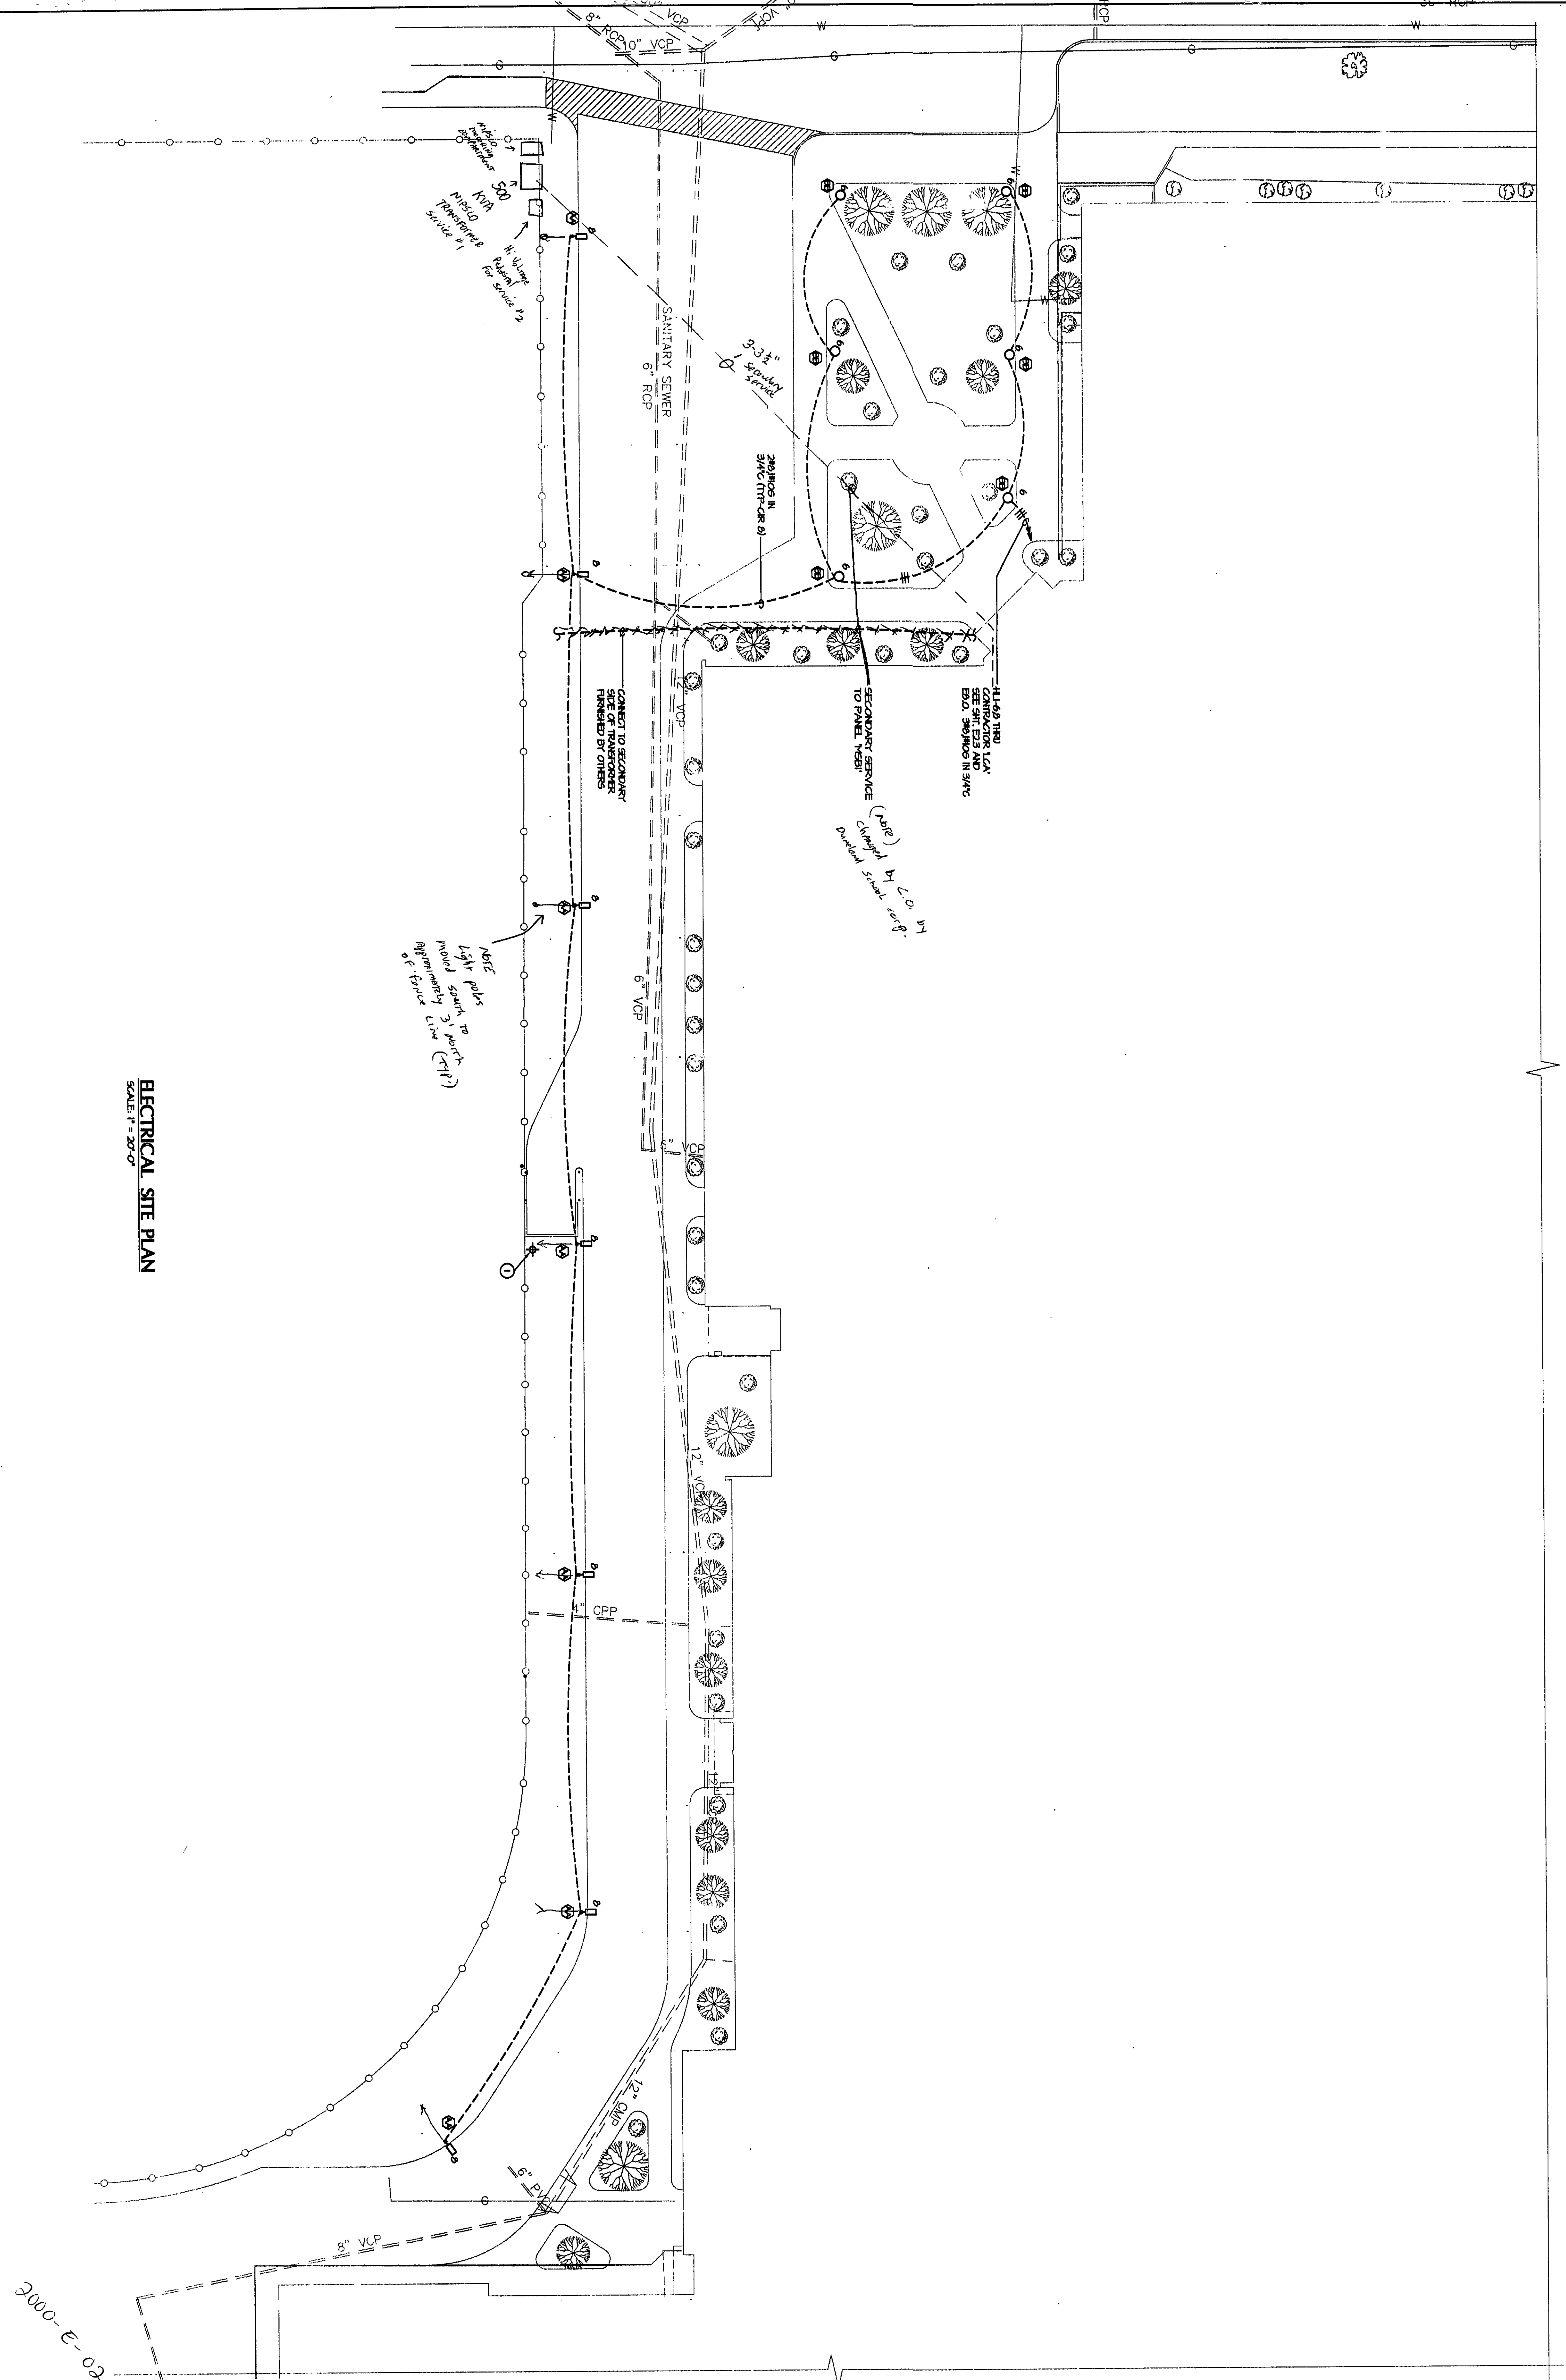

Project no.	9480.00
Project Date	JUNE 2000
Drawn By	BYAH
Approved by	TLM
Drawing No.	ES 1.1