



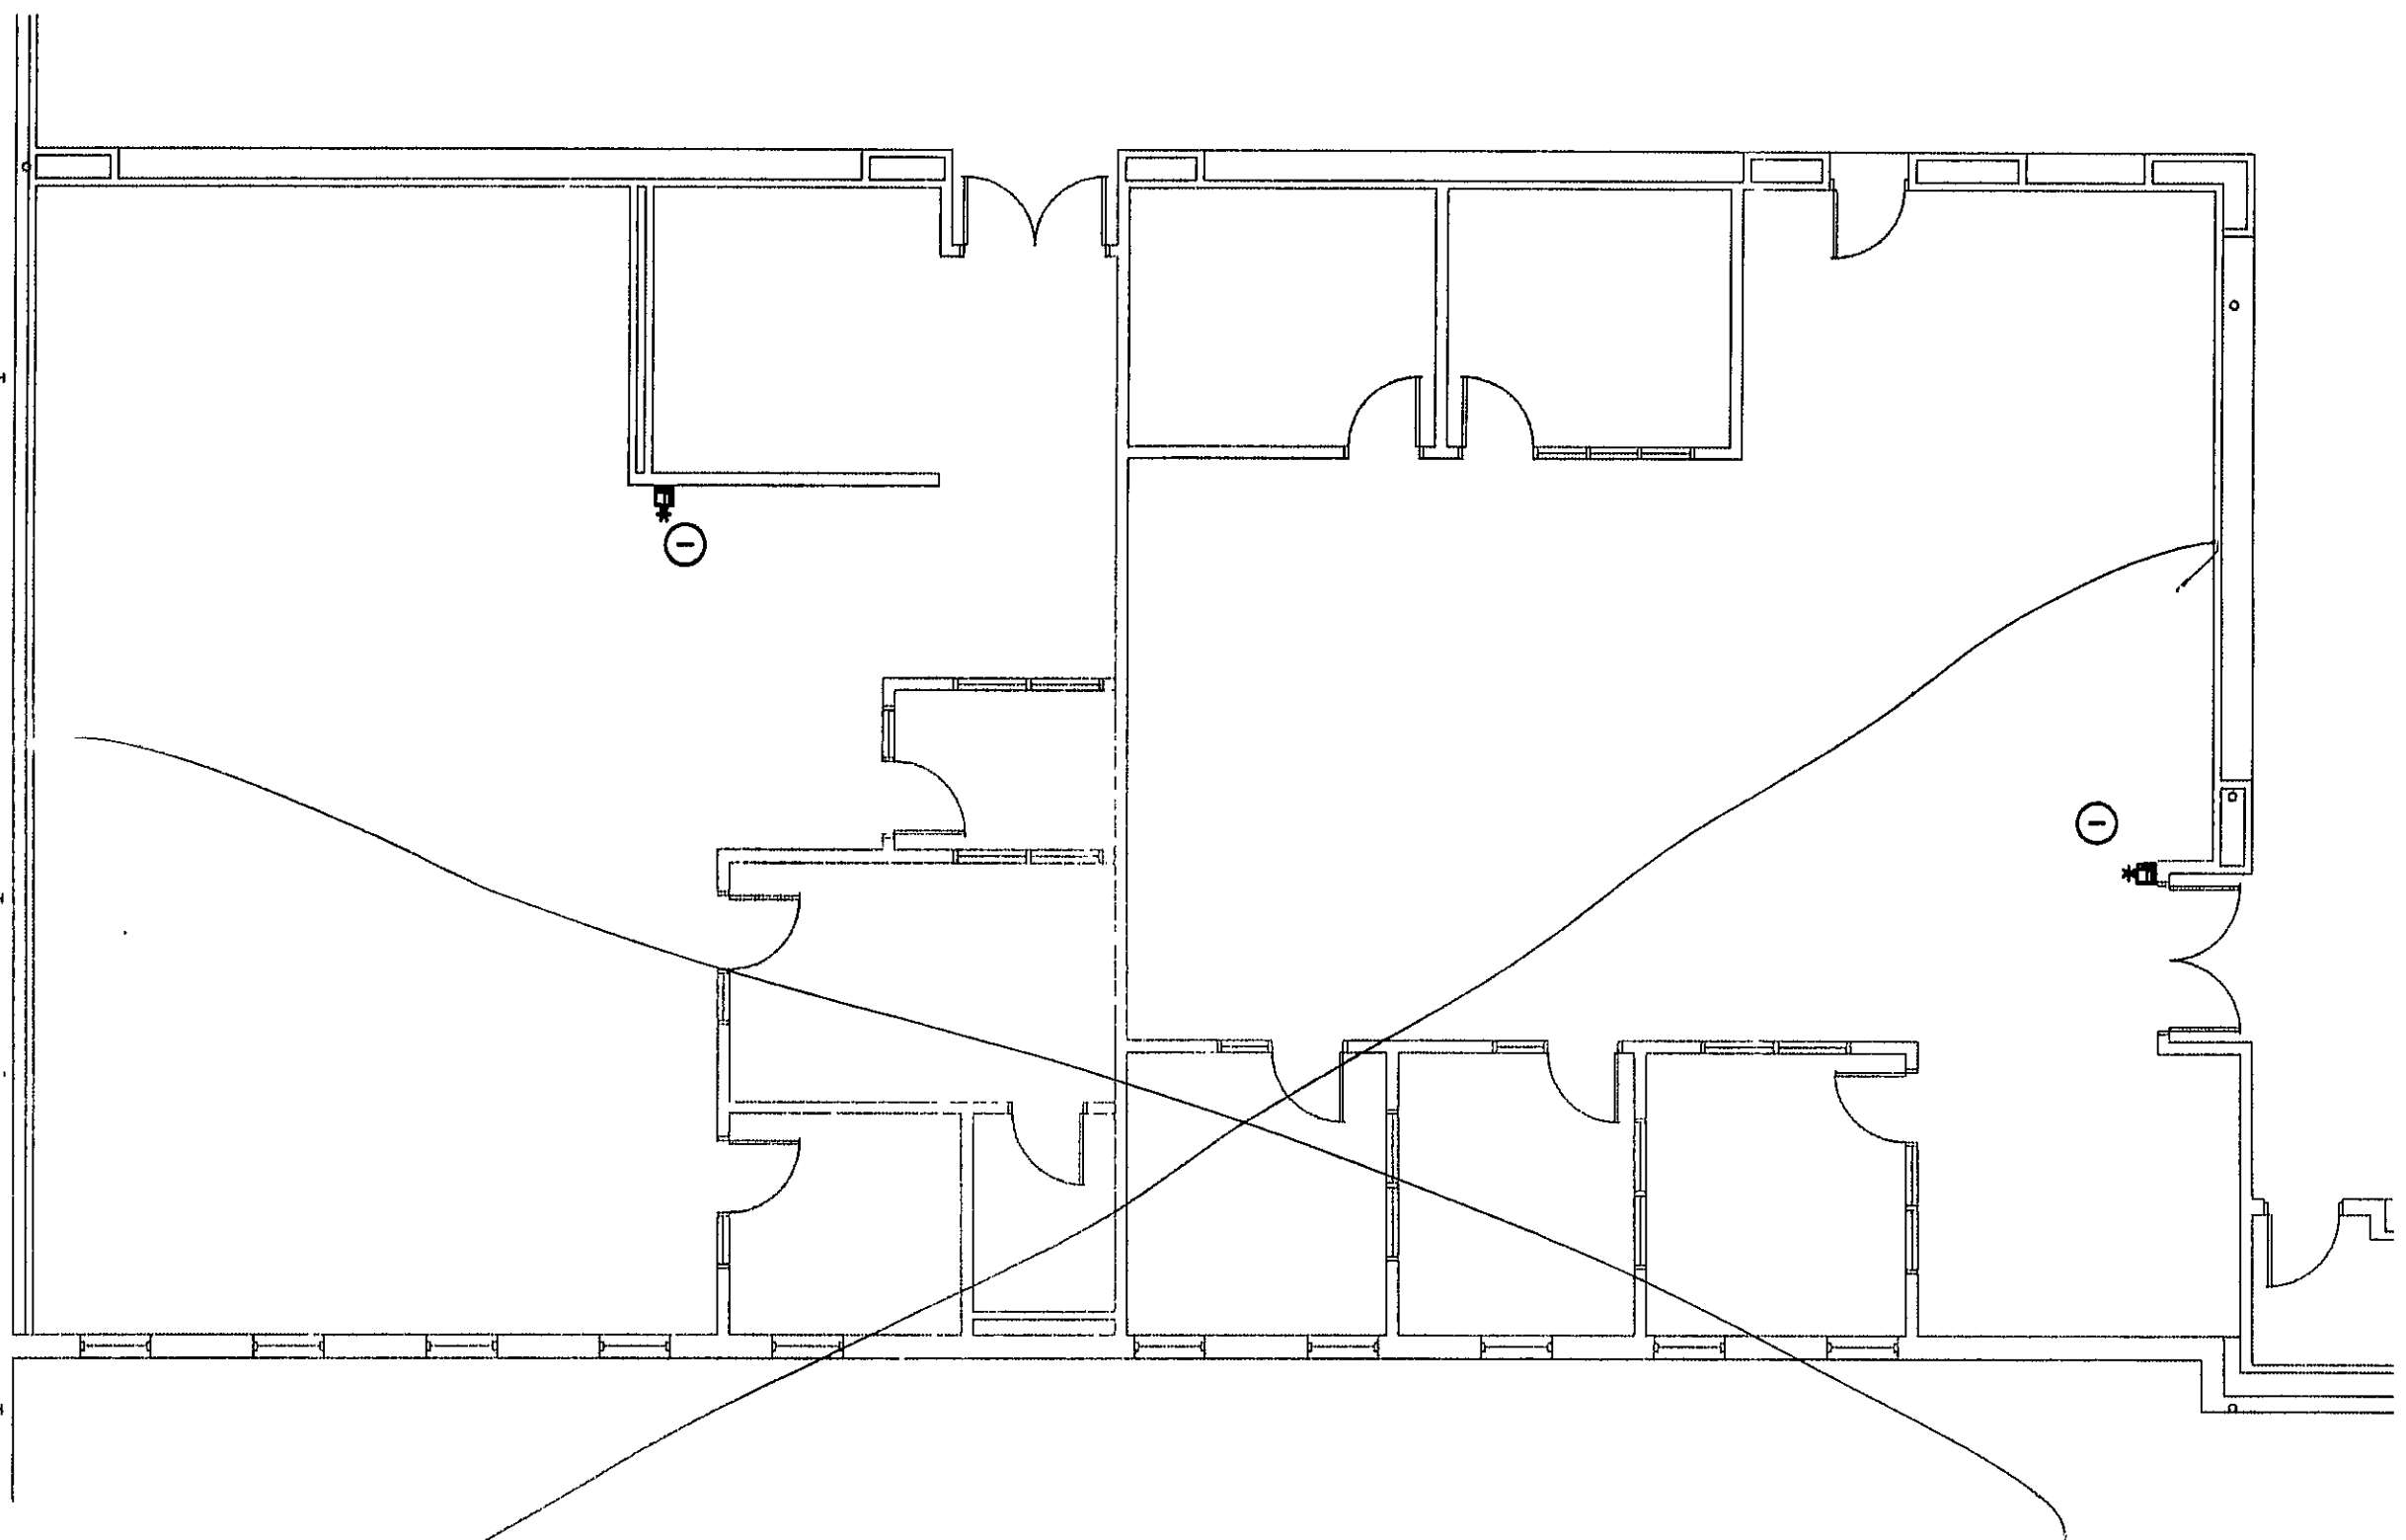


bhse
**ALTERNATE POWER PLAN
@ DEDUCTED 2ND FLOOR CLASSROOMS**
SCALE: 1/8" = 1'-0"
ALTERNATE

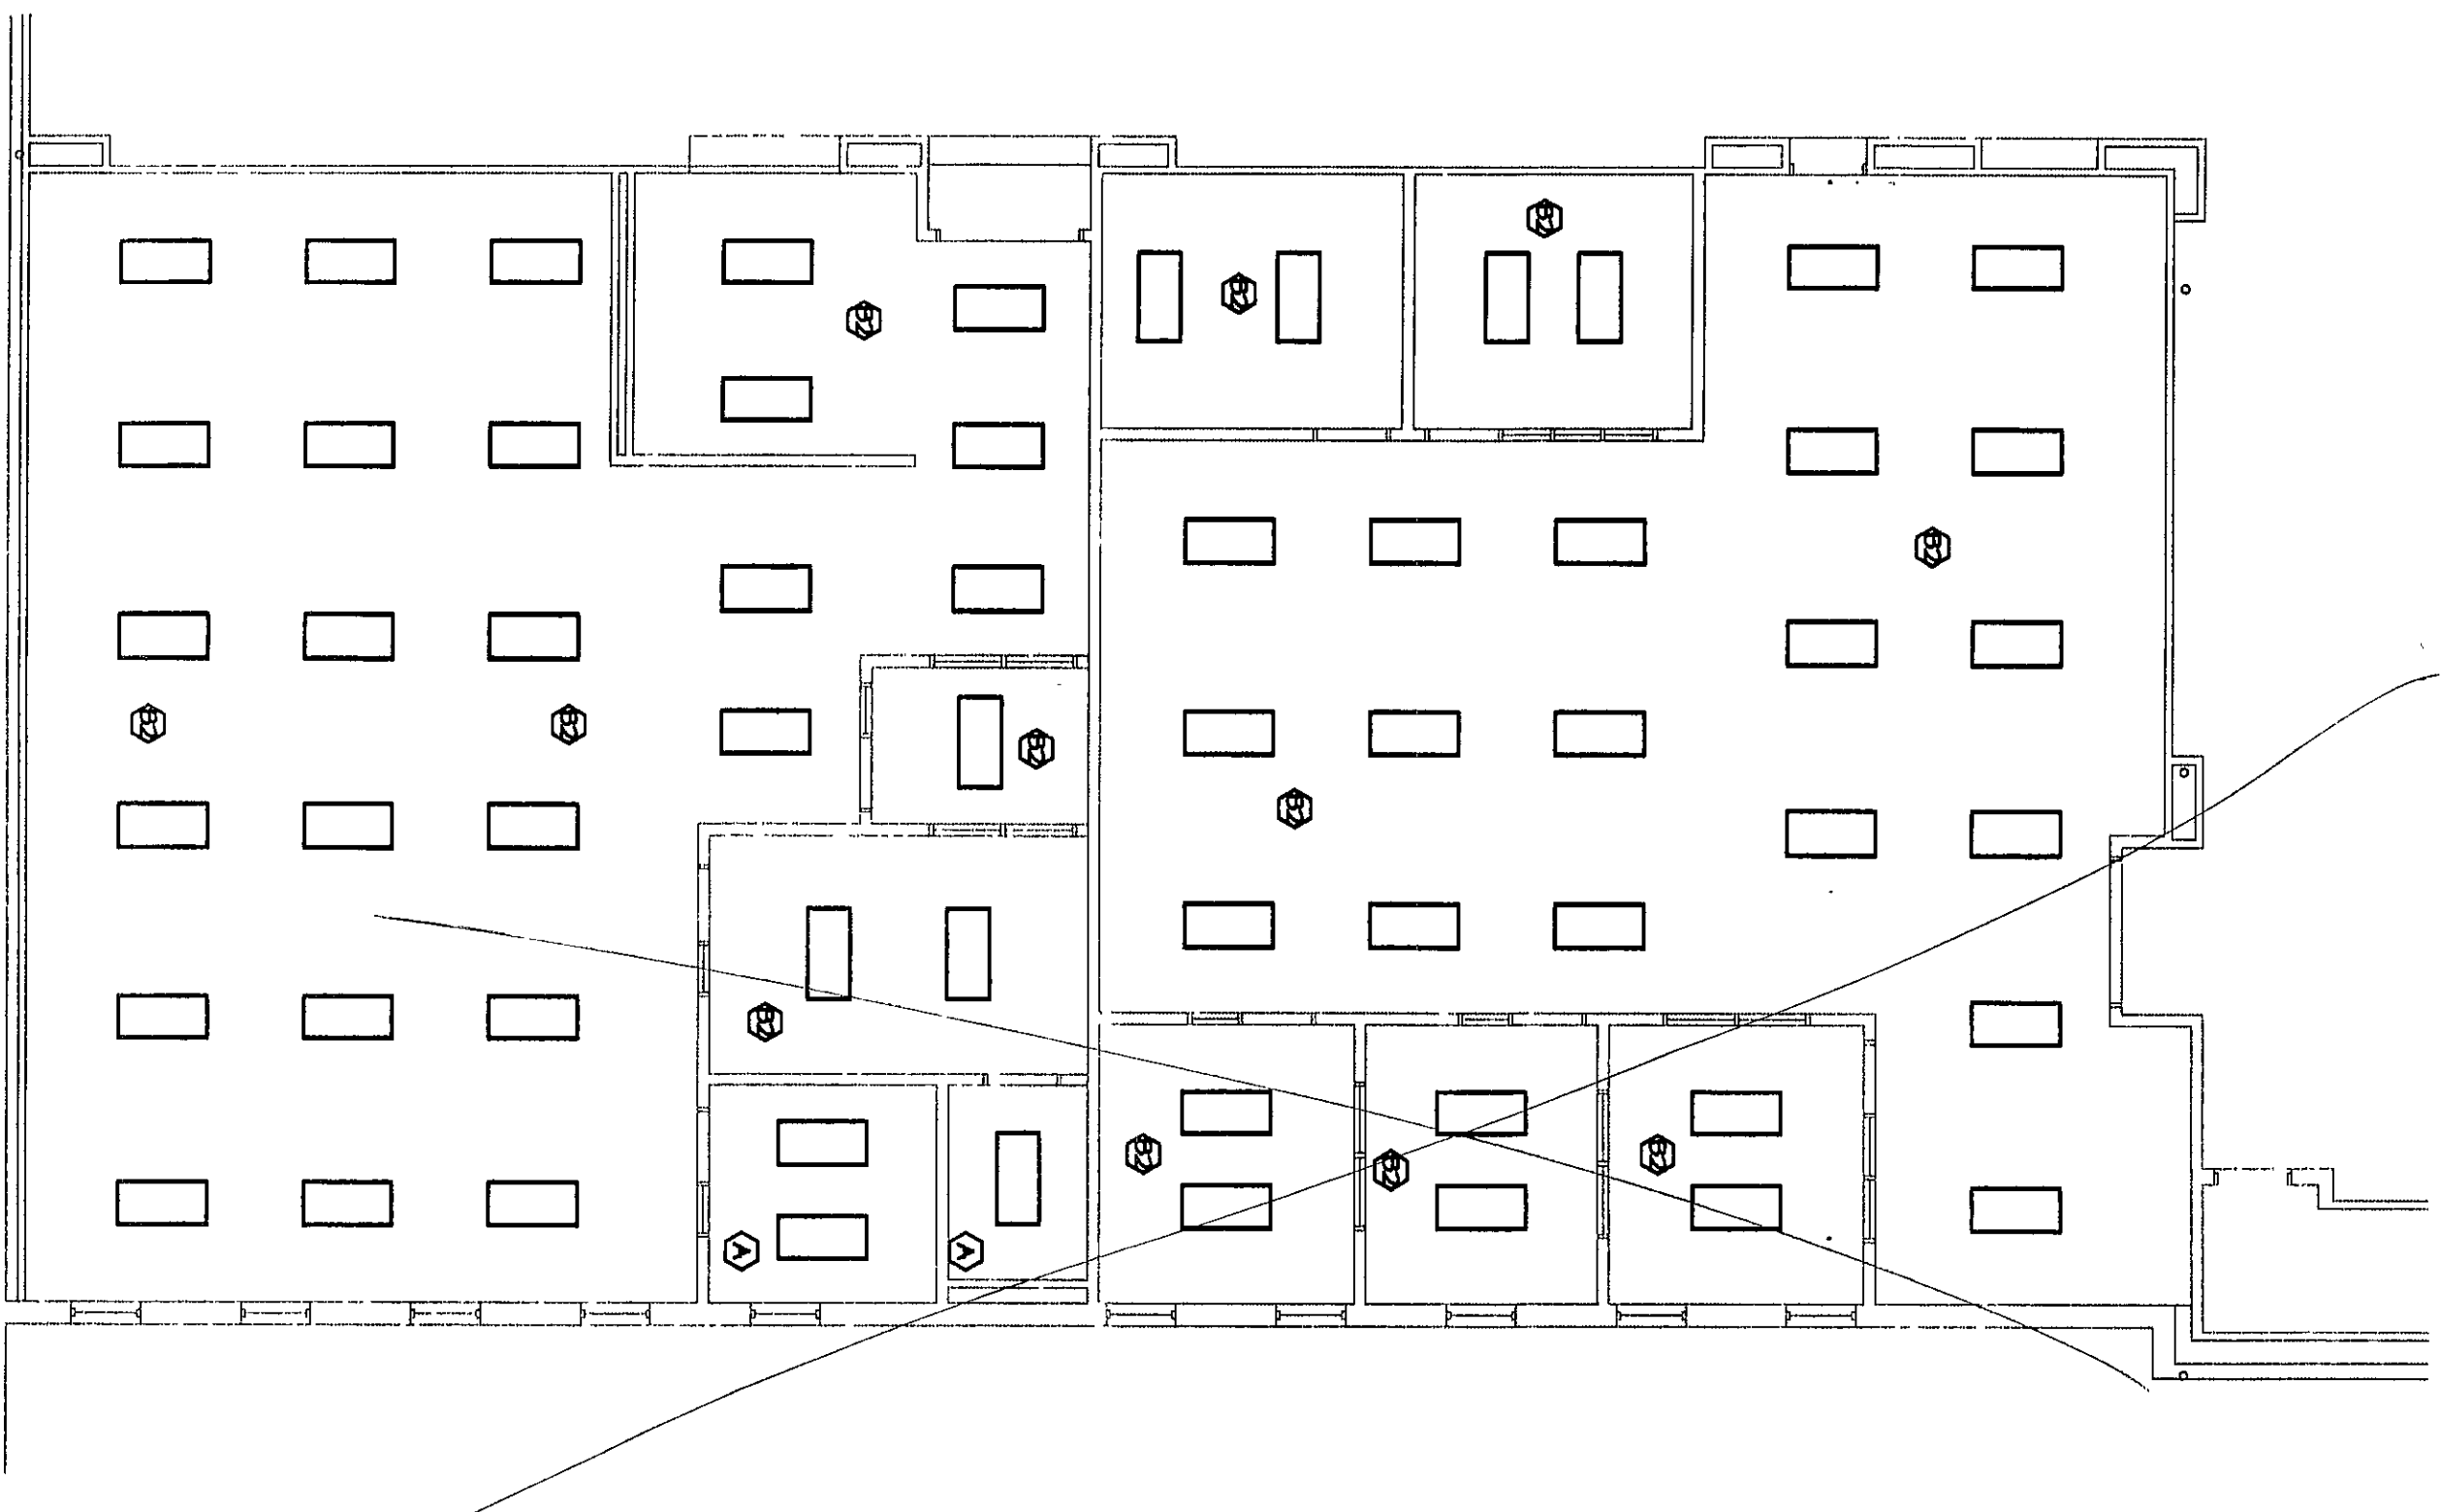


*This was done as
an alternate on sheets E-1, E-2, E-3*

bhse
**ALTERNATE LIGHTING PLAN
@ DEDUCTED 2ND FLOOR CLASSROOMS**
SCALE: 1/8" = 1'-0"
ALTERNATE

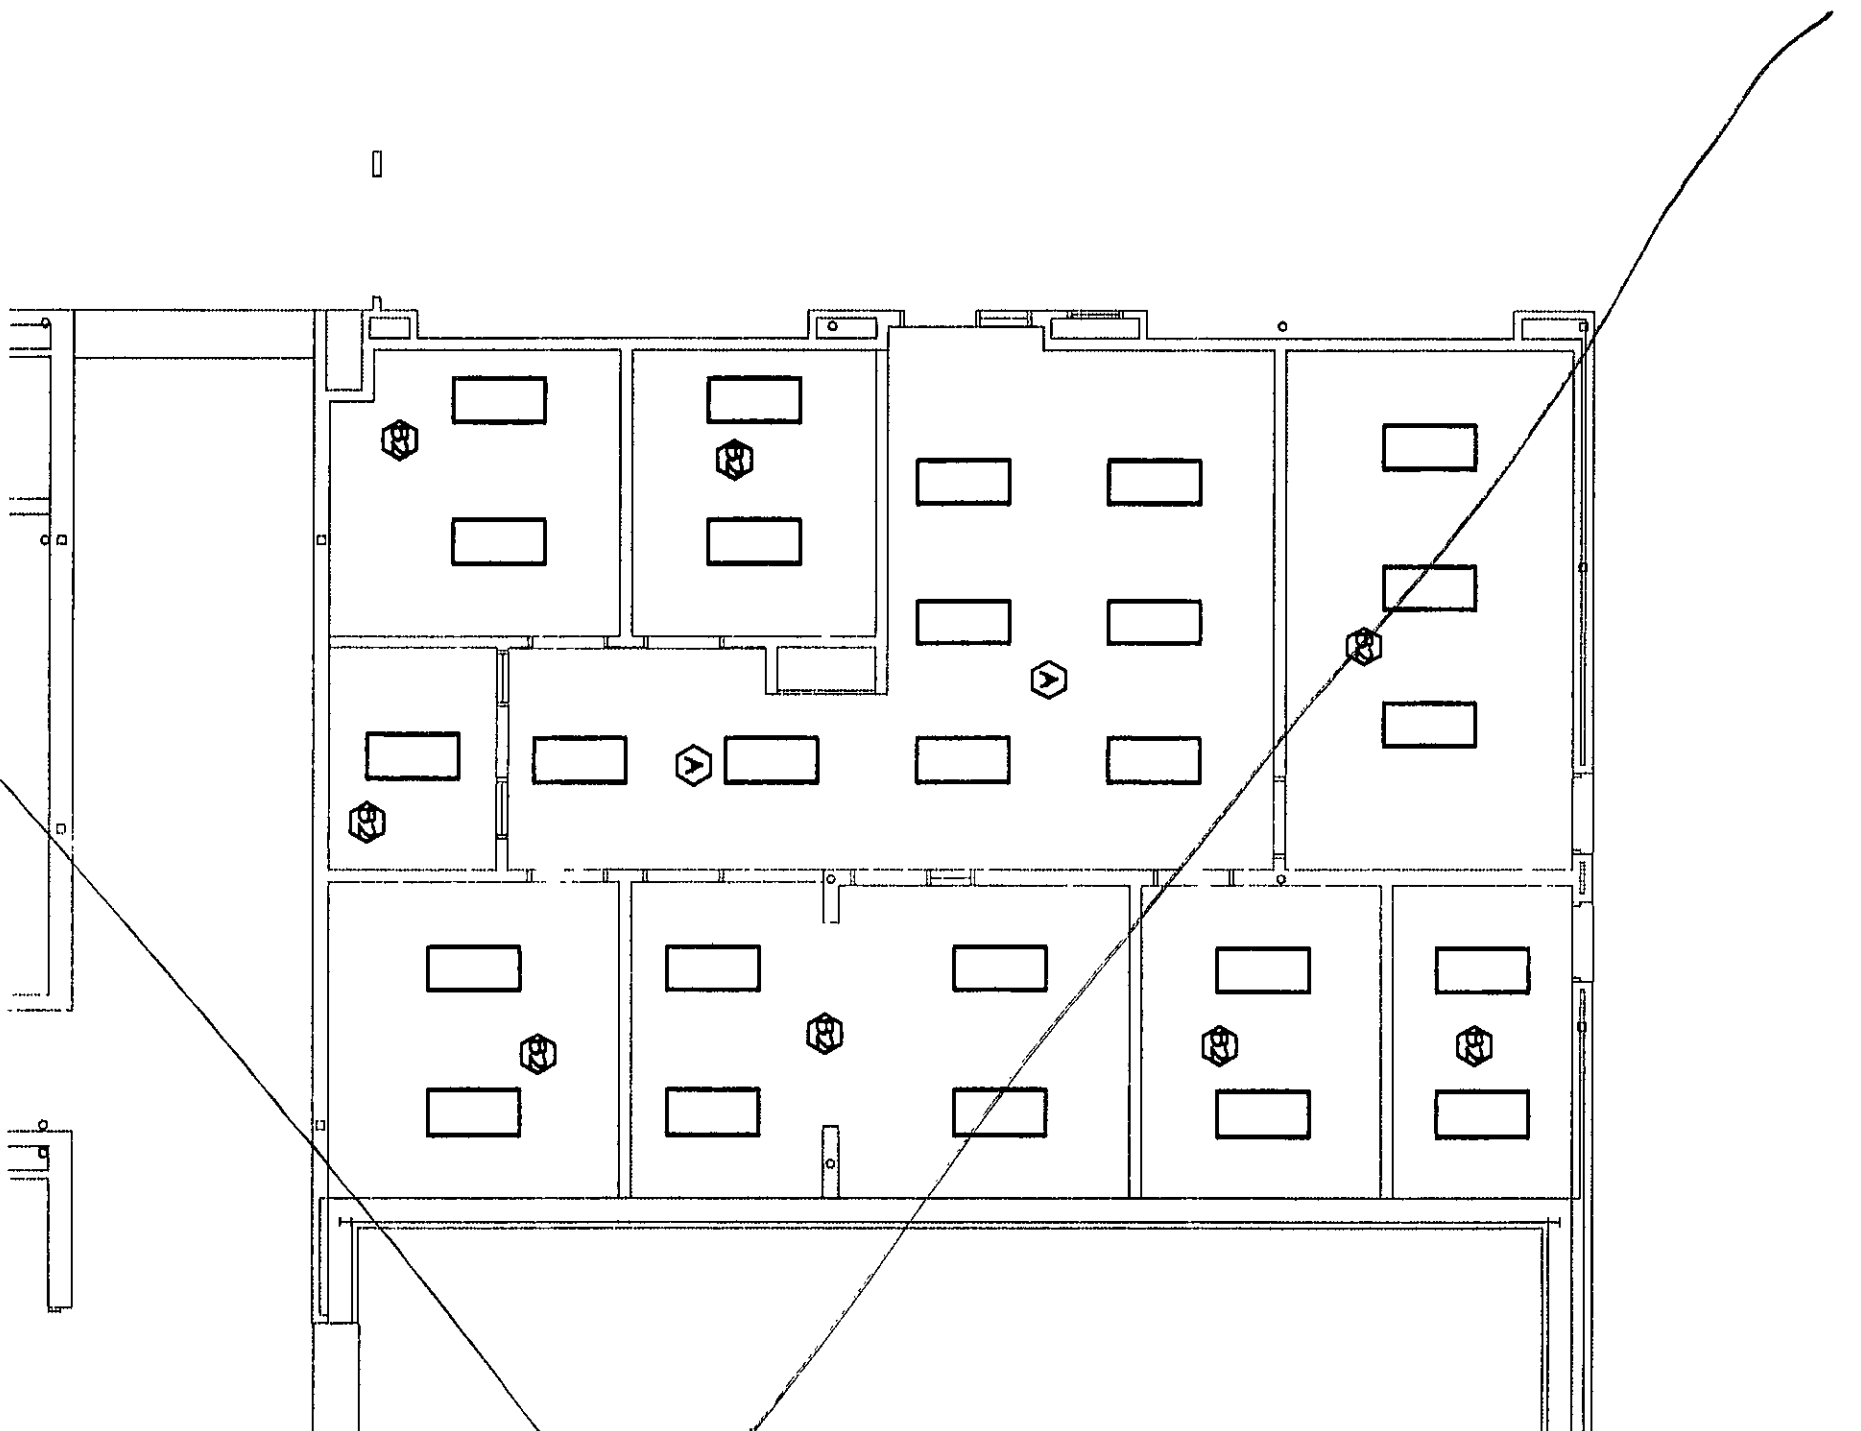


bhse
**ALTERNATE LIGHTING PLAN
@ DEDUCTED SMALL
GYMNASIUM LOCKER ROOMS**
SCALE: 1/8" = 1'-0"
ALTERNATE

*This was done as per
alternate on sheet E-1, E-2, E-3*

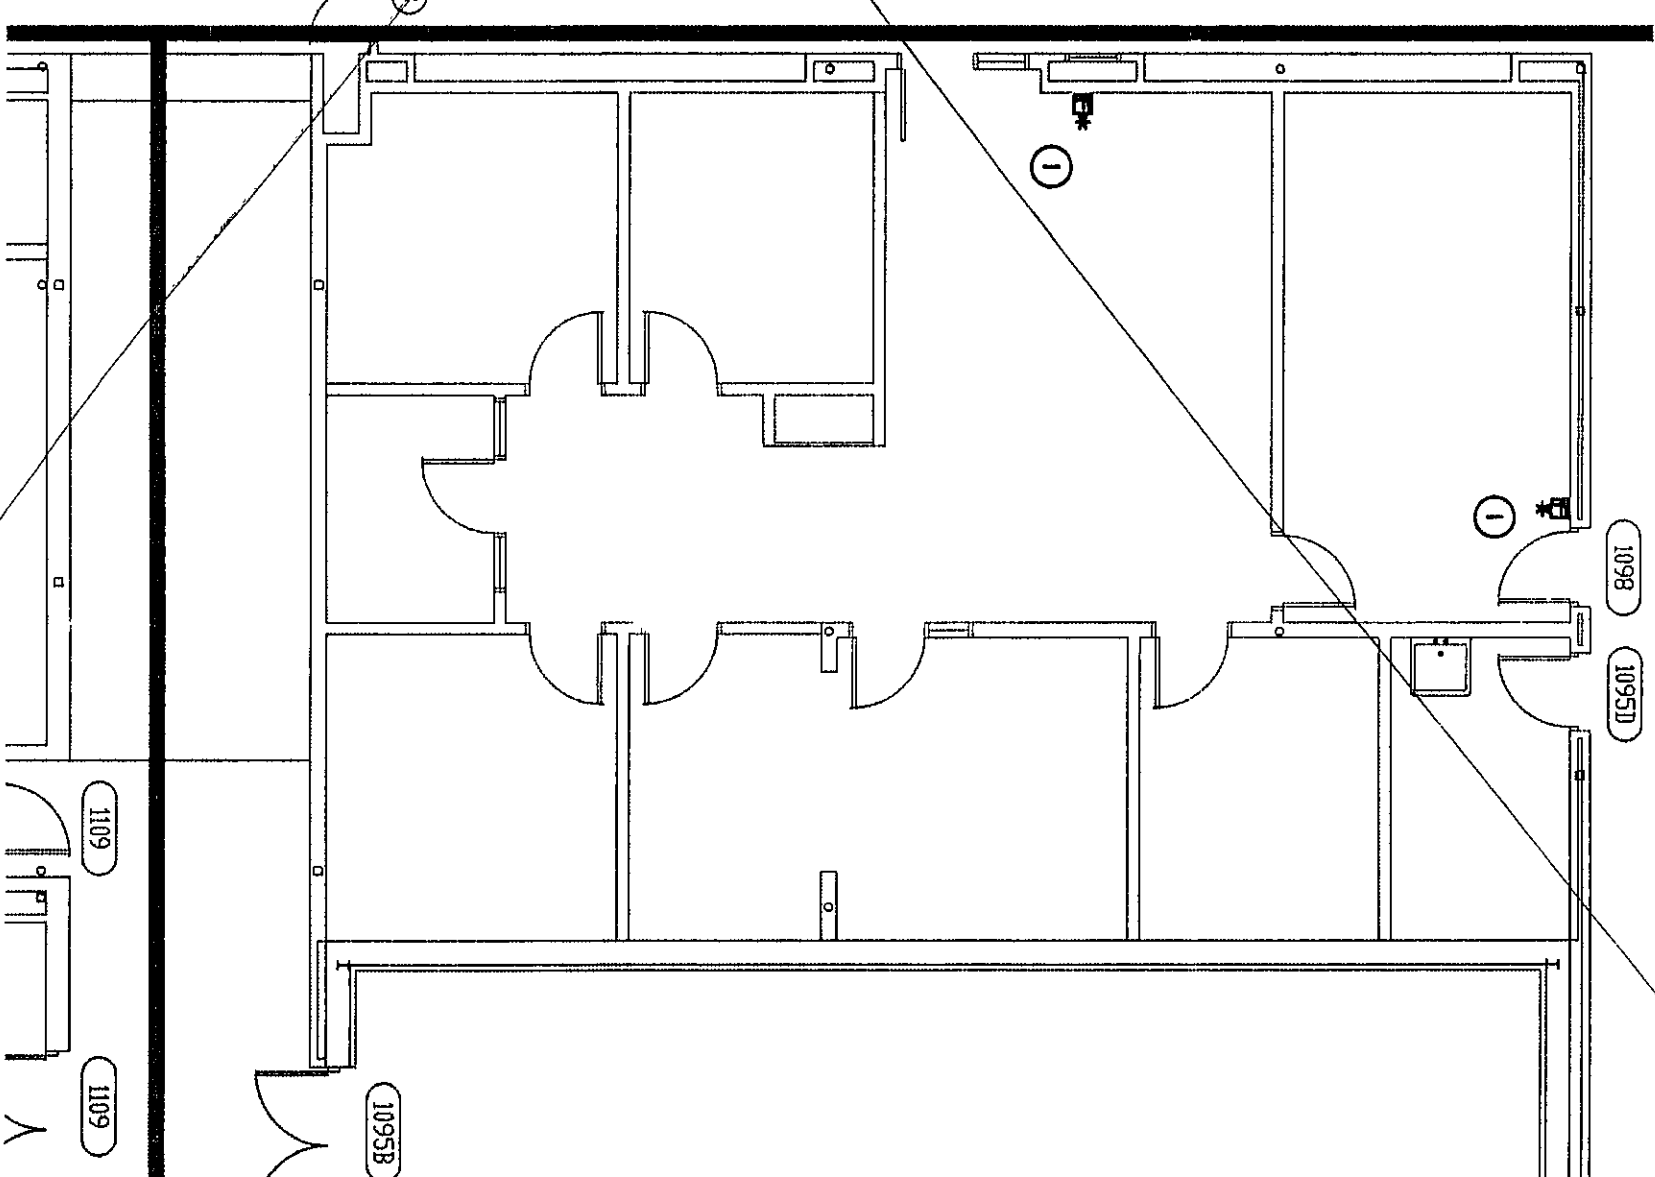


bhse
**ALTERNATE POWER
PLAN @ DEDUCTED SMALL
GYMNASIUM LOCKER ROOMS**
SCALE: 1/8" = 1'-0"
ALTERNATE

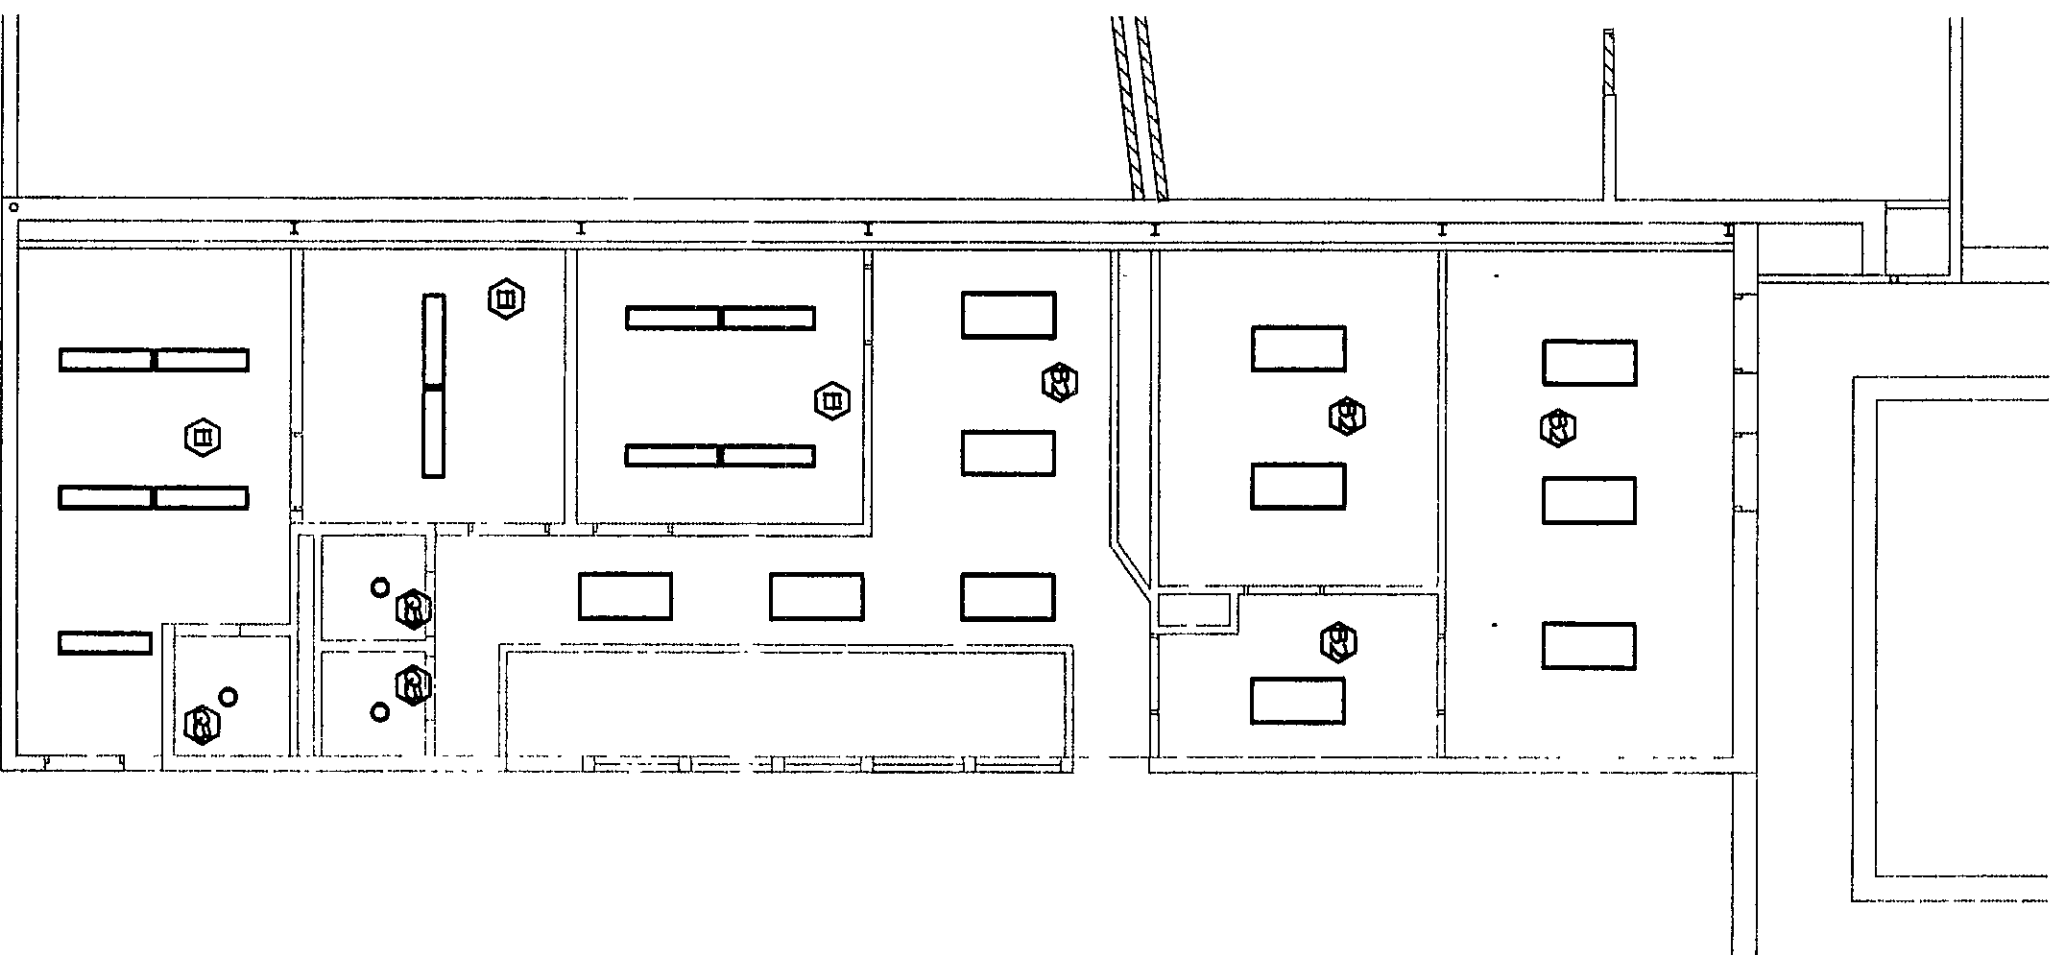

*This was done
as per this base
but prior*

bhse
**ALTERNATE LIGHTING PLAN
@ DEDUCTED MIDL LAB**
SCALE: 1/8" = 1'-0"
ALTERNATE

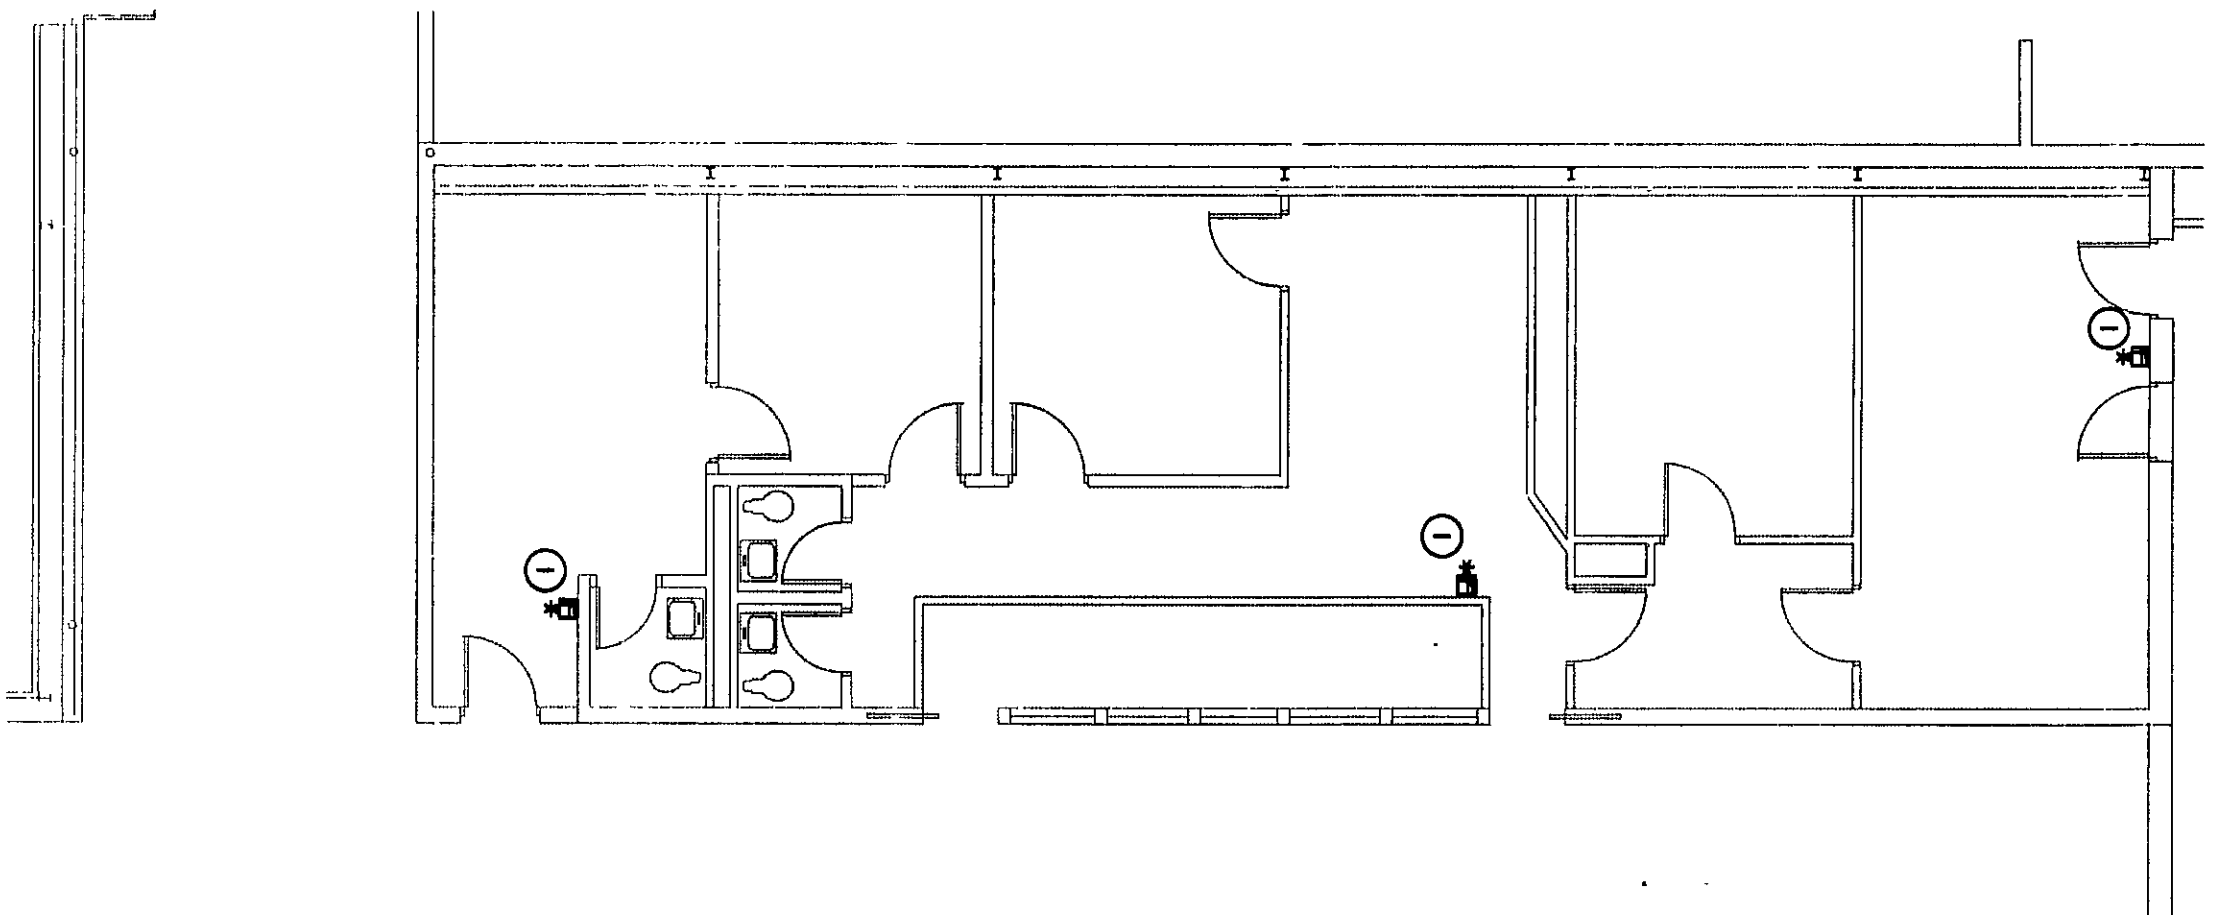

bhse
**ALTERNATE POWER PLAN
@ DEDUCTED MIDL LAB**
SCALE: 1/8" = 1'-0"
ALTERNATE

GENERAL NOTES:
A. RECONNECT ALL LIGHTING FIXTURES TO EXIST. CIRCUITS.
B. DEMOLITION OF LIGHTING FIXTURES ONLY UNDER
THE DEDUCT ALTERNATE.

ELECTRICAL NOTES:
① UTILIZE INTERLOK SERIES 400 NON-METALLIC
SURFACE RACEWAY TO EXIST FIRE ALARM
NOTIFICATION DEVICES IN NEW WALLS.
SHALL UTILIZE 1/2" O.D. IN WALL SIBBED OUT ABOVE CEILING.
NEW CONDUIT FROM EXIST. TWO STROKE ONLY. ALL
NEW CONDUIT SHALL BE 1/2" O.D. IN WALL SIBBED OUT
ALL STATIONS AND SMOKE DETECTORS CAN BE
CONNECTED TO EXIST DATA LOOP CIRCUIT.

**ARCHITECTS
ENGINEERS
PLANNERS**
**VEAZEY
PARROTT
DURKIN
&
SHOULDERS**
2000 E-15

**RENOVATION PROJECT FOR:
DUNE AND SCHOOL CORP.
CHESTER HIGH SCHOOL/MIDDLE SCHOOL
CHESTER, NEVADA**

ELECTRICAL ALTERNATE PLANS

Project No. 940000
Drawing Title: ELECTRICAL ALTERNATE PLANS
Drawn By: BAH
Approved By: TLM
Drawing No. E 0.12