


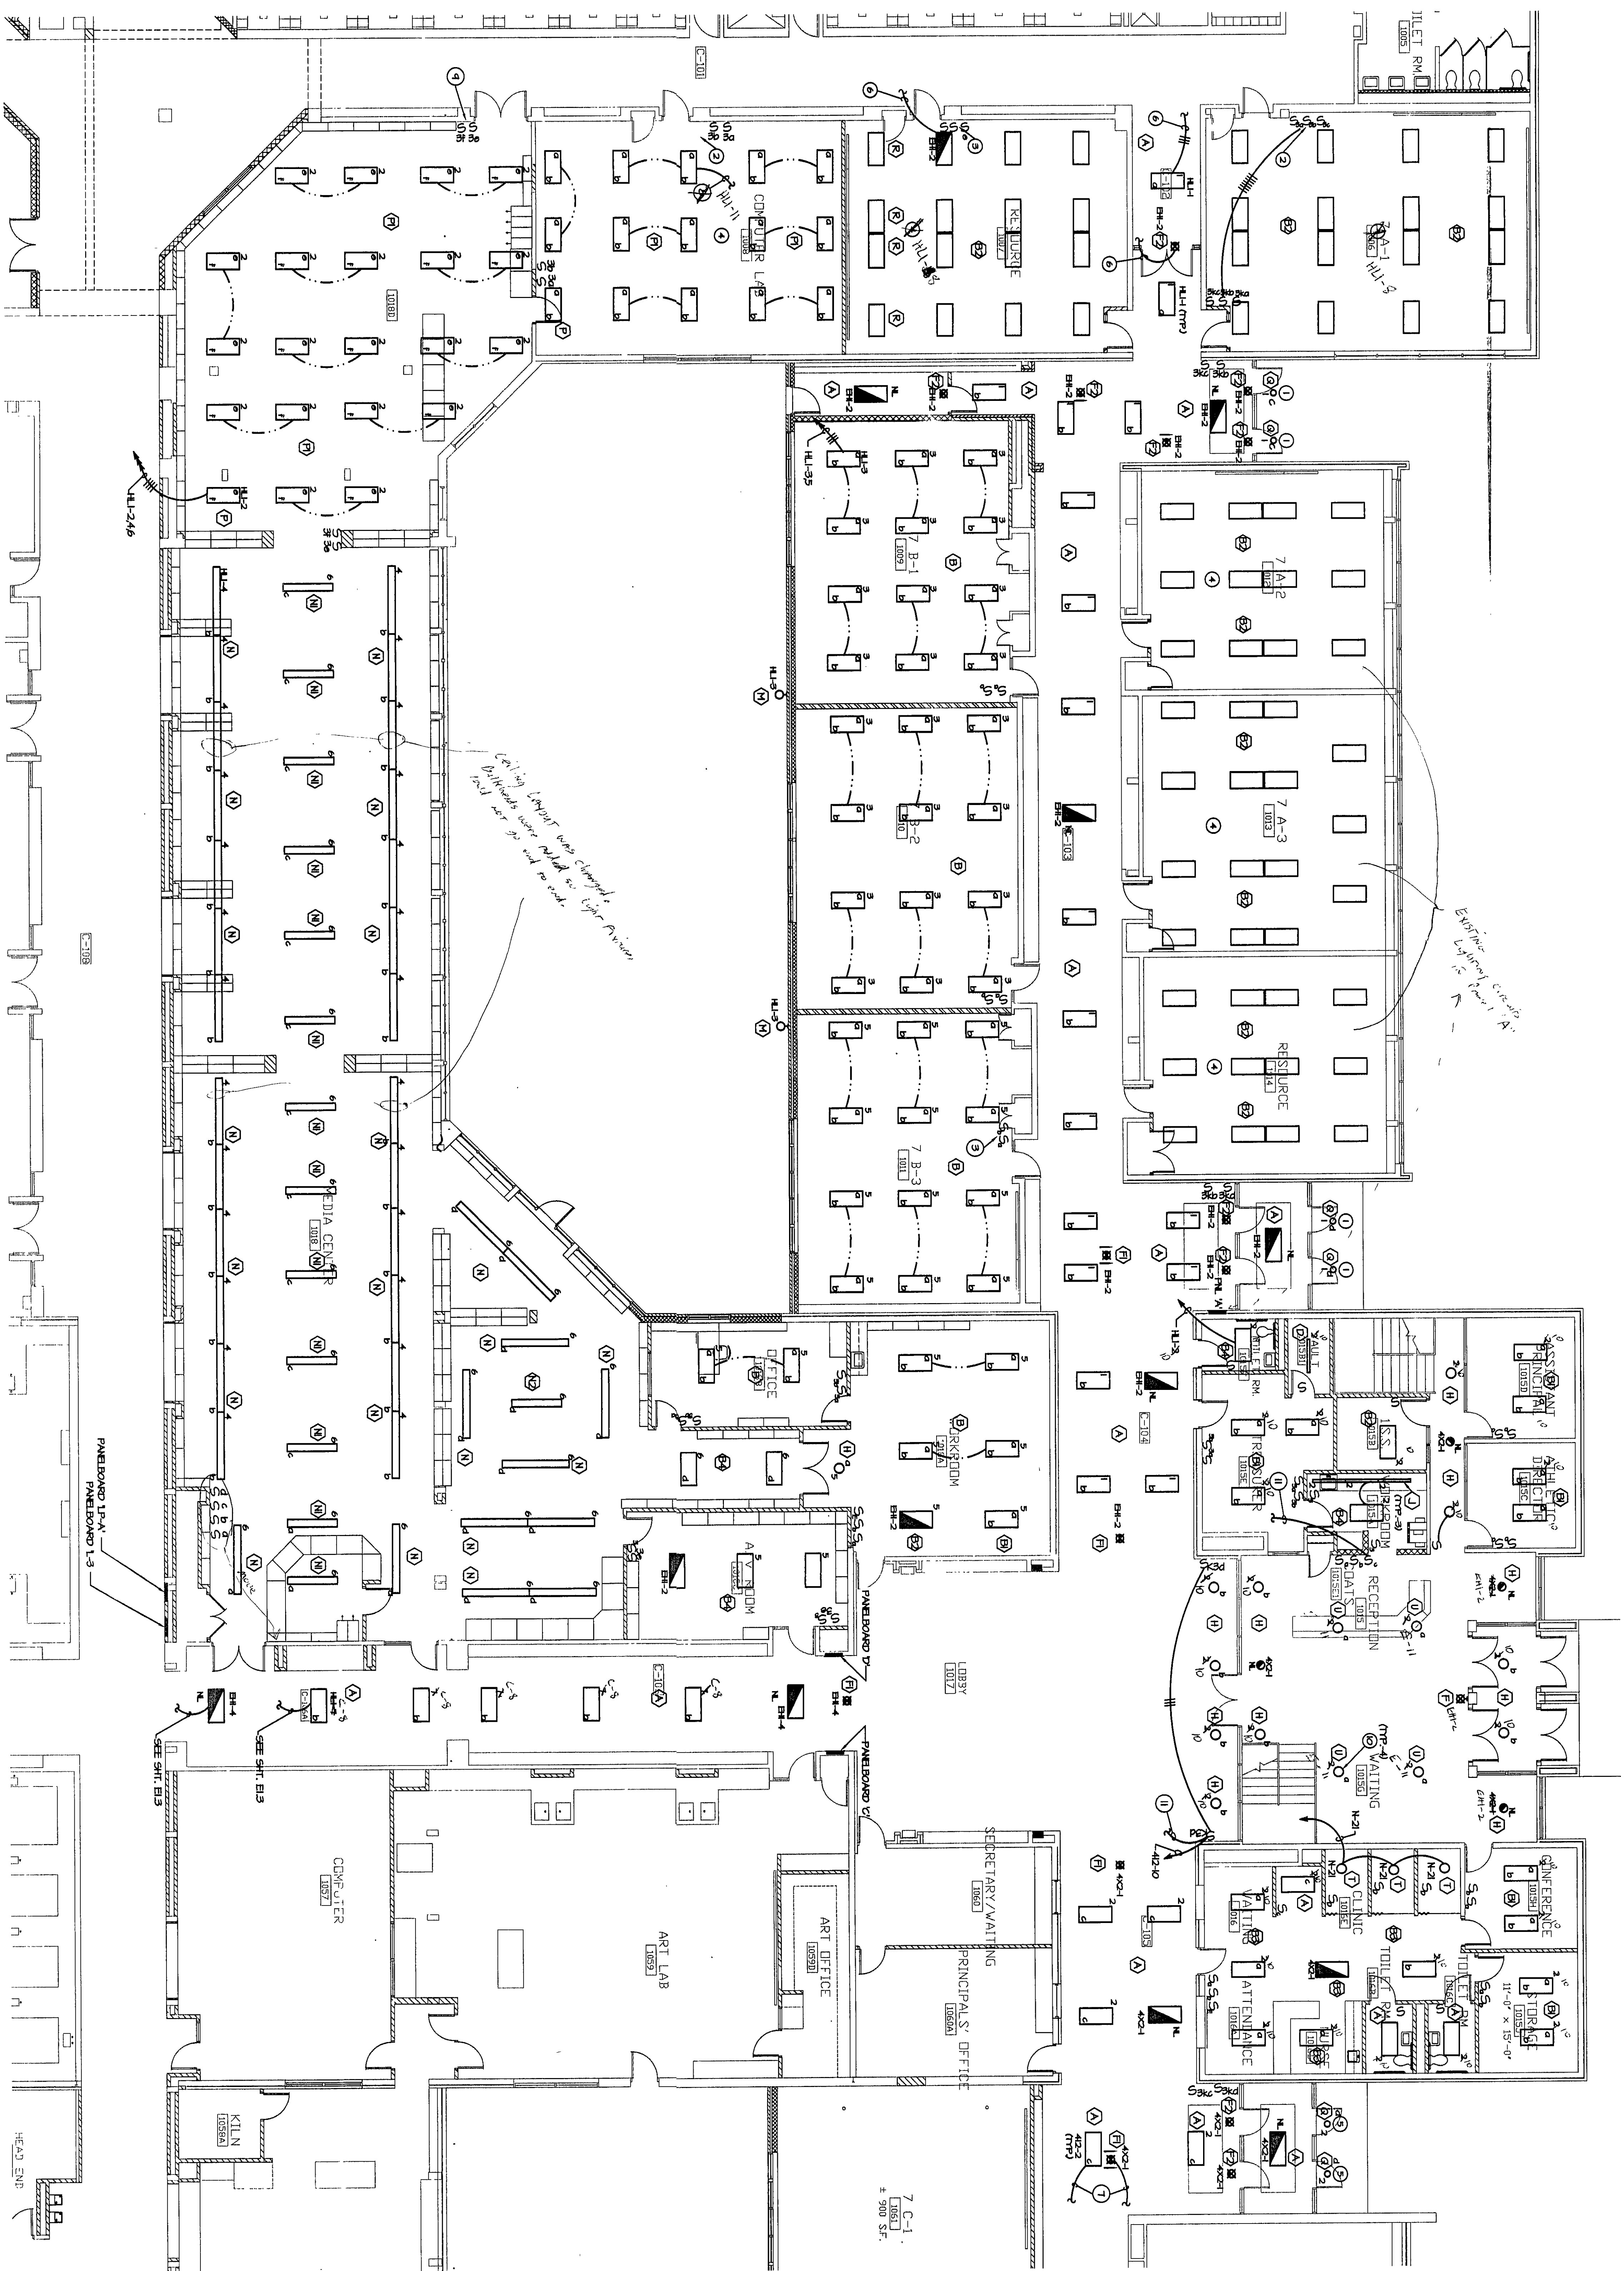



GENERAL ELECTRICAL NOTES

1. SEE SHEET E10, LIGHTING FIXTURE SCHEDULE, NOTE 1, FOR TYPE OF ELECTRICAL BALLAST REQUIRED.

NOTES

1. PROVIDE 2 HORIZONTAL SWITCHES IN EXISTING SINGLE GANG SWITCH BOX, UTILIZE EXISTING CIRCUIT.
2. REPLACE EXISTING SWITCHES WITH 3-WAY SWITCHES.
3. REPLACE EXISTING SWITCHES WITH NEW SWITCHES AND FACE PLATE. CEILING FAN SWITCH SHALL BE BLANDED OFF.
4. INSTALL LIGHTING FIXTURES IN EXISTING CEILING GRID, RECONNECT TO EXISTING LIGHTING CIRCUIT AND LIGHTING SWITCHES UNLESS NOTED OTHERWISE.
5. INSTALL LIGHTING FIXTURES OVER EXISTING OUTLET BOX.
6. SEE SHEET E11 FOR CONTINUATION.
7. SEE SHEET E14 FOR CONTINUATION.
8. REMOVE ROOM AS INDICATED INCLUDING EXIST. CIRCUIT.
9. REPLACE SINGLE GANG BOX WITH 2-GANG BOX.
10. LIGHT FIXTURE POINTED TO BOTTOM OF LIGHT TRUSS, SEE ARCHITECTURAL PLANS FOR DETAILS ON SHIT, A-11.
11. TO LIGHTING FIXTURE TYPE II, SEE SHIT, B-10, SCENE CONCEPT UP THROUGH MECHANICAL ROOM ABOVE, CIRCUIT N-1-2.

WIRING STRING FOR VOLTAGE DROP (DON, 120V, CIRCUITS)	
NO. 14	NO. 14
NO. 12	NO. 12
NO. 10	NO. 10
NO. 8	NO. 8

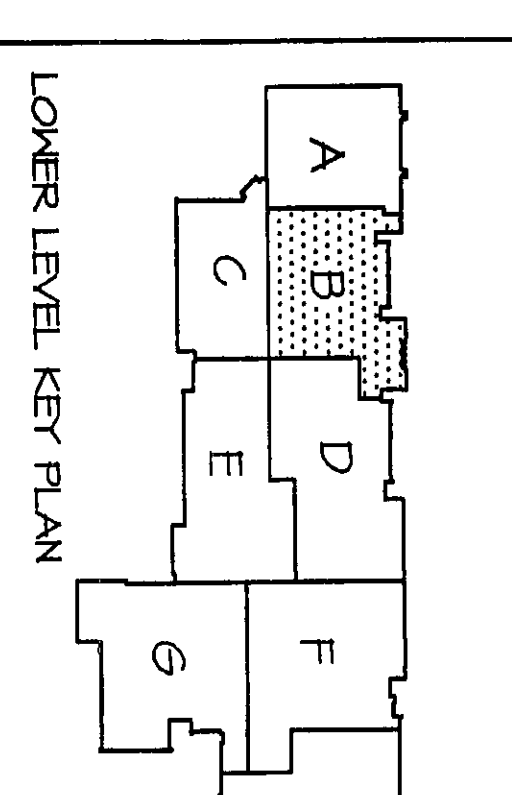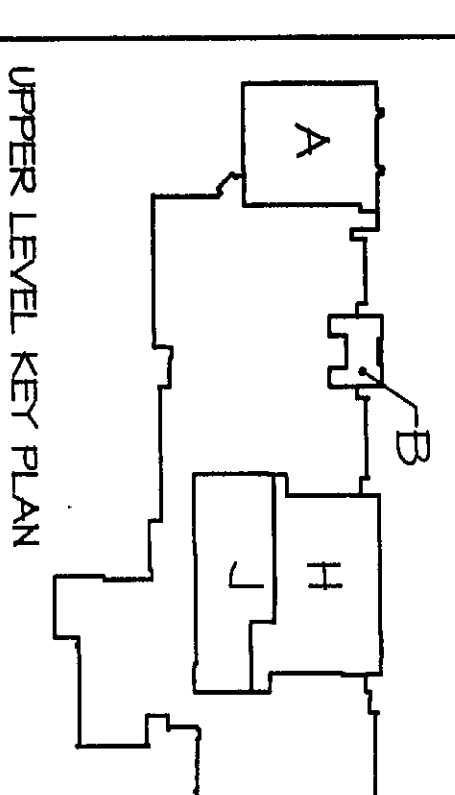

NORTH
SCALE: 1/8" = 1'-0"

**VEAZEY
PARROTT
DURKIN &
SHOULDER**

ARCHITECTS
ENGINEERS
PLANNERS

ONE SOUTH STREET
CHICAGO, ILL. 60604

**RENOVATION PROJECT FOR:
DUNELAND SCHOOL CORP.
CHESTER HIGH SCHOOL/MIDDLE SCHOOL
CHESTER, INDIANA**

**Drawing Title:
LIGHTING PLAN - UNIT 7**

Project No. 1190000
Drawn By: EKH
Approved By: TLM
Drawing No. E 12