


A. SEE SHEET EQ.O "LIGHTING FIXTURE SCHEDULE", NOTE 1 FOR TYPE OF ELECTRONIC BALLAST REQUIRED.

- | WIRING SIZING FOR
VOLTAGE DROP
(20A, 120V, CIRCUITS) | |
|--|---------|
| 240' | #10 AWG |
| 175' | #8 AWG |
| 125' | #6 AWG |

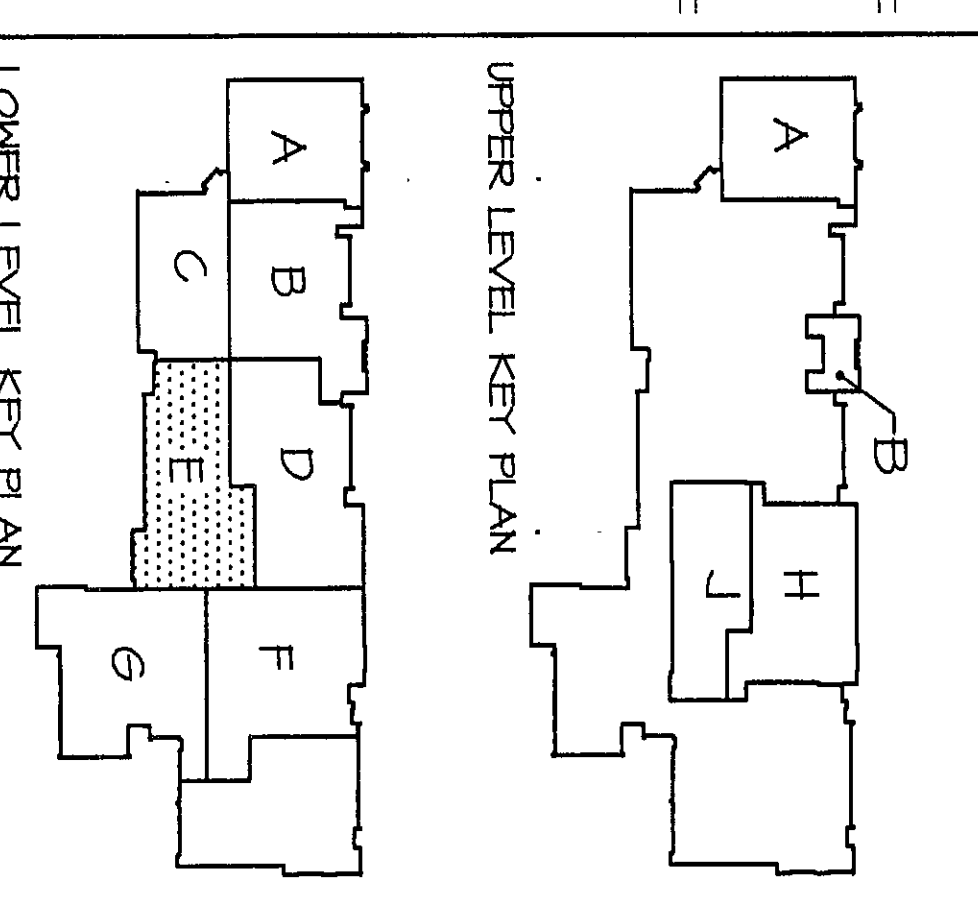

NORTH
SCALE: 1/8" = 1'-0"

**VEAZEY
PARROTT
DURKIN &
SHOULDERS**

ARCHITECTS
ENGINEERS
PLANNERS

1035 Main Street
Boston, MA 02111
Telephone: 617/762-1000

RENOVATION PROJECT FOR:
DUNELAND SCHOOL CORP.
CHESTERTON HIGH SCHOOL/MIDDLE SCHOOL
CHESTERTON, INDIANA

Drawing Title: **LIGHTING PLAN - 1ST F.**

2000-E-20

