


GENERAL ELECTRICAL NOTES

A. SEE SHEET E10 LIGHTING FIXTURE SCHEDULE, NOTE 1, FOR TYPE OF ELECTRONIC BALLAST REQUIRED.


NOTES

1. LIGHTING FIXTURES IN THIS AREA SHALL BE PROVIDED WITH THE FOLLOWING: (A) 1" X 4" RECESSED ELECTRONIC BALLAST AND ONE (1) PATTERNS 12, 0.25" THICK ACRYLIC LENS FOR A 1" X 4" LIGHTING FIXTURE. FIELD FROM EXISTING LIGHTING FIXTURES (RESISTANCE FROM 10' AWAY).
2. LIGHTING SWITCHES INDICATED SHALL BE NEW DEVICES AND COVER PLATES INSTALLED IN EXISTING OUTLET BOXES.
3. REINSTALL LIGHTING FIXTURES IN EXISTING CEILING GRID. RECONNECT TO EXISTING LIGHTING CIRCUIT AND LIGHTING SERVICES.
4. EXISTING STROBE LIGHTING FIXTURE IN REPTILE CASE SHALL BE RECONNECTED WITH ONE (1) 320W T-8 LAMP & ONE (1) ELECTRONIC BALLAST.
5. CONNECT TO EXISTING LIGHTING CIRCUIT IN CORRIDOR. SEE SHEET E1A.
6. CONNECT TO EXISTING IDOY LIGHTING CIRCUIT.
7. CONNECT TO EXISTING 277V LIGHTING CIRCUIT.
8. SEE SHEET E1T FOR CONTINUATION.
9. EXIST. 2 STRIP LIGHT IN DISPLAY CASE SHALL BE PROVIDED WITH ONE (1) T-8, 17W LAMP & 1 ELECTRONIC BALLAST. TYPICAL FOR'S AT THIS LOCATION.
10. SEE SHEET E1A FOR CONTINUATION.
11. UTILIZE EXIST. CONDUIT AND OUTLET BOX FOR NEW CANOPY LIGHTING FIXTURE.

| WIRING SIZING FOR VOLTAGE DROP (20A, 100' CIRCUMFERENCE) |        |  |
|----------------------------------------------------------|--------|--|
| 20'                                                      | NO AWG |  |
| 37'                                                      | 40 AWG |  |
| 225'                                                     | 40 AWG |  |

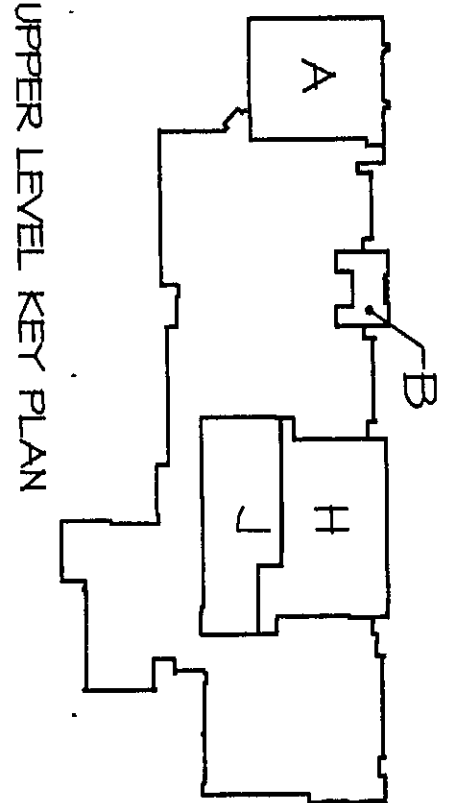

UPPER LEVEL KEY PLAN

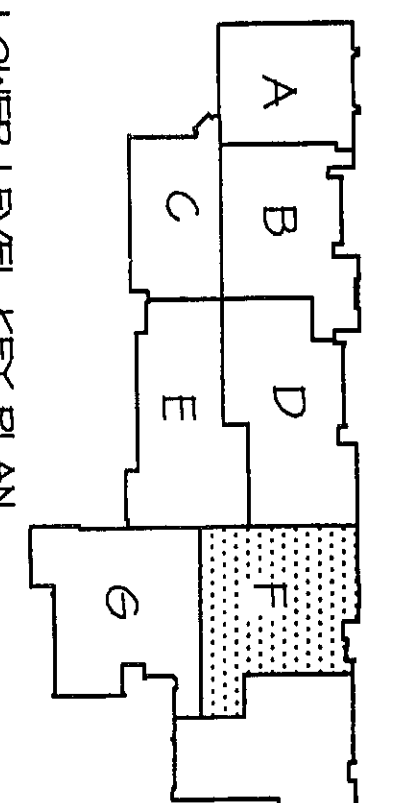

LOWER LEVEL KEY PLAN

NORTH  
SCALE: 1/8" = 1'-0"

ARCHITECTS  
ENGINEERS  
PLANNERS

VEAZEY  
PARKOT  
DURKIN &  
SHOULDERS

RENOVATION PROJECT FOR:  
DUNE LAND SCHOOL CORP.  
CHESTER HIGH SCHOOL/MADE SCHOOL  
CHESTER, INDIANA

Professional Engineer  
No. 19257  
STATE OF INDIANA  
19257  
19257  
19257

Drawn By: EKH  
Approved By: TLM  
Drawing No.: E 1.6