
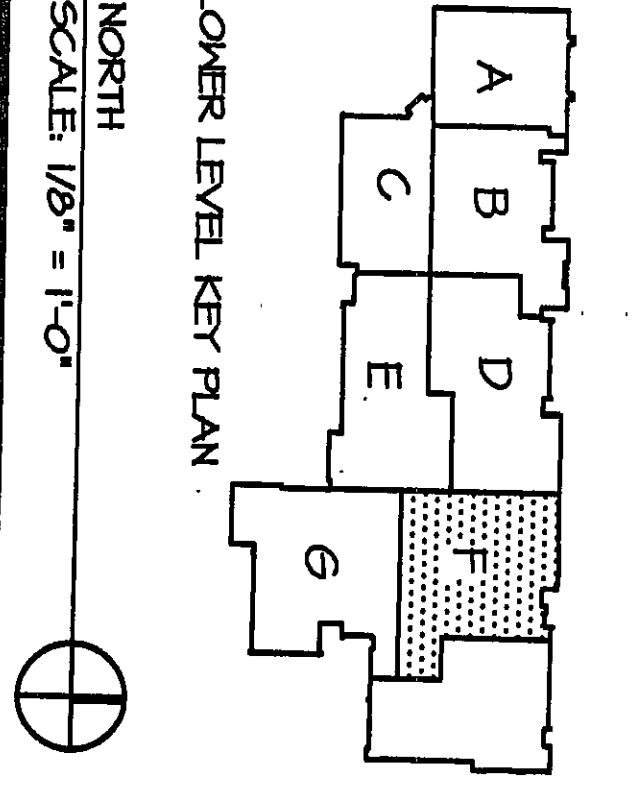


GENERAL ELECTRICAL NOTE
FOR THE ELECTRICAL CONTRACTOR AND LIAISON REQUIRED
IN ORDER TO COMPLY WITH THE REQUIREMENTS OF THE
ELEVATIONS ON SHEET E-2.6, COORDINATE WITH THE
AL. SERVICE RACKING RACKING WITH DIV. 11.

- NOTES**
1. UTILIZE AIR-ROD SERIES 400 NON-METALLIC
EXHIBIT RACKING AND SERVICE BOX TO LOWER
TO TOP OF BOX PROVIDE ALL MOUNTING HARD-
WARE REQUIRED, EXHIBIT EXIST. CIRCUIT.
 2. UTILIZE AIR-ROD SERIES 400 NON-METALLIC
SERVICE RACKING AND SERVICE BOX TO LOWER
TO TOP OF BOX PROVIDE ALL MOUNTING HARD-
WARE REQUIRED, EXHIBIT TO EXIST. CIRCUIT.
 3. UTILIZE AIR-ROD SERIES 400 NON-METALLIC
SERVICE RACKING AND SERVICE BOX TO LOWER
TO TOP OF BOX PROVIDE ALL MOUNTING HARD-
WARE REQUIRED, EXHIBIT TO EXIST. CIRCUIT.
 4. RELOCATE EXIST. FIRE ALARM SMOKE DETECTOR
IN NEW CEILING, RECONNECT TO EXIST. CIRCUIT.
 5. UTILIZE AIR-ROD SERIES 400 NON-METALLIC
SERVICE RACKING AND SERVICE BOX TO LOWER
TO TOP OF BOX PROVIDE ALL MOUNTING HARD-
WARE REQUIRED, EXHIBIT TO EXIST. CIRCUIT.
 6. RECONNECT NEW MECHANICAL EQUIPMENT TO EXISTING
CIRCUIT.
 7. UTILIZE EXIST. SPACES IN PANELBOARD 2H.
UTILIZE AIR-ROD SERIES 400 NON-METALLIC SERVICE
RACKING AND SERVICE BOX TO LOWER TO TOP OF
BOX PROVIDE ALL MOUNTING HARDWARE REQUIRED,
RECONNECT TO EXIST. CIRCUIT.
 8. UTILIZE AIR-ROD SERIES 400 NON-METALLIC SERVICE
RACKING AND SERVICE BOX TO LOWER TO TOP OF
BOX PROVIDE ALL MOUNTING HARDWARE REQUIRED,
RECONNECT TO EXIST. CIRCUIT.
 9. UTILIZE AIR-ROD SERIES 400 NON-METALLIC SERVICE
RACKING AND SERVICE BOX TO LOWER TO TOP OF
BOX PROVIDE ALL MOUNTING HARDWARE REQUIRED,
RECONNECT TO EXIST. CIRCUIT.
 10. EXIST. SMOKE DETECTOR LOCATED IN ENTRY AND RETURN
DO NOT AUTOMATICALLY SHUT DOWN IN CONNECTION TO
EXIST. FIRE ALARM DATA LOOP CIRCUIT.

**WIRING SCHEDULE FOR
VOLTAGE DROP
(20A, 120V, CIRCUITS)**


140'	90 AMPS
170'	90 AMPS
220'	90 AMPS

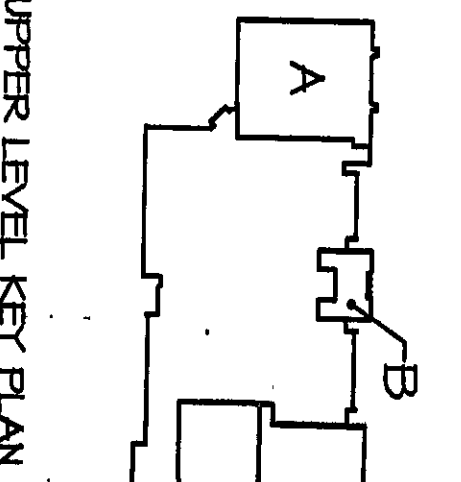

**VEAZEY
PARROTT
&
DURKIN
&
SHOULDERS**
ARCHITECTS
ENGINEERS
PLANNERS

**RENOVATION PROJECT FOR:
DUNELAND SCHOOL CORP.
OCEANVIEW HIGH SCHOOL/MIDDLE SCHOOL
OCEANVIEW, INDIANA**

POWER PLAN - UNIT 7P
Project No: 9902000
Project Date: JUNE 2000
Drawn By: BWH
Approved By: TLM
Drawing No: E.2.6

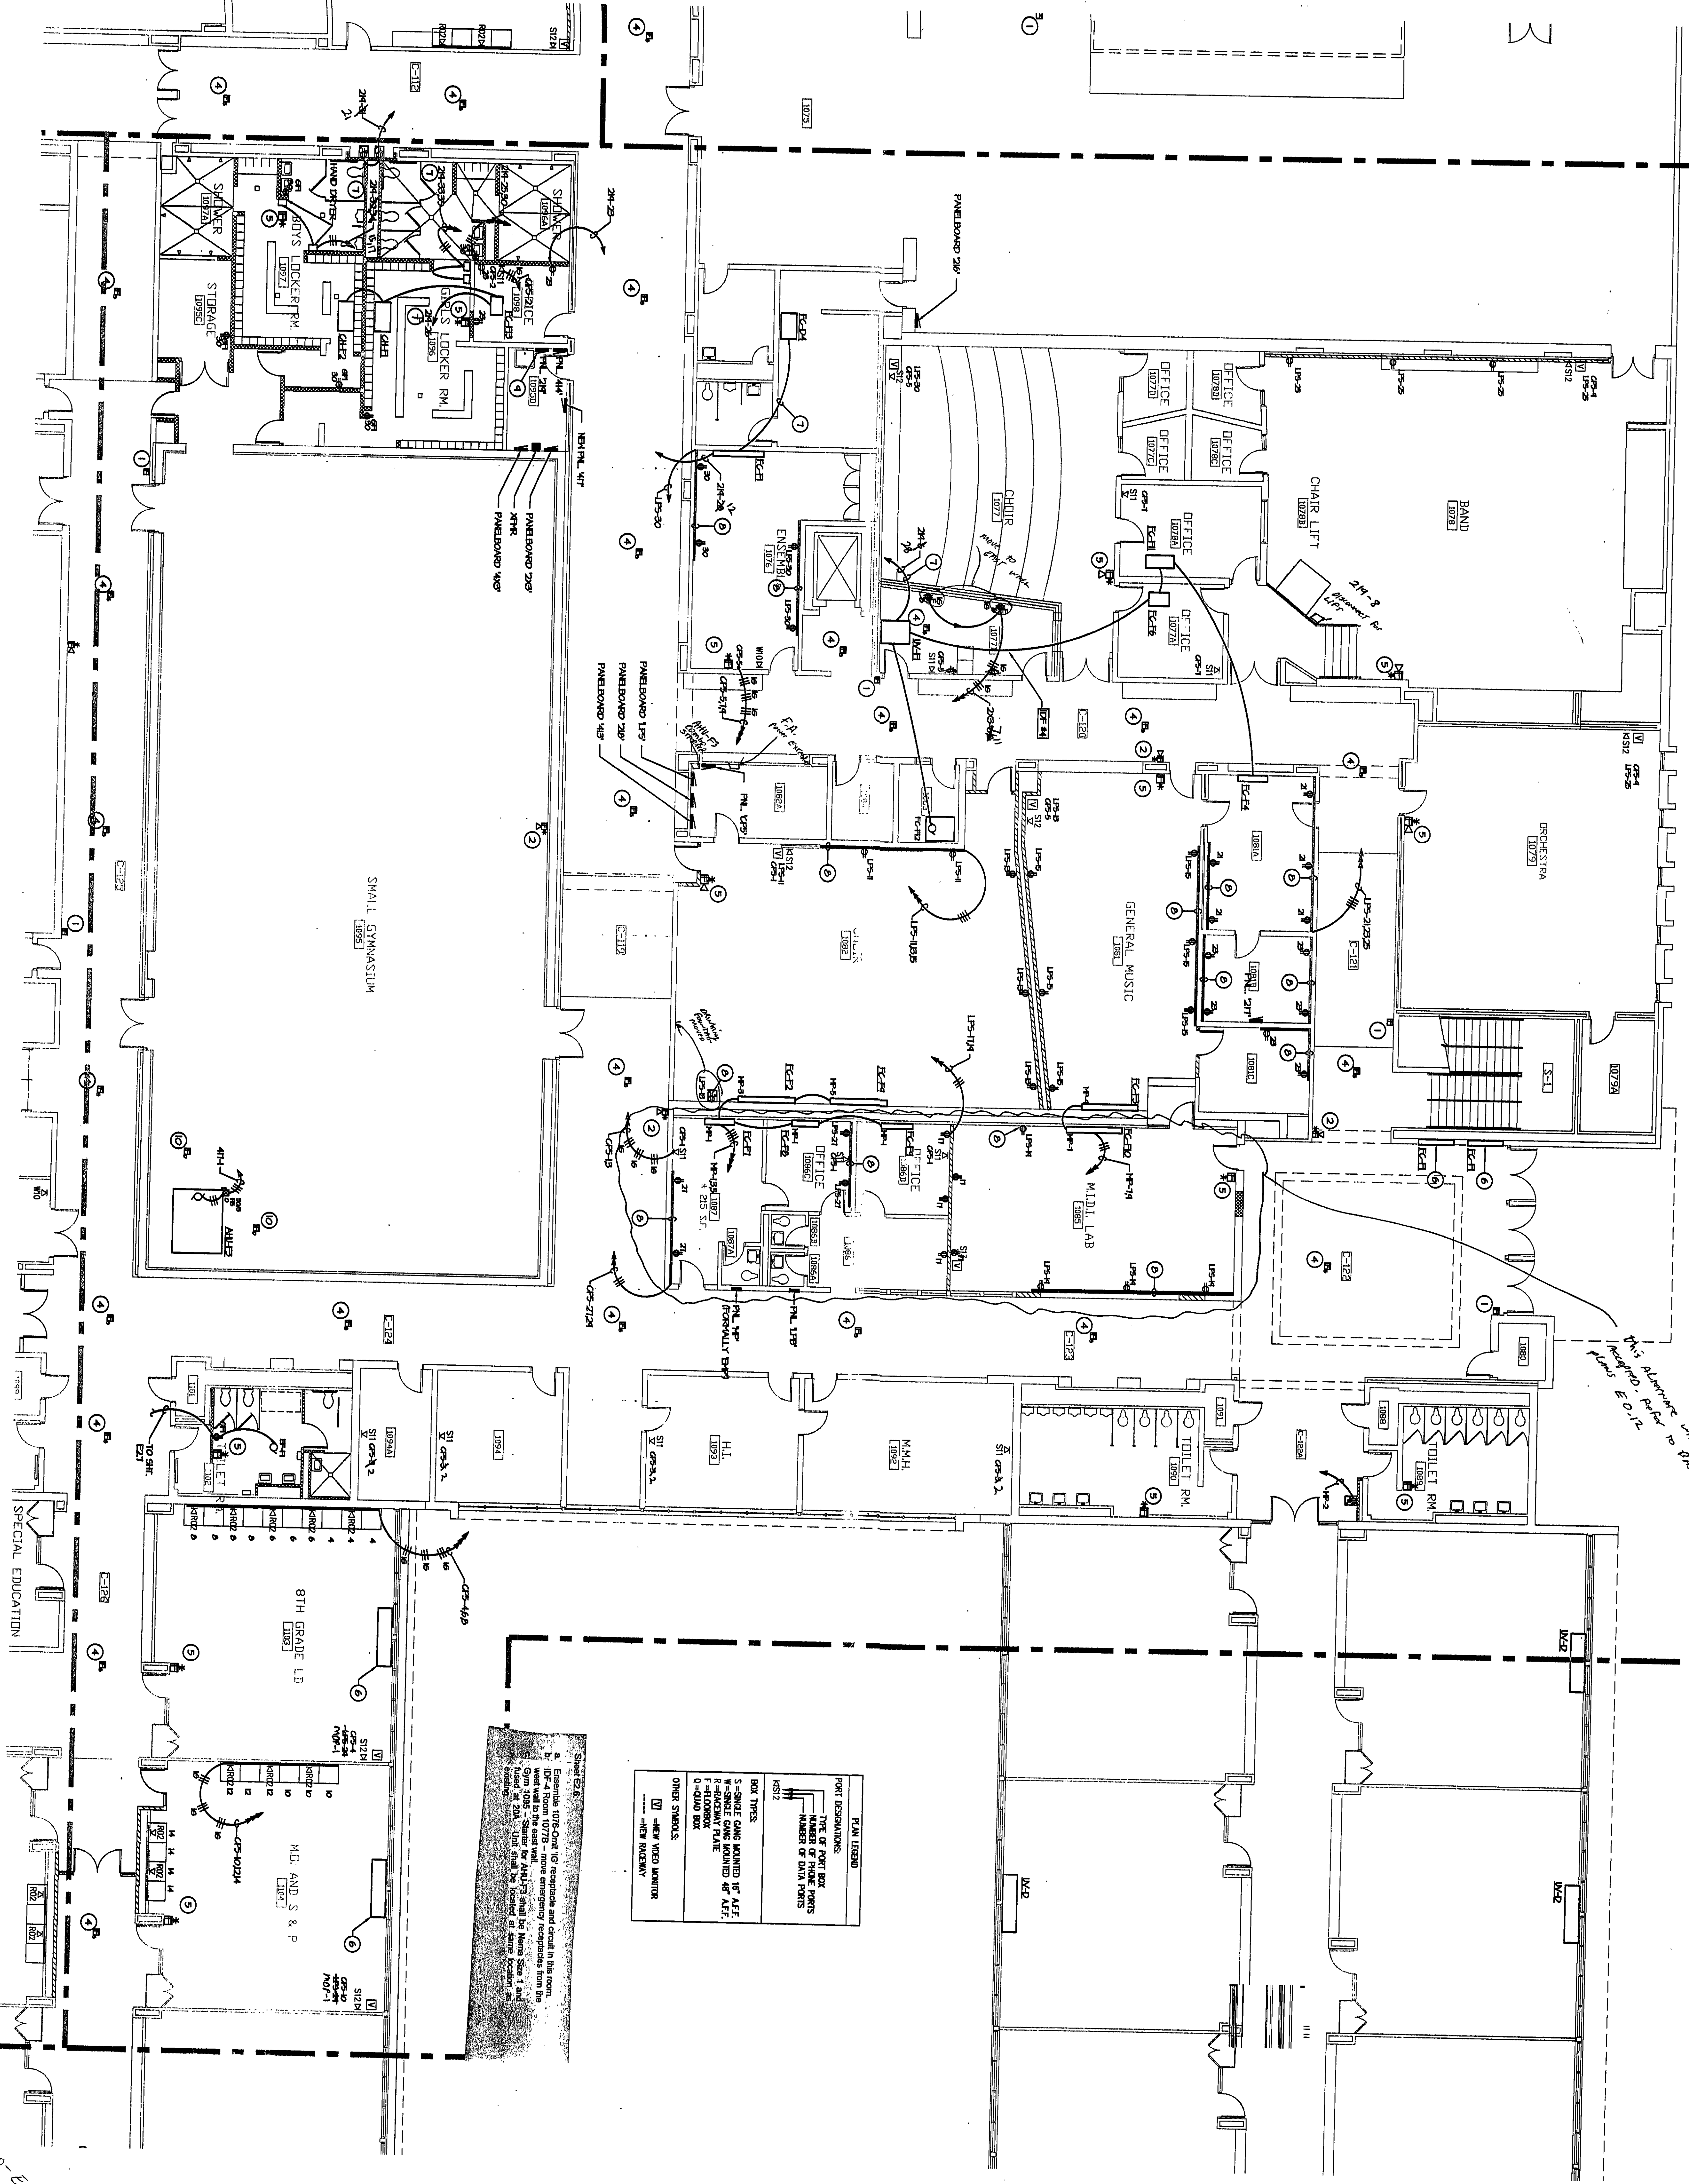

Sheet E-2.6
a. Entrance 100% Cont. 15' emergency and 15' in this room.
b. 100% Cont. 15' emergency and 15' in this room.
c. 100% Cont. 15' emergency and 15' in this room.
d. 100% Cont. 15' emergency and 15' in this room.
e. 100% Cont. 15' emergency and 15' in this room.
f. 100% Cont. 15' emergency and 15' in this room.
g. 100% Cont. 15' emergency and 15' in this room.
h. 100% Cont. 15' emergency and 15' in this room.
i. 100% Cont. 15' emergency and 15' in this room.
j. 100% Cont. 15' emergency and 15' in this room.
k. 100% Cont. 15' emergency and 15' in this room.
l. 100% Cont. 15' emergency and 15' in this room.
m. 100% Cont. 15' emergency and 15' in this room.
n. 100% Cont. 15' emergency and 15' in this room.
o. 100% Cont. 15' emergency and 15' in this room.
p. 100% Cont. 15' emergency and 15' in this room.
q. 100% Cont. 15' emergency and 15' in this room.
r. 100% Cont. 15' emergency and 15' in this room.
s. 100% Cont. 15' emergency and 15' in this room.
t. 100% Cont. 15' emergency and 15' in this room.
u. 100% Cont. 15' emergency and 15' in this room.
v. 100% Cont. 15' emergency and 15' in this room.
w. 100% Cont. 15' emergency and 15' in this room.
x. 100% Cont. 15' emergency and 15' in this room.
y. 100% Cont. 15' emergency and 15' in this room.
z. 100% Cont. 15' emergency and 15' in this room.

PLAN LEGEND

PORT DESIGNATIONS
TYPE OF PORT BOX
NUMBER OF DATA POINTS
BOX TYPES
1 - SINGLE GROUND MOUNTED 12" A.F.F.
2 - SINGLE GROUND MOUNTED 12" A.F.F.
3 - SINGLE GROUND MOUNTED 12" A.F.F.
100 - SINGLE GROUND MOUNTED 12" A.F.F.

2000-E-2.6