
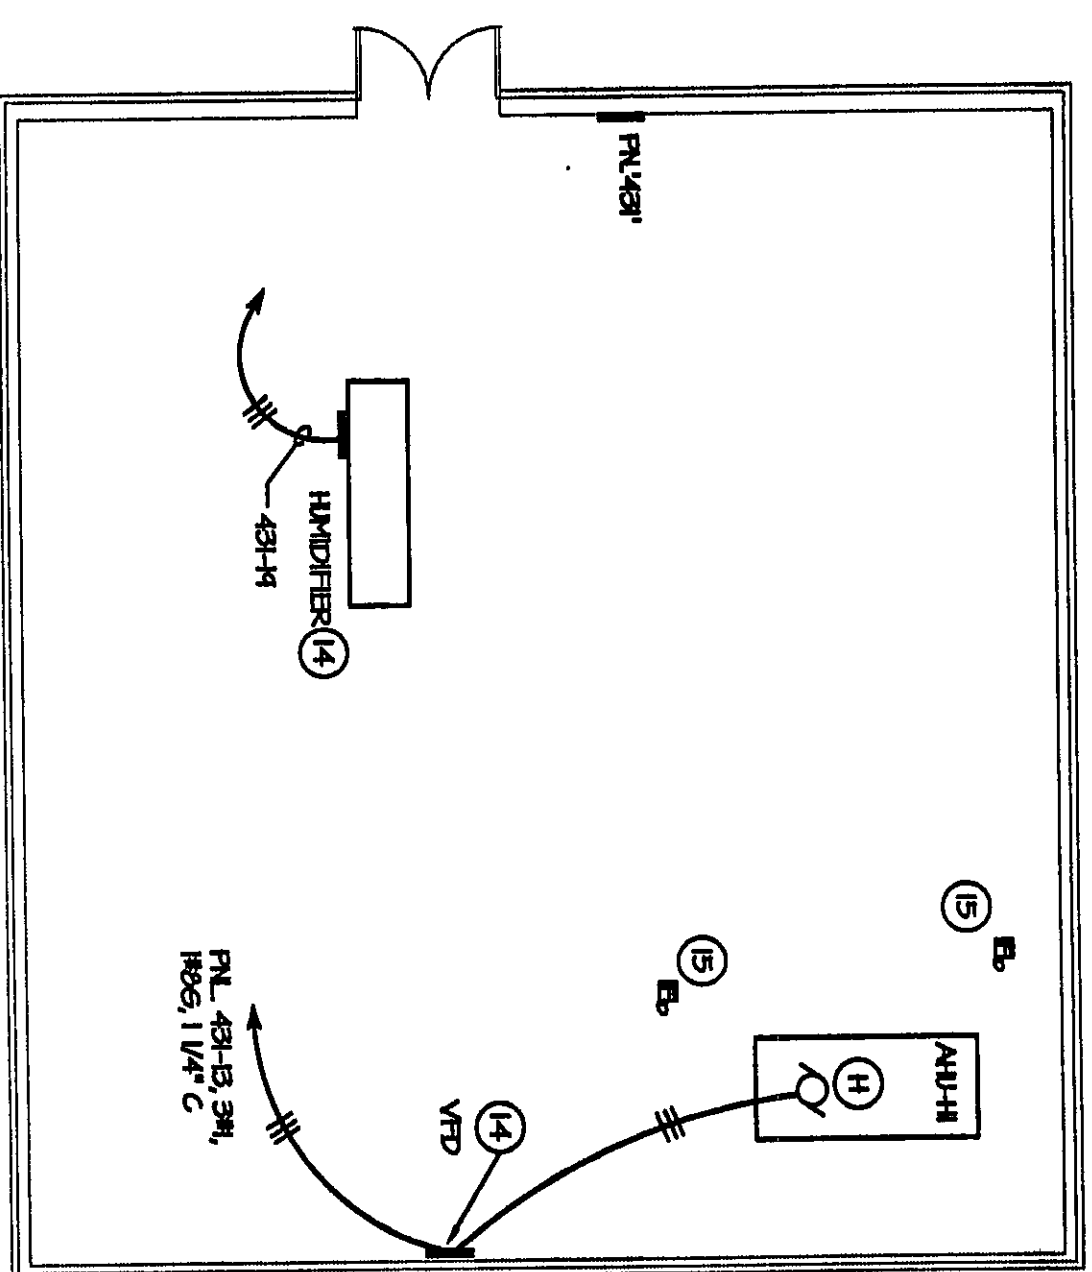


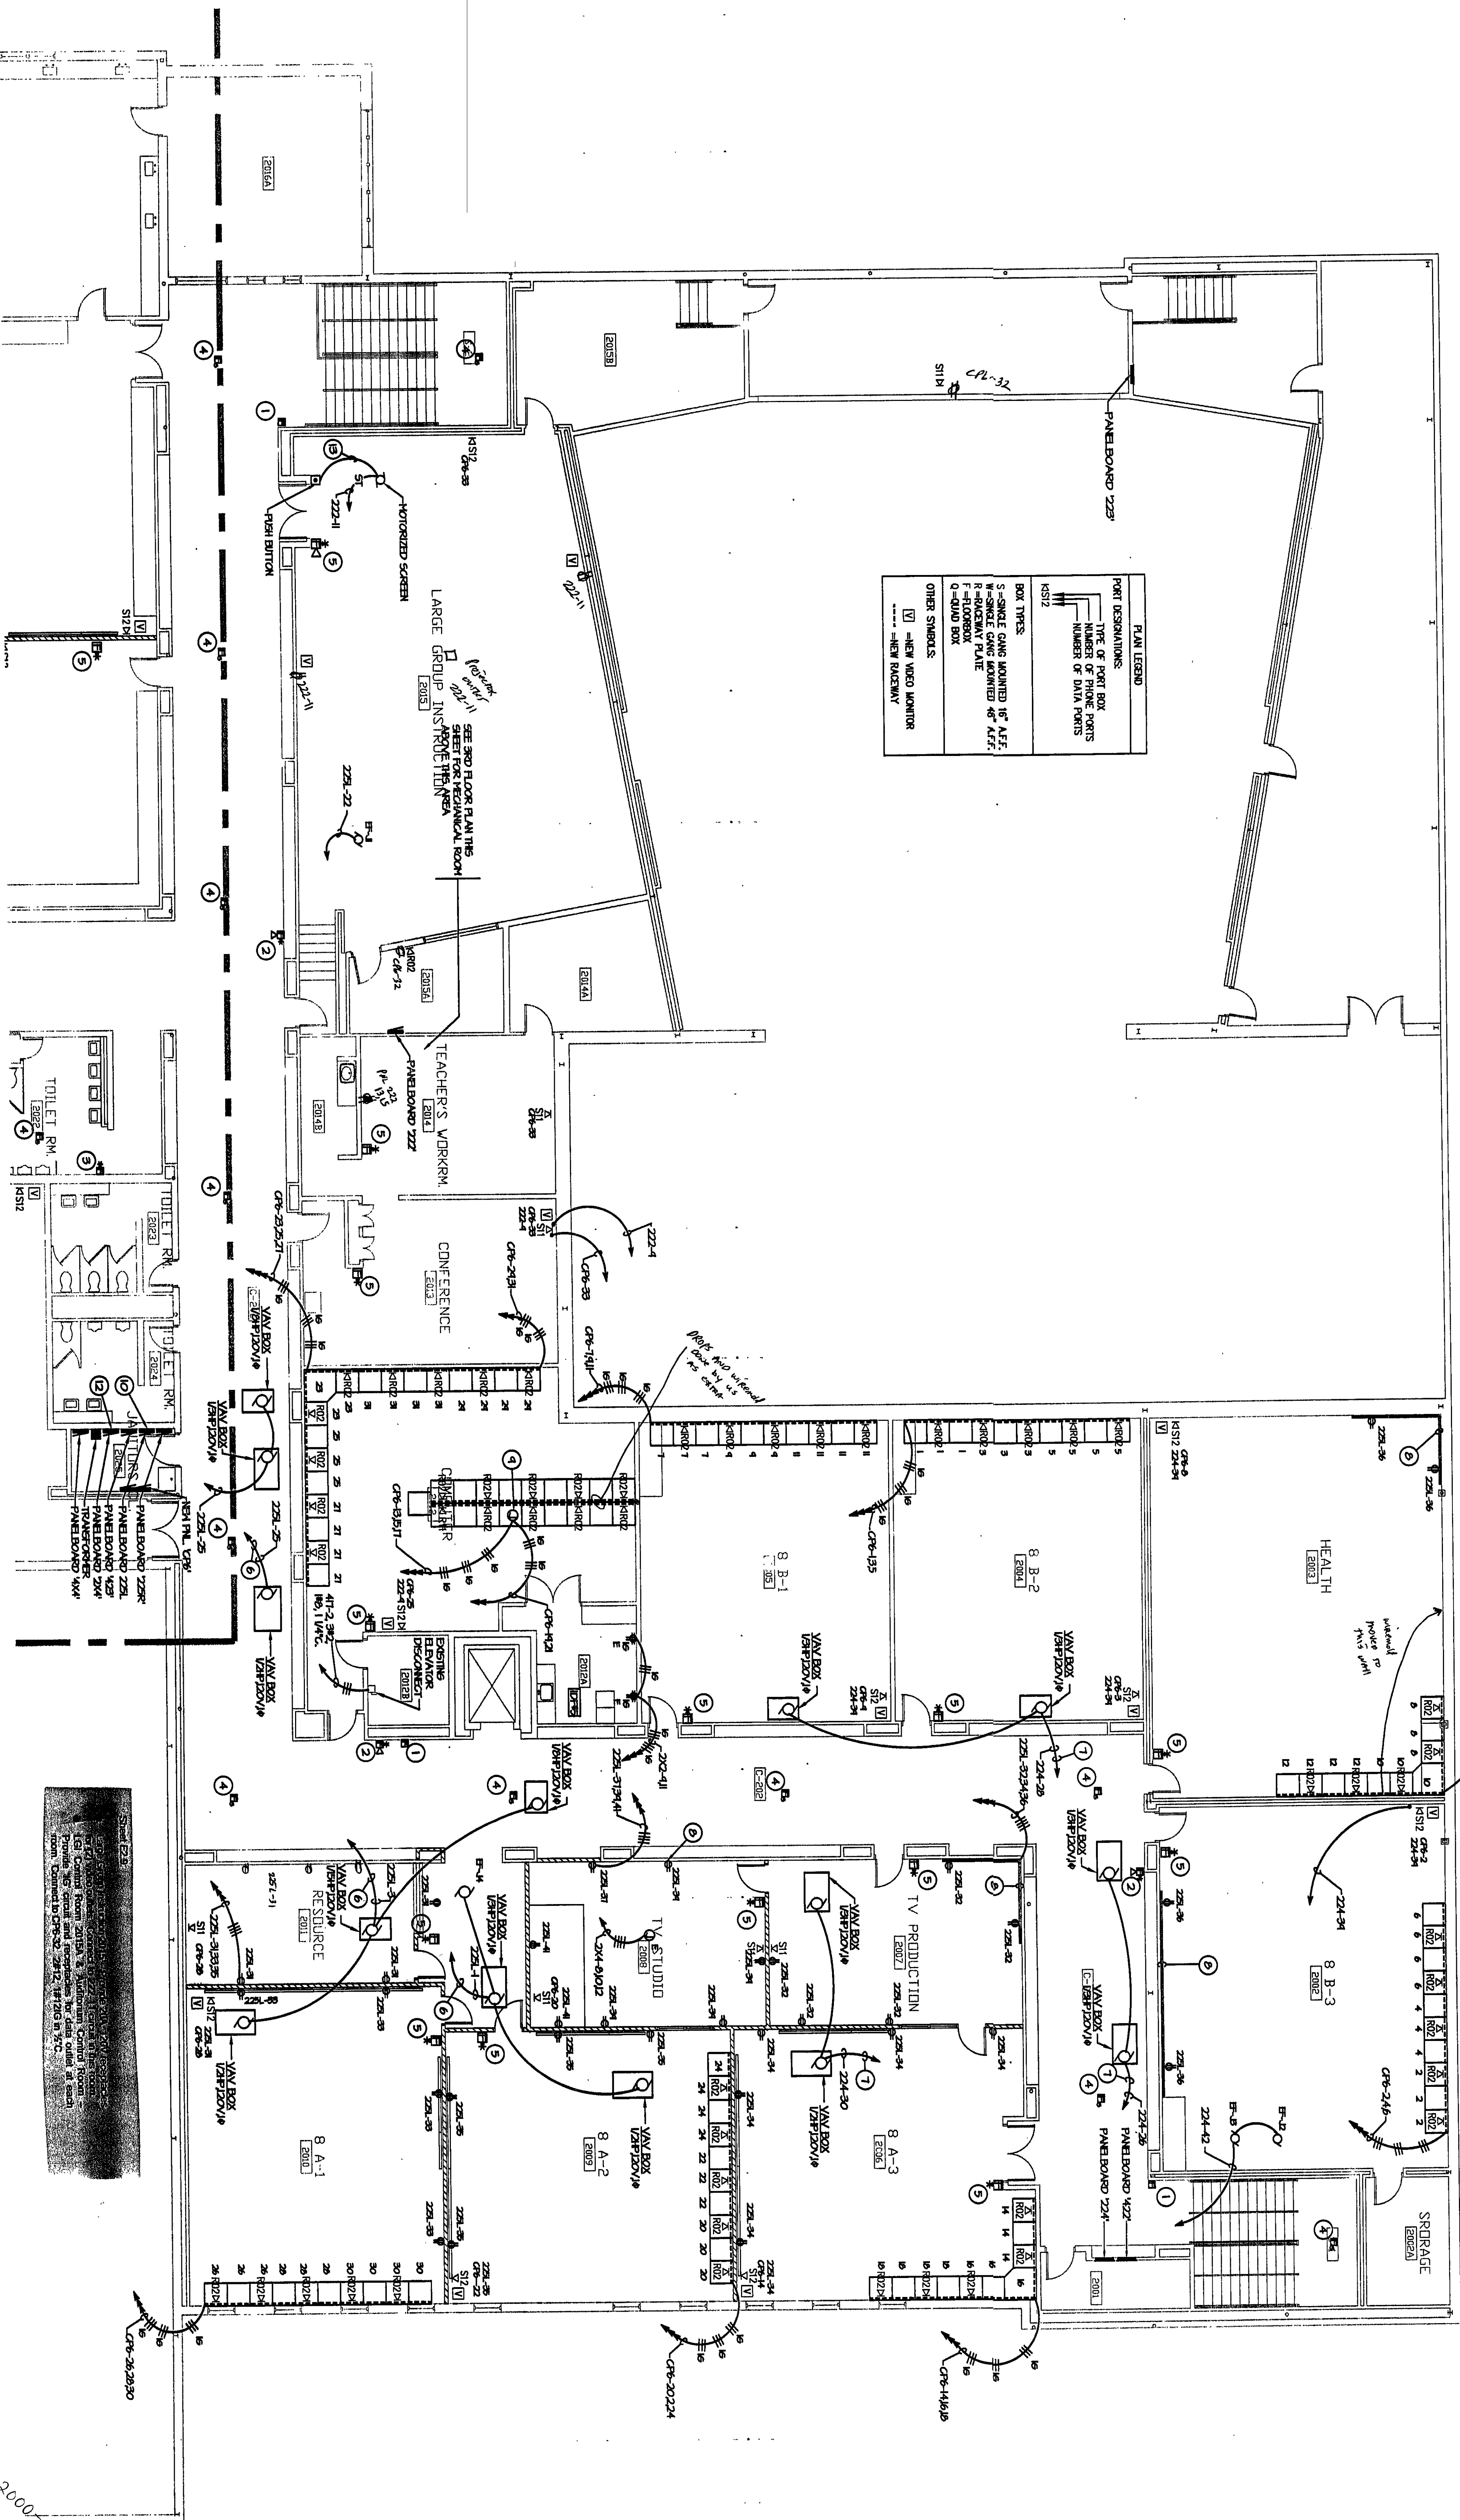

3RD FLOOR PLAN - ABOVE ROOM 2014
SCALE: 1/8" = 1'-0"

[illegible]

2000-E-34

GENERAL ELECTRICAL NOTES:


A. FOR TYPICAL COMPUTER CIRCUITS AND LAYOUT REQUIRED IN CLASSROOMS, OFFICES, LABS, ETC., SEE TYPICAL LAYOUT ELEVATIONS ON SHIT, E & L. COORDINATE INSTALLATION OF ALL SURFACE MOUNTED RACEWAY WITH DW-17.

GENERAL ELECTRICAL NOTES


- [illegible]

NOTES

WRING SZING FOR VOLTAGE DROP (20A, 120V, CIRCUITS)	
240'	#10 AWG
375'	#8 AWG
525'	#6 AWG

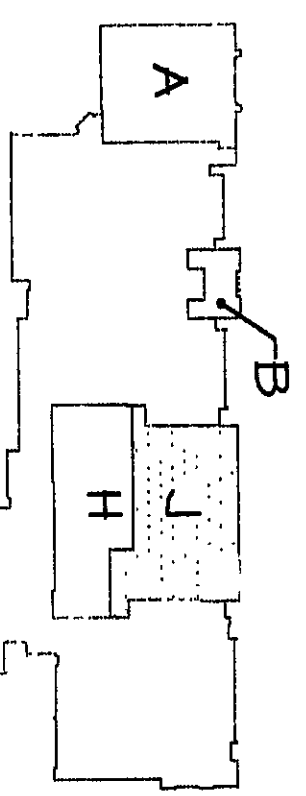

UPPER LEVEL KEY PLAN

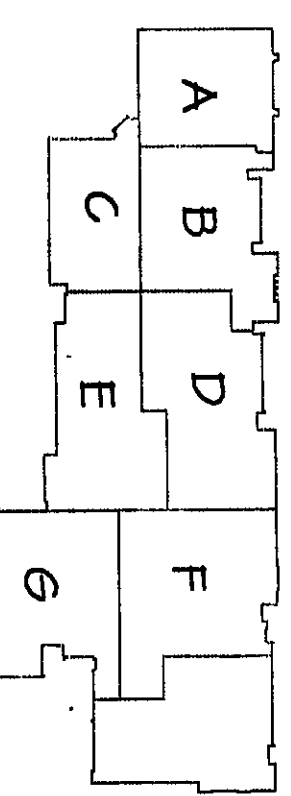

LOWER LEVEL KEY PLAY

NORTH
SCALE: 1/8" = 1'-0"

**ARCHITECTS
ENGINEERS
PLANNERS**

**VEAZEY
PARROTT
DURKIN &
SHOULDERS**

RENOVATION PROJECT FOR:
DUNELAND SCHOOL CORP.
CHESTERTON HIGH SCHOOL/MIDDLE SCHOOL
CHESTERTON, INDIANA

POWER PLAN – UNIT J

E.2.9