



A. FLUORESCENT LIGHTING FIXTURES IN THE TUNNEL SHALL BE PROVIDED WITH THE FOLLOWING, EXCEPT WHERE INDICATED OTHERWISE: TWO (2) T-8 LAMPS AND ONE (1) TWO-LAMP ELECTRONIC BALLAST, FIELD VERIFY EXISTING LIGHTING FIXTURES VOLTAGE REQUIREMENTS PRIOR TO ORDERING.

① PULS SMOKE DETECTORS LOCATED IN SUPPLY AND RETURN DUCT TO AUTOMATICALLY SHUT DOWN UNIT. CONNECT TO EXISTING FIRE ALARM DATA LOOP CIRCUIT.

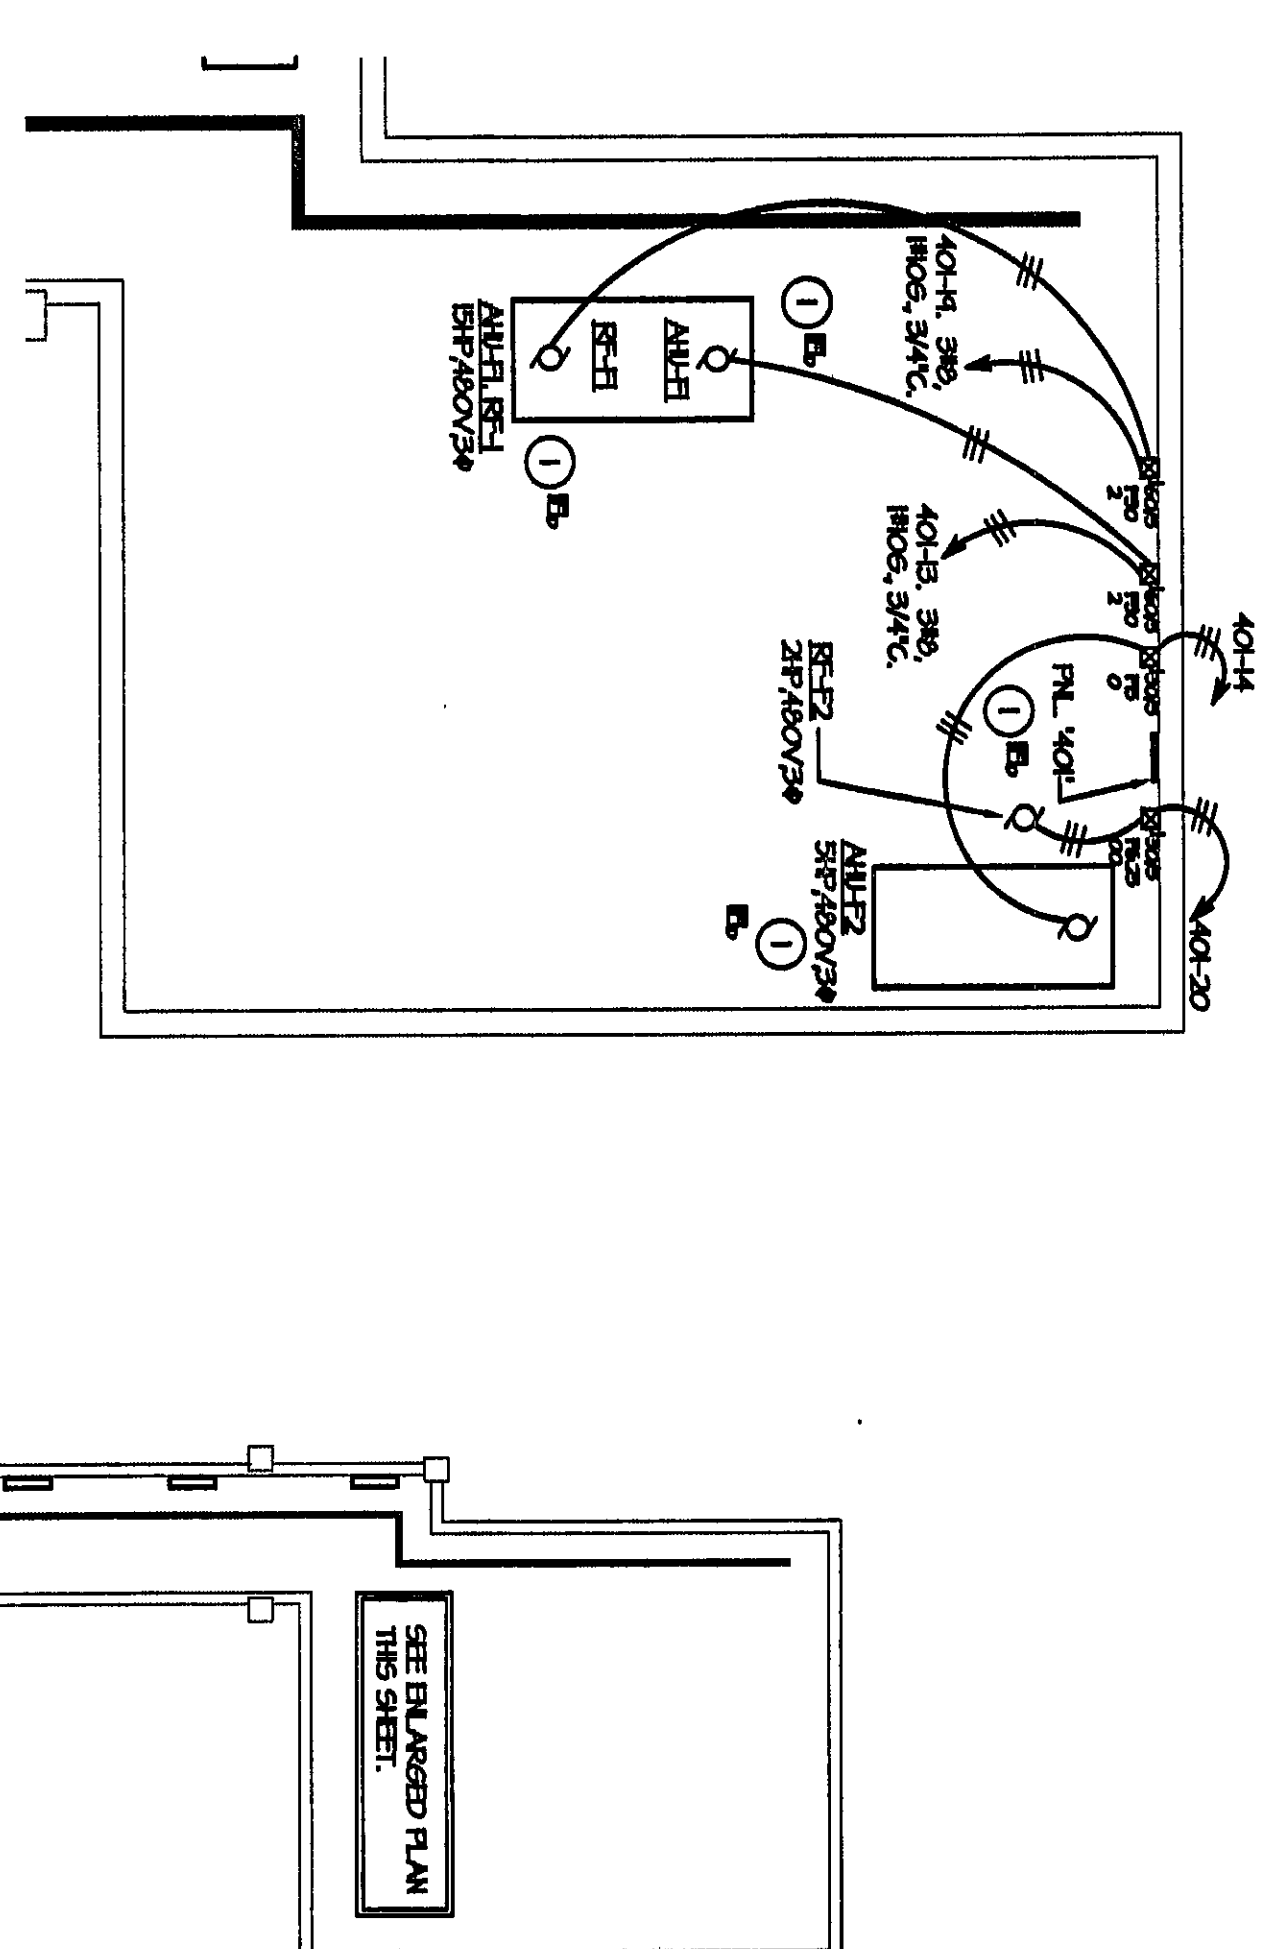

SEE ENLARGED PLAN
THIS SHEET.

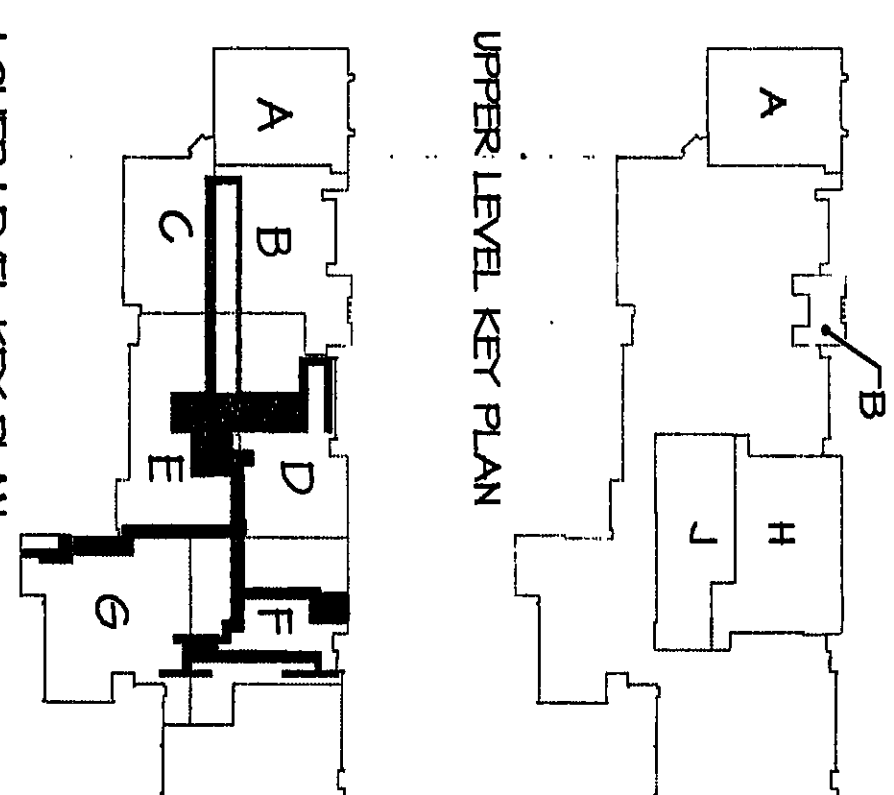

NORTH
SCALE: 1/16" = 1'-0"

**ARCHITECTS
ENGINEERS
PLANNERS**

628 Main Street
Suite 400
Evansville, In 4770

Drawing title
POWER AND LIGHTING PLAN-TUNE.

2000-E-36