

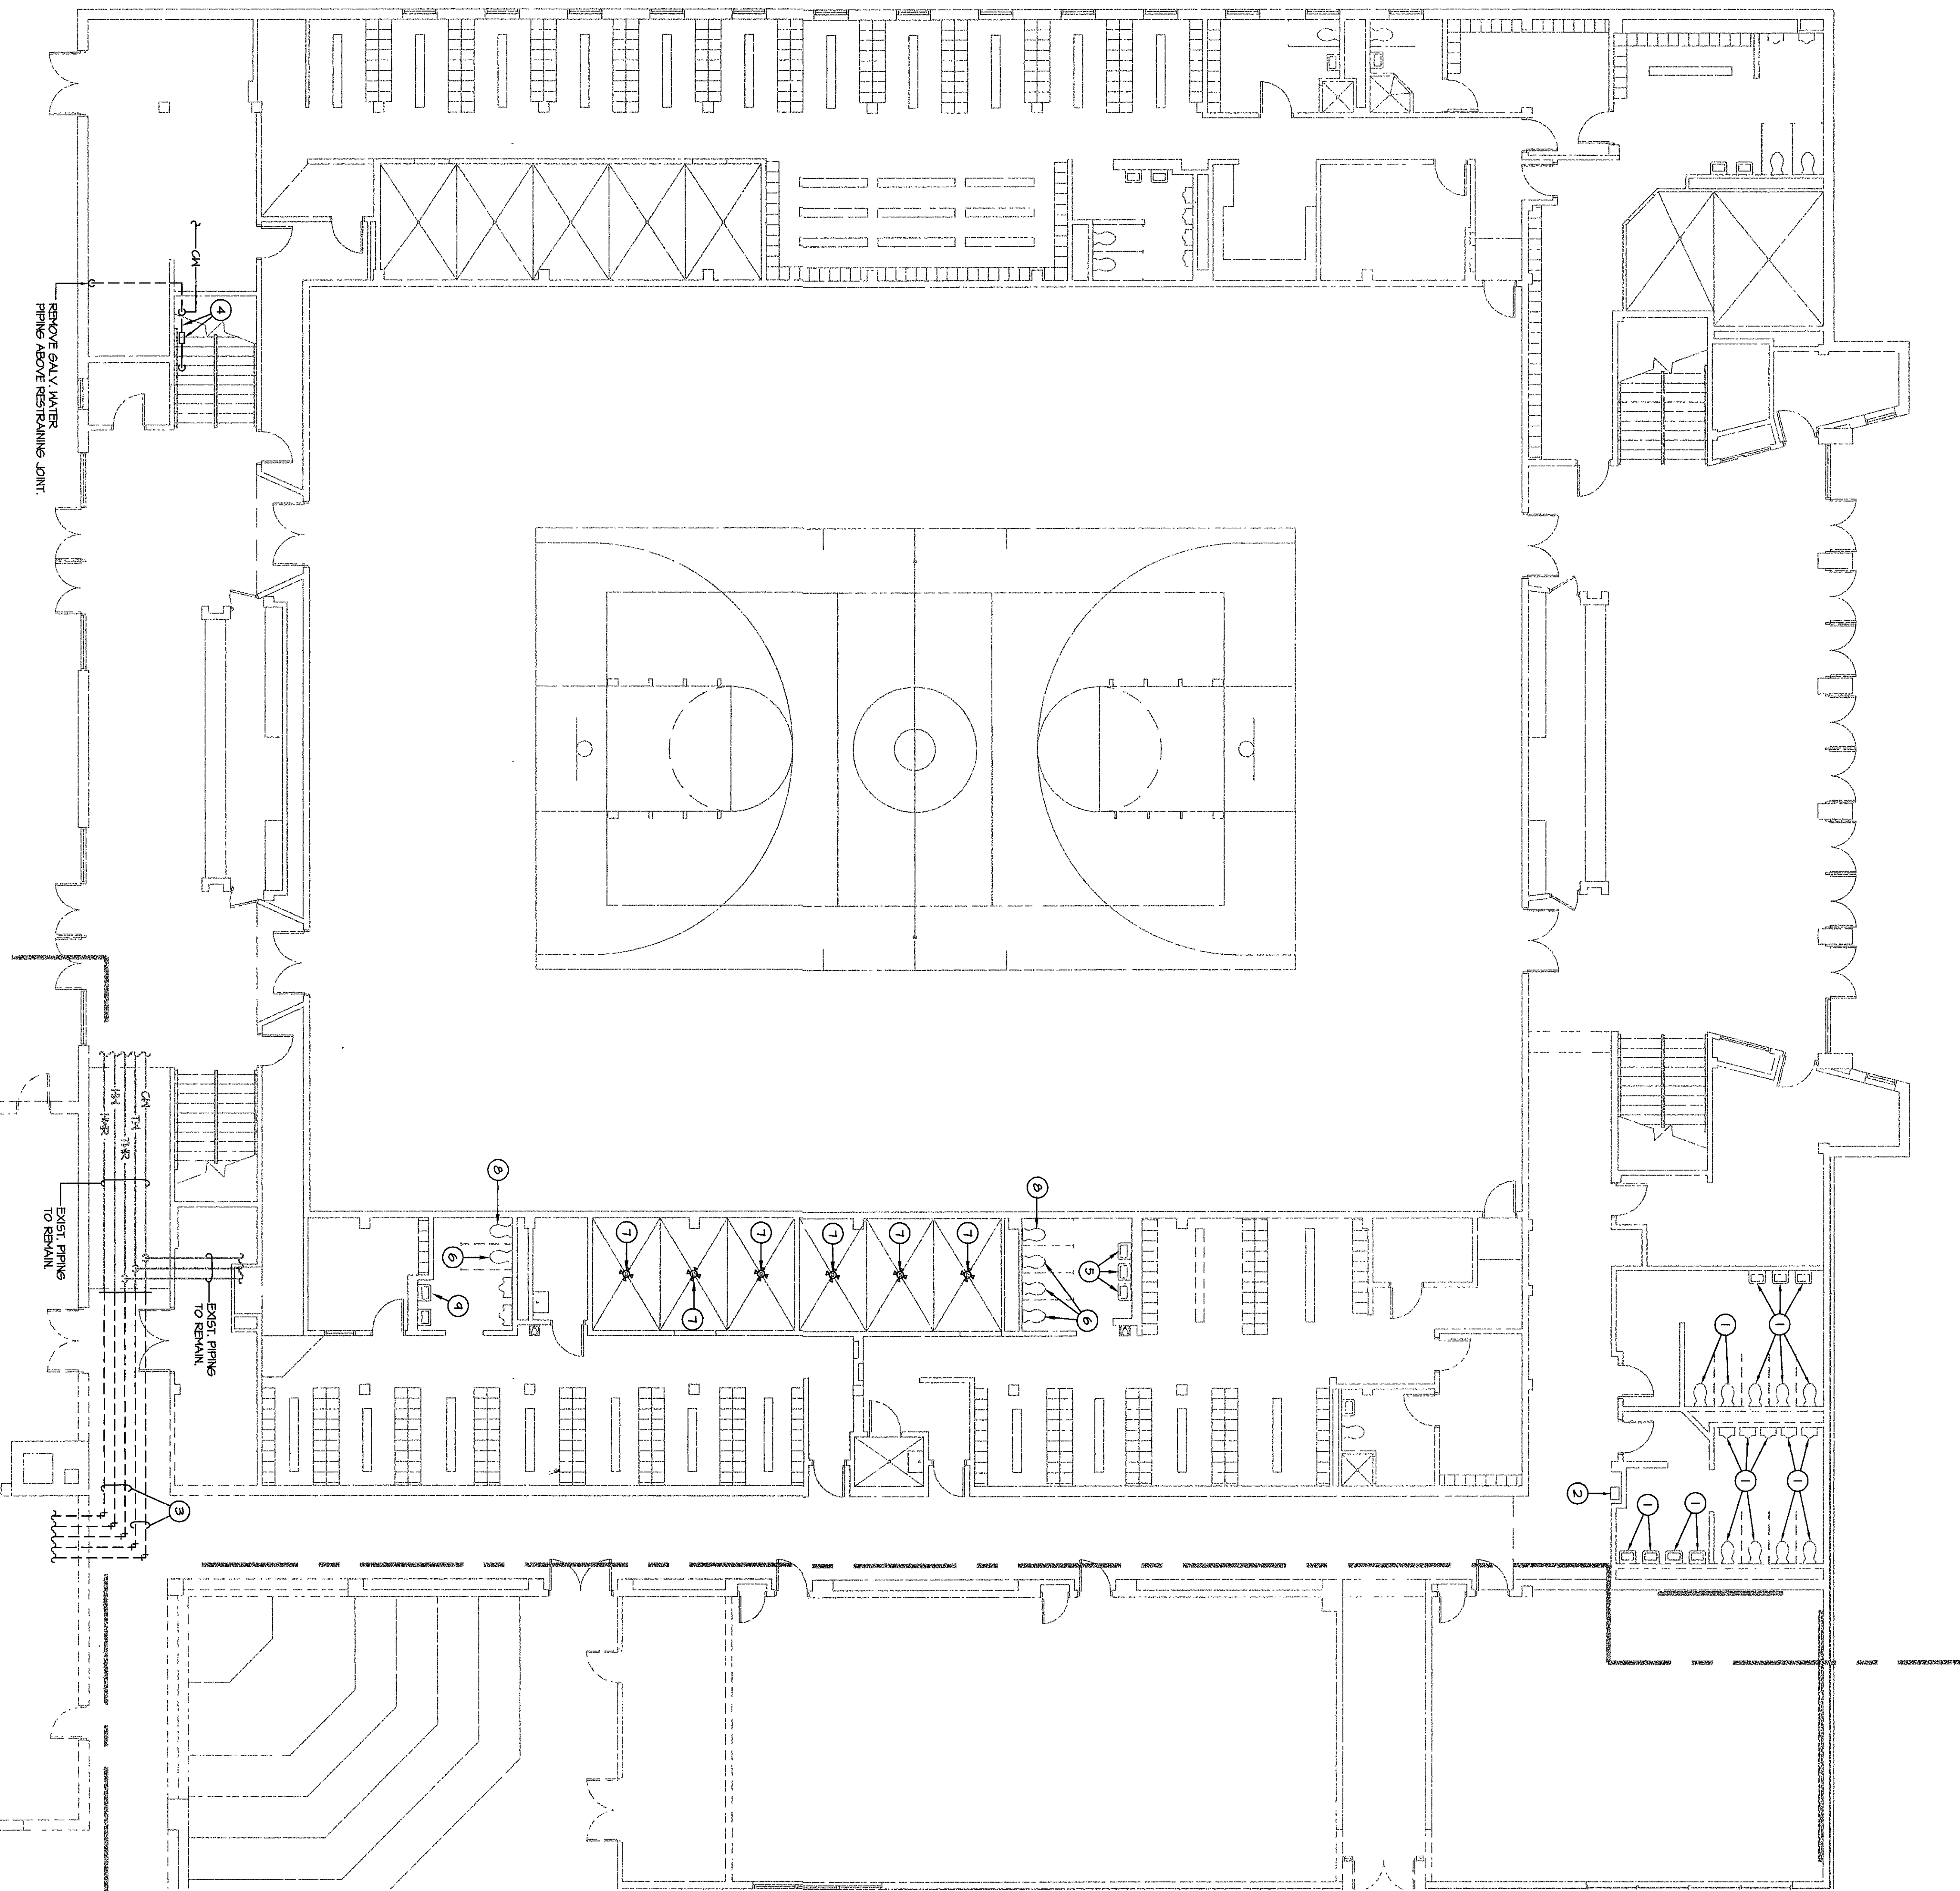


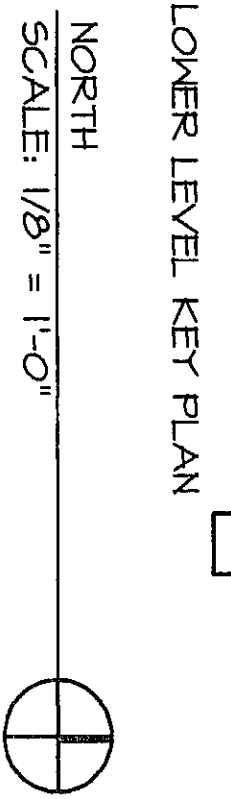

DEMOLITION PLAN - UNIT A

SCALE: 1/8" = 1'-0"

- REFERENCE NOTES:**
- 1. REMOVE EXIST. PLUMBING FIXTURES AND PIPING. REWORK ROUGH-IN AS REQUIRED FOR NEW LAYOUT.
 - 2. REMOVE EXISTING WATER CLOSET AND PIPING. REWORK ROUGH-IN AS REQUIRED FOR NEW BOX. SEE FINISH SCHEDULE.
 - 3. REMOVE PORTION OF DOMESTIC WATER PIPING AS INDICATED IN DASHED LINES.
 - 4. REMOVE SANITIZED WATER SERVICE PIPING DOWNSTREAM OF METER AND REPLACE WITH NEW COPPER. SEE DETAIL ON SHEET P-11.
 - 5. REMOVE WALL HUNG LAVATORY AND PIPING. PLUG WASTE AND CAP WATER IN WALL.
 - 6. REMOVE WALL HUNG WATER CLOSET, FLUSH VALVE, AND PIPING. CUT OFF CARRIER BOLTS AND PLUG WASTE IN WALL. CAP WATER IN WALL.
 - 7. REMOVE SHOWER LEADS AT COLUIN SHOWERS. 4 PER COLUIN. SEE FINISH SCHEDULE FOR NEW SHOWERS.
 - 8. REMOVE WATER CLOSET AND FLUSH VALVE. REWORK ROUGH-IN AS REQUIRED FOR NEW ADA FIXTURE.
 - 9. REMOVE LAVATORY AND PIPING. REWORK ROUGH-IN AS REQUIRED FOR NEW ADA FIXTURE.

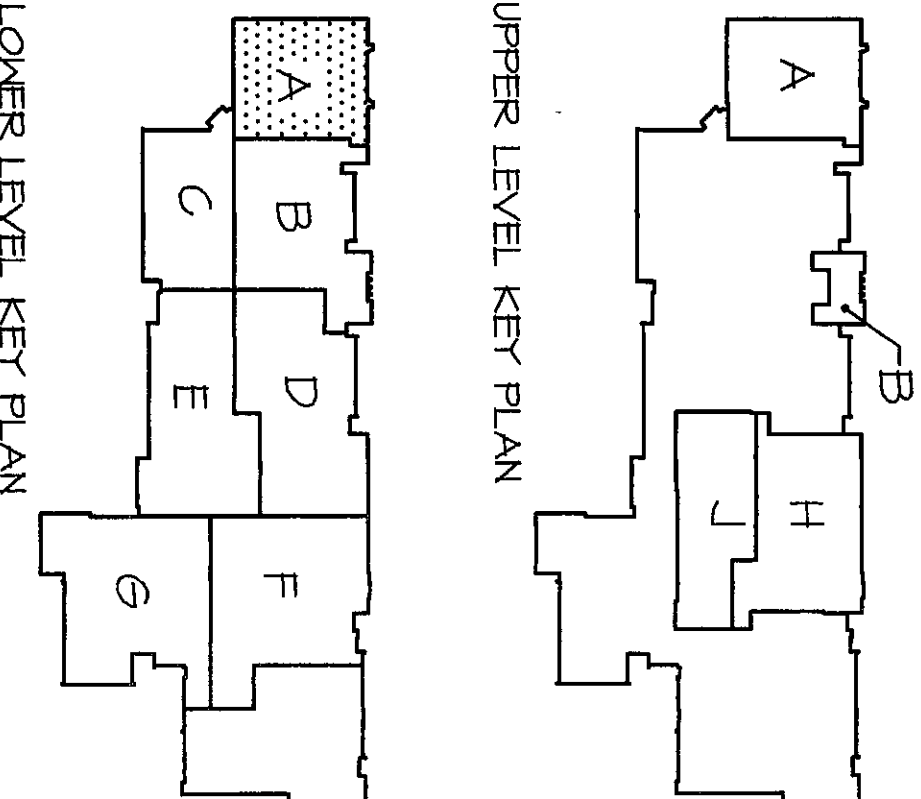

ARCHITECTS
ENGINEERS
PLANNERS

**VEAZEY
PARROTT
&
SHOULDERS**

RENOVATION PROJECT FOR:
DUNELAND SCHOOL CORP.
CHESTER HIGH SCHOOL/MIDDLE SCHOOL
CHESTER, INDIANA

Drawing Title:
DEMOLITION PLAN - UNIT A

Project No.	940000
Project Date	JUNE 2000
Drawn By	RLM
Approved By	KLF
Drawing No.	P 0.1

Professional Engineer
No. 19257
State of Indiana
Professional Engineer