



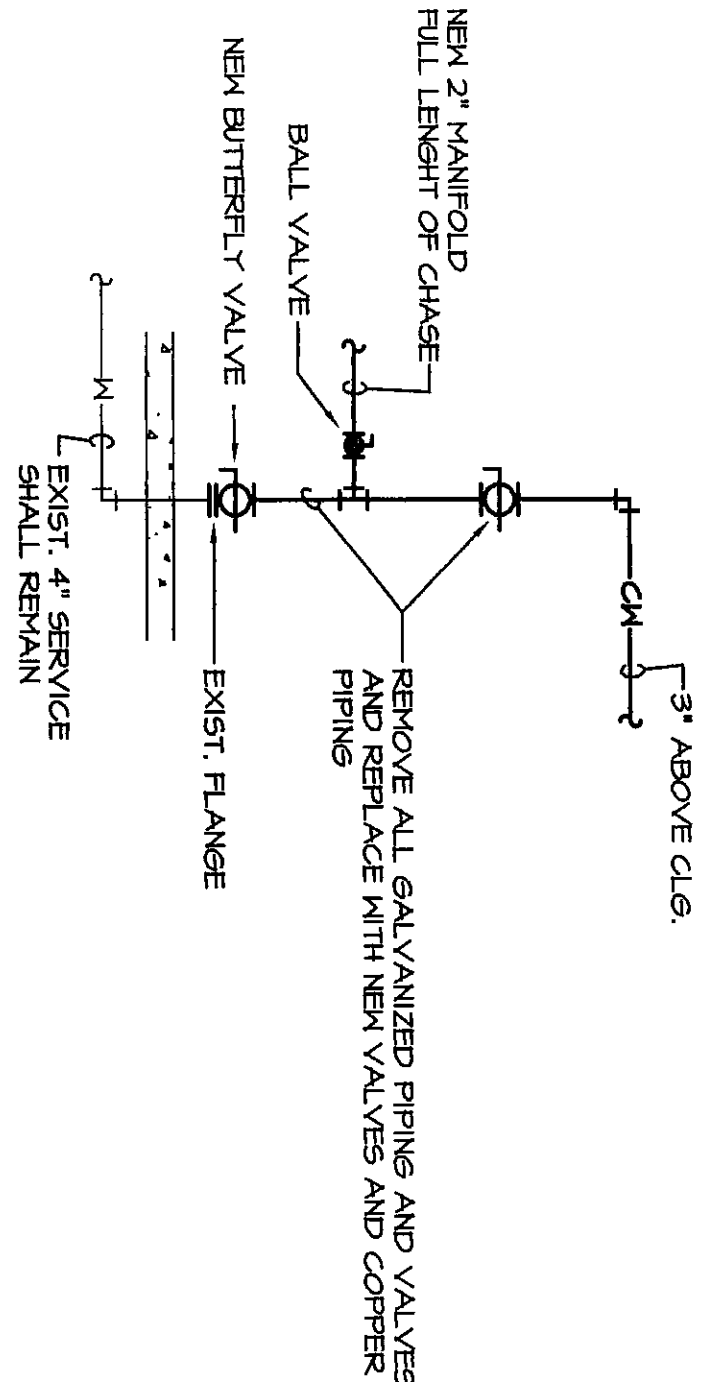


WATER SERVICE RISER DETAIL
SCALE: NONE


- REFERENCE NOTES:**
1. INSTALL BALL VALVE, CHECK VALVE, AND BALANCING VALVE ON EXIST. 1/2" HMR PIPING.
 2. CONNECT WASTE AND WATER FOR LAV TO EXIST. IN CHASE. GENERAL CONTRACTOR TO PATCH WALL.
 3. REMOVE AND REPLACE LABORATORY FOUNTAINS WITH NEW AS FOLLOWS.
 4. COMBINATION GAS AND WATER FAUCET EQUAL TO T15 BRASS MODEL BL-6005-2.
 5. HOT AND COLD WATER FOUNTAIN FAUCET WITH VACUUM BREAKER EQUAL TO T15 BRASS MODEL BL-5700-6.
 6. SINGLE CO. FAUCET WITH VACUUM BREAKER EQUAL TO T15 BRASS MODEL BL-5705-6.
 7. SINGLE 1/4" FAUCET WITH VACUUM BREAKER EQUAL TO T15 BRASS MODEL BL-5705-6.
 8. GAS RISER WITH TWO STOPS AT 4" O.D. EQUAL TO T15 BRASS MODEL BL-4800-0.
 9. 2" IN. SIZE 200 SHORTSOL.
 10. SEE WATER SERVICE RISER DETAIL, THIS SHEET.
 11. NEW 2" CM MANIFOLD WITH 2" IN. SIZE 400 SHORTSOL. NEEDS INDICATED. CONNECT TO NEW FLUID VALVES AND CM BRANCHES TO LAV SUPPLIES.
 12. DROP 4" IN. COIL IN COVER TO A MINIMUM OF 4" BELOW GRADE. CONNECT TO EXIST. STORM DRAIN AS INDICATED. GENERAL CONTRACTOR TO PATCH AND FINISH EXTERIOR ADJACENT OR SHIELD TYP AT EXIST. 12".

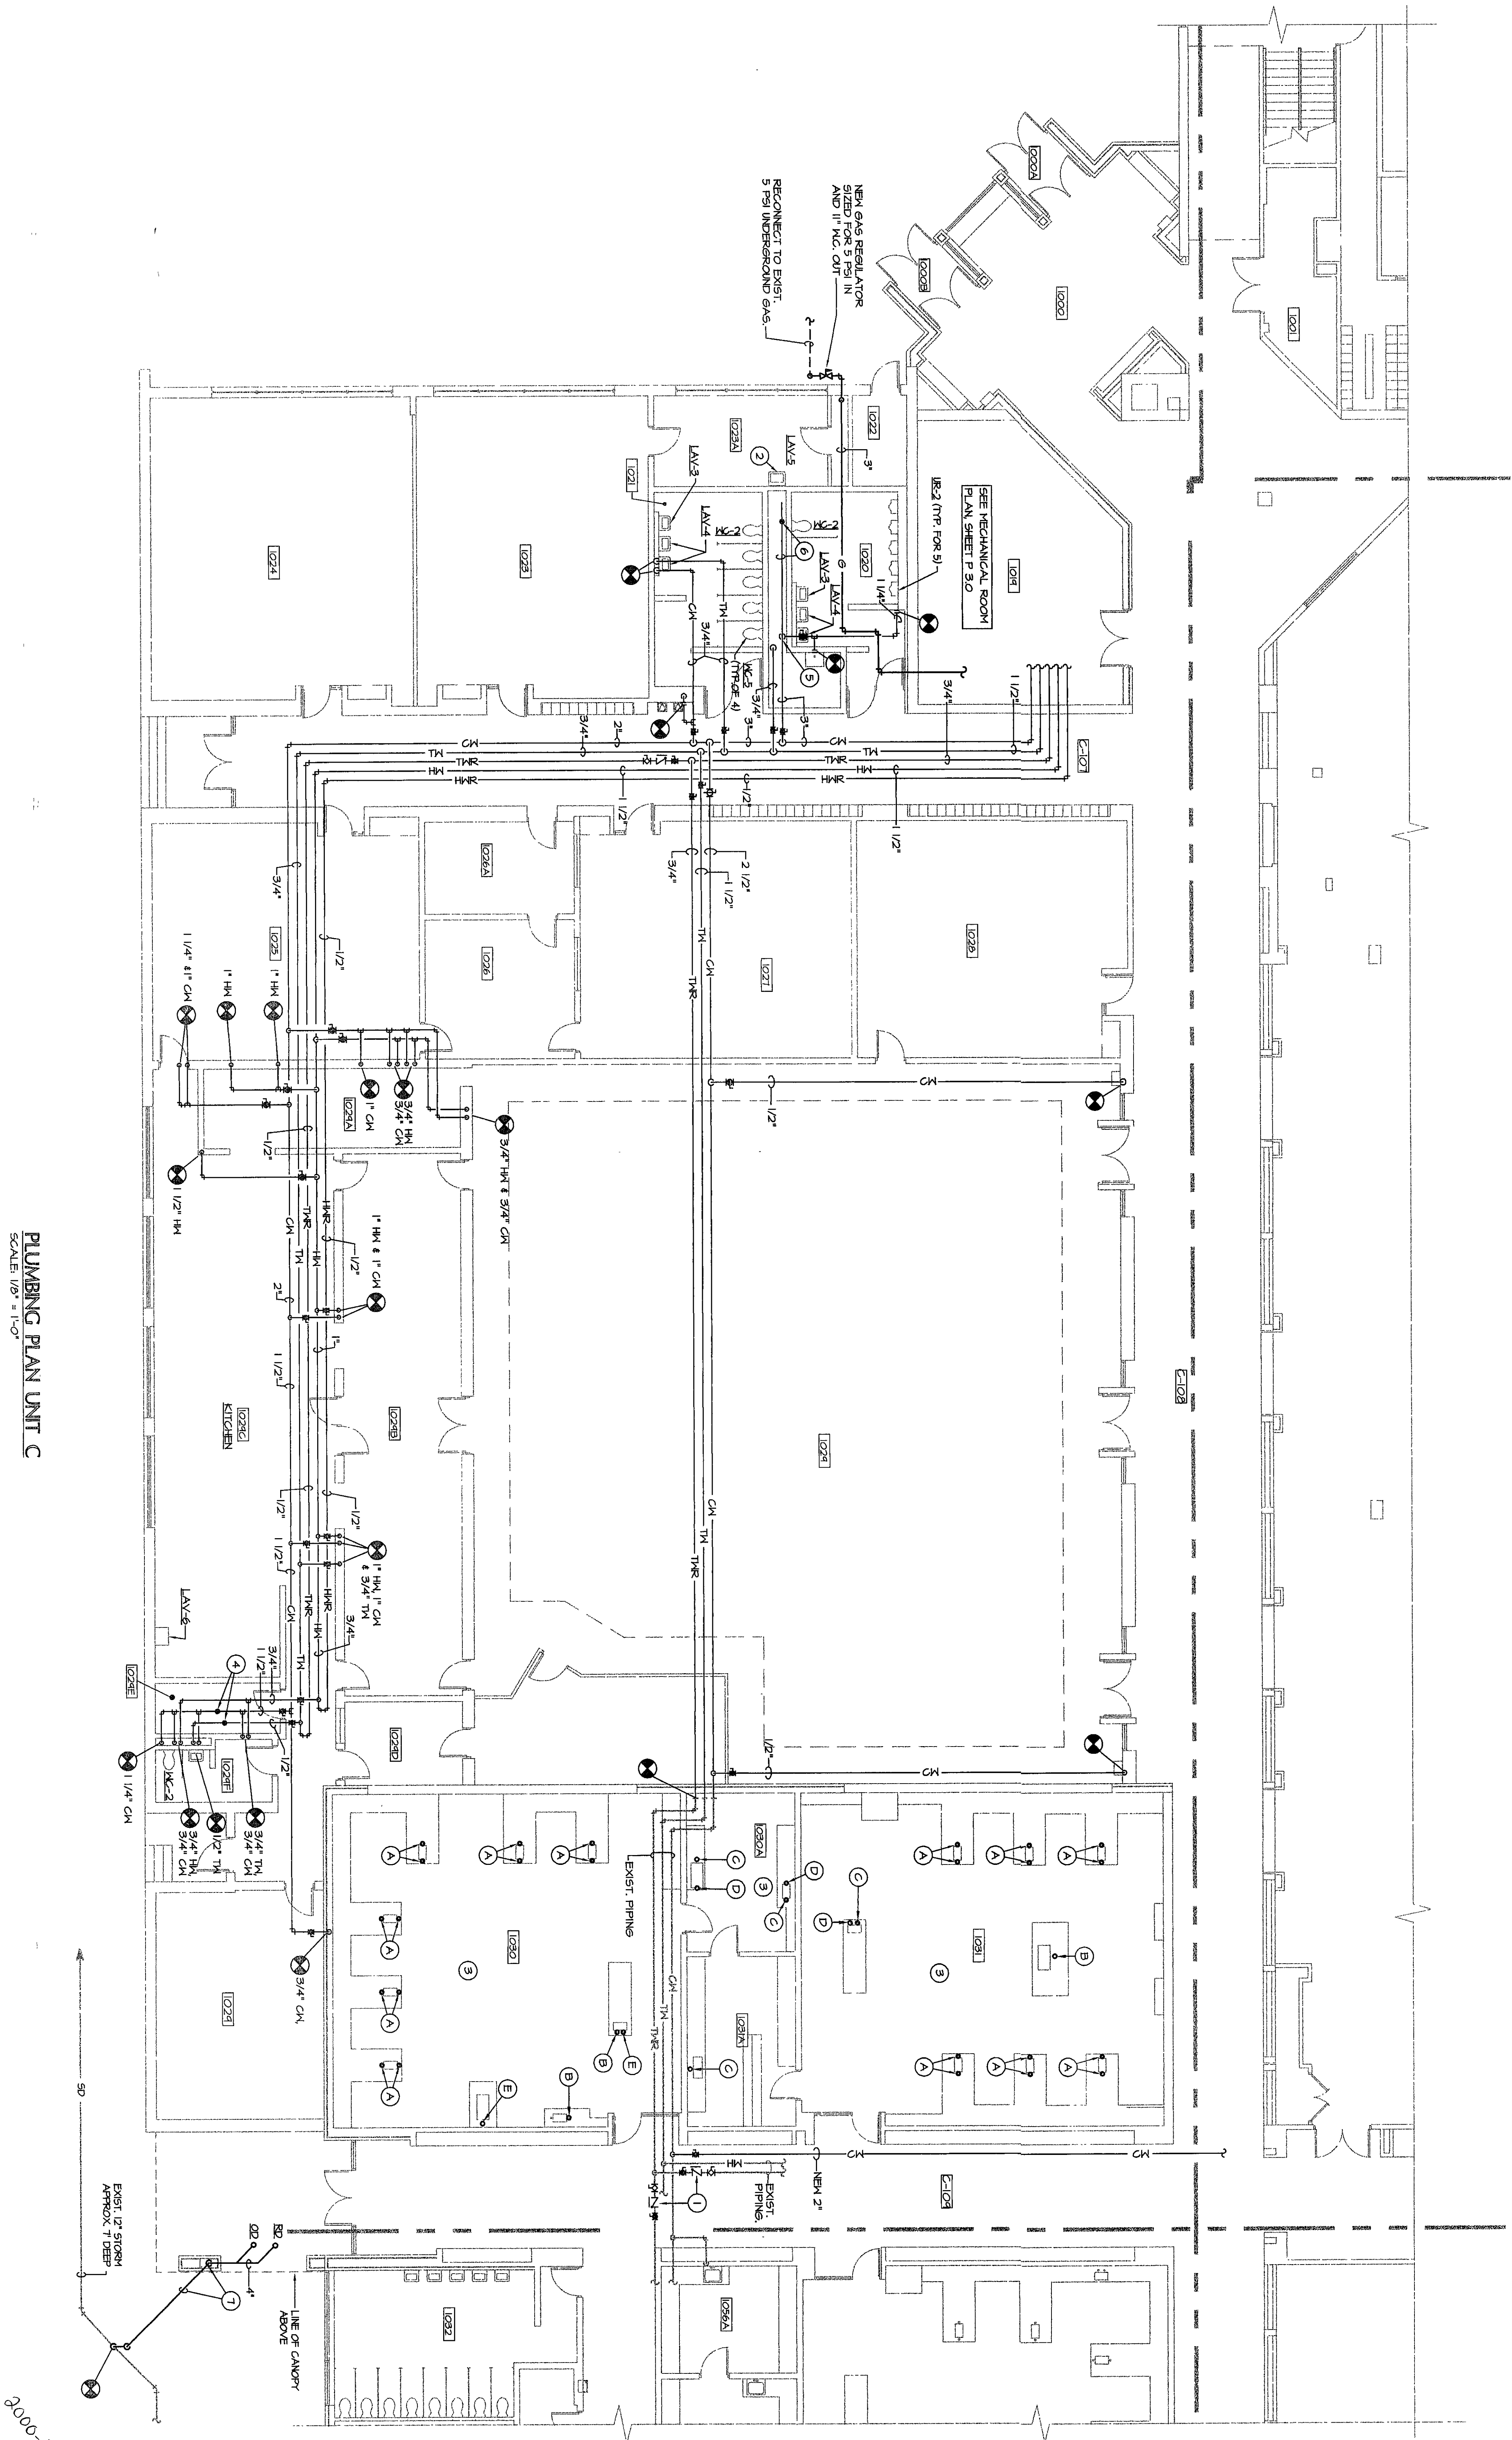

PLUMBING PLAN UNIT C
SCALE: 1/8" = 1'-0"

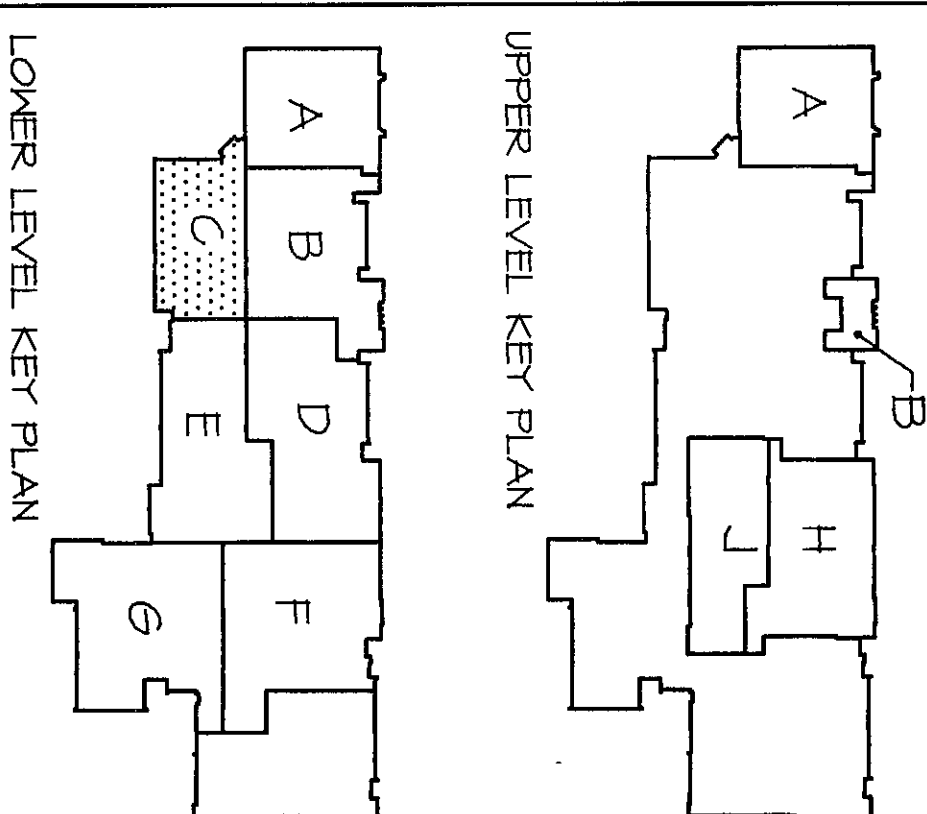

UPPER LEVEL KEY PLAN
SCALE: 1/8" = 1'-0"

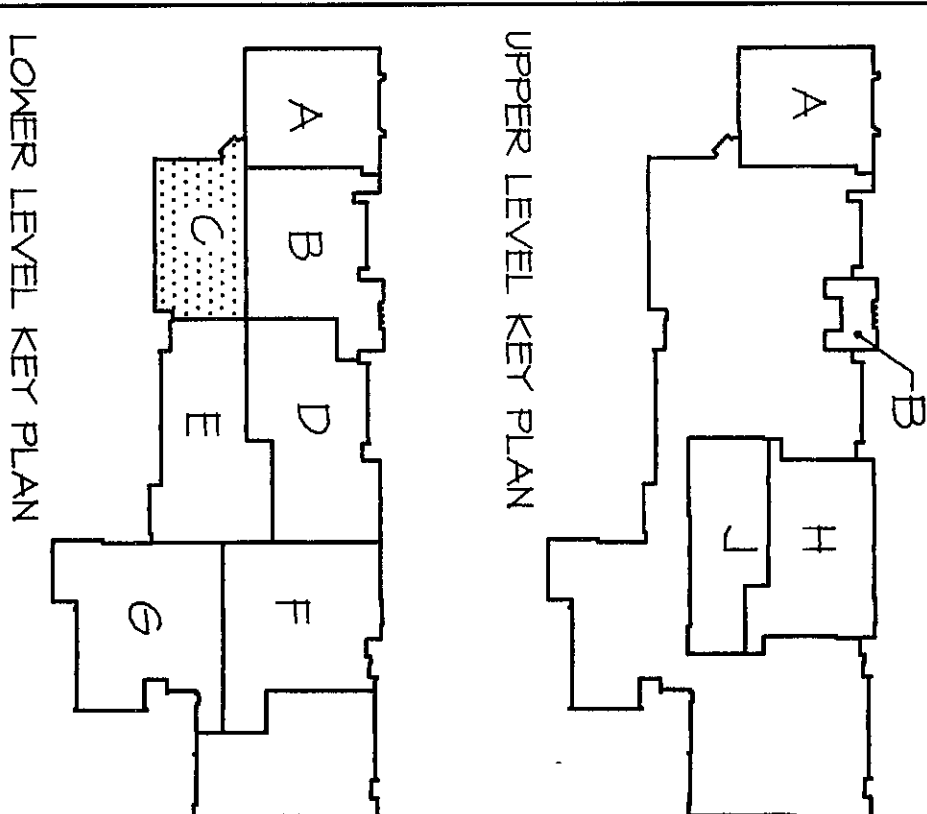

LOWER LEVEL KEY PLAN
SCALE: 1/8" = 1'-0"

**VEAZEY
PARROT
&
DURKIN
SHOULDERS**

**ARCHITECTS
PLANNERS**

**RENOVATION PROJECT FOR:
DUNEIL AND SCHOOL
CORPORATION
CHESTERTON, INDIANA**

PLUMBING PLAN - UNIT 'C'

Project No. 948000

Project Date: 06-12-00

Drawn By: RLW

Approved By: KLF

Drawing No. P 1.3

Scale: 1/8" = 1'-0"

Sheet: 1 of 1

Project: 948000

Date: 06-12-00

Drawn By: RLW

Approved By: KLF

Drawing No. P 1.3

Scale: 1/8" = 1'-0"

Sheet: 1 of 1