
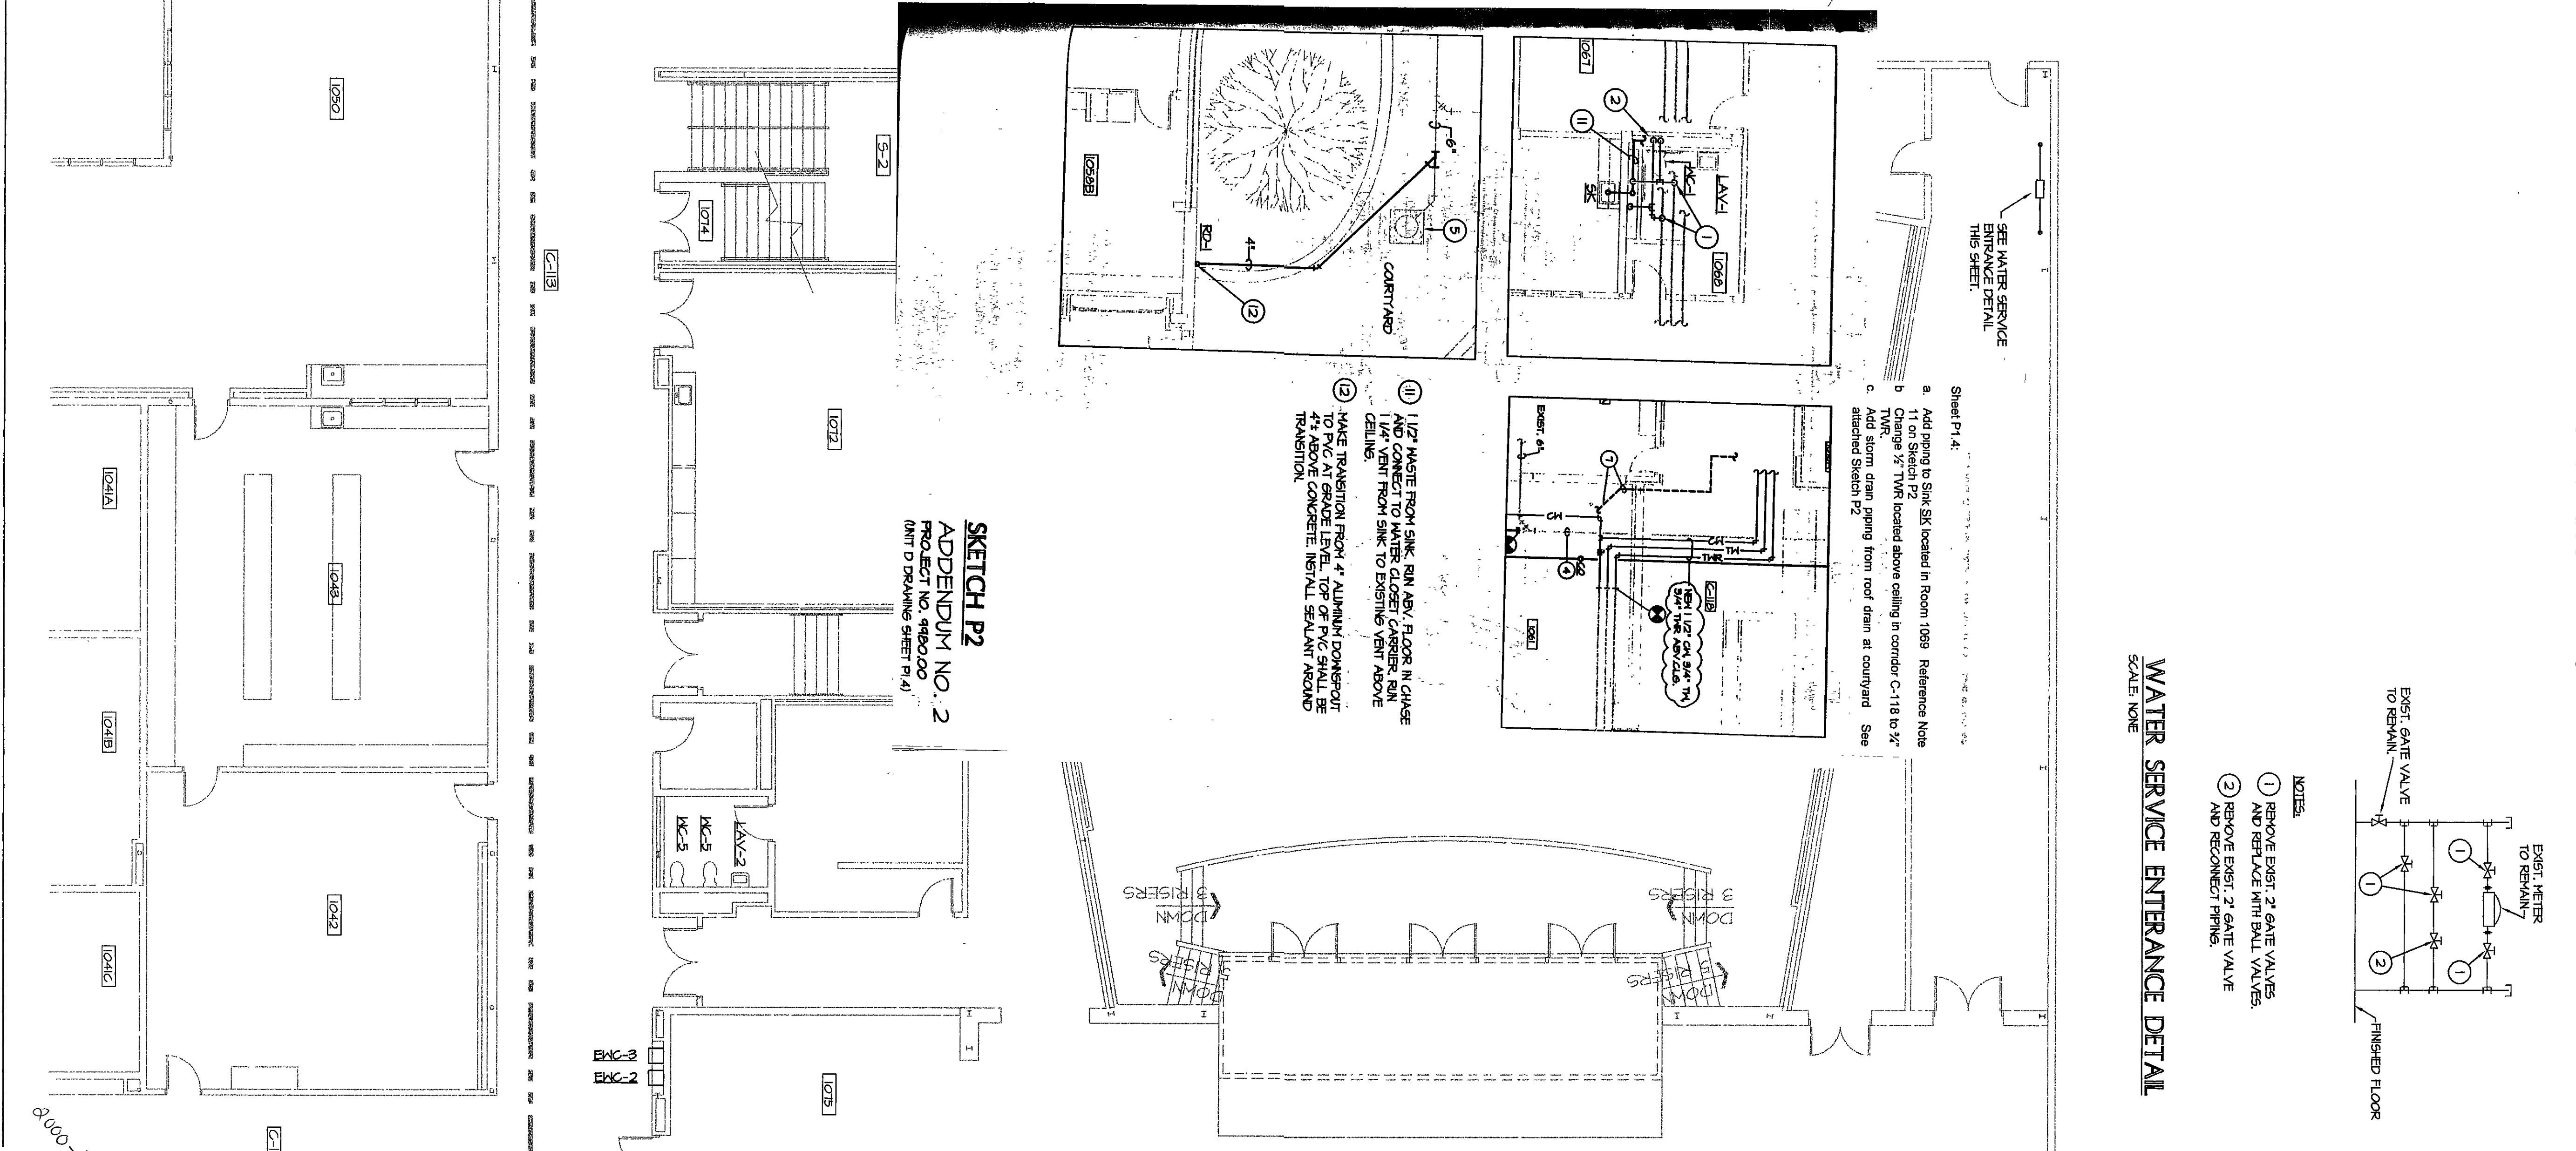


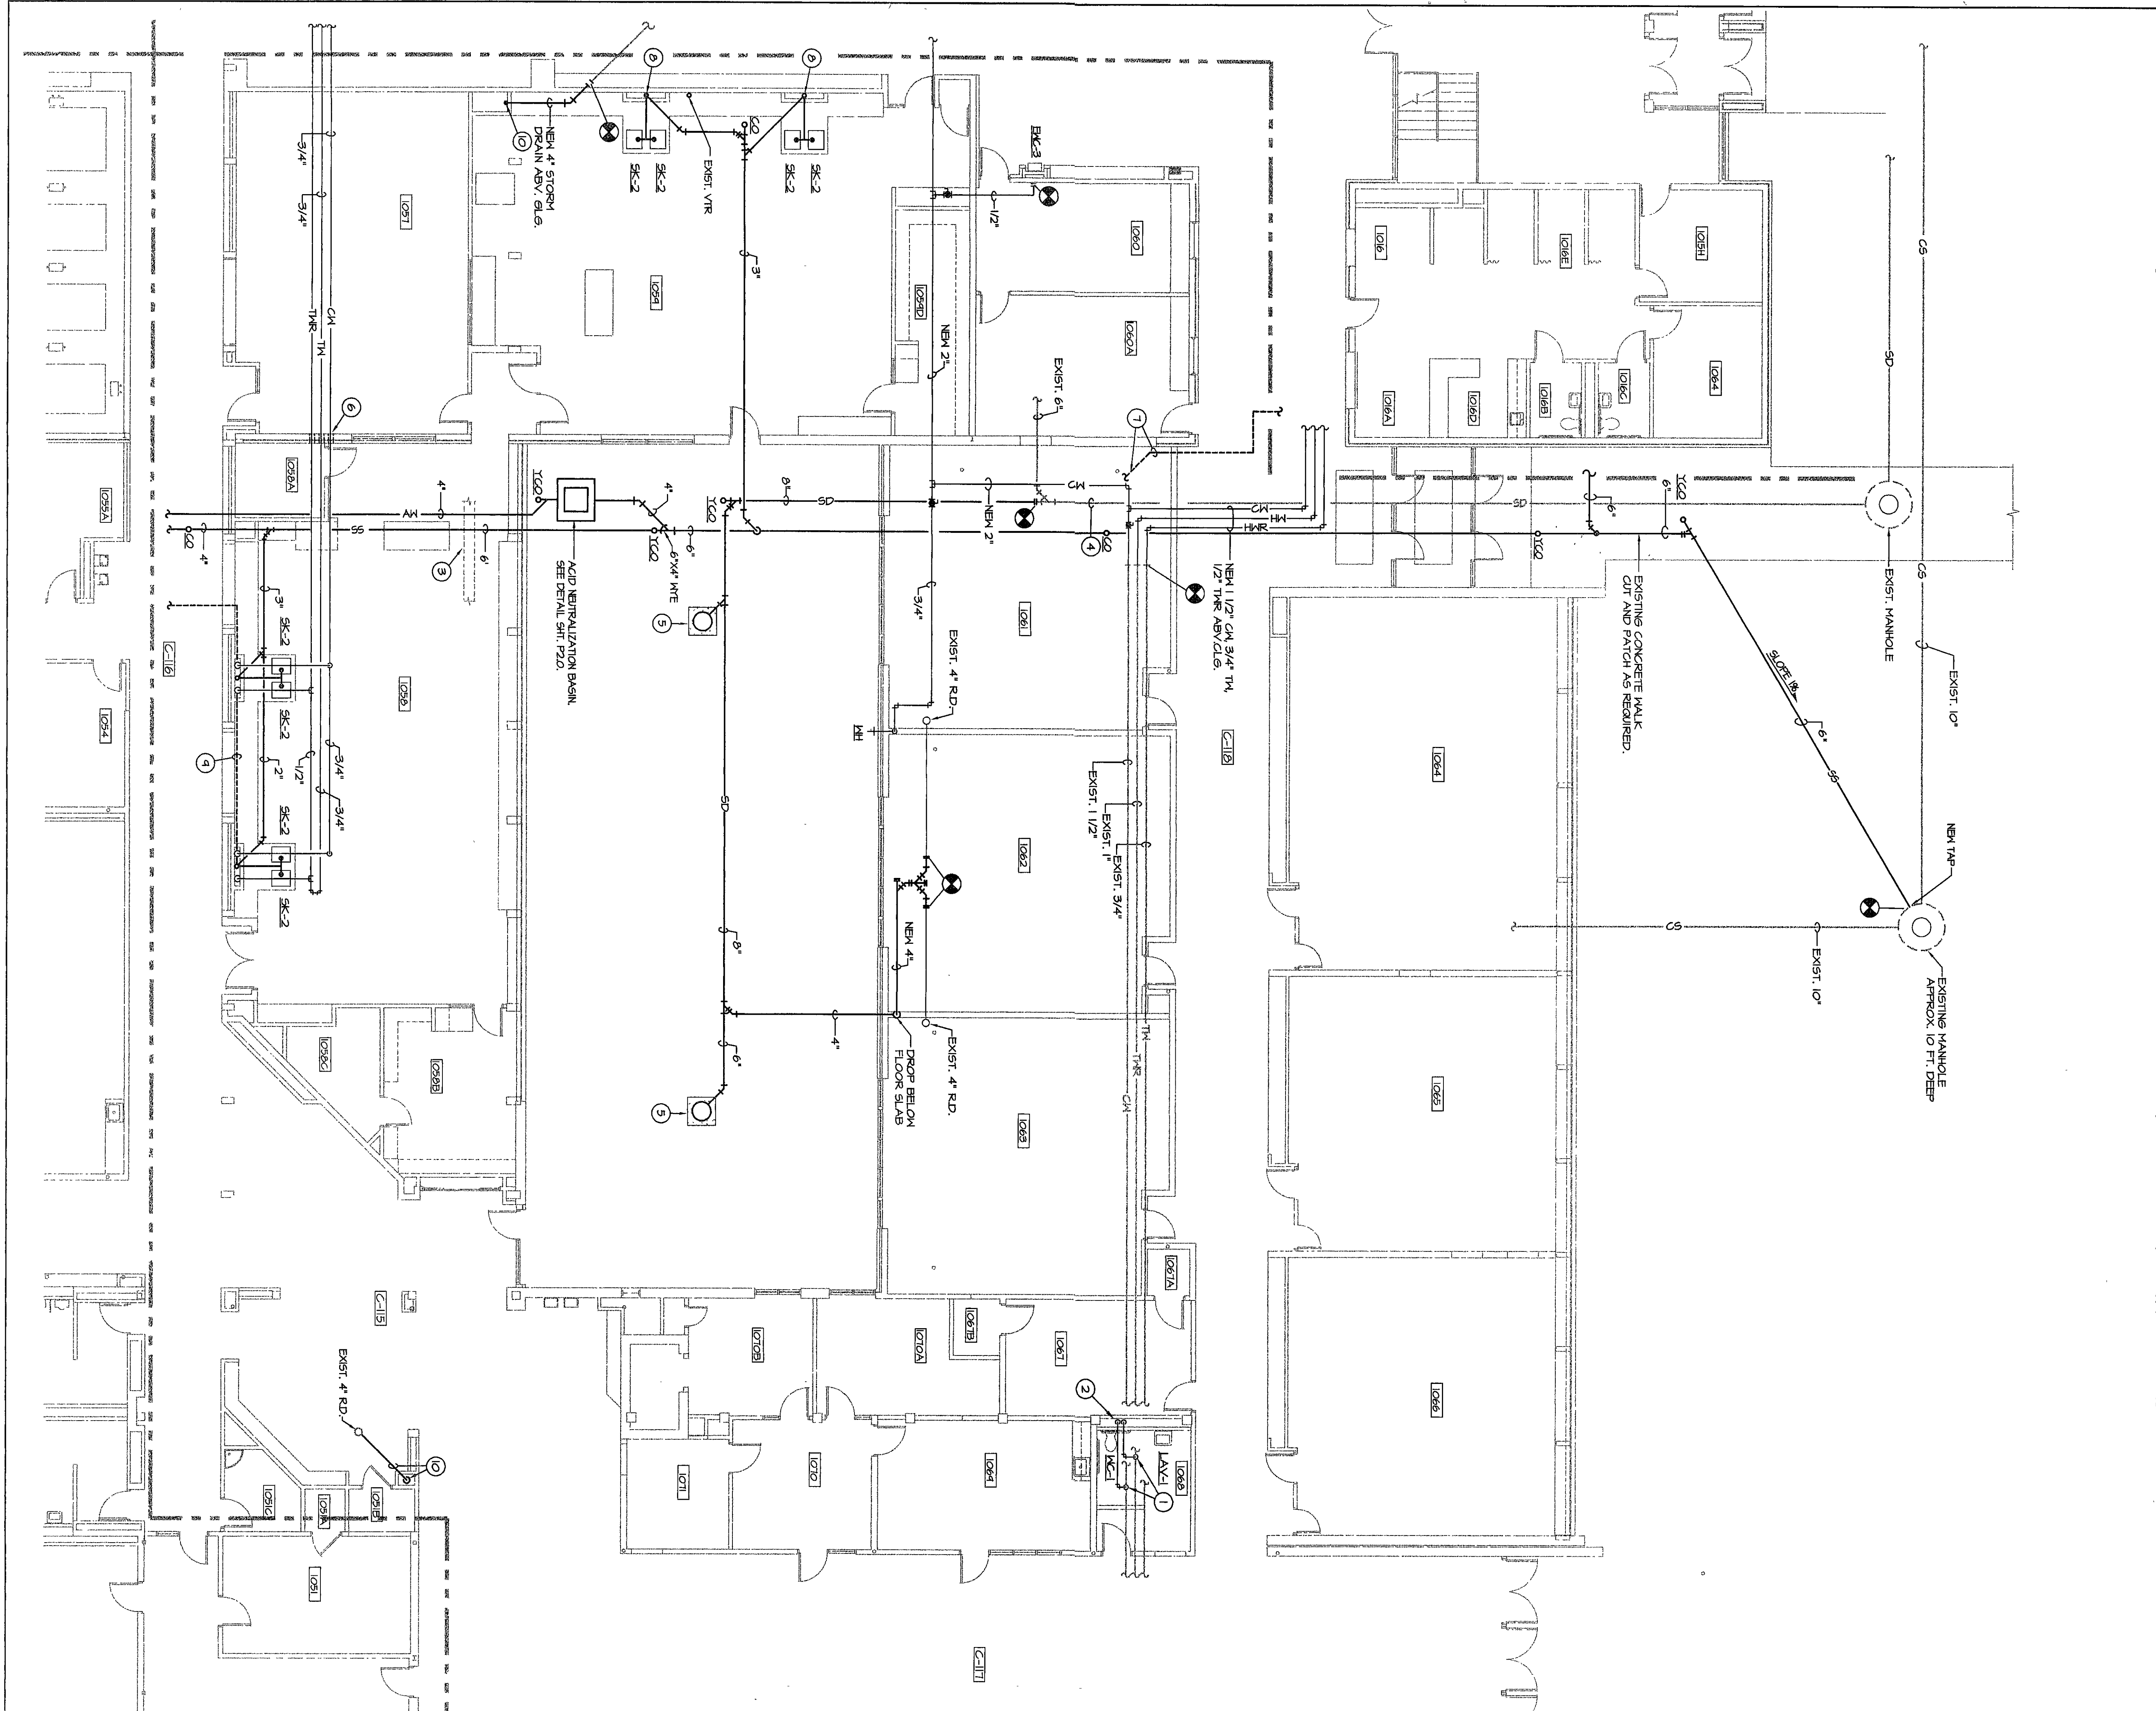

REFERENCE NOTES:

1. 1/2" DIA. AND 1/2" THICK CONNECTION TO EXIST. PIPING ABOVE CEILING. SEE DETAIL ON SHEET P-20.
2. CONNECT 4" WASTE FROM WATER CLOSET AND FLOOR. CONNECT NEW 2" VENT TO EXIST. VENT ABOVE CEILING.
3. INSTALL WALL SLEEVE AND "LINK-SEAL" AT PENETRATION THROUGH TUNNEL WALL.
4. EXISTING 10" STORM DRAIN. APPROXIMATE DEPTH 10". SEE DETAIL ON SHEET P-20.
5. NEW 4" STORM DRAIN. SEE DETAIL ON SHEET P-20.
6. SLEEVE AND GASKET AT MASONRY WALL.
7. NEW 2" VENT ABOVE CEILING FROM TOILETS AND BATHS. CONNECT TO EXISTING VENT THROUGH ROOF.
8. CONNECT NEW 1 1/4" VENT FROM SINKS TO EXISTING VENT THROUGH ROOF ABOVE CEILING.
9. 1 1/2" VENT ABOVE CEILING.
10. NEW 4" ROOT DRAIN PIPING, DROP IN TUNNEL AND RECONNECT TO EXIST. STORM DRAIN.

VEAZEY PARROTT DURKIN & SHOULDER

ARCHITECTS ENGINEERS PLANNERS

3000 Project Ave. S.W.
Bend, Oregon 97001

**RENOVATION PROJECT FOR:
DUNE AND SCHOOL CORPORATION
OCEASTON, INDIANA**

PLUMBING PLAN - UNIT 'D'

Drawing Title: PLUMBING PLAN - UNIT 'D'

Project No: 9480000

Project Date: 06-12-00

Drawn By: RLW

Approved By: KLF

Drawing No: P 14

**SKETCH P2
APPENDIX NO. 2
PROJECT NO. 9480000
(UNIT D PLUMBING SHEET P-14)**

1. 1 1/2" WASTE FROM SINK AND LAV. FLOOR IN CHANGE AND CONNECT TO WATER CLOSET ABOVE CEILING. SEE DETAIL ON SHEET P-20.

2. HAVE TRANSITION FROM 4" ALUMINUM DOWNROUT TO 4" ABOVE CEILING LEVEL. TOP OF PVC SHALL BE 4" ABOVE CEILING. INSTALL 3/4" DIA. TRANSITION.

UPPER LEVEL KEY PLAN

LOWER LEVEL KEY PLAN

NORTH

SCALE: 1/8" = 1'-0"