




SCALE: 3/4" = 1'-0"

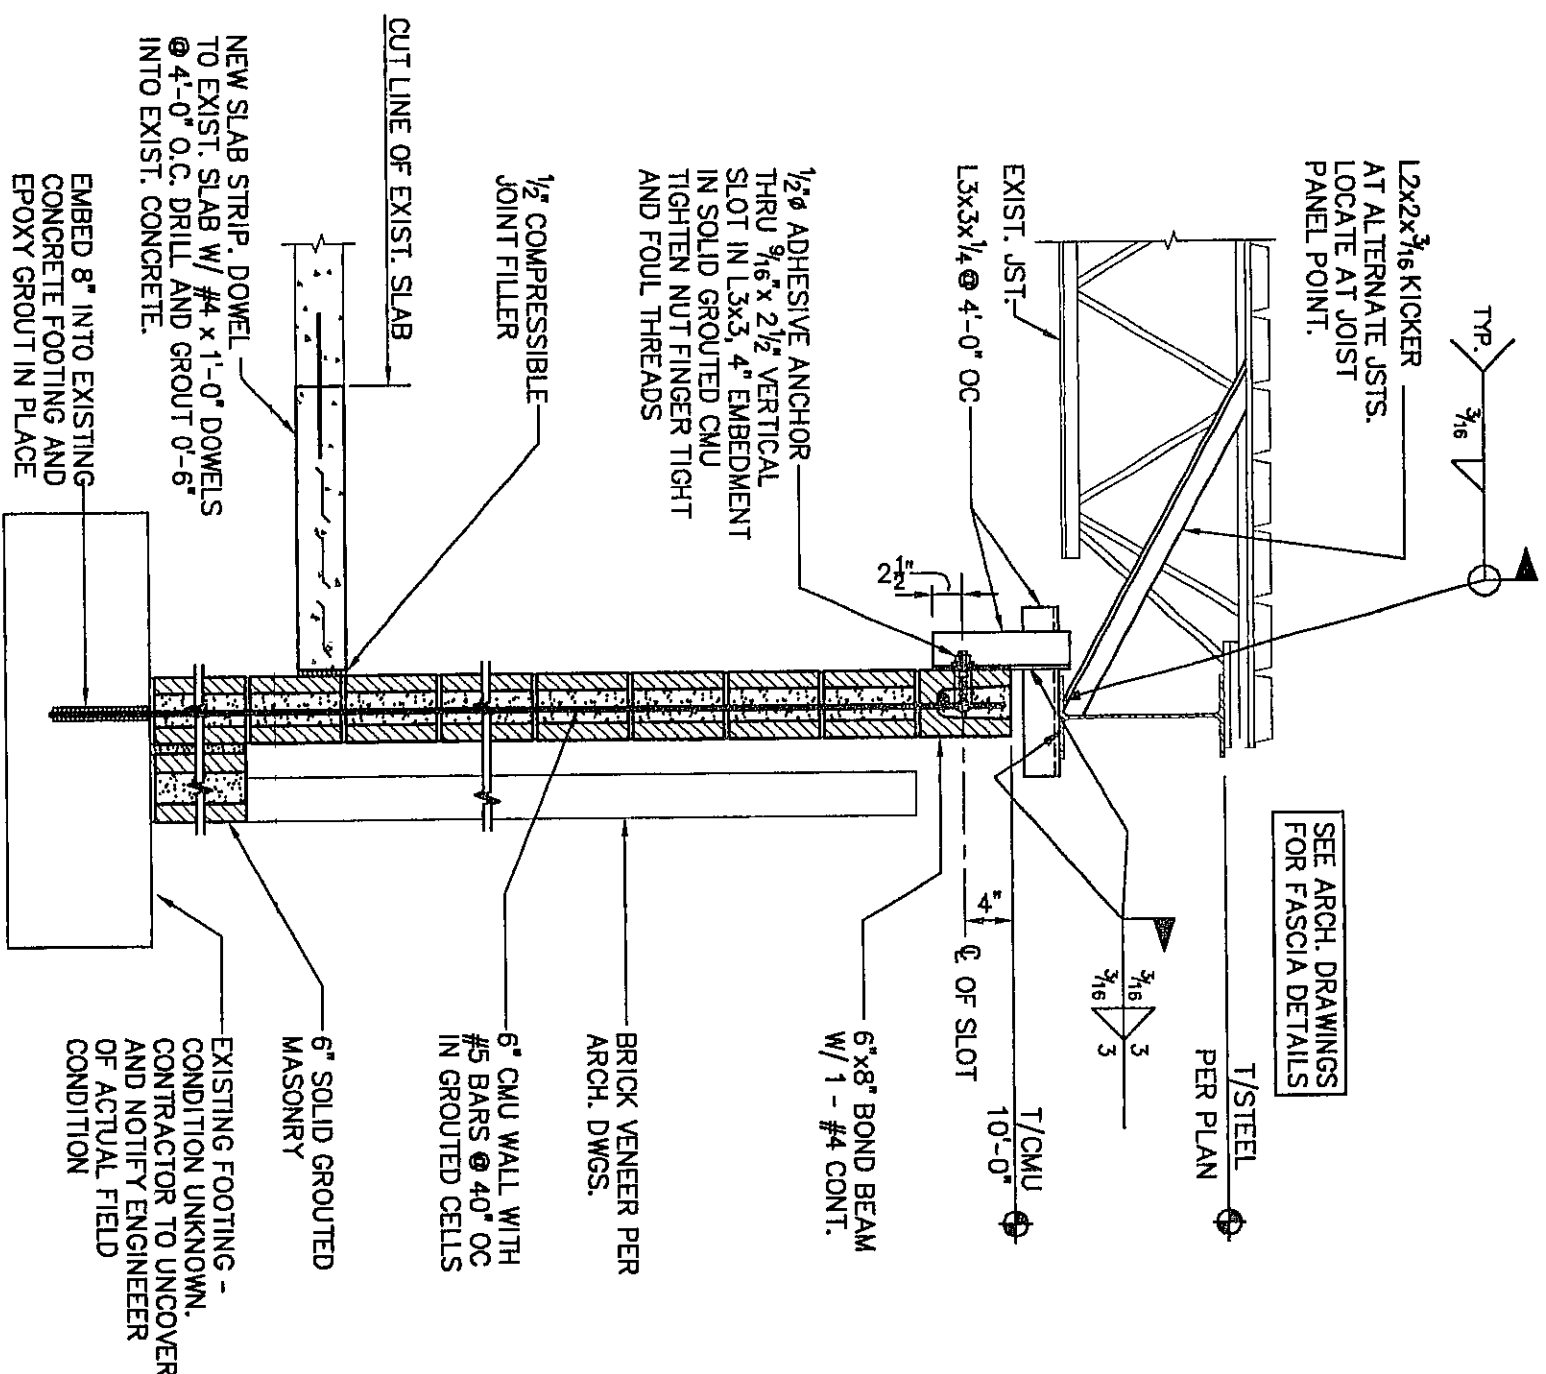


SCALE: 3/4" = 1'-0"

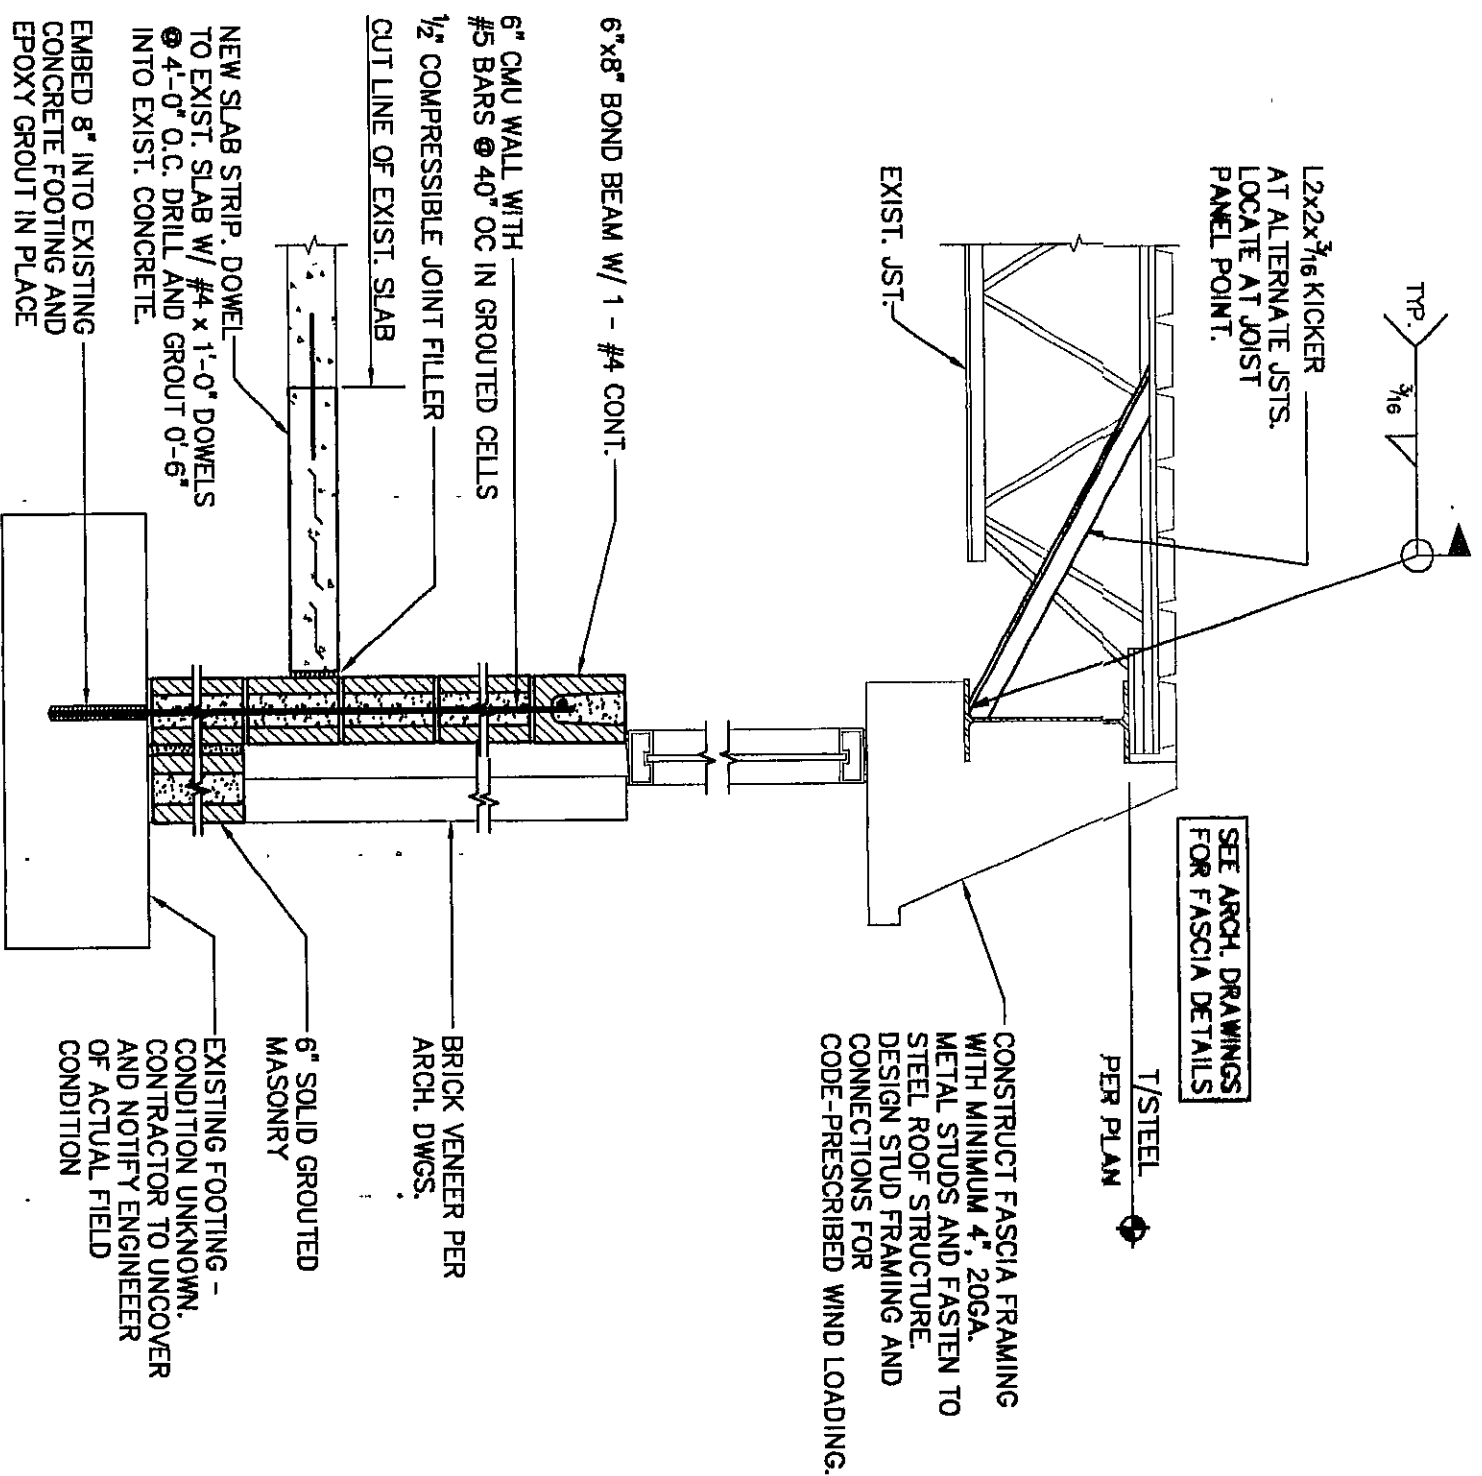

SCALE: 1/8" = 1'-0"

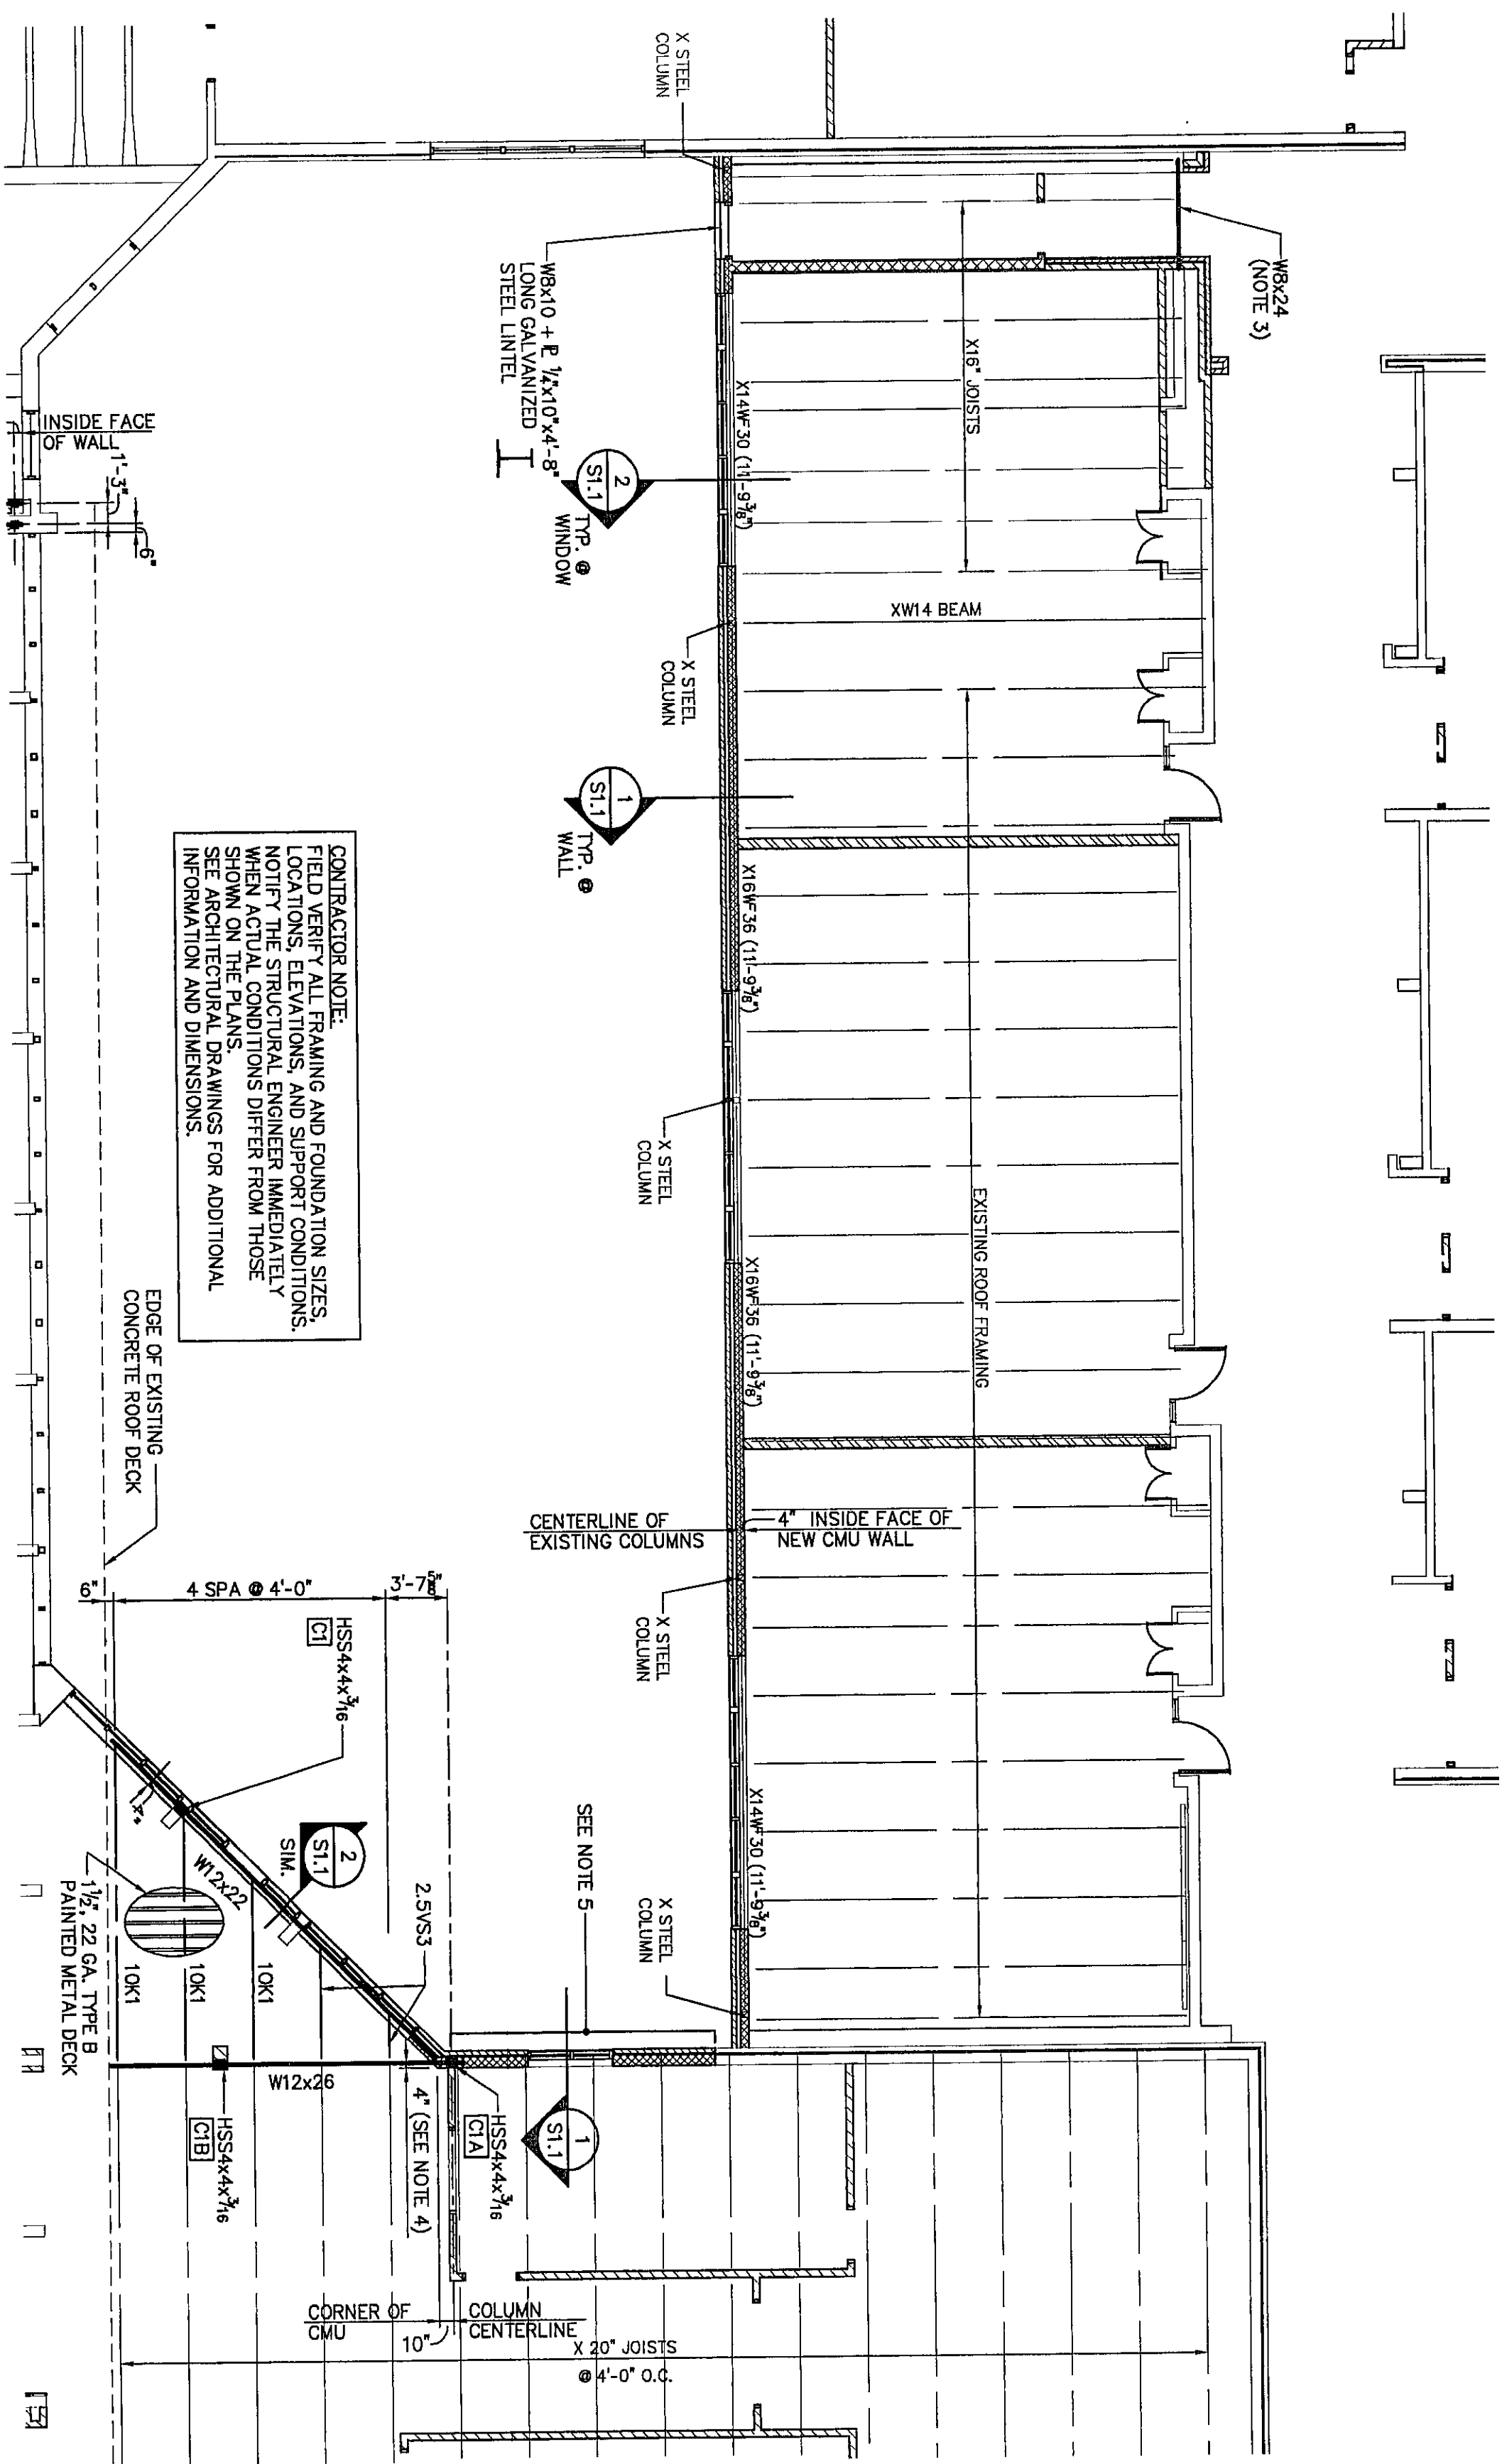


SCALE: 1/8" = 1'-0"

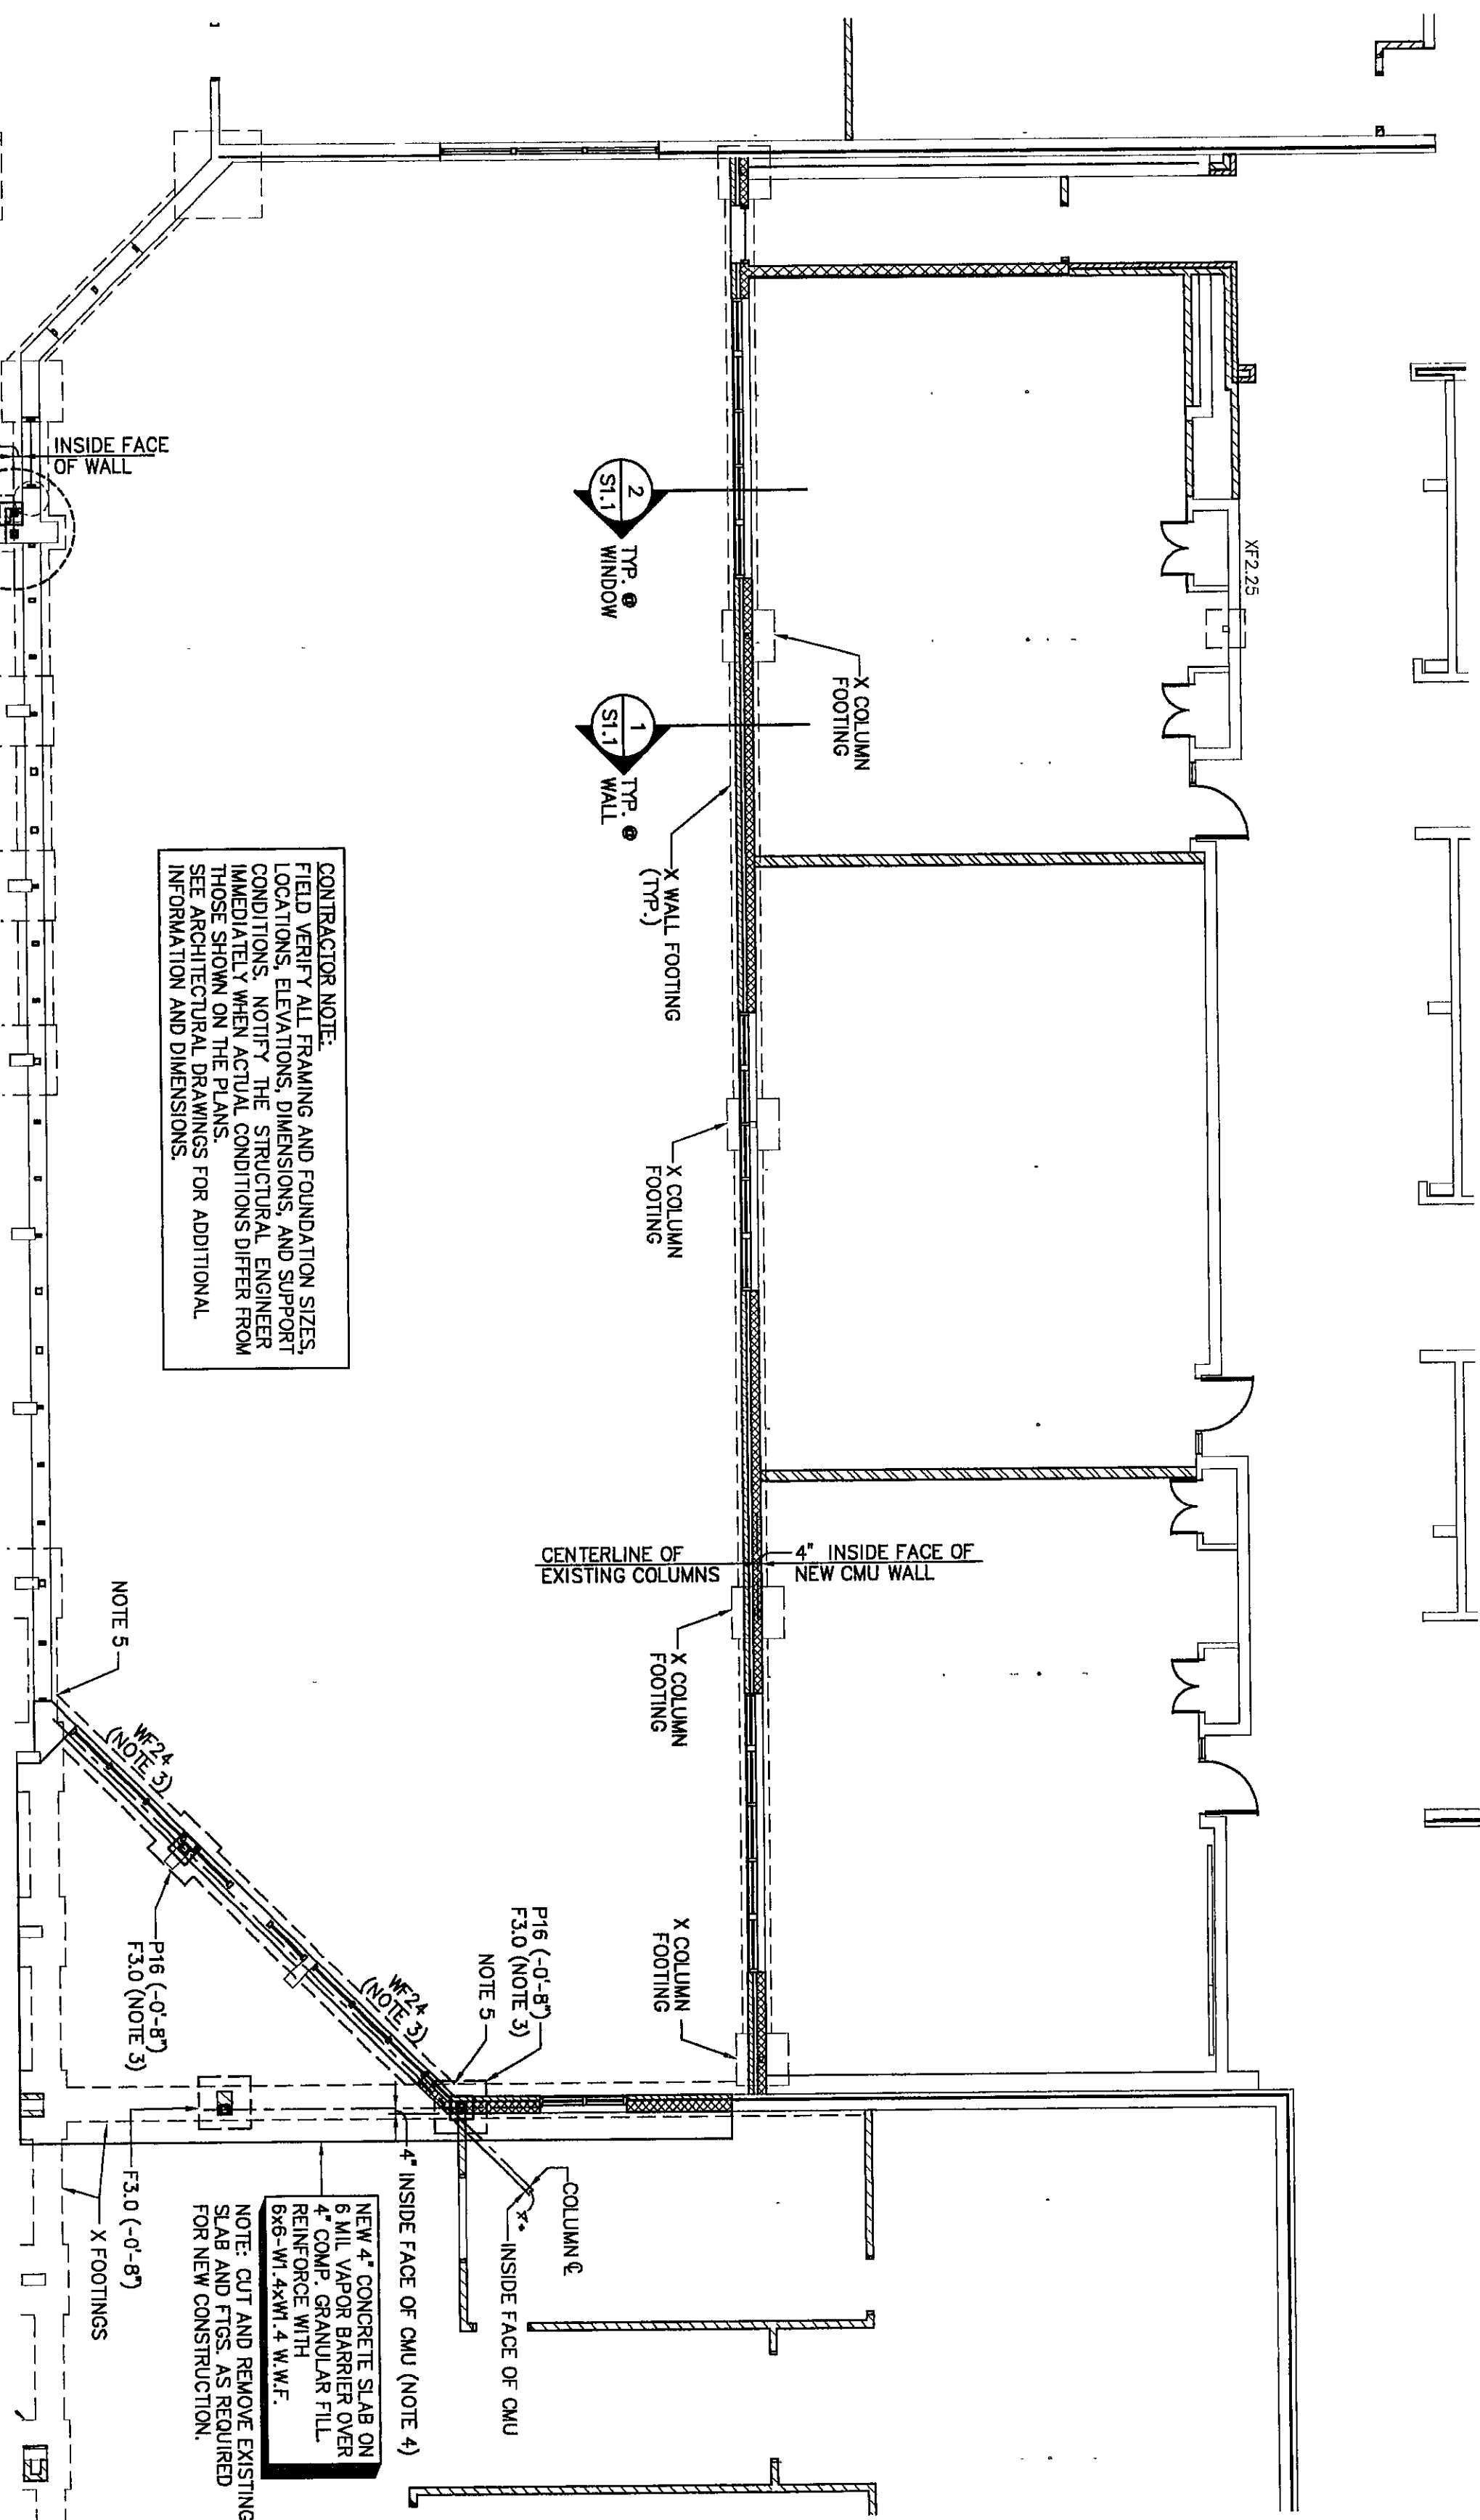

Abstract

AMERICAN CONSULTING, INC.



Architects 465 MILLERSTVILLE ROAD
Consultants INDIANAPOLIS, IN 46205-2996
Engineers (317) 547-5580 FAX: (317) 545-0700

Copyright (c) 1985-2000 by American Consulting, Inc.

American Consulting, Inc. Project Number IN2000.0200

ARCHITECT
ENGINEER
PLANNERS

**VEAZEY
PARROTT
DURKIN &
SHOULDERS**

8860 Priority Way S Dr
Suite 118
Medina, In 48240

UNT B COURTYARD FOUNDATION AND FRAMING PLANS

RENOVATION PROJECT FOR:
DUNELAND SCHOOL
CORPORATION
CHESTERTON MIDDLE SCHOOL
CHESTERTON, INDIANA

[illegible]