


- GENERAL NOTES:
1. ALL WORK SHALL BE IN ACCORDANCE WITH THE LATEST EDITIONS OF THE NATIONAL ELECTRICAL CODE (NEC) AND THE NATIONAL FIRE PROTECTION ASSOCIATION (NFPA) 70B.
  2. ALL WORK SHALL BE IN ACCORDANCE WITH THE LATEST EDITIONS OF THE NATIONAL ELECTRICAL CODE (NEC) AND THE NATIONAL FIRE PROTECTION ASSOCIATION (NFPA) 70B.

REFERENCES NOTES

1. SEE TS-5.0(2) TYPICAL FOR ALL CLASSROOMS. PROVIDE (1) 2" MULTI-MEDIA MONITOR & (1) 5-WAY VCR IN EACH CLASSROOM.
2. MONITOR DEVICES (PLATE/POSS) IN BACKWAY PROVIDED BY DIVISION 16 CONTRACTOR. TYPICAL AS INDICATED.
3. SEE TS-5.0(3) PROVIDE 20 FOOTING/BRACKET FOR EACH MONITOR & VCR.
4. SEE TS-5.1(3) FOR ADDITIONAL INFORMATION.
5. PROVIDE EQUIPMENT NUMBER OF CAT 6 CABLES AND COAX TO PROVIDE SAME SERVICE AS PRINCIPAL'S OFFICE. PROVIDE 30' CABLE IN CABLE IN CENTER OF SPACE.
6. PROVIDE 30' CAT 6 CABLE CABLE MEET ABOVE CEILING FOR FUTURE USE. TERMINATE OTHER END.
7. PROVIDE 27" MULTI-MEDIA MONITOR/BRACKET ONLY. NO VCR. LOOP SIGNALS FROM PRIMARY MONITOR.
8. PROVIDE ONE (1) 7" CONNECTOR IN PLATE FOR LOOK INPUT ONLY. NO MONITOR. NO VCR. MOUNT AT 16' AFF.
9. PROVIDE ONE (1) 7" CONNECTOR IN PLATE FOR LOOK INPUT ONLY. NO MONITOR. NO VCR. MOUNT AT 16' AFF.
10. PROVIDE TELEPHONE LOCATION.
11. SEE TS-5.1 (4) FOR ADDITIONAL INFORMATION.
12. PROVIDE 27" MULTI-MEDIA MONITOR/BRACKET FOR PRINCIPAL'S OFFICE. PROVIDE NO MONITOR. PROVIDE NO VCR.
13. PROVIDE 30' MULTI-MEDIA MONITOR/BRACKET. NO VCR. SEE TS-5.1 (5).
14. INTERCOM HORN SPEAKER MOUNT AT 12' AFF OR NEAR CEILING. PROVIDE NO MONITOR. PROVIDE NO VCR.
15. INTERCOM HORN SPEAKER MOUNTED 15' ABOVE GROUND. CABLE TRAY SHOWN FOR REFERENCE ONLY.
16. CEILING SPEAKERS. ROUTE TO ROOM INTERCOM/AMPLIFIER. TYPICAL OF 16.
17. SURFACE MOUNT ADDITIONAL SPEAKER.
18. WALL MOUNT 9x12 PROJECTION SCREEN.
19. CEILING MOUNT LCO PROJECTION. ROUTE CABLE TO AV EQUIPMENT RACK.
20. ADDITIONAL EQUIPMENT RACK.

KEY PLAN

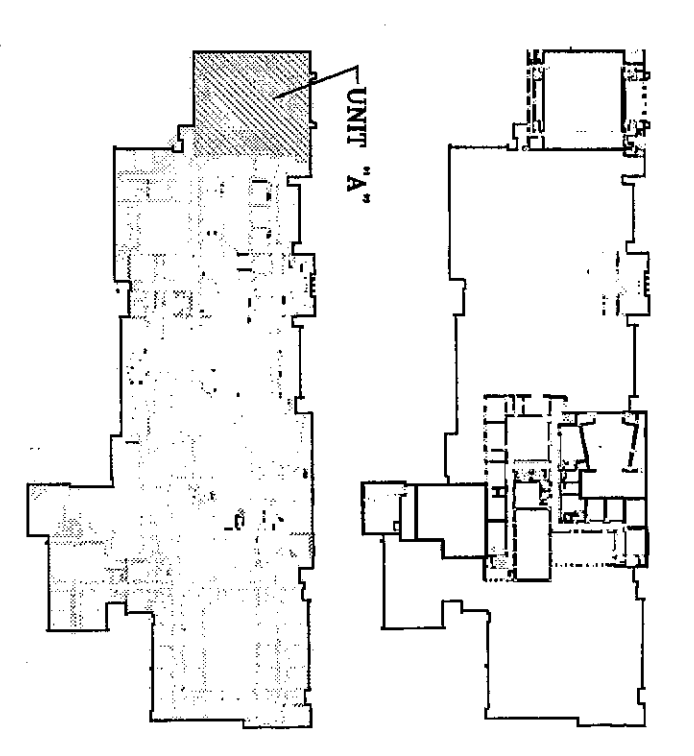

NORTH  
SCALE: NTS

**D S & A INC.**  
Technology Design Consultants  
14416 East 196th Street  
Mokena, IL 60450-9500  
708.594-5152  
D&A Incorporated

**VEAZEY  
PARROTT  
&  
SHOULDERS**  
ARCHITECTS  
ENGINEERS  
PLANNERS

**RENOVATION PROJECT FOR:  
DUNELAND SCHOOL  
CORPORATION  
OBERLIN MIDDLE SCHOOL,  
OBERLIN, INDIANA**

**TECHNOLOGY SYSTEMS  
FLOOR PLAN (UNIT 7A)**

Drawing Title:  
Project No.: 99-10294  
Project Date: 6-14-2000  
Drawn By: TDES  
Approved By: LWD  
Drawing No.: 2000-TS-02  
TS 11